


Horizontal Scale 1:500
Vertical Scale 1:50
Vert. exaggeration = 10.0
Datum = 57.0

Link Name	1.000	1.001	1.002	1.003	1.004	Tank	1.006
Section Type	225mm	300mm	300mm	375mm	450mm	600mm	225mm
Slope	1:194	1:155	1:200	1:101	1:182.0	1:71	1:236
Cover Level	62.280	62.150	62.170	62.080	61.930	61.320	61.200
Invert Level	60.875	60.765 60.680	60.190 60.190	60.090 60.015	59.715 59.320	59.270 58.700 58.650	58.610
Length	21.36	77.63	20.04	30.41	9.10	3.54	9.44

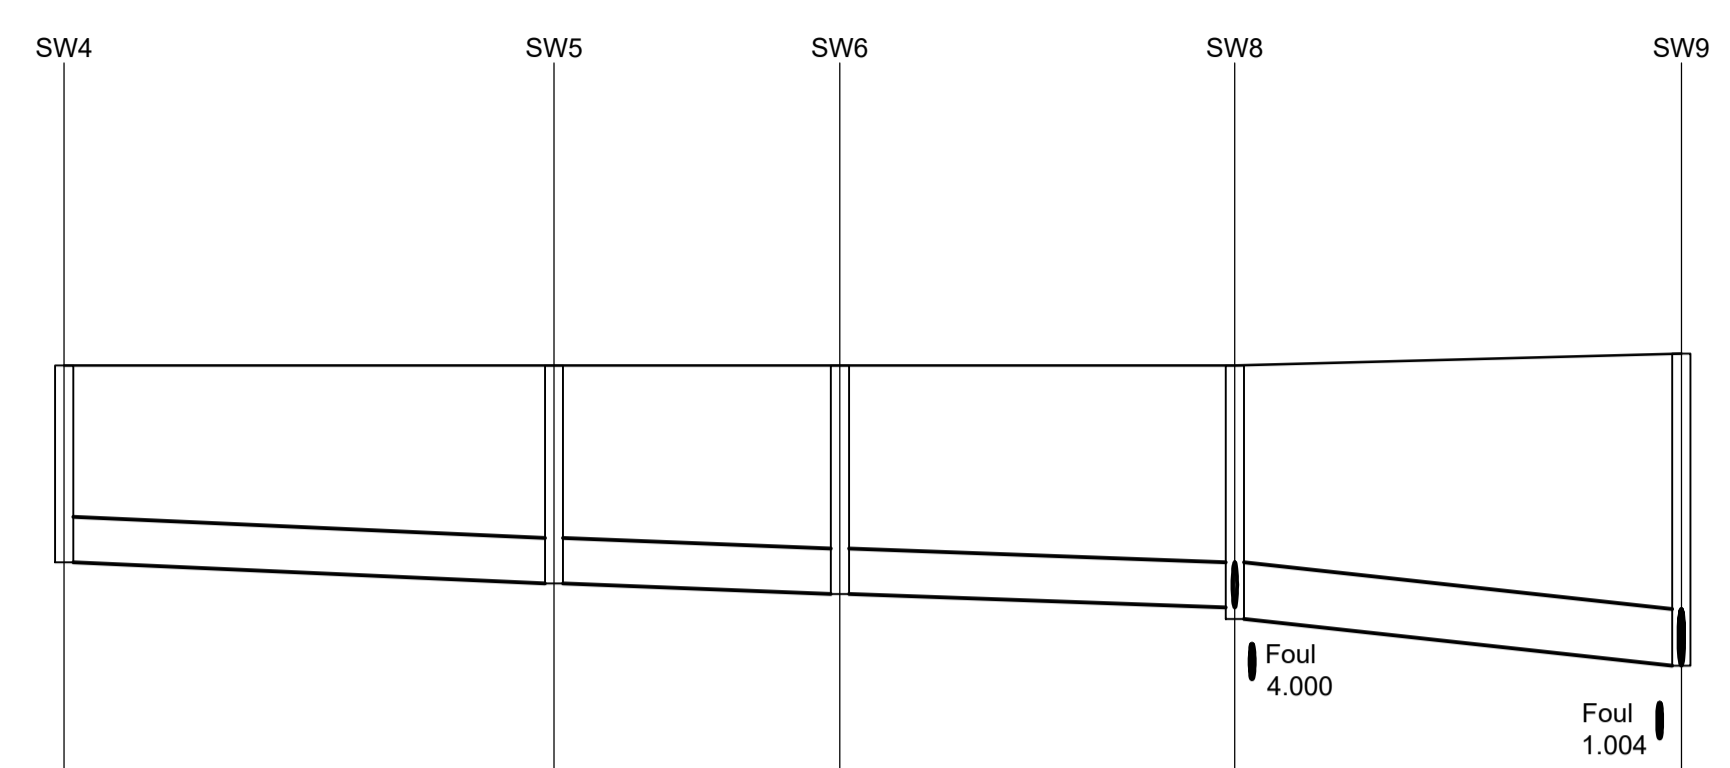


Horizontal Scale 1:500
Vertical Scale 1:50
Vert. exaggeration = 10.0
Datum = 57.0

Link Name	2.000	2.001	2.002	2.003
Section Type	300mm	300mm	300mm	375mm
Slope	1:231	1:270	1:290	1:95
Cover Level	62.000	62.000	62.000	62.080
Invert Level	60.700	60.560 60.560	60.490 60.490	60.400 60.325
Length	32.40	18.91	26.12	29.53




Horizontal Scale 1:500
Vertical Scale 1:50
Vert. exaggeration = 10.0
Datum = 58.0

Link Name	3.000
Section Type	300mm
Slope	1:197
Cover Level	62.000
Invert Level	60.700
Length	59.03

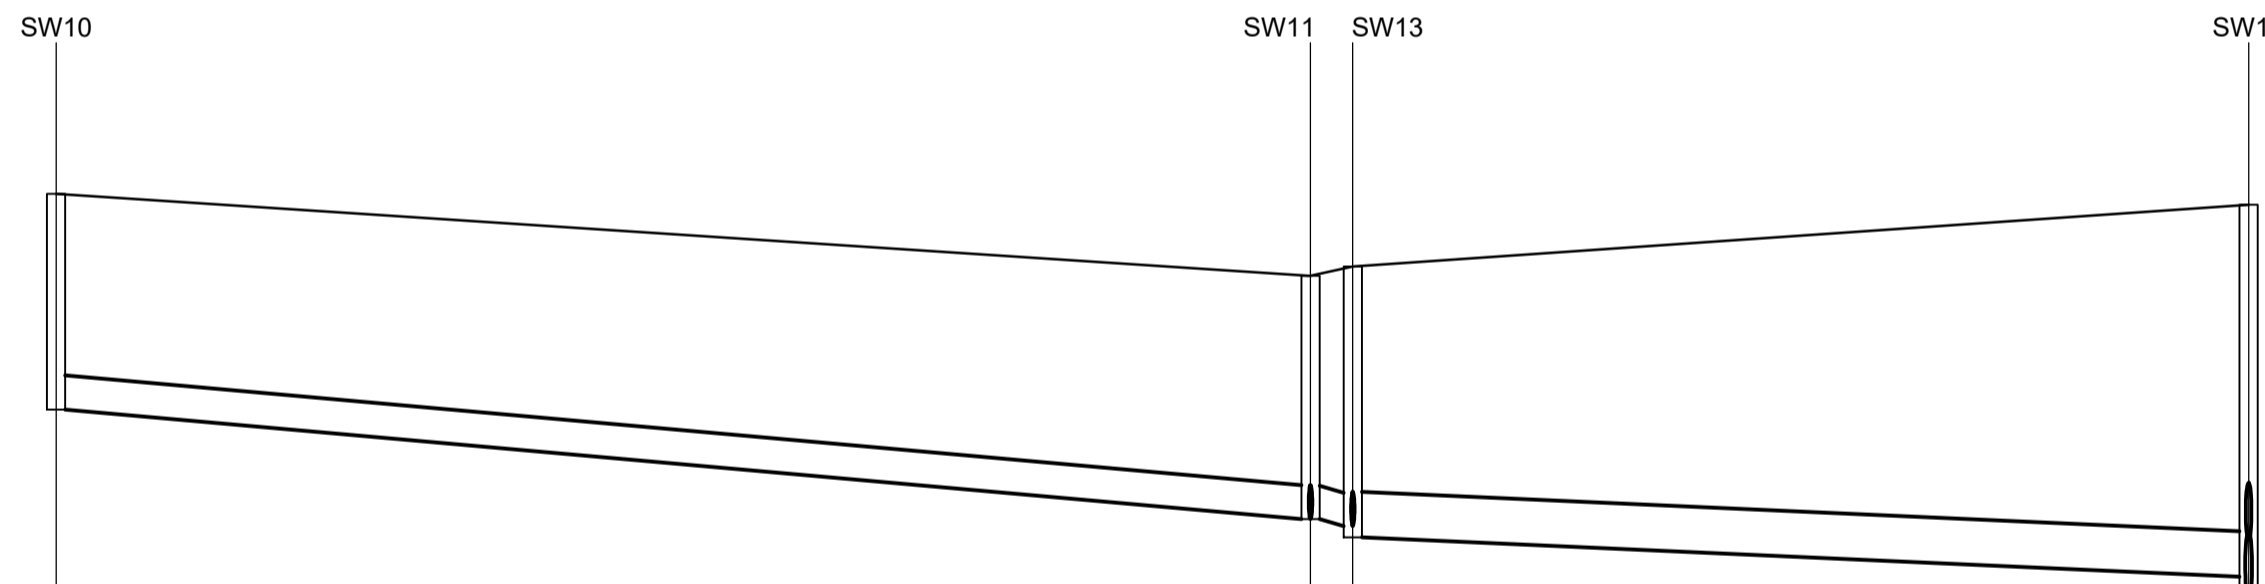

Horizontal Scale 1:500
Vertical Scale 1:50
Vert. exaggeration = 10.0
Datum = 58.0

Link Name	4.000	4.001	4.002
Section Type	225mm	225mm	300mm
Slope	1:114	1:31	1:228
Cover Level	62.000	61.460 61.520	61.930
Invert Level	60.575	59.850 59.805 59.730	59.470
Length	82.96	2.80	59.25

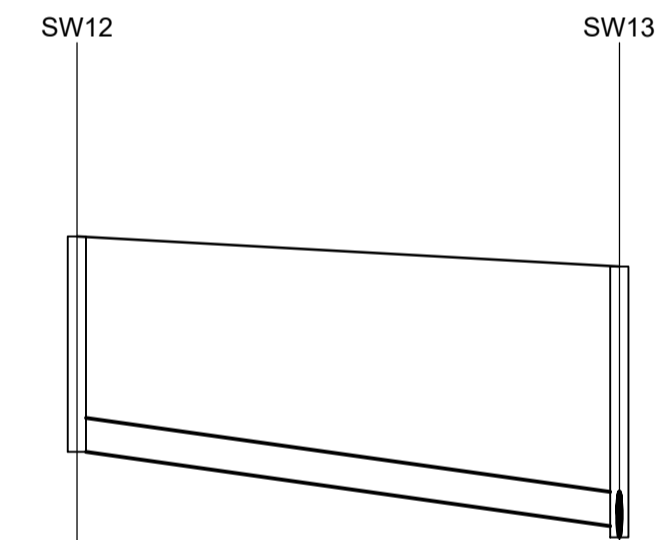

Horizontal Scale 1:500
Vertical Scale 1:50
Vert. exaggeration = 10.0
Datum = 58.0

Link Name	5.000
Section Type	225mm
Slope	1:73
Cover Level	61.720
Invert Level	60.295
Length	35.87

Mark	Date	By	Chk	App	Revision
PL16	19-12-2021	PB	DOS	DOS	SCALES TO EACH INDIVIDUAL LONGSECTION.
PL14	02-12-2021	PB	BK	DOS	ISSUED FOR PLANNING. REVIEWED ACCORDING TO SDCC.
PL13	30-11-2021	PB	BK	DOS	ISSUED FOR PLANNING. ADJUSTMENT OF SWALES.
PL12	25-11-2021	PB	BK	DOS	DRAINAGE LAYOUT CHANGED.
PL11	14-10-2021	PB	BK	DOS	ISSUED FOR PLANNING. WATERMAIN LAYOUT CHANGED.
PL10	30-04-2021	BK	DOS		ISSUED FOR PLANNING

Job Title
**RESIDENTIAL DEVELOPMENT
@ St. EDMUNDS PHASE 3,
PALMERSTOWN, DUBLIN 20**

Architect/Client
MOYKERR LIMITED

Drawing Title
**LONGITUDINAL SECTIONS
STORM WATER DRAINAGE**

Drawing Status
PLANNING

Drawn PB	<p>Tel. 01 - 450 0694 Unit G3, Calmount Pk. Fax. 01 - 426 4340 Ballymount, Dublin 12. Email: pkavanagh@kavanaghburke.ie</p>
Checked BK	
Approved DOS	
Scales 1:500, 1:50	
Date December 2021	Job No. D1621
Rev. D5	Rev. PL16