
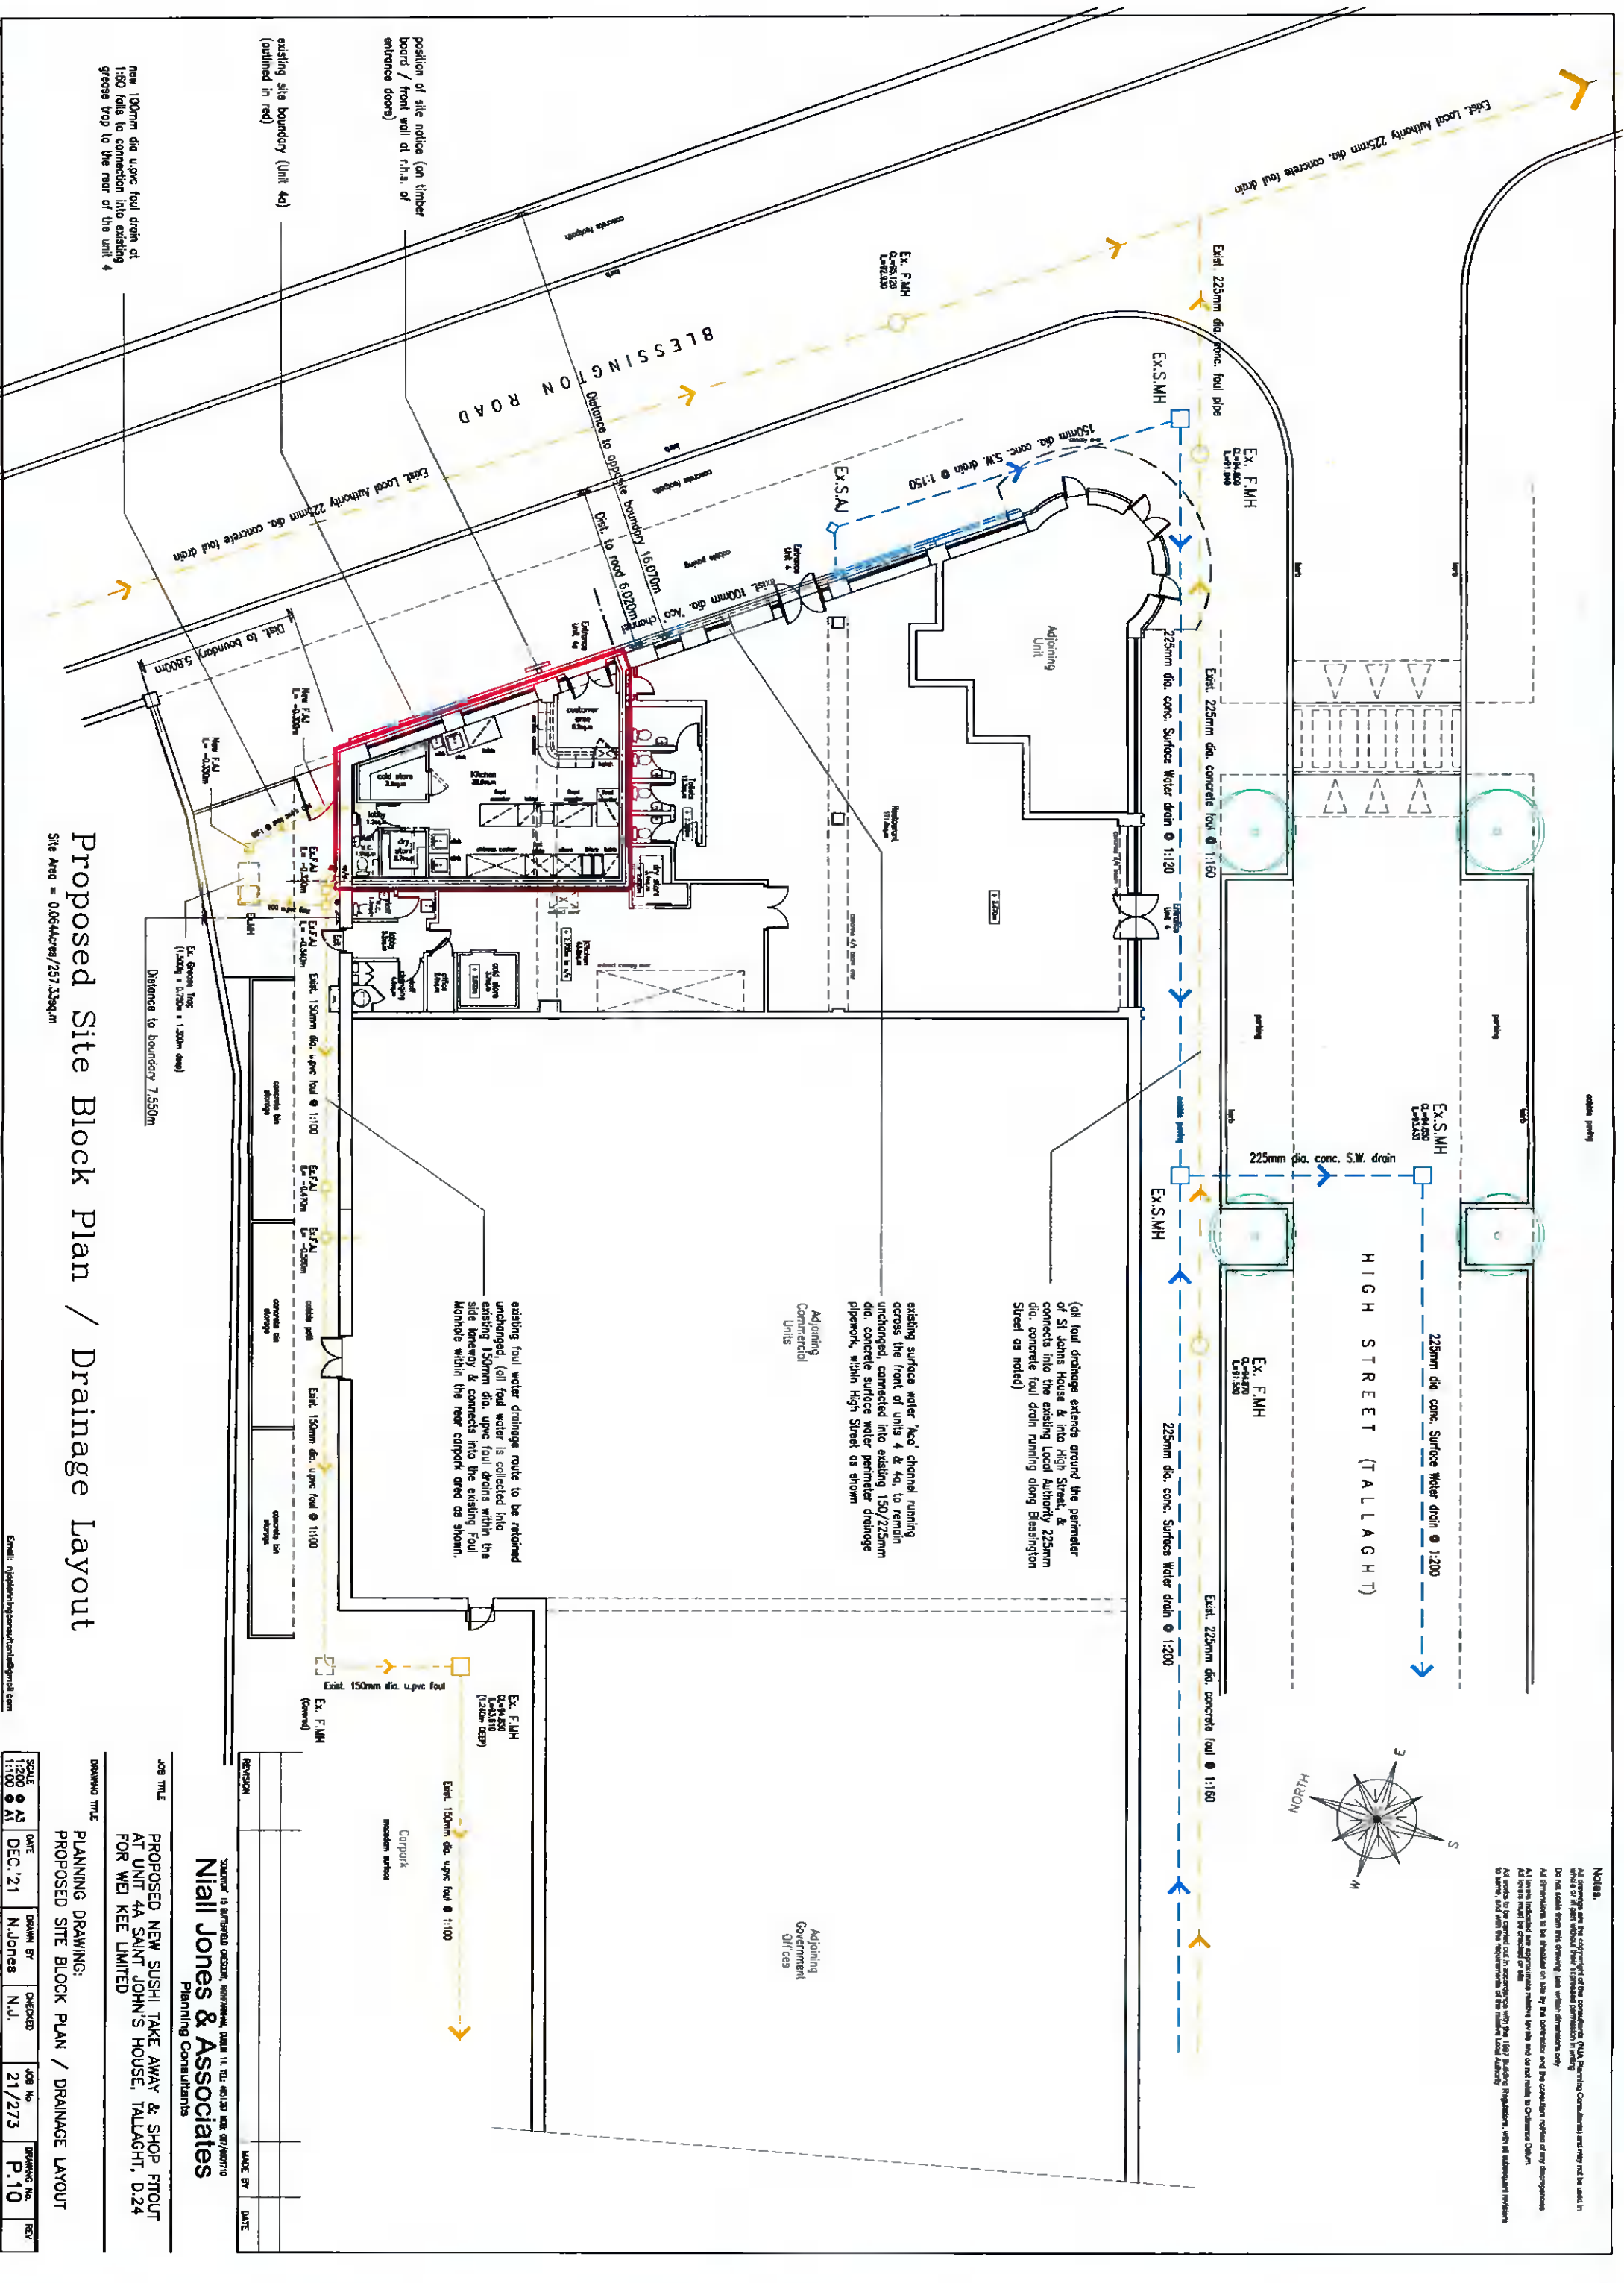


NOTES:
 All drawings are the copyright of the consultant (NIA Planning Consultants) and may not be used in whole or in part without their expressed permission in writing.
 Do not scale from this drawing, use written dimensions only.
 All dimensions to be checked on site by the contractor and the consultant notified of any discrepancies.
 All levels indicated are approximate unless stated and do not include Ordnance Datum.
 All levels must be checked on site.
 All work to be carried out in accordance with the 1987 Building Regulations, with all subsequent revisions as they apply and with the requirements of the current local authority.
 All work to be carried out in accordance with the 1987 Building Regulations, with all subsequent revisions as they apply and with the requirements of the current local authority.

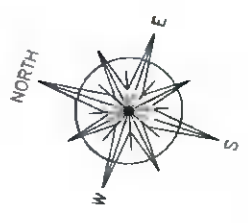

Proposed Site Block Plan / Drainage Layout

Site Area = 0.0644acres/257.33sqm

CLIENT: Niall Jones & Associates
 Planning Consultants

JOB TITLE: PROPOSED NEW SUSHI TAKE AWAY & SHOP FITOUT AT UNIT 4A SAINT JOHN'S HOUSE, TALLAGHT, D.24 FOR WEI KEE LIMITED

DRAWING TITLE: PLANNING DRAWING: PROPOSED SITE BLOCK PLAN / DRAINAGE LAYOUT

SCALE	DATE	DRAWN BY	CHECKED	JOB No.	DRAWING No.	REV.
1:200 A3	DEC '21	N.Jones	N.J.	21/273	P.10	