




**COPYRIGHT**

No part of this document may be re-produced or transmitted in any form or stored in any retrieval system of any nature without the written permission of iStruct Consulting Engineers as copyright holders except as agreed for use on the project for which the document was originally issued.

**NOTES:**

- 1) All levels are in metres and have to be referred to a temporary benchmark.
- 2) Do not scale off this drawing. Use figured dimensions only.

**KEYPLAN:**

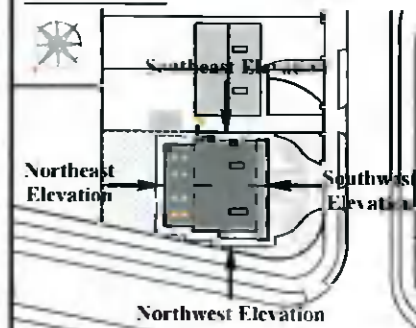

**Planning Drawings Only**


*These drawings should not be used for construction.*

**LEGEND**

- SWMH
- FMH
- RWP

B	Public Manholes Assigned Letter Names for Reference, Note Added Re. Route of the 300mm SW Line	23/08/21
A	Minor Adjustments	23/08/21
-	issued for review	02/08/21
Rev	Details	Date

Job title: New House at No. 1 Birchview Drive		
Drawing title: Existing Drainage Plan		
Drawing No.: 1910 - PG - 1.31		
Client: Romaine Nolan		
Drawn by: R.O.D.	Checked by: D.N.	Scale: 1:200 @A3
Date: 02/08/2021	Rev: B	

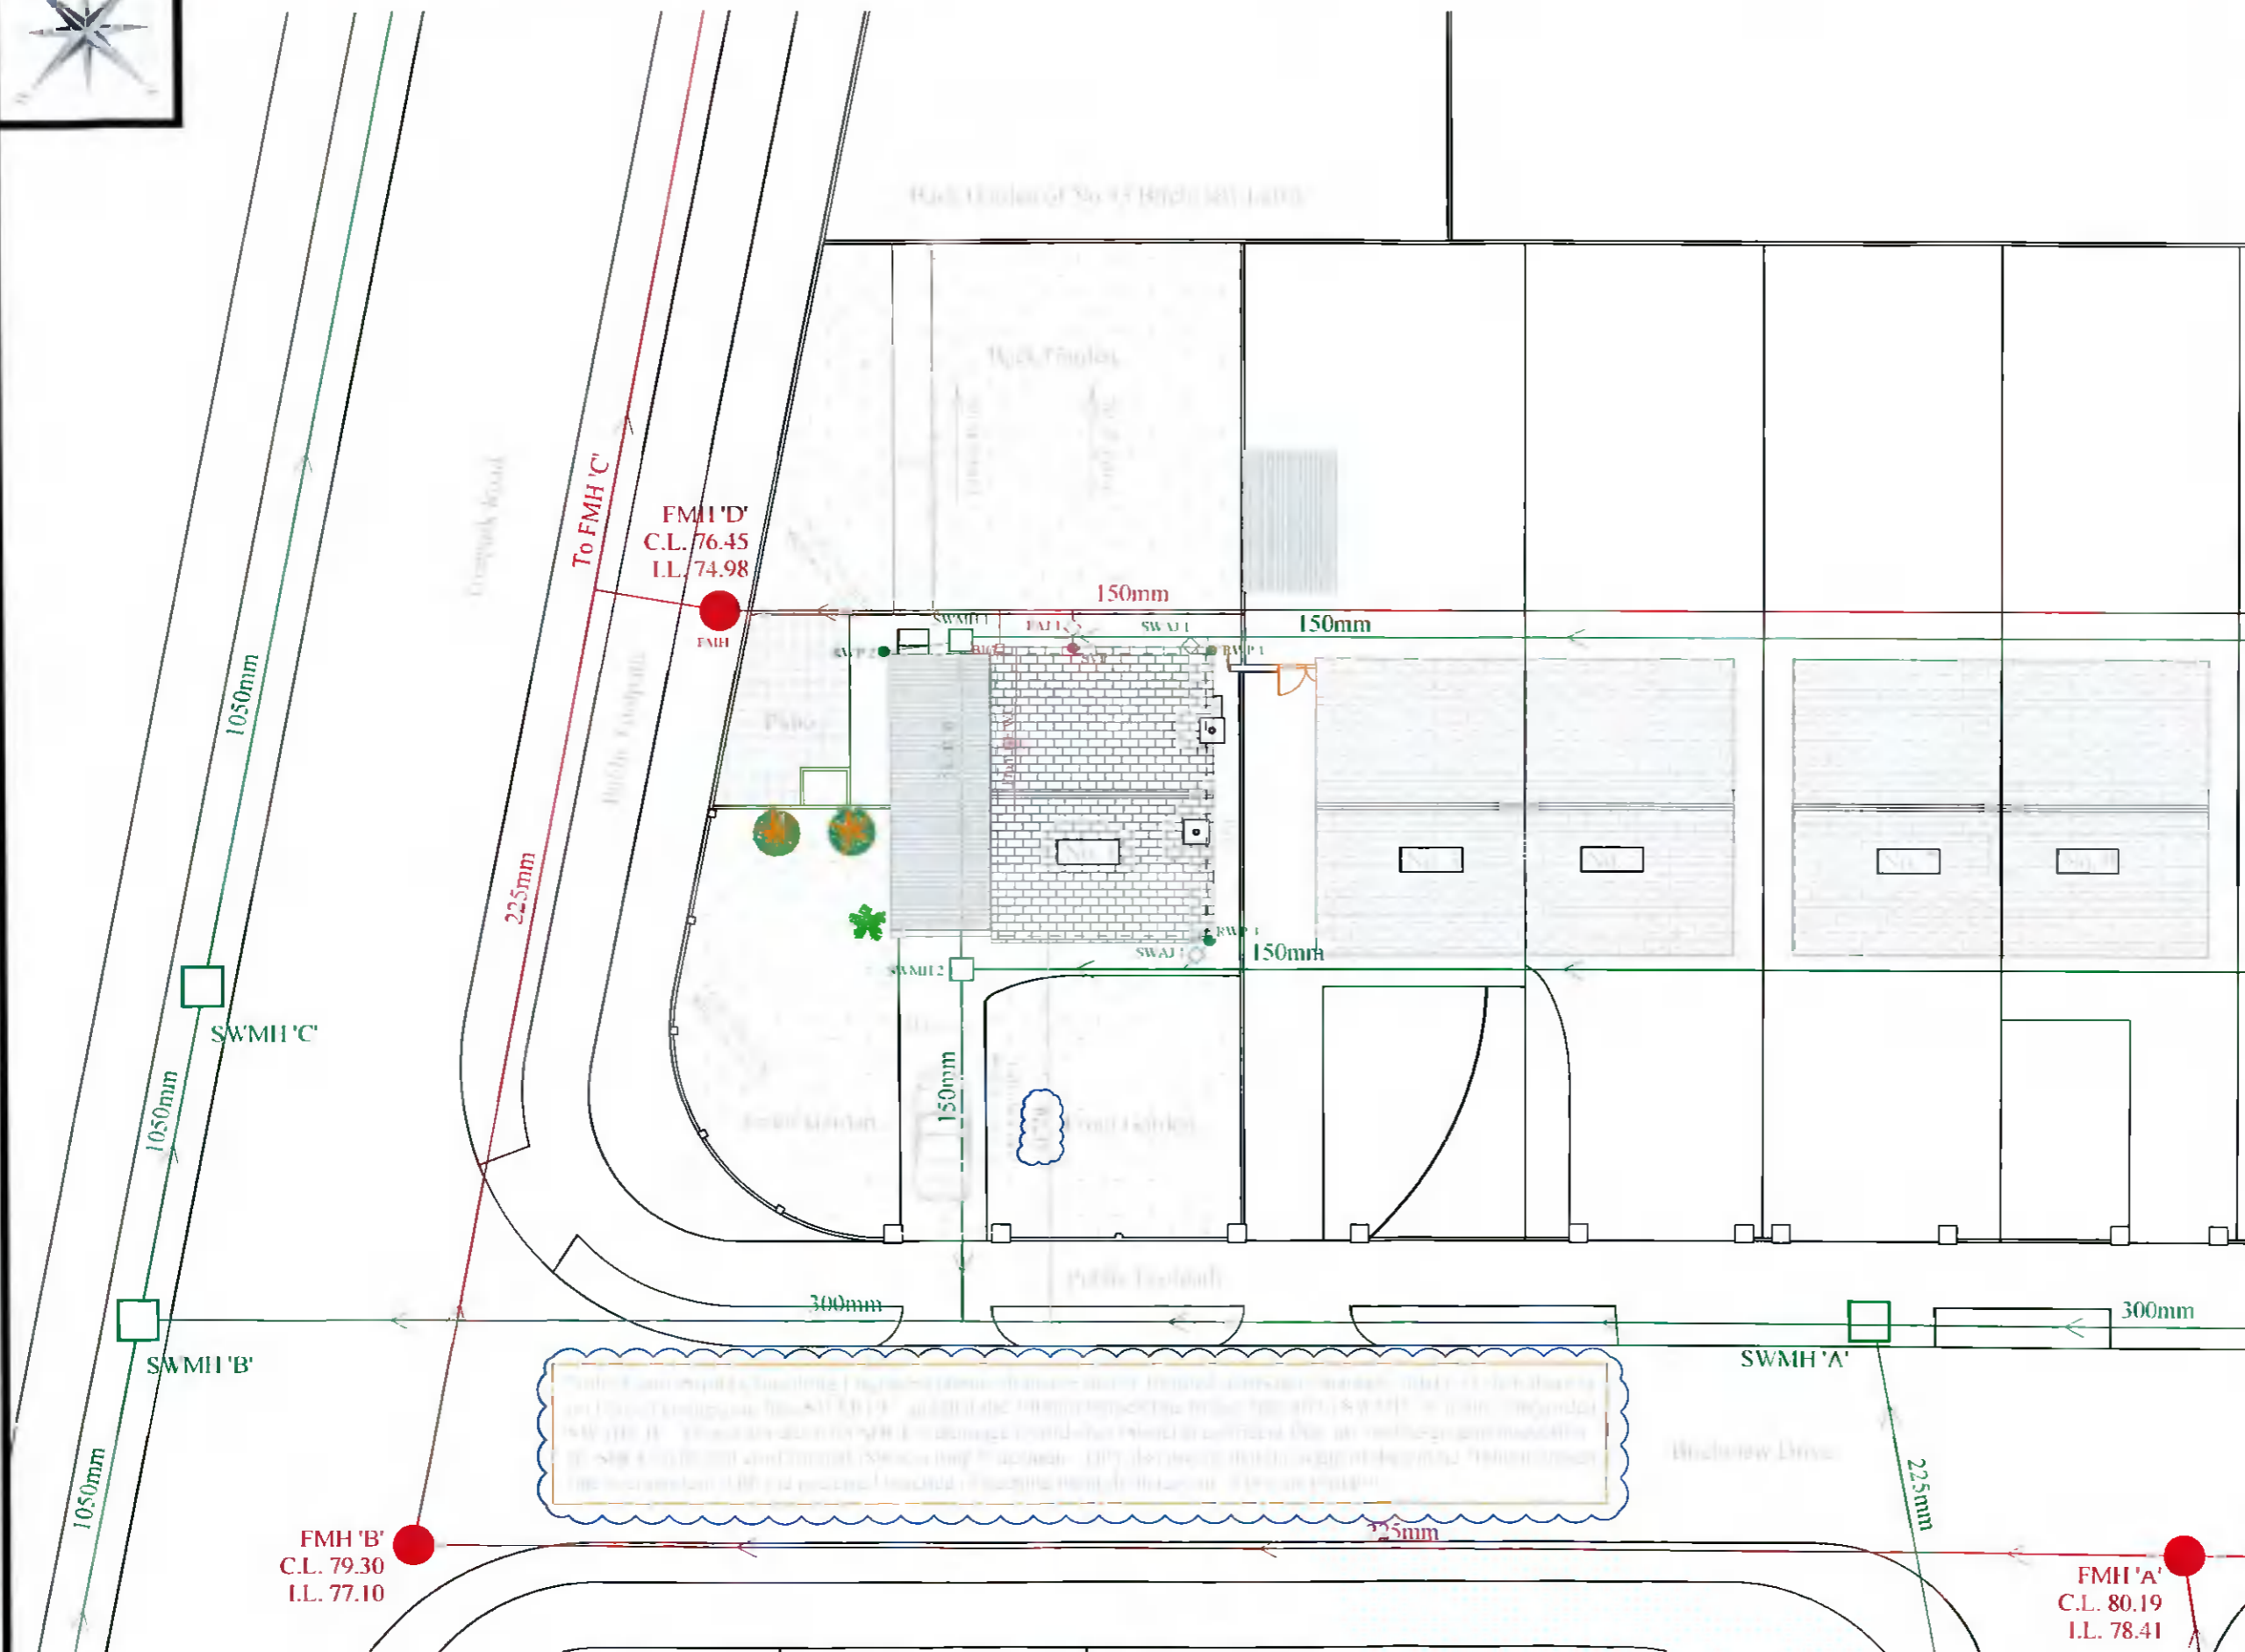

**31 Existing Drainage Plan**  
Scale: 1:200