


 


 
 

**THIS IS NOT AN APPROVED
ESB DESIGN DRAWING.
INFORMATION ONLY**

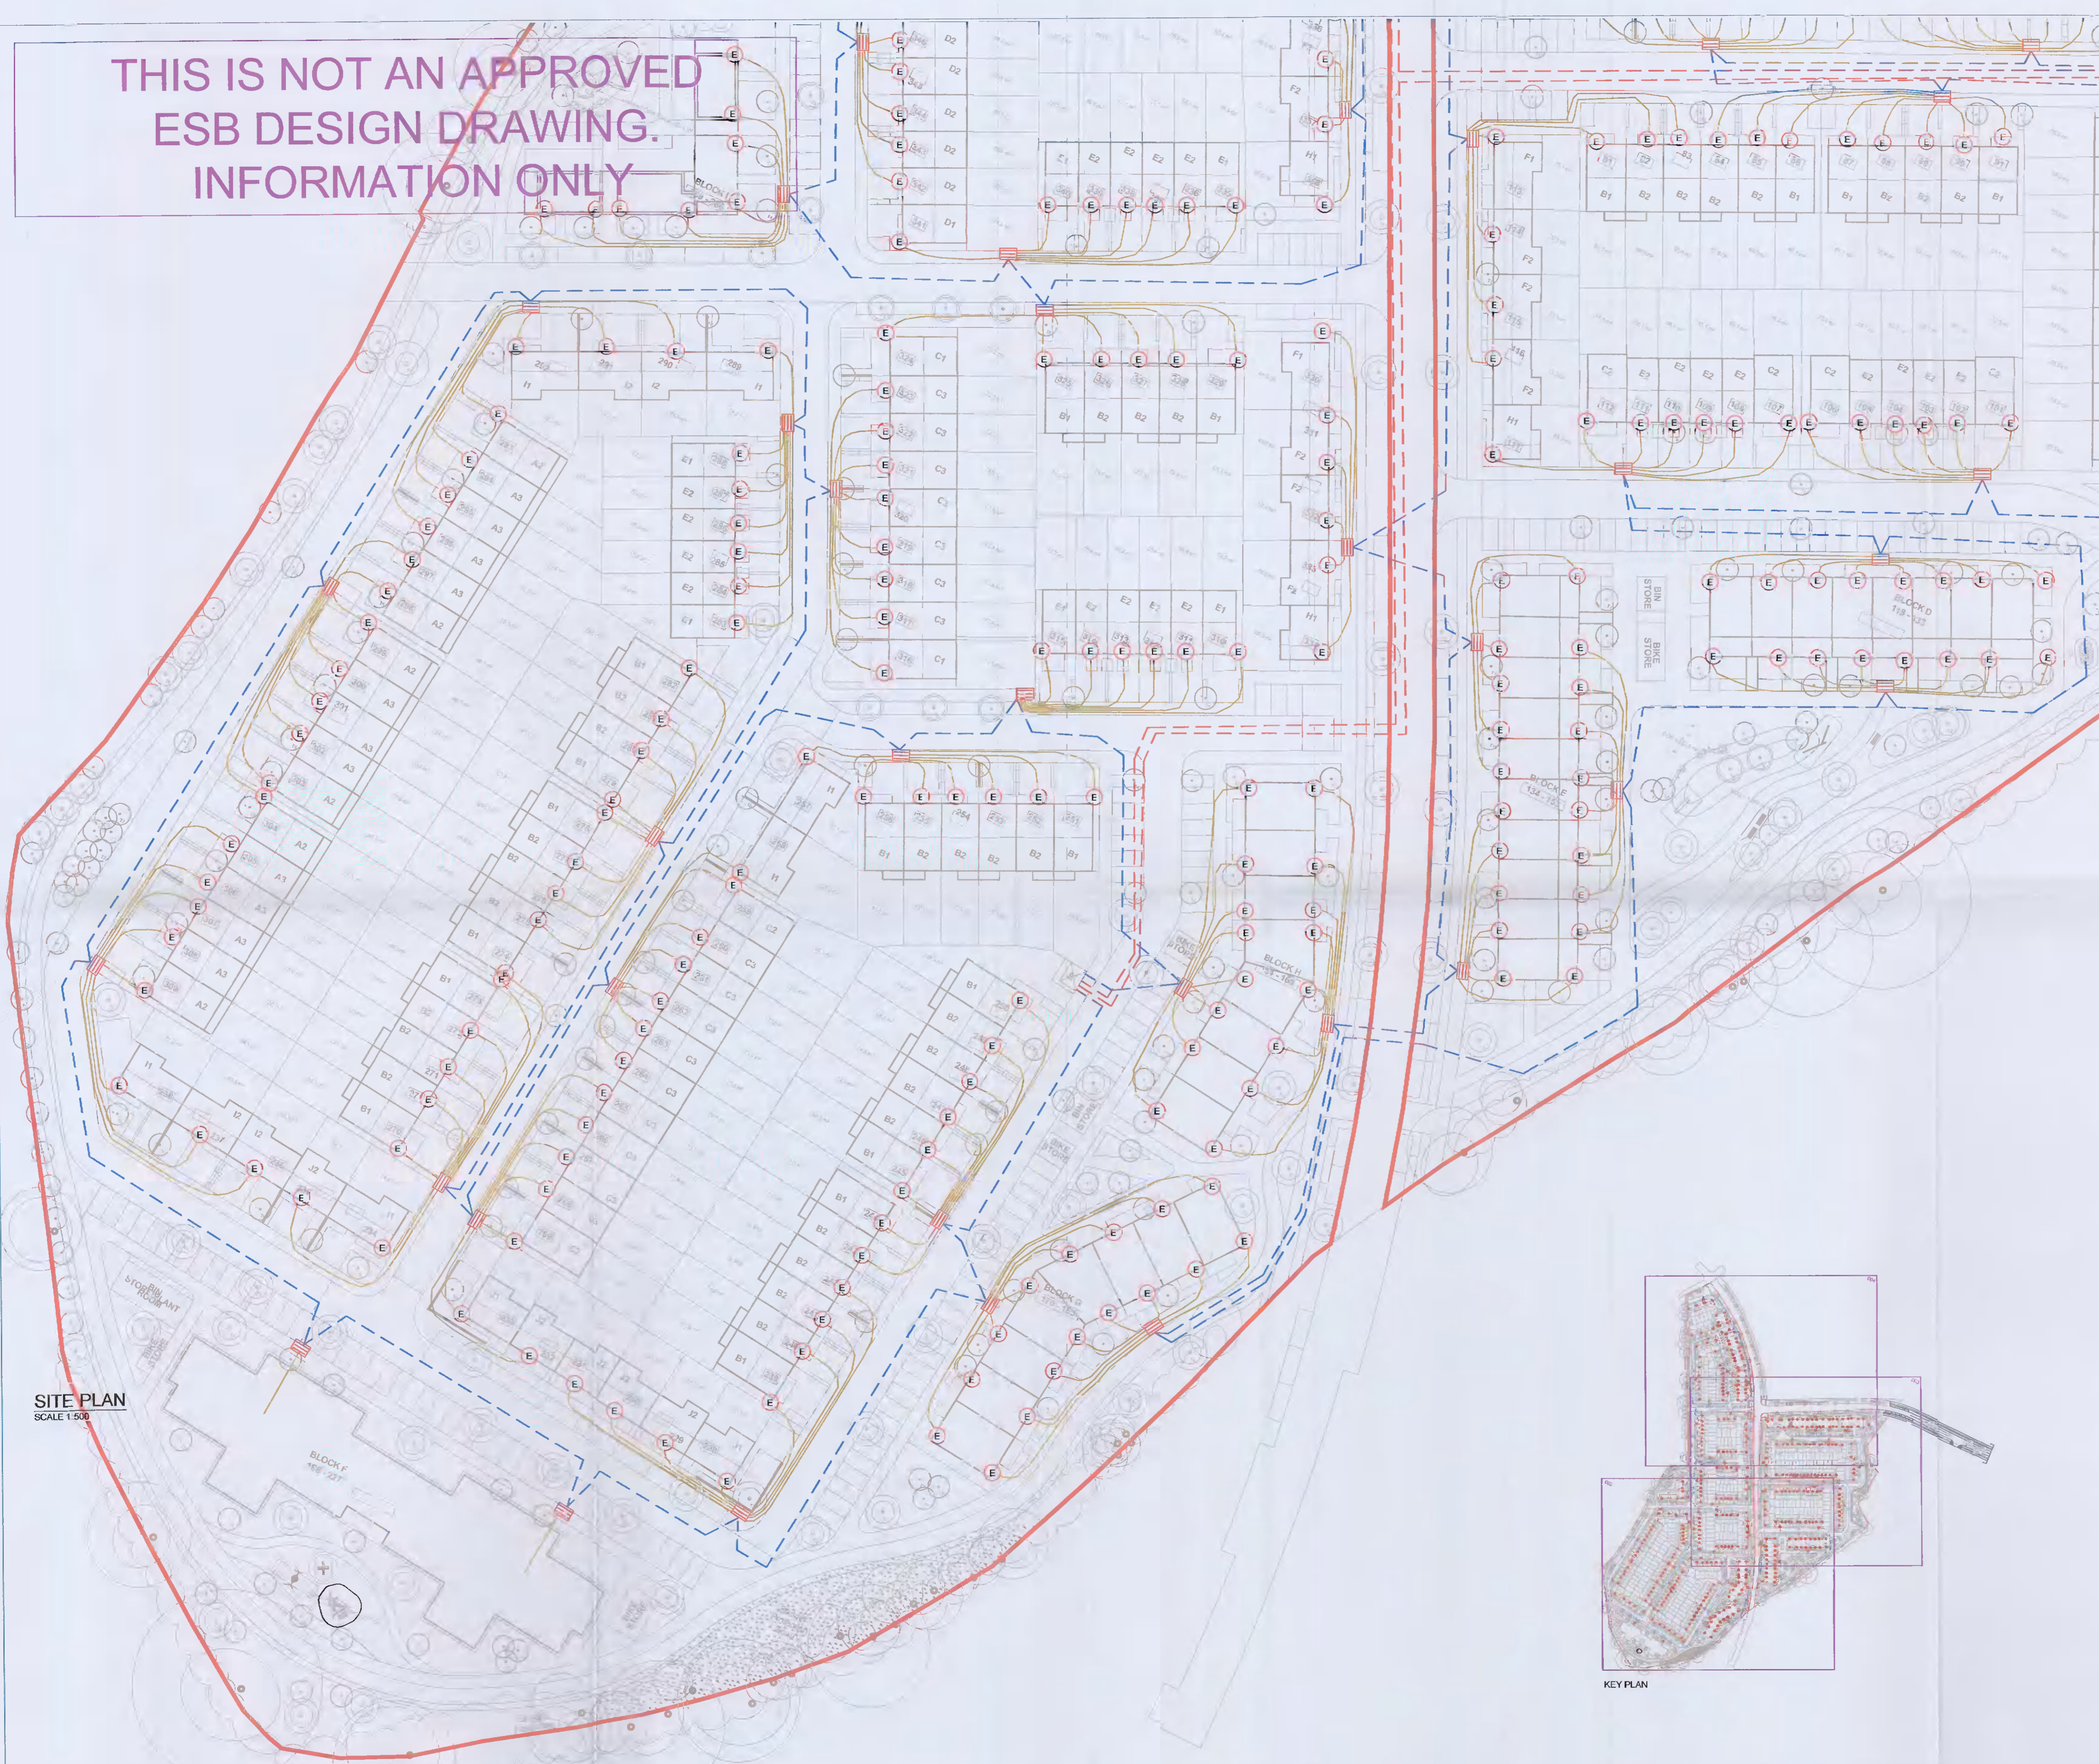
THIS DRAWING IS COPYRIGHT © ALL RIGHTS RESERVED. NO PART OF THIS DRAWING MAY BE REPRODUCED, STORED IN A RETRIEVAL SYSTEM OR TRANSMITTED IN ANY FORM OR BY ANY MEANS WITHOUT THE PRIOR WRITTEN PERMISSION FROM MCELIGOTT CONSULTING ENGINEERS LIMITED.

NOTES

01. DO NOT SCALE. USE FIGURED DIMENSIONS ONLY.
02. THIS DRAWING IS TO BE READ IN CONJUNCTION WITH ALL OTHER RELEVANT ARCHITECTURAL AND ENGINEERING DRAWINGS.
03. FINAL LOCATION OF MINIPILLARS & DUCTS TO BE AGREED WITH ESB SUPERVISOR PRIOR TO INSTALLATION.
04. PROVIDE FOR ESB METER CABINET, INTERNAL METER & BRACKETS, SURGE PROTECTION & CABLE TO PUMPING STATION CONTROL PANEL.
05. REFER TO ESB PUBLICATION ELECTRICAL SERVICES GUIDE BOOK FOR HOUSING SCHEMES FOR ALL INSTALLATION DETAILS.
06. THIS DRAWING SHOULD BE READ IN CONJUNCTION WITH THE NATIONAL CODE OF PRACTICE FOR CUSTOMER INTERFACE ISSUED BY ESB.
07. ALL ELECTRICAL WORKS SHALL BE CARRIED OUT IN ACCORDANCE WITH THE ET101 REGULATIONS.
08. THIS PROPOSAL IS FOR INFORMATION AND IS SUBJECT TO APPROVAL FROM THE ESB REPRESENTATIVE AND PLANNING PERMISSION.
09. ESB HAVE NOT FINALISED THEIR DRAWING FOR PHASE 3.
10. TO BE READ IN CONJUNCTION WITH ESB FINAL DESIGN DRAWING FOR PHASE 3.

LEGENDS

-  125mm ESB HOPE DUCT WITH TAPE OVER DUCT. (600mm COVER & 750mm COVER IN ROAD CROSSING)
-  125mm ESB HOPE DUCT WITH TAPE OVER DUCT (600mm COVER & 750mm COVER IN ROAD CROSSING)
-  50mm uPVC RED DUCTING WITH WARNING TAPE OVER (600mm MIN COVER & 750mm COVER IN ROAD CROSSING)
-  ESB UNIT-SUB
-  ESB METER CABINET OUTSIDE OF HOUSE
-  EXTERNAL ESB MINIPILLAR
-  MANHOLE



SITE PLAN
SCALE 1:500



B	FOR INFORMATION	RT	TMC	TMC	10/12/22
A	FOR INFORMATION	RT	TMC	TMC	27/08/22
ISSUE	DESCRIPTION	DRN	ORIG	APP	DATE

McElligott

CONSULTING ENGINEERS
H2a Centrepoint Business Park, Oak Road, Dublin 12
tel: +353 (0)1 424 3014 email: info@mcelligott.ie web: www.mcelligott.ie

CLIENT **HUGH MCGREEVY & SONS**

PROJECT **TUBBER LANE 3**

TITLE **PHASE 3
ESB SERVICES LAYOUT**

SHEET	SCALE	PROJECT No.	DRAWING No.
A1	1:1000	19024	E002