




**PLANNING**

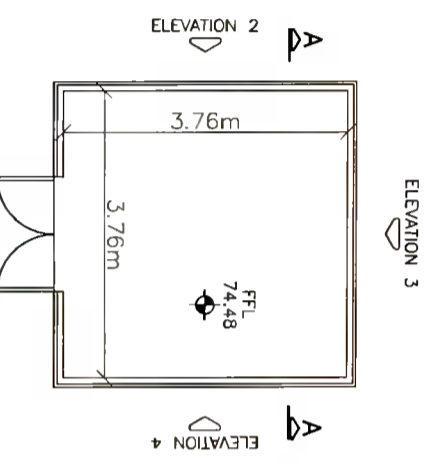


**FLOOR PLAN**  
(Scale 1:100)

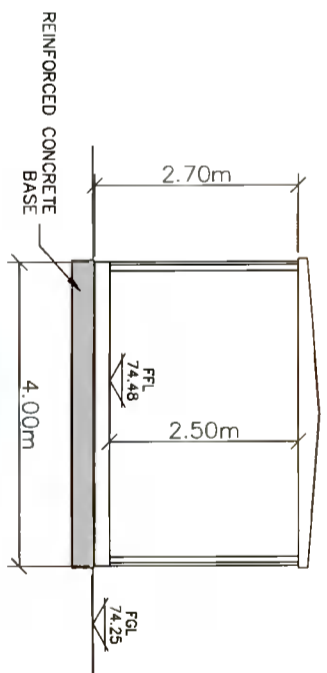


**SECTION A-A**  
(Scale 1:100)

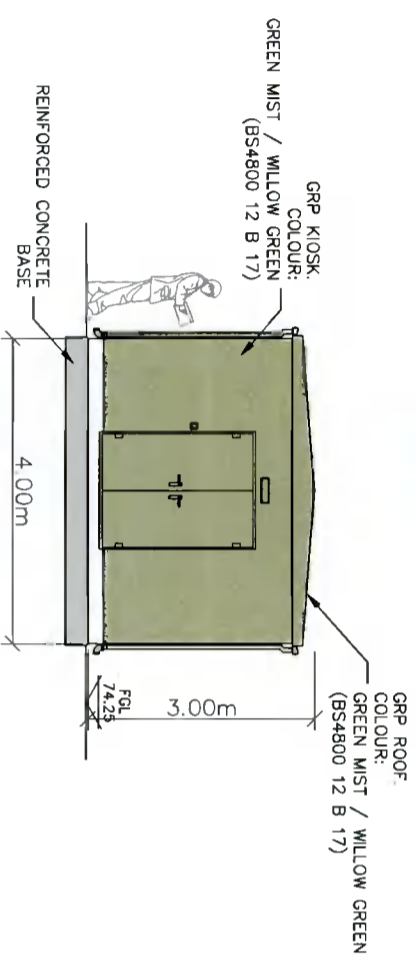


**ELEVATION 1 – Facing South**  
(Scale 1:100)

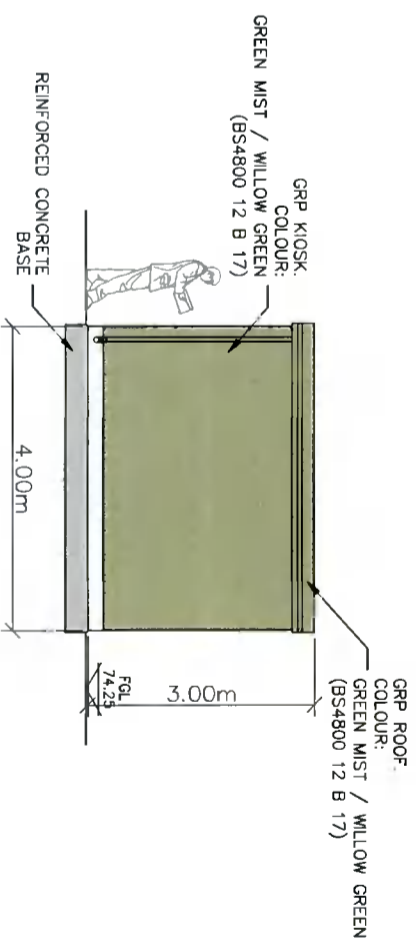

**ELEVATION 2 – Facing West**  
(Scale 1:100)

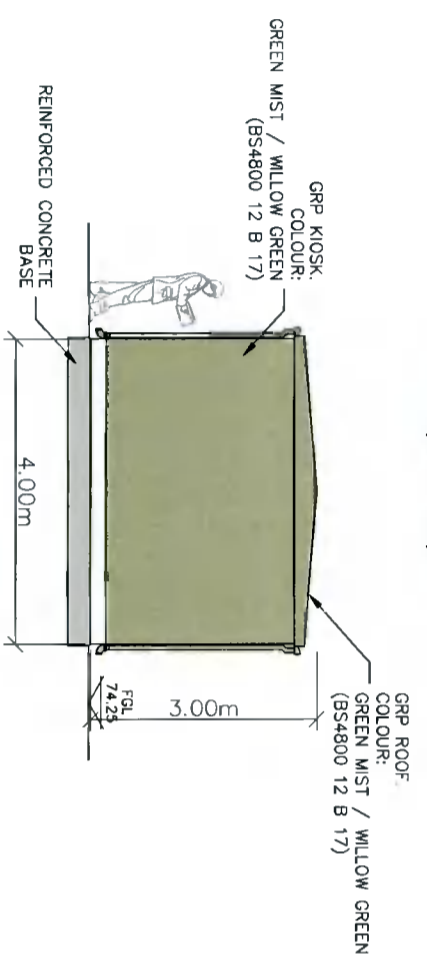

**ELEVATION 3 – Facing North**  
(Scale 1:100)

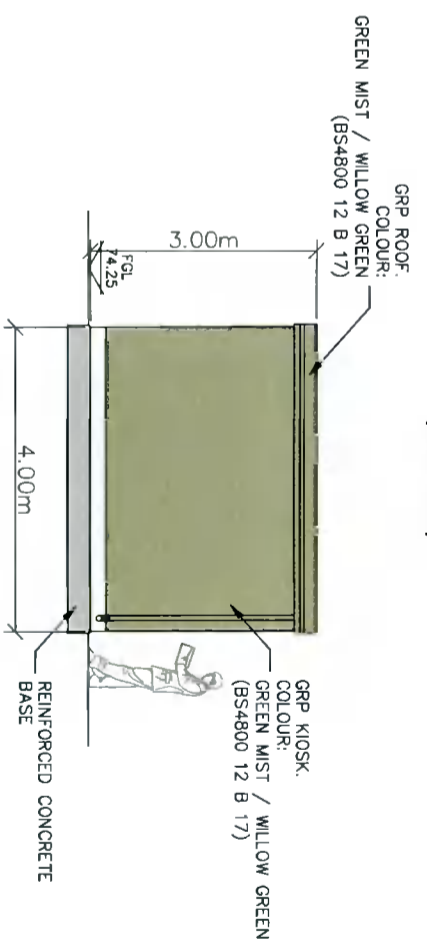

**ELEVATION 4 – Facing East**  
(Scale 1:100)

**NOTE:**  
Internal Plant Layout subject to Detailed Design Specification

ISSUE	REVISION	REV BY	A	B	C	D	E	F	G
0	PLANNING ISSUE								
		TM	RMD	JL	NM				
		08/12/2021	08/12/2021	08/12/2021	08/12/2021				

APPROVALS	
A	DRAWING OFFICE
B	DESIGN ENGINEERING
C	STRATEGY/PLANNING
D	DESIGN MANAGEMENT
E	OPERATIONS
F	CONSTRUCTION
G	AM/AO ADDITIONAL

PROJECT	44370116 PC4_TXLIC Grange Back-up Power Ltd.
TITLE	PLAN, SECTION & ELEVATIONS OF ELECTRICAL/INSTRUMENTATION KIOSK
DRAWING NUMBER	GNI/9001/07/044
SCALE	1:100
SHEET	01 OF 01



P.O. Box 51,  
Gasworks Road,  
Cork,  
Rep of Ireland  
T +353 21 4534000