


PROPOSED WORKS
SHOWN COLOURED BLUE

NOTE:
DRAINAGE LAYOUT
IS SCHEMATIC

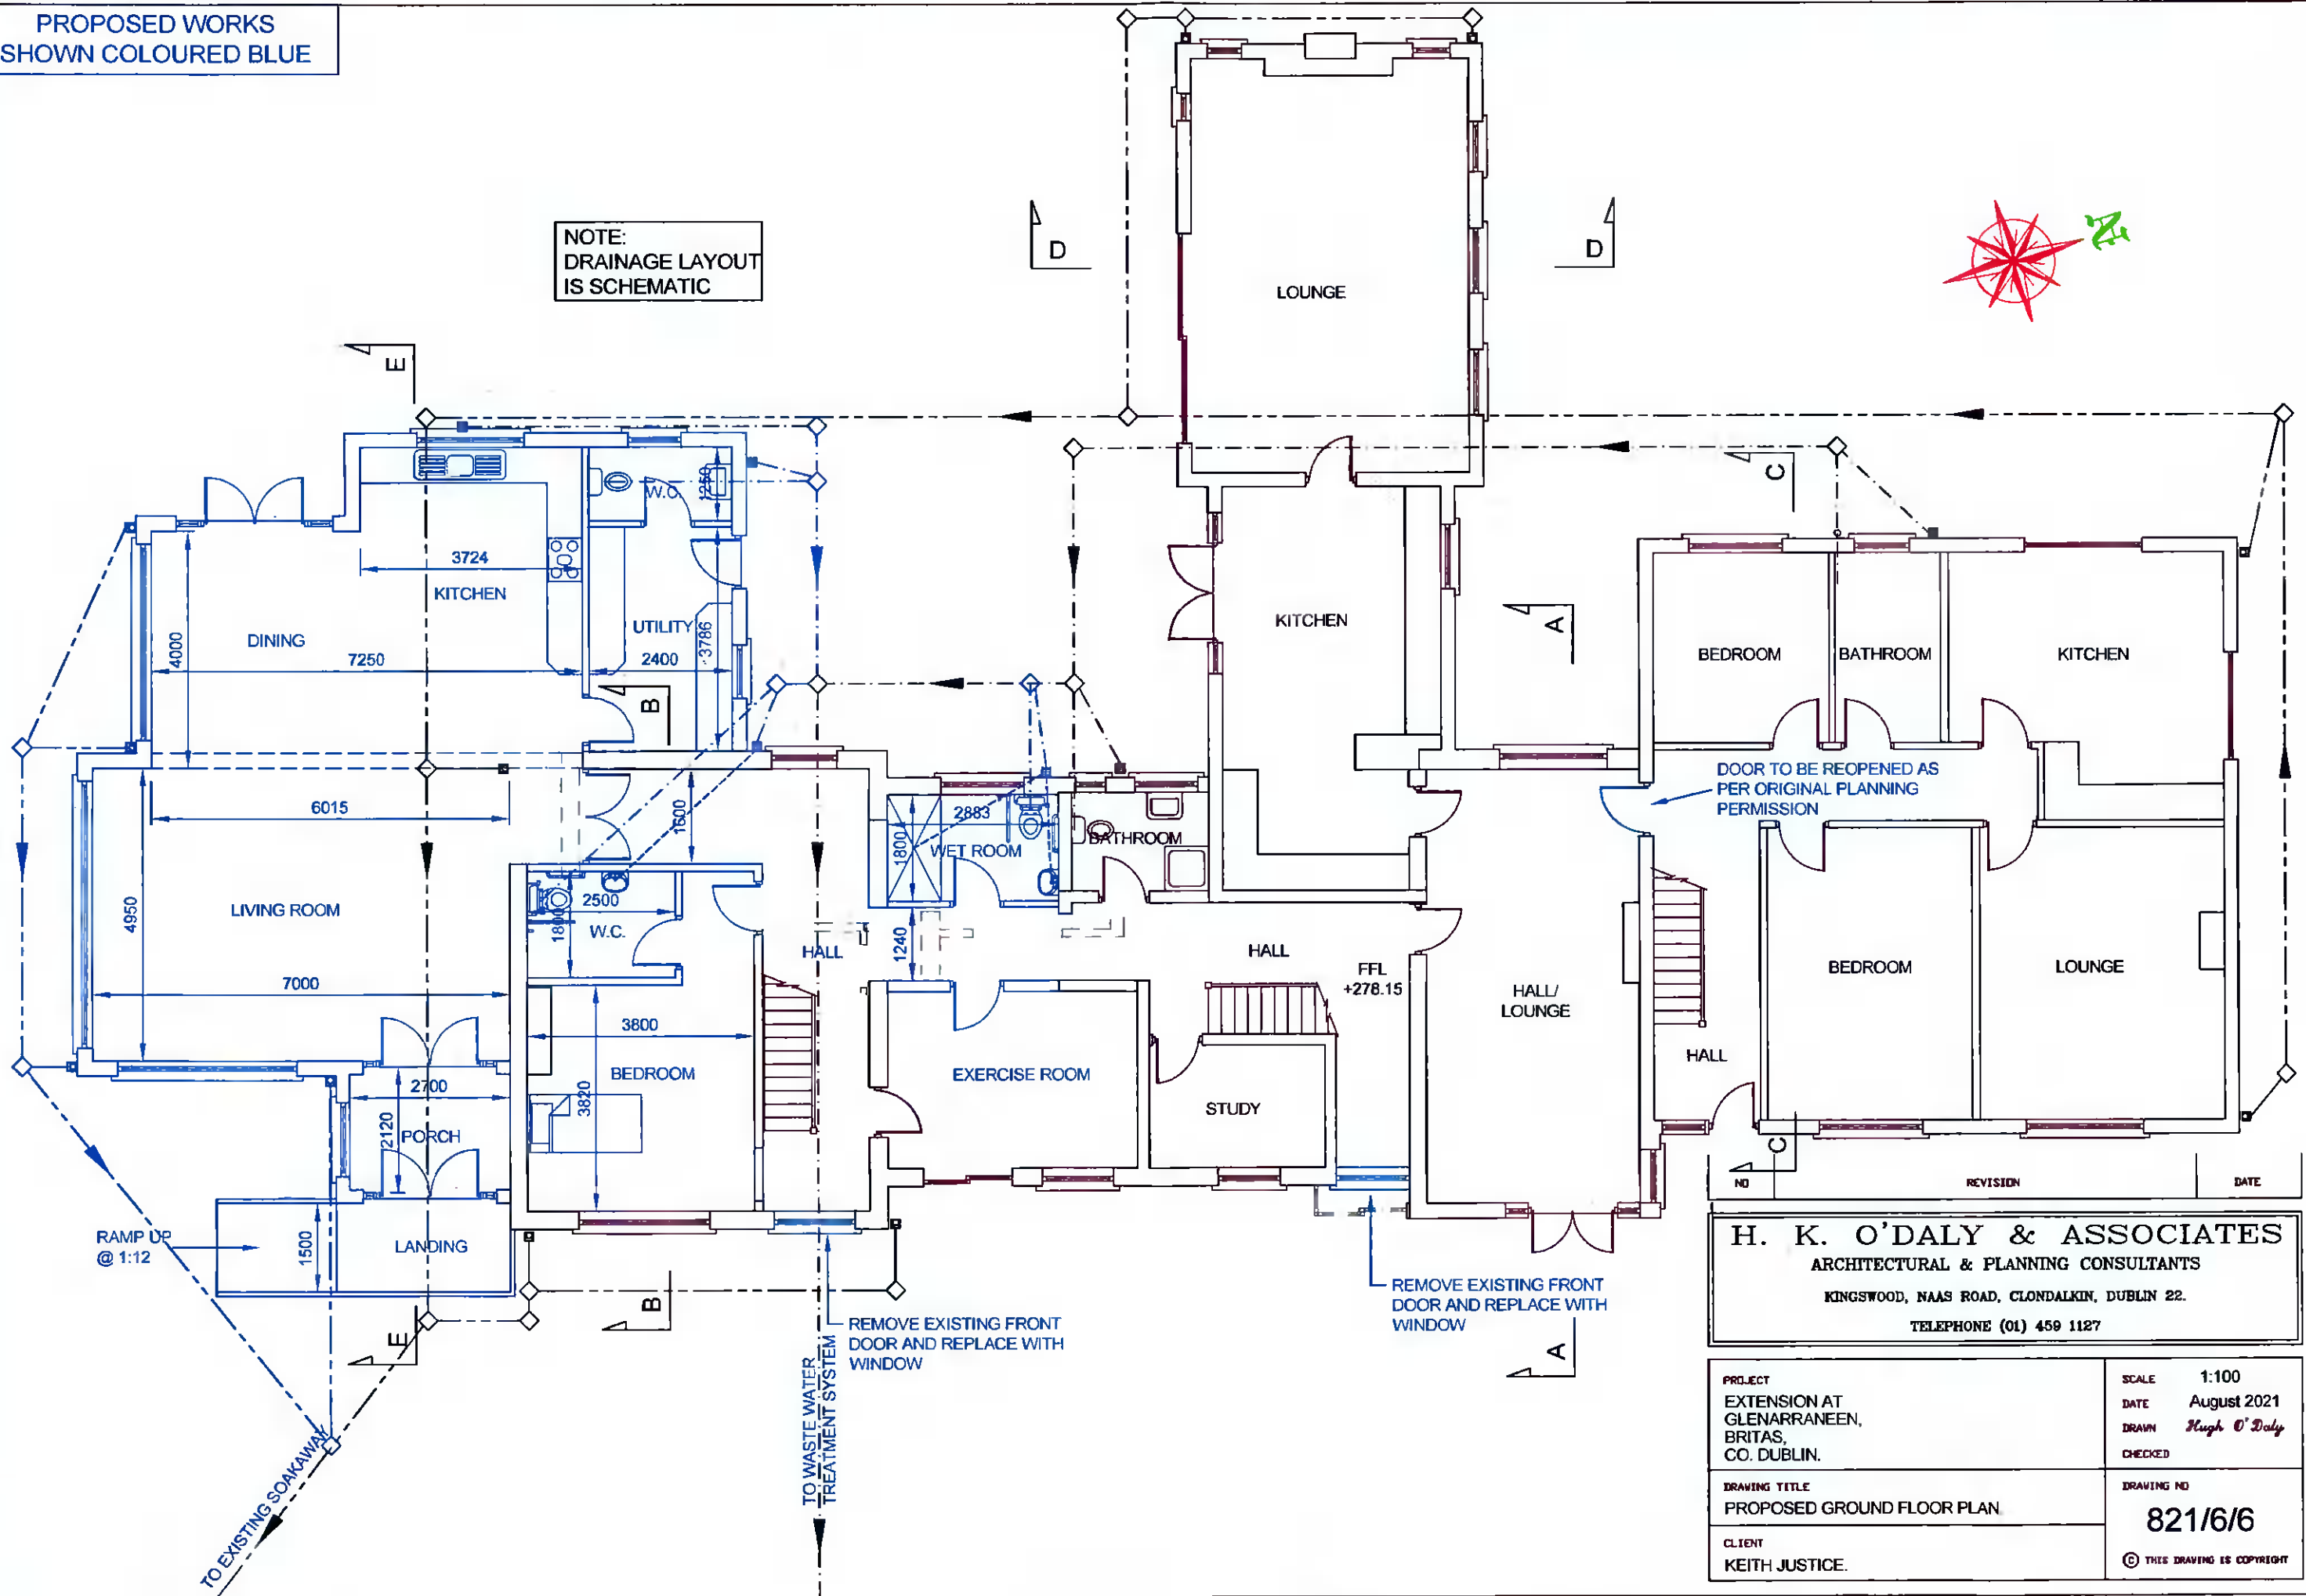

NO	REVISION	DATE

H. K. O'DALY & ASSOCIATES
ARCHITECTURAL & PLANNING CONSULTANTS
KINGSWOOD, NAAS ROAD, CLONDALKIN, DUBLIN 22.
TELEPHONE (01) 459 1127

PROJECT EXTENSION AT GLENARRANEEN, BRITAS, CO. DUBLIN.	SCALE 1:100 DATE August 2021 DRAWN <i>Hugh O'Daly</i> CHECKED
DRAWING TITLE PROPOSED GROUND FLOOR PLAN.	DRAWING NO 821/6/6
CLIENT KEITH JUSTICE.	© THIS DRAWING IS COPYRIGHT