 



Urban PLACE Map



Surveyed 1977
Revised 2015
Levelled 1992

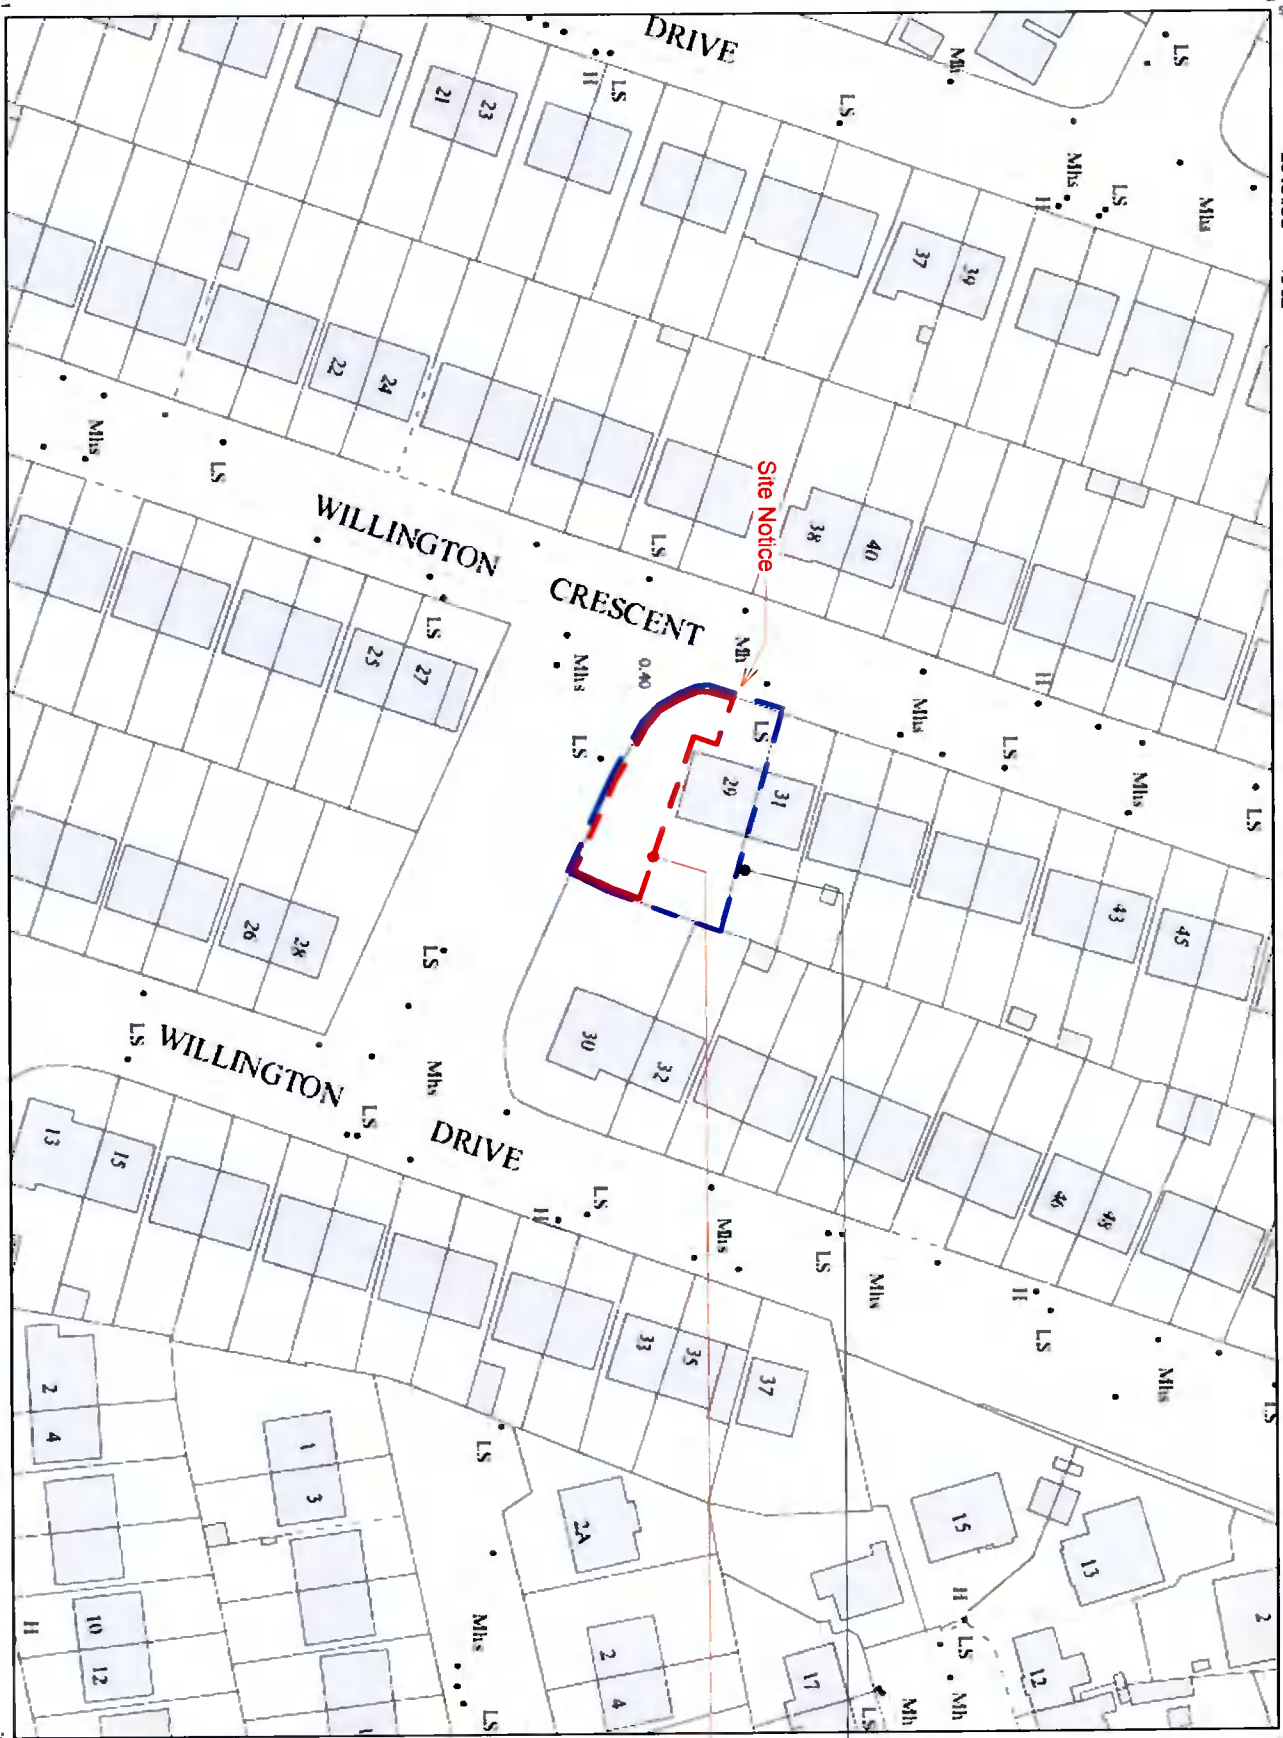

OS MAP

- NOTE**
1. Copyright Reserved.
 2. Do not scale off this drawing use figured dimensions only.
 3. The contractor is to check all dimensions and levels on site.
 4. Where appropriate, for R.C. structure, or mechanical and electrical details refer to Engineers drawings.
 5. Proprietary items to be fixed in strict accordance with manufacturers instructions and recommendations.
 6. The contractor shall be responsible for the co-ordination of structure and services.
 7. The contractor shall be responsible for ensuring that all work complies with the current Building Regulations.

Revision Schedule	Initial
No. Date Description	

PLANNING DRAWING
This drawing has been prepared for the purposes of a PLANNING APPLICATION ONLY and is NOT to be used as a Working Drawing or for Construction.

Project Name: 29 Wellington Crescent
Drawing Title: OS map
Scale: @ A3
Date: 26.02.2020
Dwg No: 506 - P030
Top Floor, 2 Westford St, Dublin 2, D02XXA9, Ireland.
T: +353 (0) 1 47 888 39 E: info@box.ie W: www.box.ie



FTM CENTRE PT COORDS	711492.729327
DESCRIPTION	
MAP SHEETS	1:1000 3327 25

Blue line denotes total site boundary & current ownership.

Red line denotes extent of Subdivision of site



Area shown on this map is based on Ordnance Survey data. It is not intended to be used for any purpose other than that for which it was prepared. The user of this map is advised to check the accuracy of the data for their own use. Ordnance Survey is not responsible for any loss or damage caused by the use of this map. © Ordnance Survey 2016