
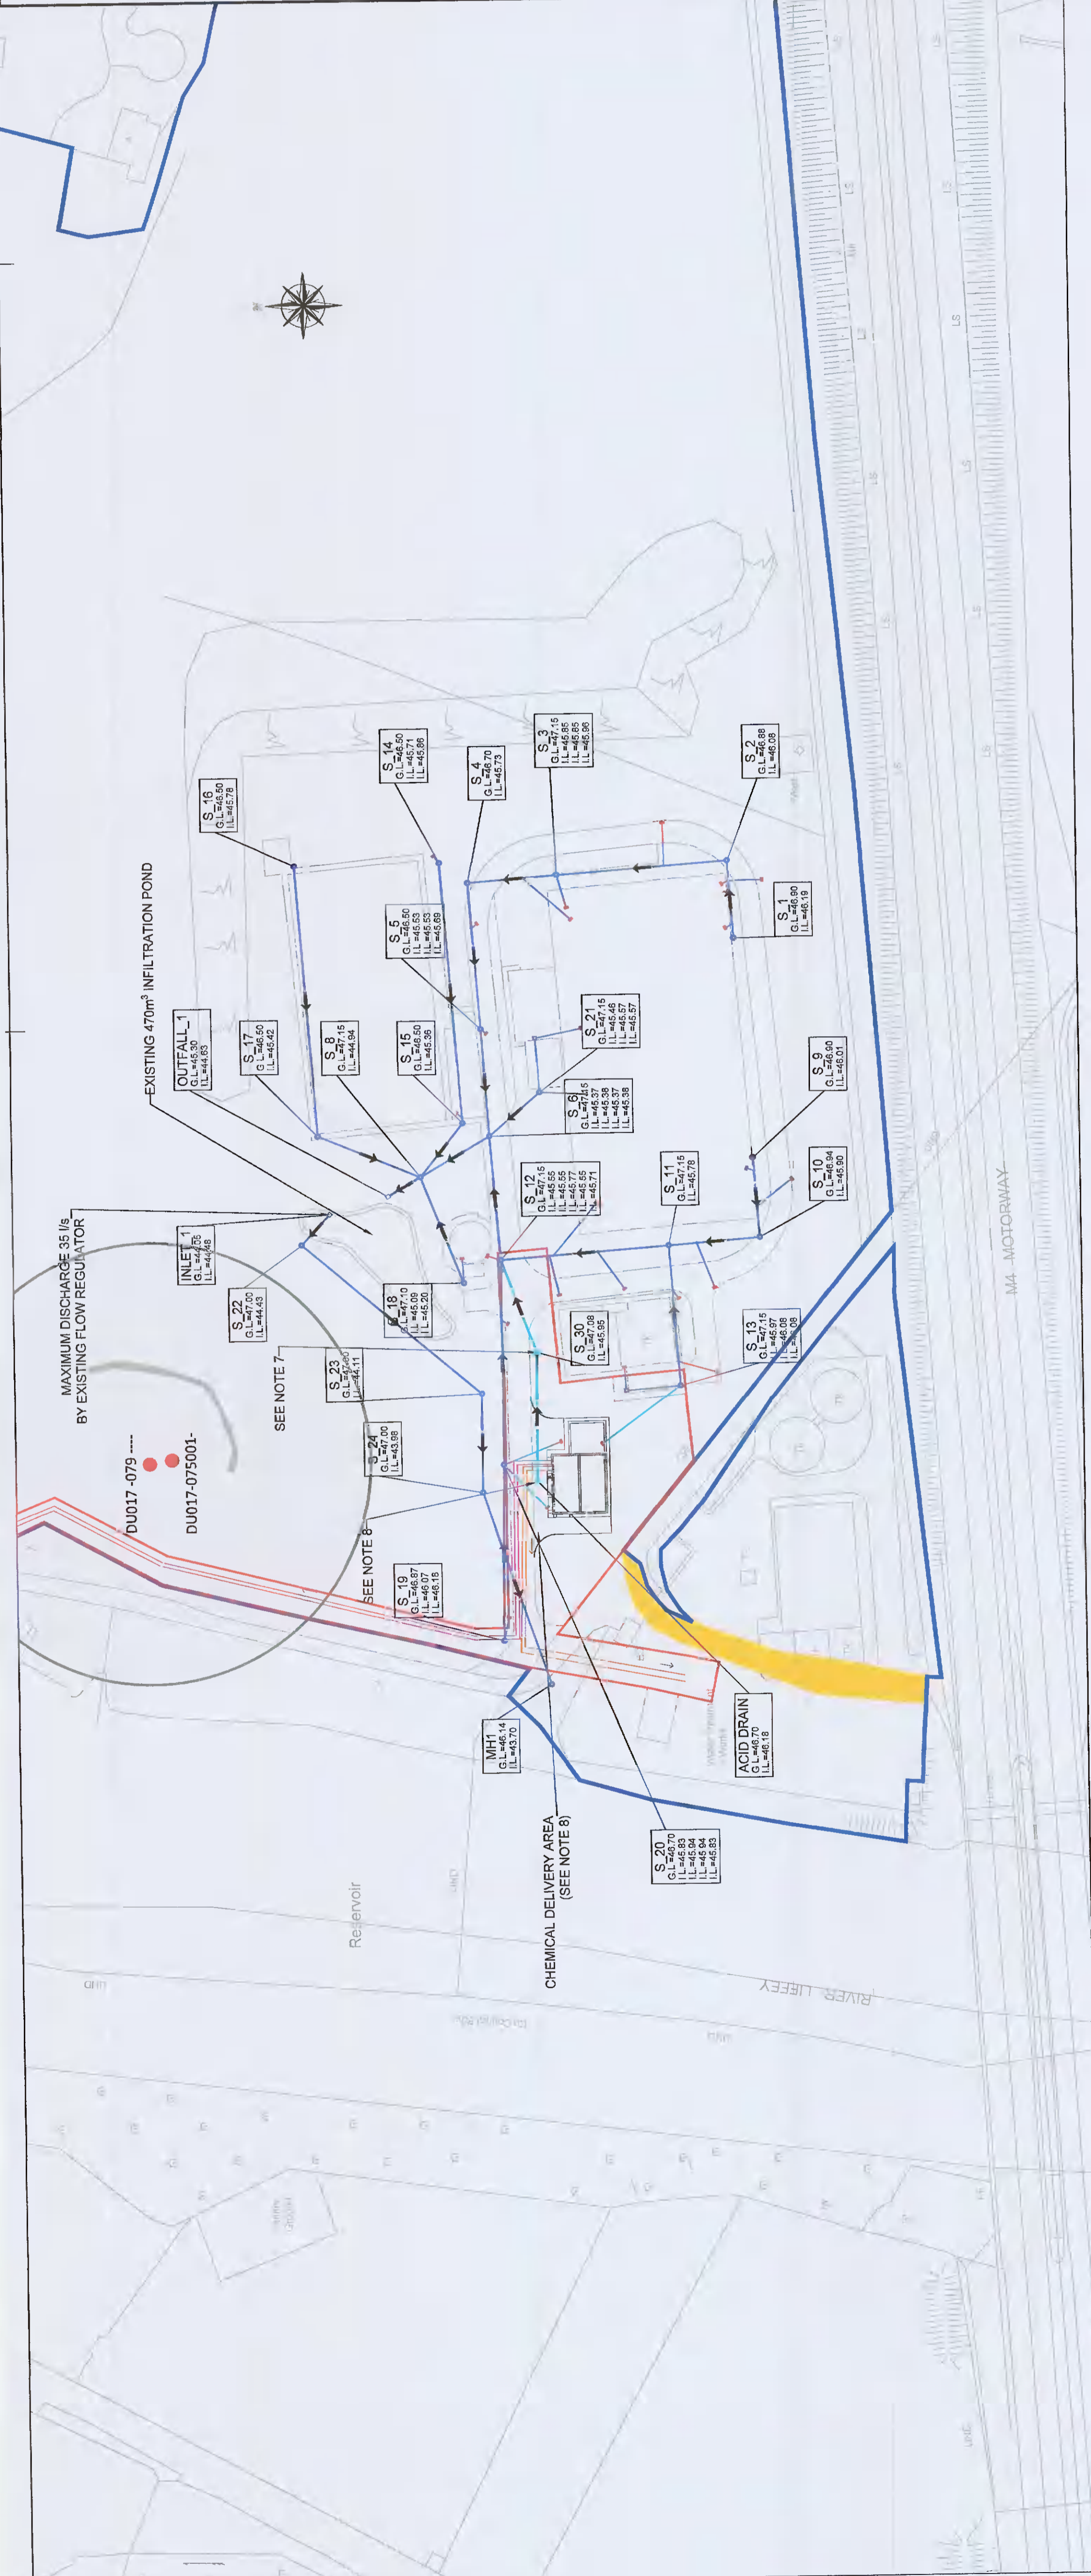


- NOTES:**
- DO NOT SCALE THIS DRAWING - IF IN DOUBT ASK.
  - ALL WORK ON THE SITE TO BE IN ACCORDANCE WITH THE SAFETY, HEALTH AND WELFARE AT WORK (CONSTRUCTION) REGULATIONS.
  - ALL DIMENSIONS ARE AS SHOWN.
  - ALL LEVELS ARE SHOWN IN M.O.D.
  - ALL DRAWINGS ARE TO BE READ IN CONJUNCTION WITH OTHER FABRICATORS DRAWINGS.
  - ALL CONSTRUCTION LEVELS AND CONTOURS ON THE INCLUDED DRAWINGS ARE TO BE VERIFIED BY THE SURVEYOR.
  - NORMALLY OPEN TO ALLOW UNCONTAMINATED RAIN TO BE DRAWN FROM CHEMICAL DELIVERY AREA TO BE ACID RESISTANT (PTFE OR EQUIVALENT). ACID RESISTANT SHUT-OFF VALVE TO BE NORMALLY OPEN TO ALLOW UNCONTAMINATED RAIN TO BE DRAWN FROM CHEMICAL DELIVERY AREA TO BE ACID RESISTANT (PTFE OR EQUIVALENT). ACID RESISTANT SHUT-OFF VALVE TO BE NORMALLY OPEN TO ALLOW UNCONTAMINATED RAIN TO BE DRAWN FROM CHEMICAL DELIVERY AREA TO BE ACID RESISTANT (PTFE OR EQUIVALENT).
  - SECTION TO BE OVER-SIZED TO PROVIDE EMERGENCY STORAGE FOR DELIVERY TANKERS WILL BE SET OUT IN DETAIL IN DRAWING 11118-RHL-LP2-XX-DR-PL-0016
  - MODIFICATION TO EXISTING SURFACE WATER DRAINAGE SYSTEMS TO BE COMPLETED WHERE CUSH OCCURS WITH ALL SURFACE WATER SECTIONS CHECKED FOR PERCENTAGE FILLING - ALL LESS THAN 80% FULL

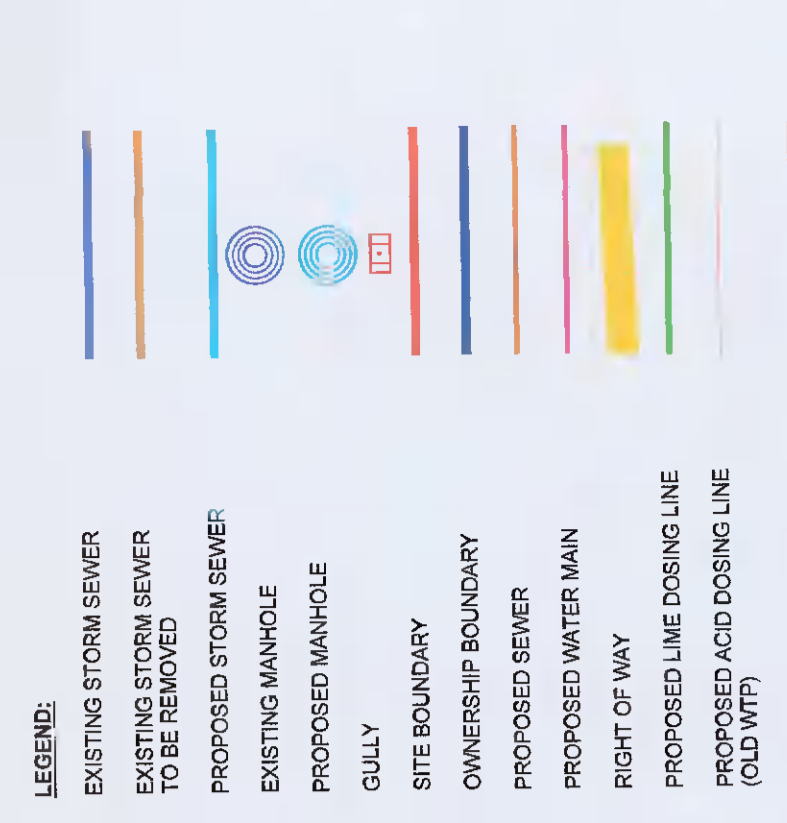

REV	DATE	DESCRIPTION	D	C	A
02	28/01/22	Updated following comments	EV	MG	MJ
01	28/09/21	Updated following comments	EV	MG	JB

**Planning Drawings**

**COPYRIGHT RESERVED - THIS DRAWING IS NOT TO BE USED FOR A PURPOSE OTHER THAN THAT FOR WHICH IT WAS PREPARED BY GLAN AGUA IN ANY MANNER WITHOUT WRITTEN CONSENT.**

**CLIENT:** IRISH WATER  
 Civic House, 100, North Wall, Dublin 1.  
 Tel: 1890 278 278 Web: www.water.ie

**FINGAL COUNTY COUNCIL**  
 County Hall, Main Street, Swords, County Dublin.

**PROJECT**  
**LEIXLIP WATER TREATMENT PLANT UPGRADE**

**GLAN AGUA**  
 MOTENGIL GROUP  
 Tel: +353(0)1909830301  
 Fax: +353(0)1909630300  
 Email: info@glanagua.com  
 Web: www.glanagua.com

**RYAN HANLEY CONSULTING ENGINEERS**  
 1 Cabway Business Park, Dangan, Galway.  
 HPA3EF (Head Office),  
 Email: ryan.hanley@rhanley.ie  
 Web: www.rhanley.ie

**TITLE**  
**PROPOSED AND EXISTING SURFACE WATER DRAINAGE PLAN & PROFILES**

SCALE	DRAWN	CHECKED	APPROVED
EV	MG	JB	JB
1:100	26/05/2021	26/05/2021	26/05/2021
1:1000	26/05/2021	26/05/2021	26/05/2021

DRAWING No: 11118-RHL-LP2-XX-DR-PL-0017  
 STATUS: S2  
 REVISION: 02

S\_19 - S\_1  
 M:1:1000/100

A142  
 M:1:1000/100

