




**NOTES:**  
 1. THIS DRAWING IS TO BE READ IN CONJUNCTION WITH ALL OTHER RELEVANT DRAWINGS & SPECIFICATIONS.  
 2. DO NOT SCALE, USE FIGURED DIMENSIONS ONLY.

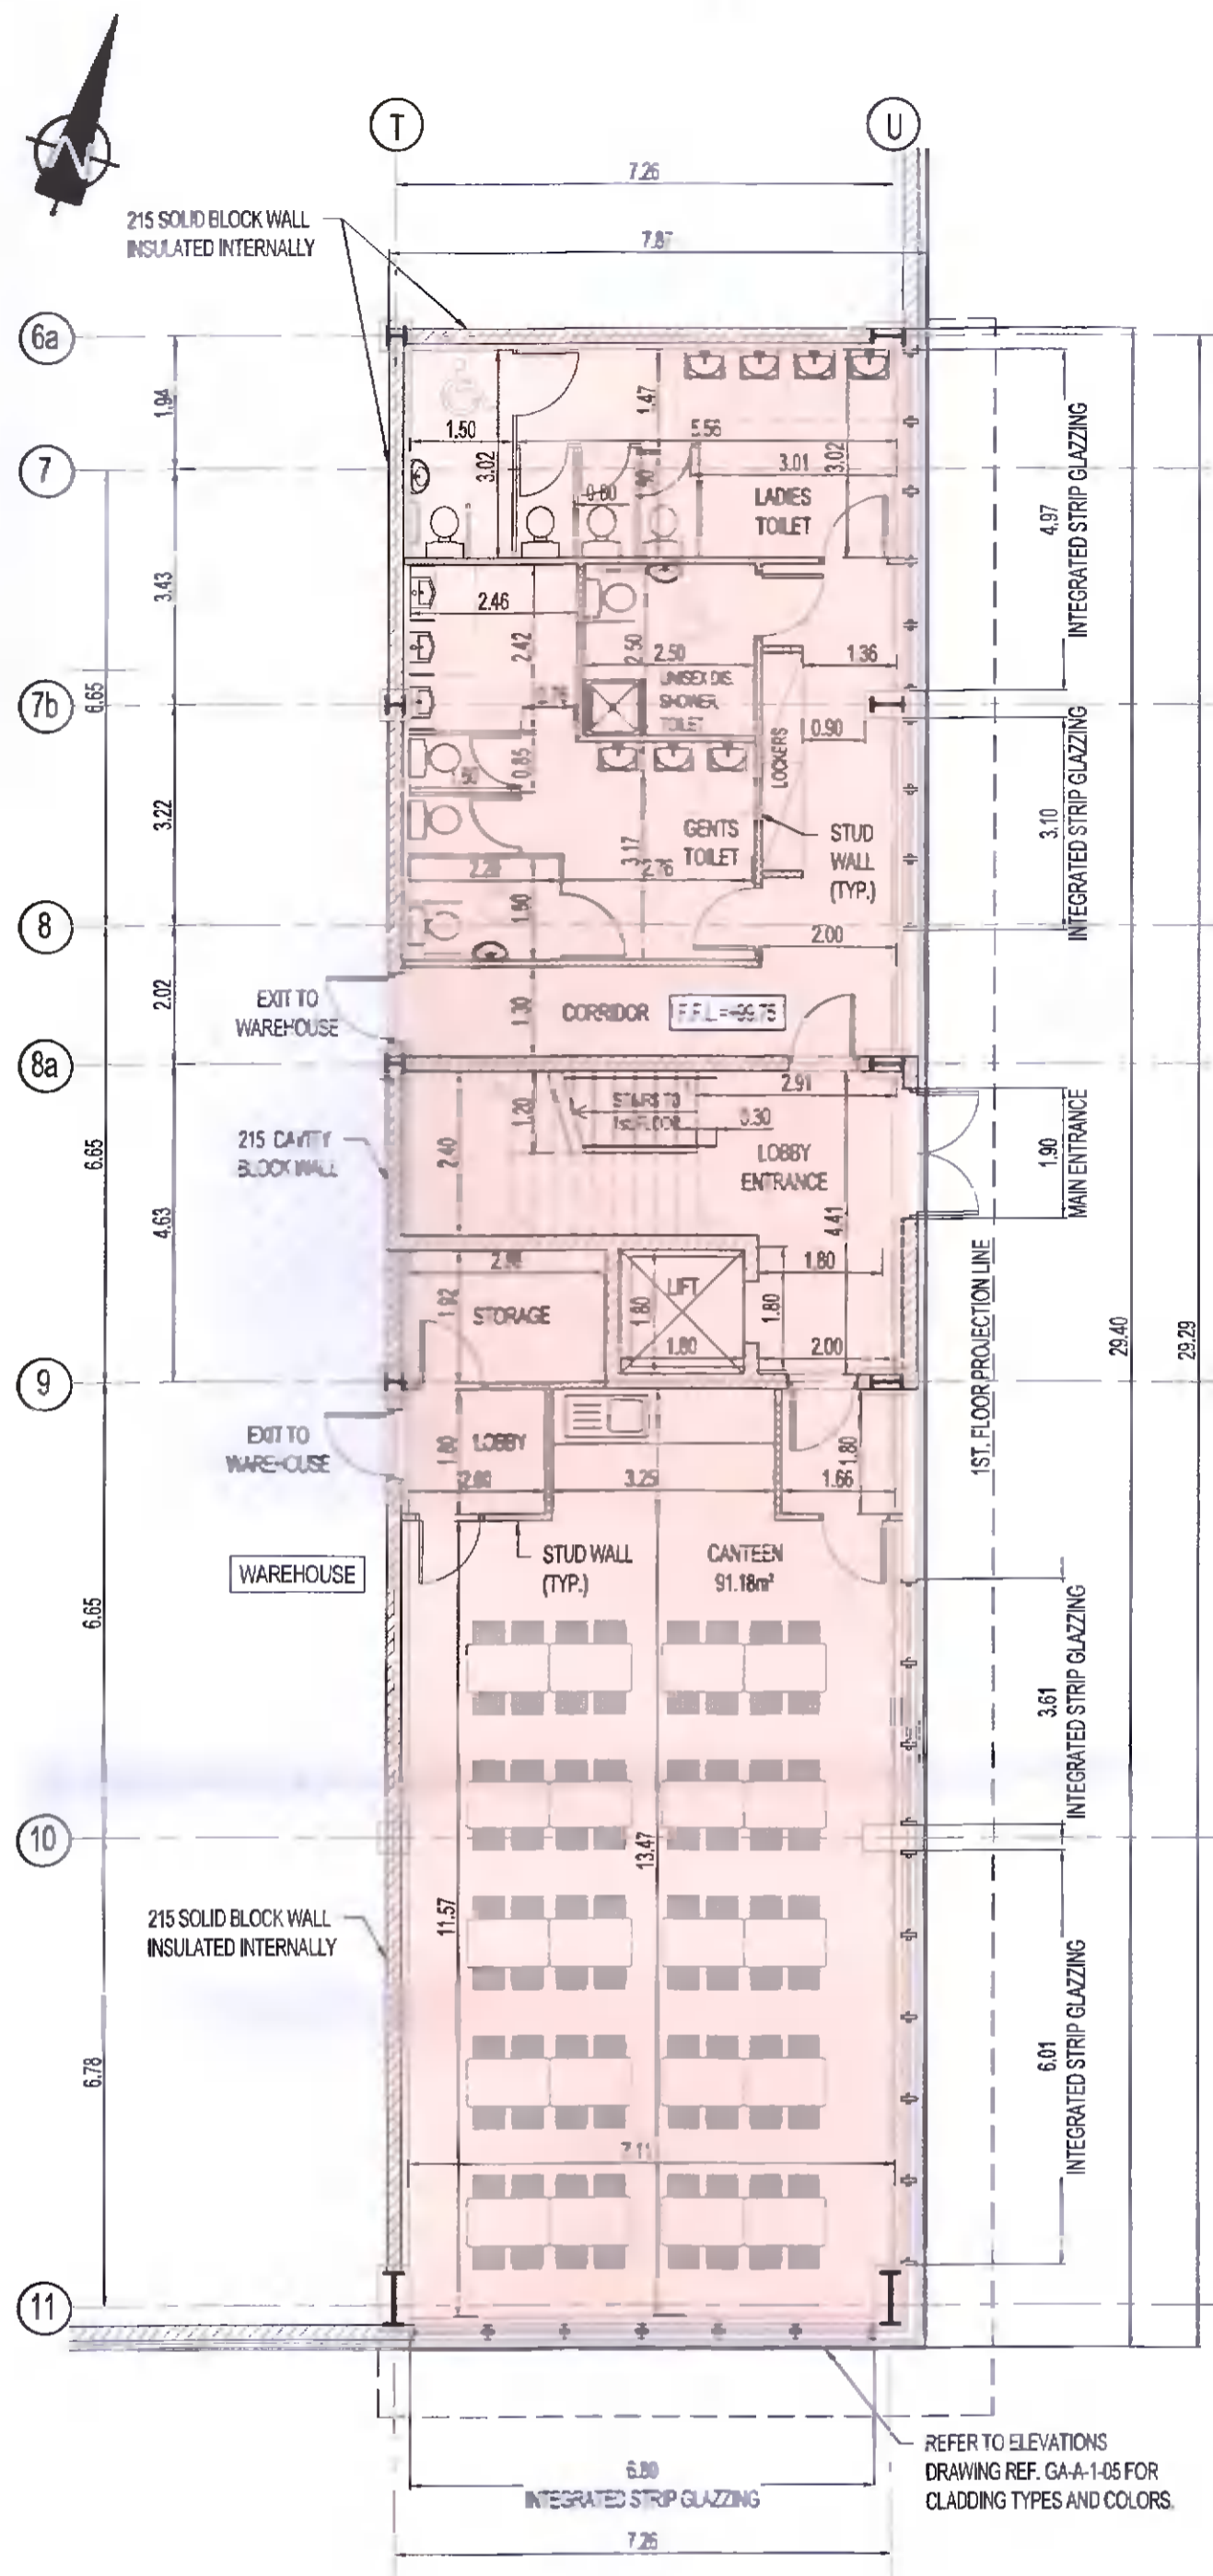


**ANCILLARY OFFICES - GROUND FLOOR PLAN**  
 SCALE 1:100

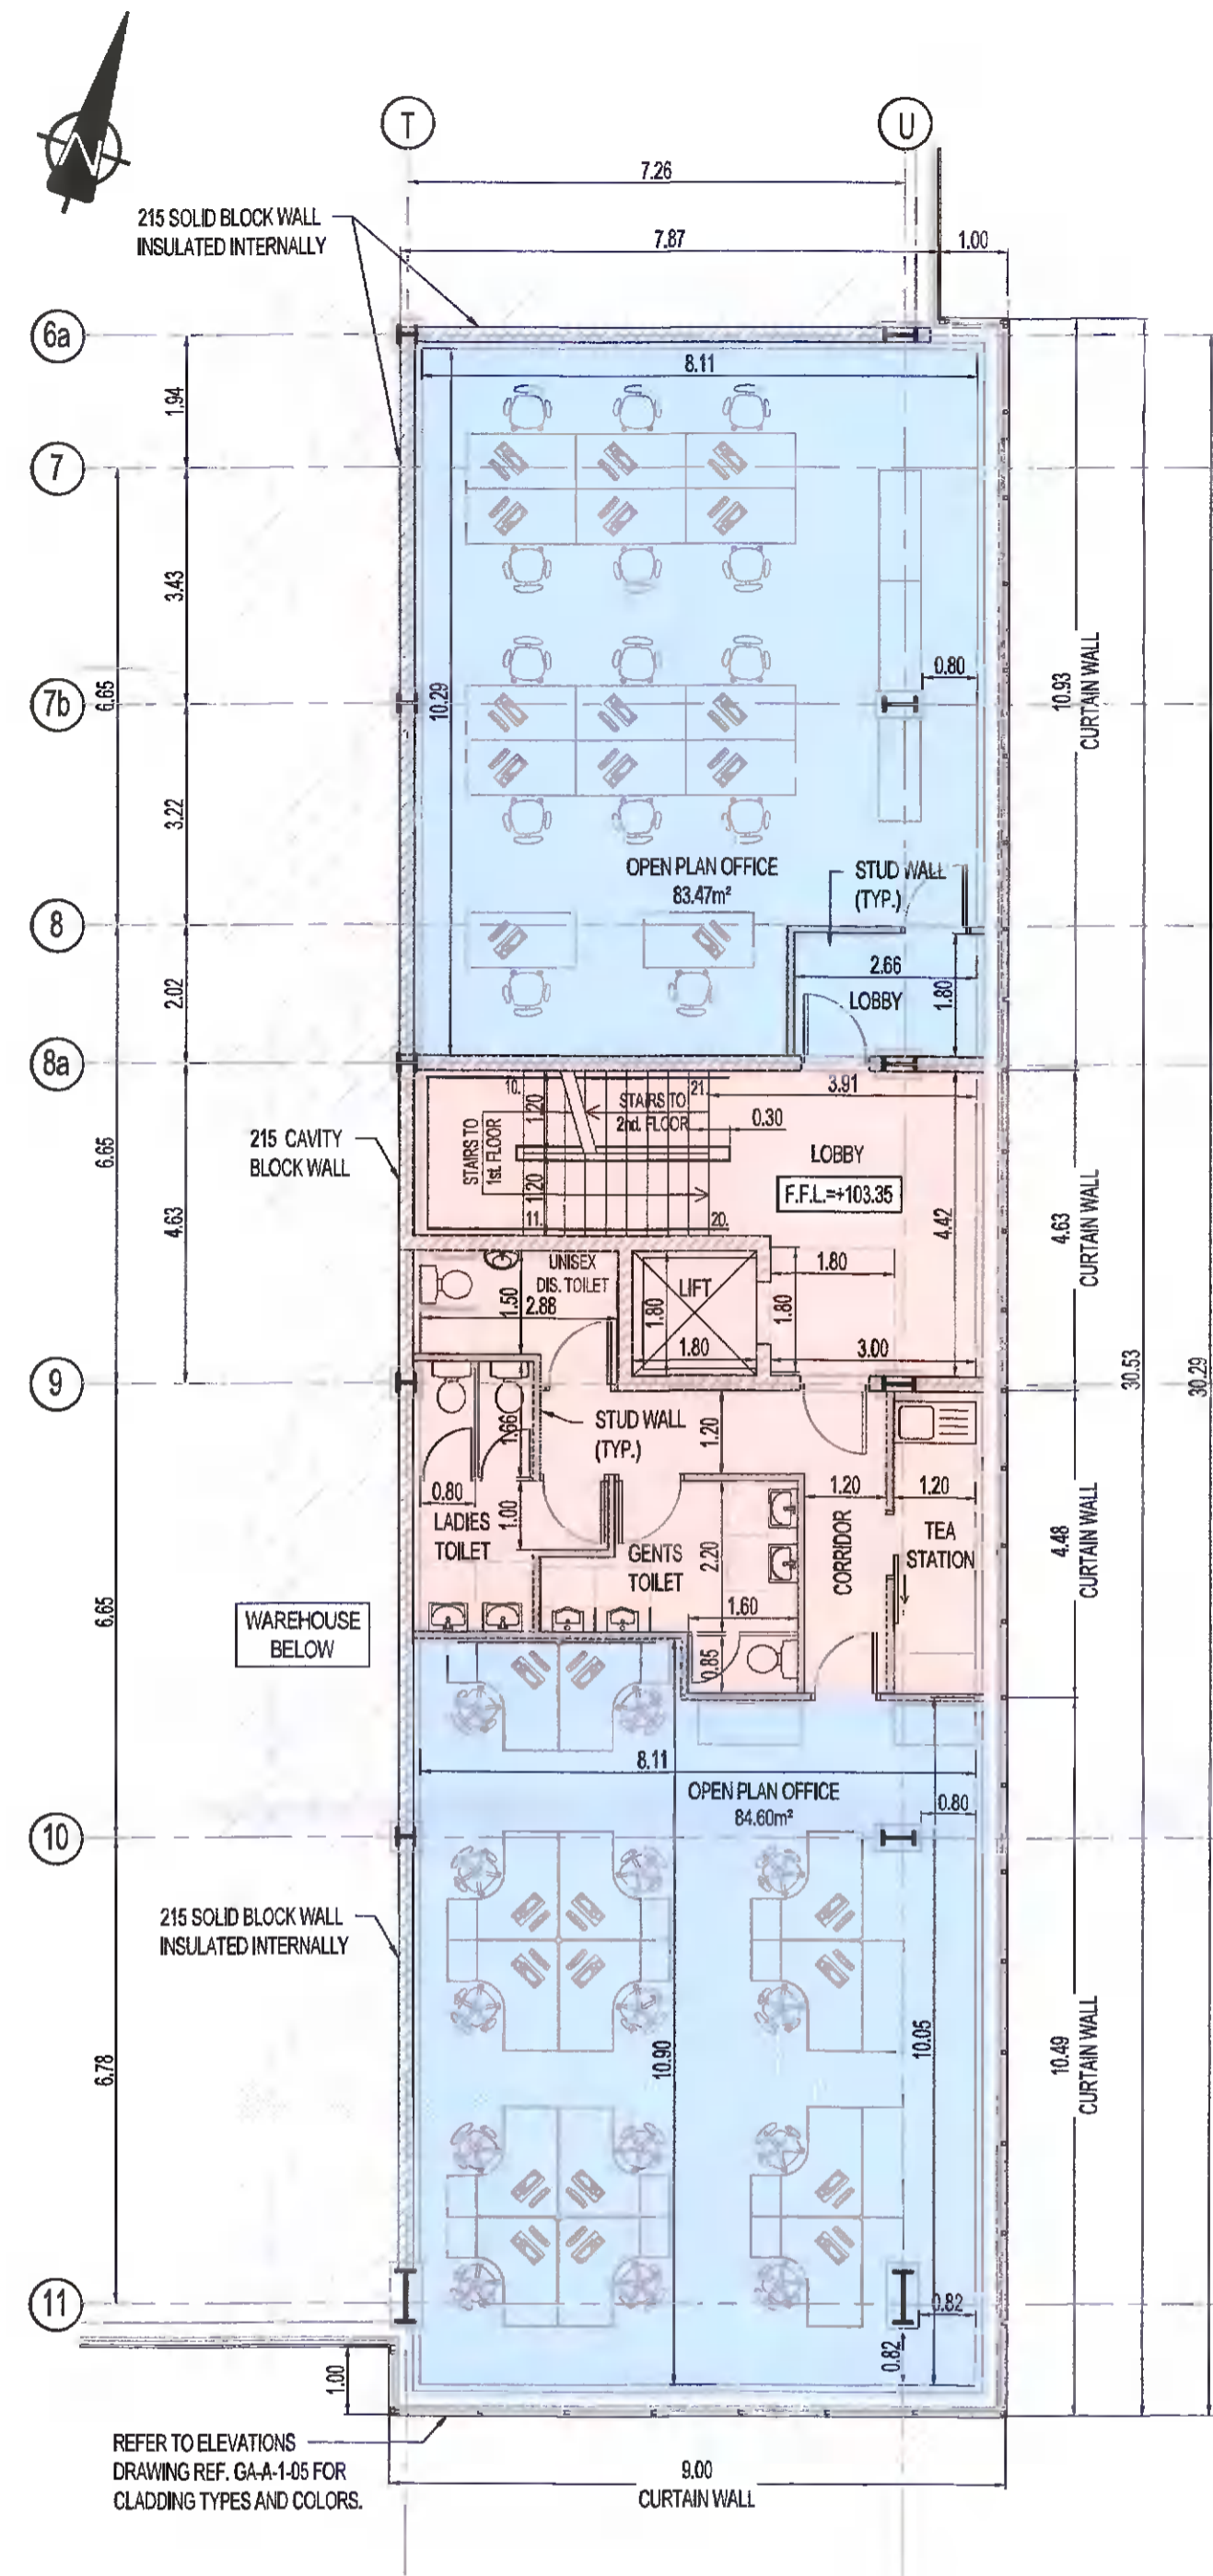


**ANCILLARY OFFICES - FIRST FLOOR PLAN**  
 SCALE 1:100

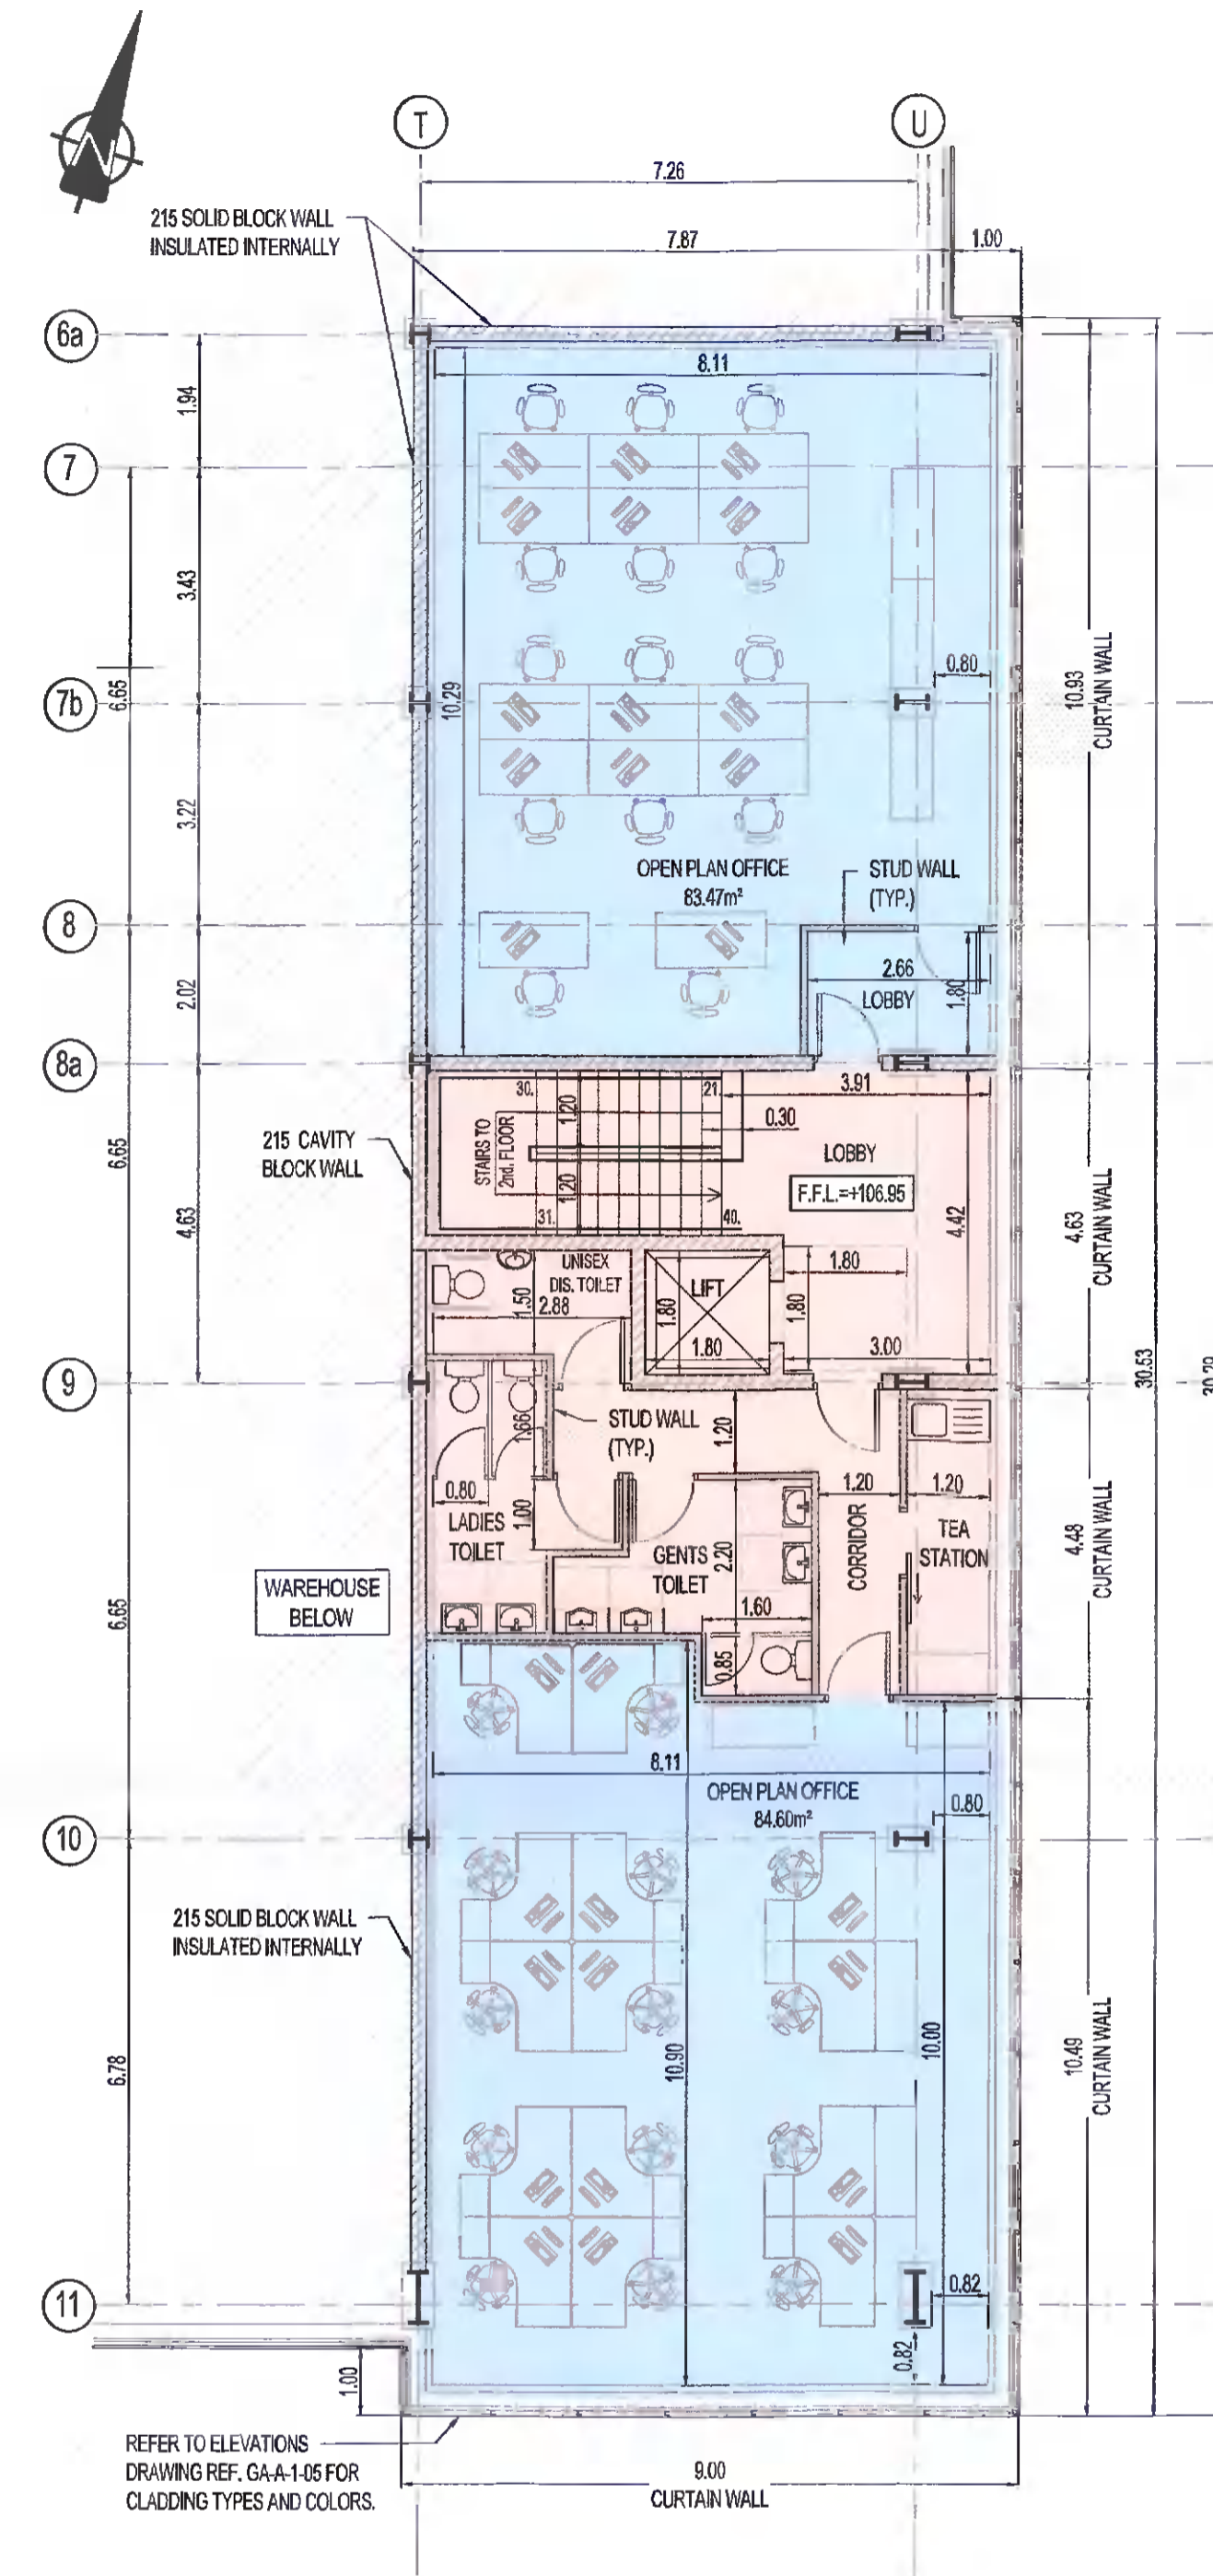

**ANCILLARY OFFICES - SECOND FLOOR PLAN**  
 SCALE 1:100

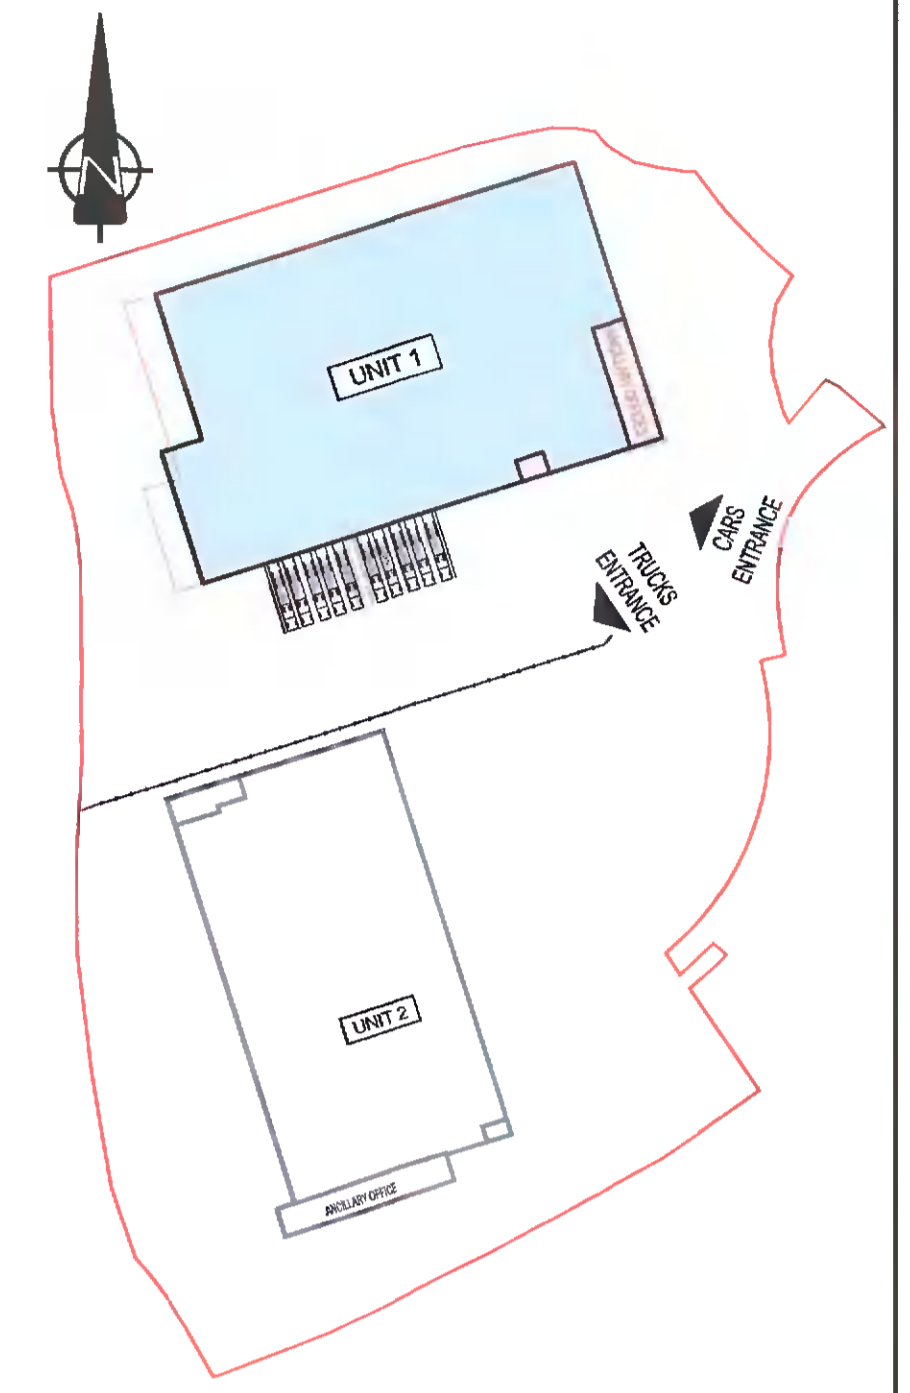

**KEY PLAN**  
 SCALE 1:1750

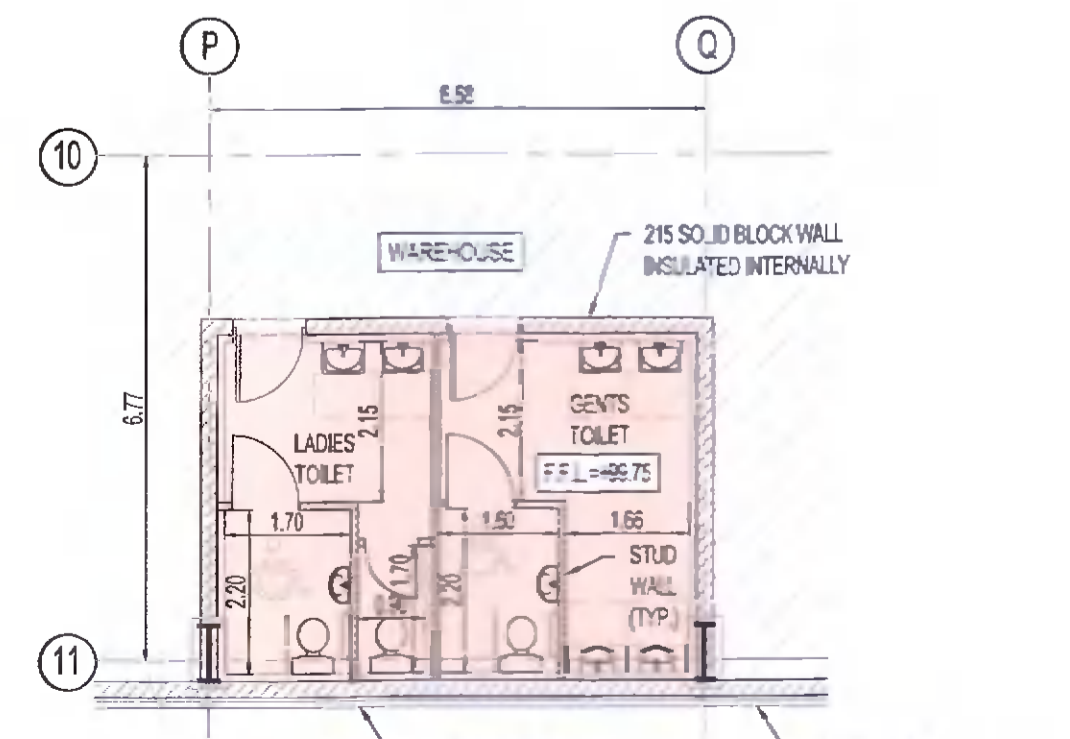

**TOILET BLOCK - GROUND FLOOR PLAN**  
 SCALE 1:100

PL2	24-01-2022	TX	PK	PK	ISSUED FOR PLANNING ADDITIONAL INFORMATION
PL2	03-03-2022	SS	PK	PK	ISSUED FOR PLANNING
Rev	Date	By	Chk	App	Revised
Drawing Title <b>PLANNING AI</b>					
Job No. <b>WAREHOUSE DEVELOPMENT AT BROWNSBARN, CITYWEST CAMPUS, DUBLIN 24</b>					
Drawing Title <b>UNIT 1 ANCILLARY OFFICE &amp; WAREHOUSE TOILET BLOCK FLOOR PLANS</b>					
Author/Client <b>Exeter Ireland Property IV B Limited</b>					
Consultant <b>KAVANAGH BURKE CONSULTING ENGINEERS</b>					
Tel. 01 - 450 0694 Unit G3, Calmount Pk. Fax. 01 - 426 4340 Ballymount, Email: pkavanagh@kavanaghburke.ie Dublin 12.					
Dr	TX	Checked	PK	Approved	PK
Scale	1:100 @A1	Date	JANUARY 2022		
Job No.	D1678	Drawing No.	GA-A-1-04	Rev.	PL3