



NOTES:


1. THIS DRAWING IS TO BE READ IN CONJUNCTION WITH ALL OTHER RELEVANT DRAWINGS & SPECIFICATIONS.
2. DO NOT SCALE, USE FIGURED DIMENSIONS ONLY.

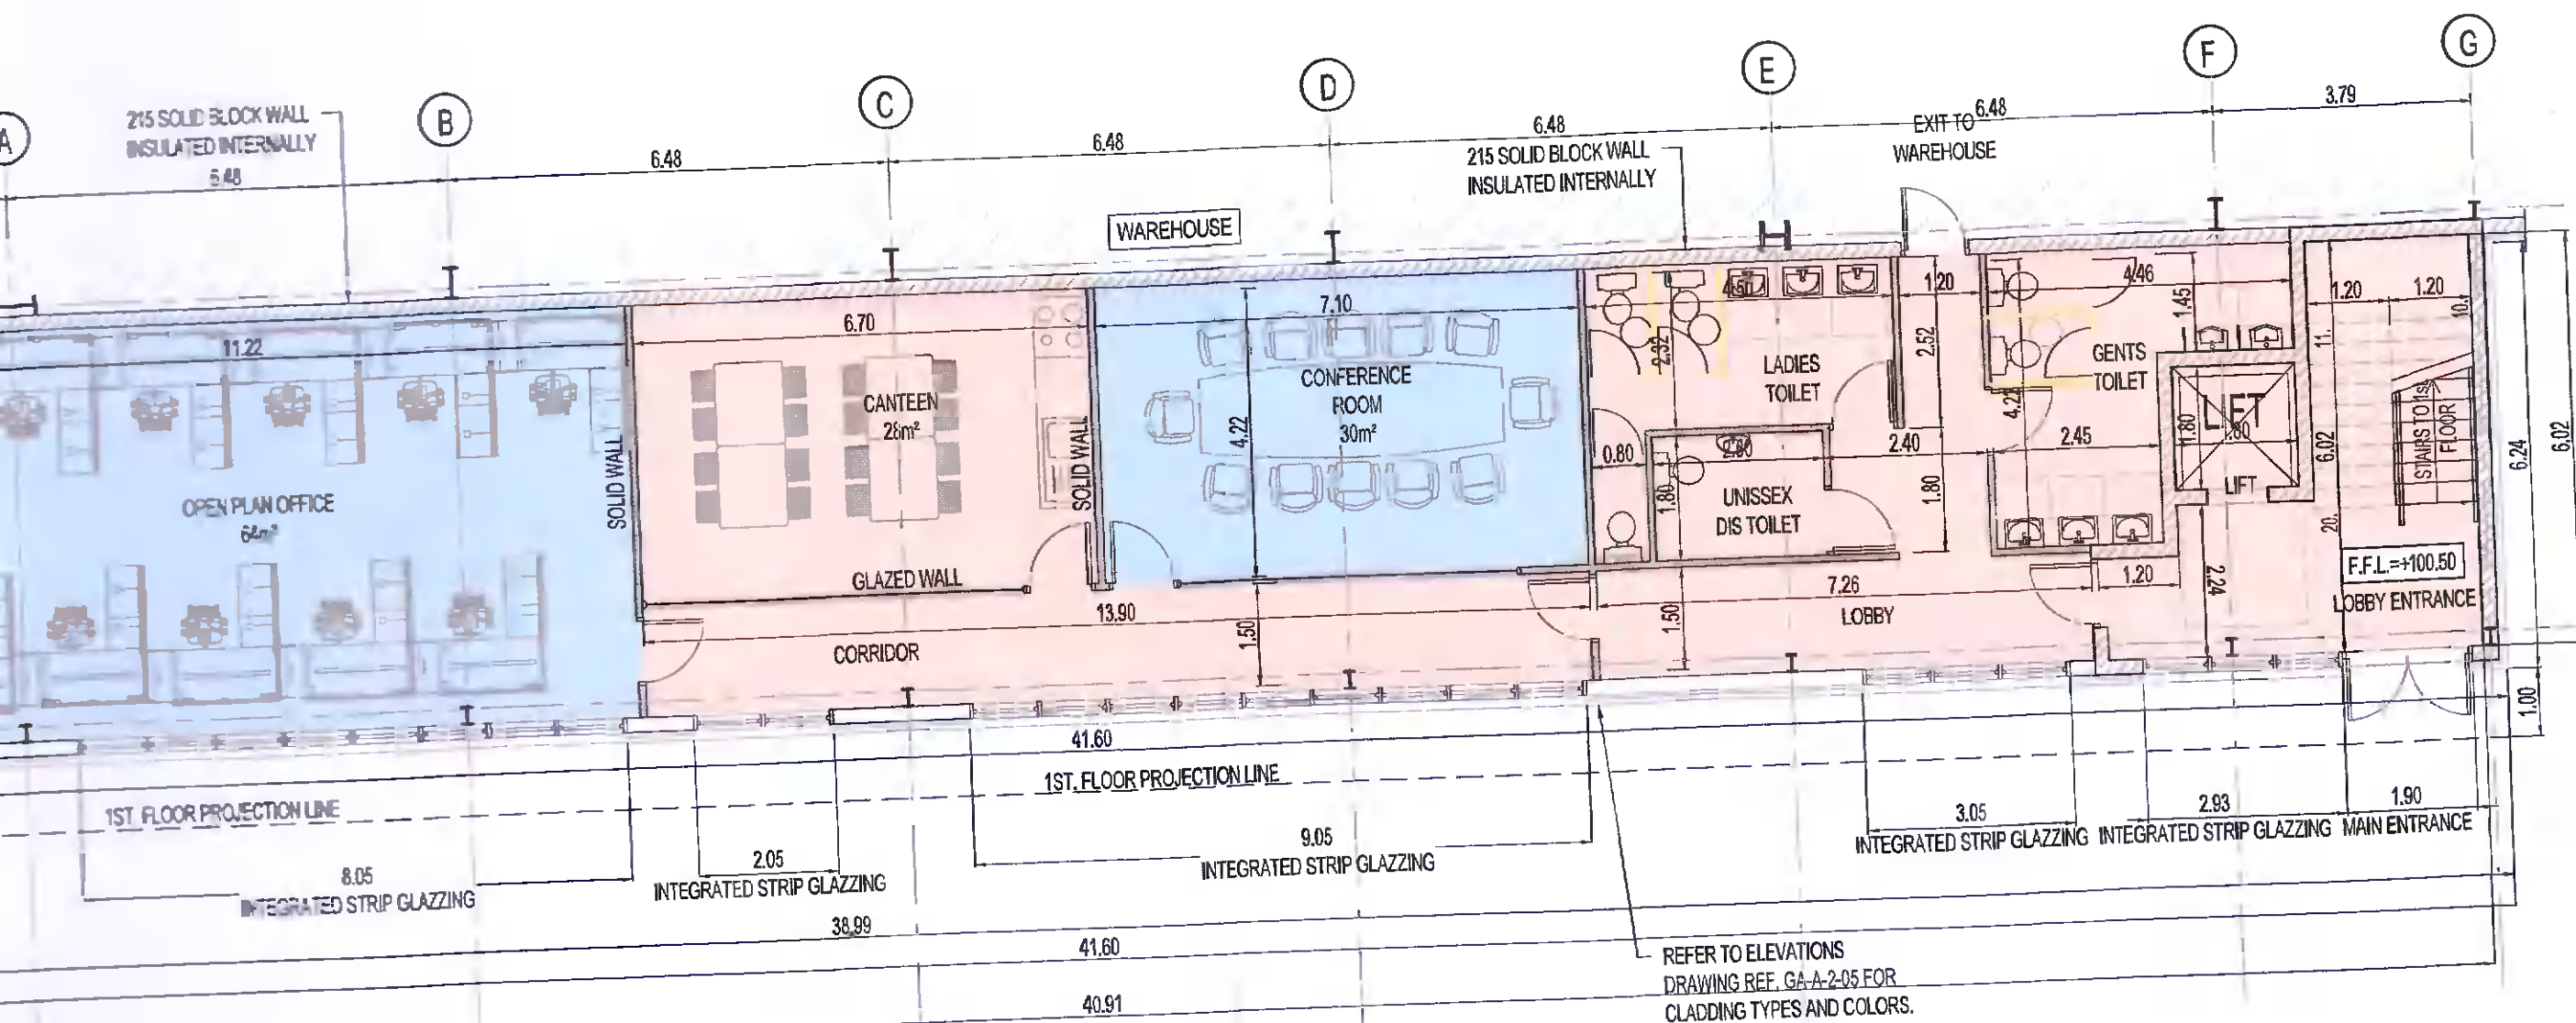


OFFICES - GROUND FLOOR PLAN

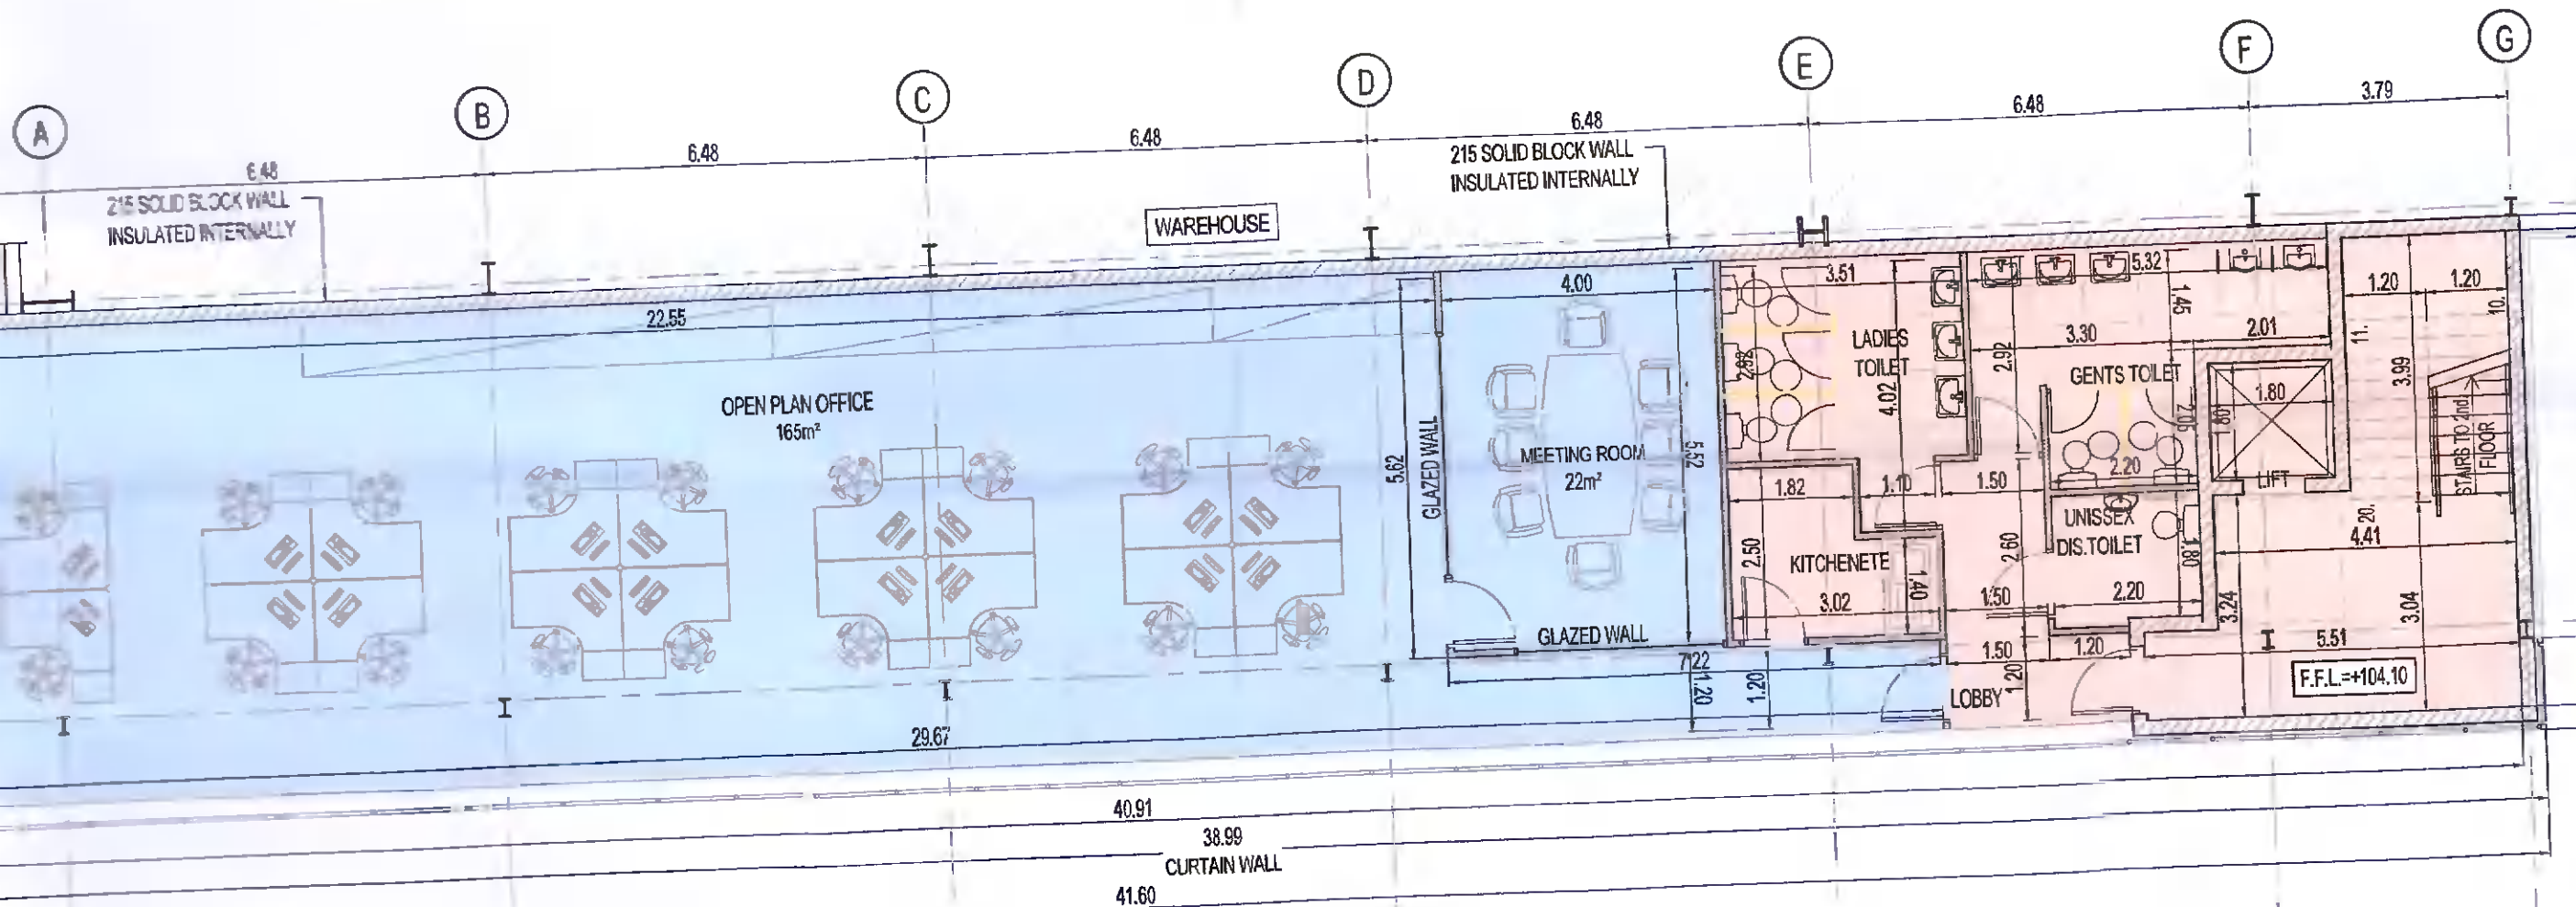


OFFICES - FIRST FLOOR PLAN

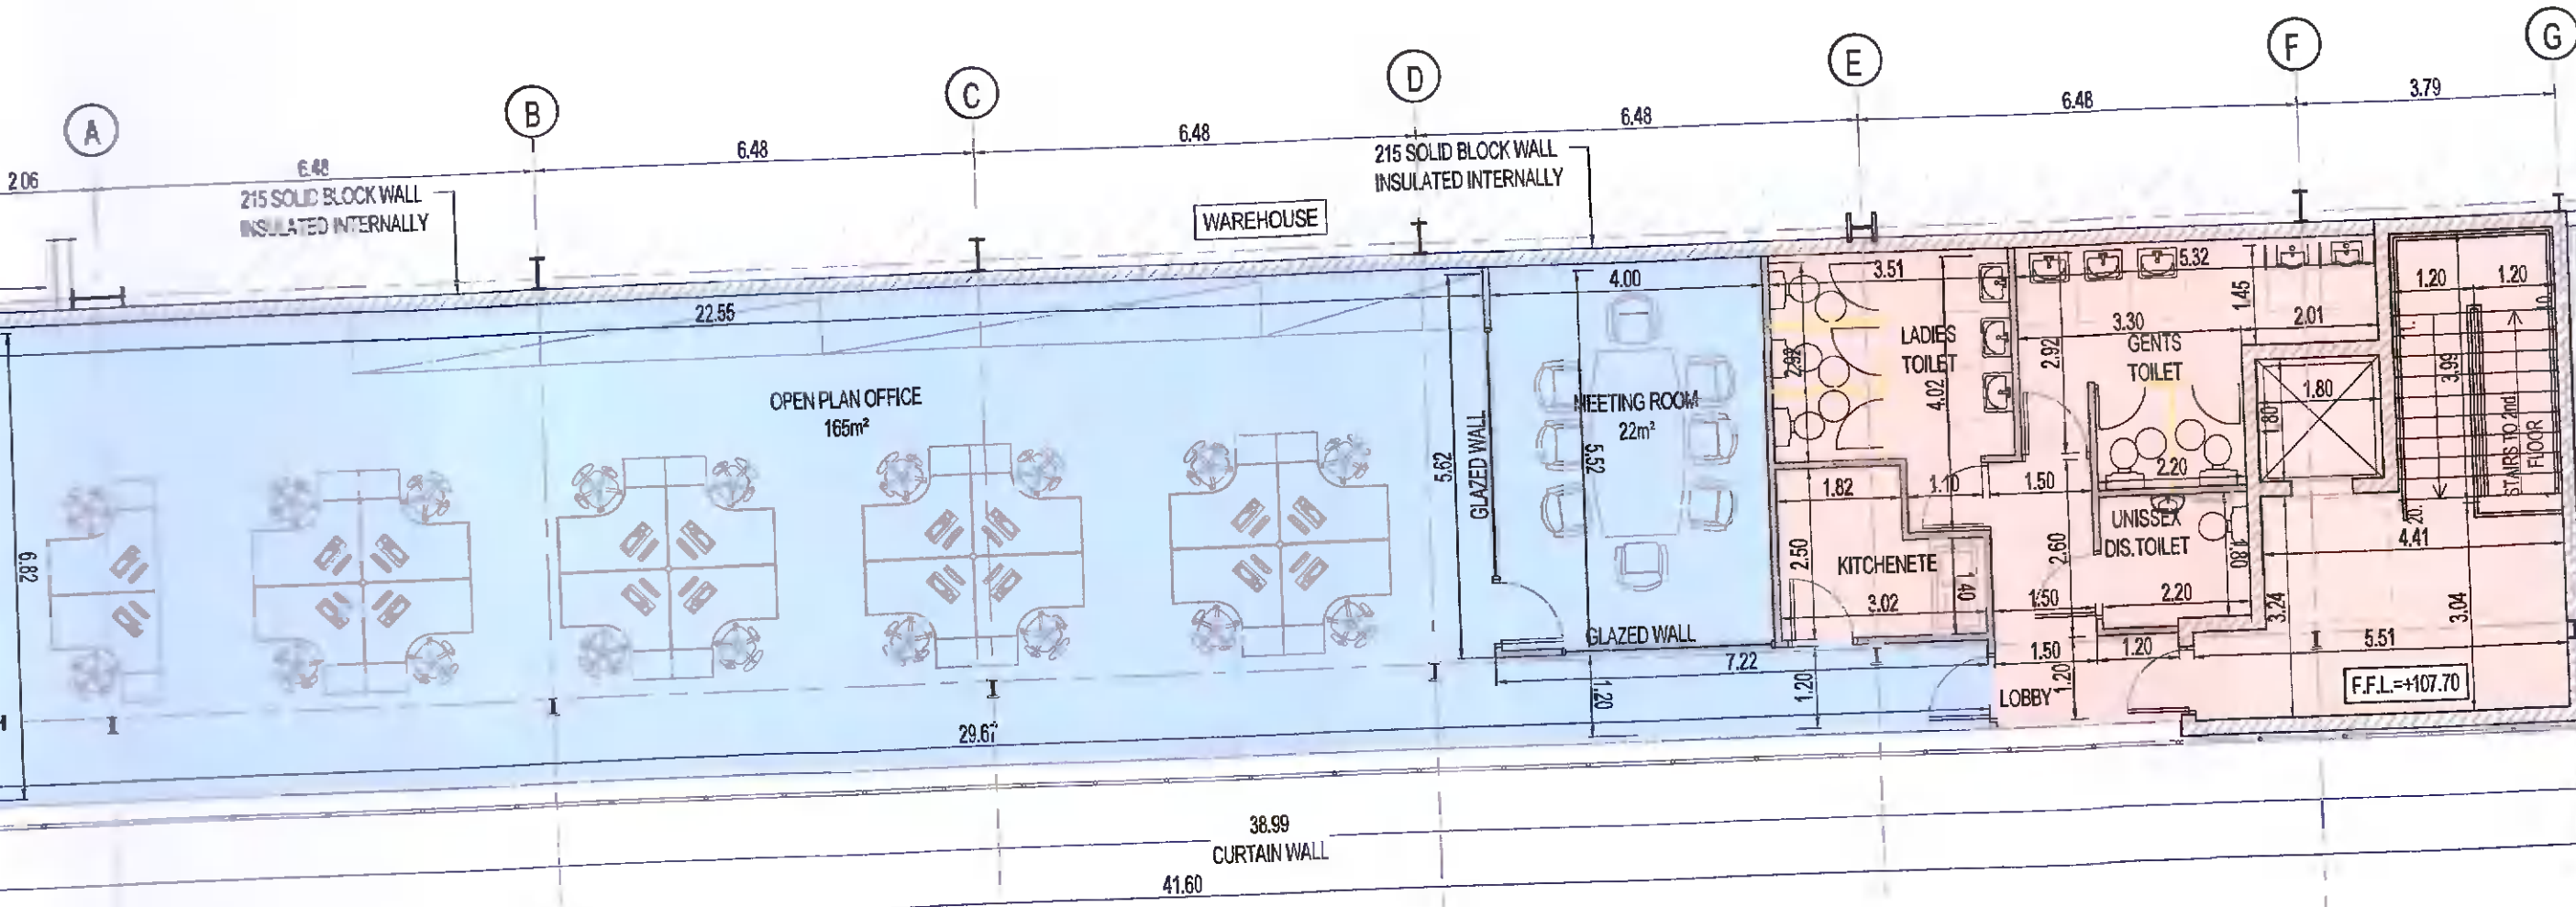


OFFICES - SECOND FLOOR PLAN

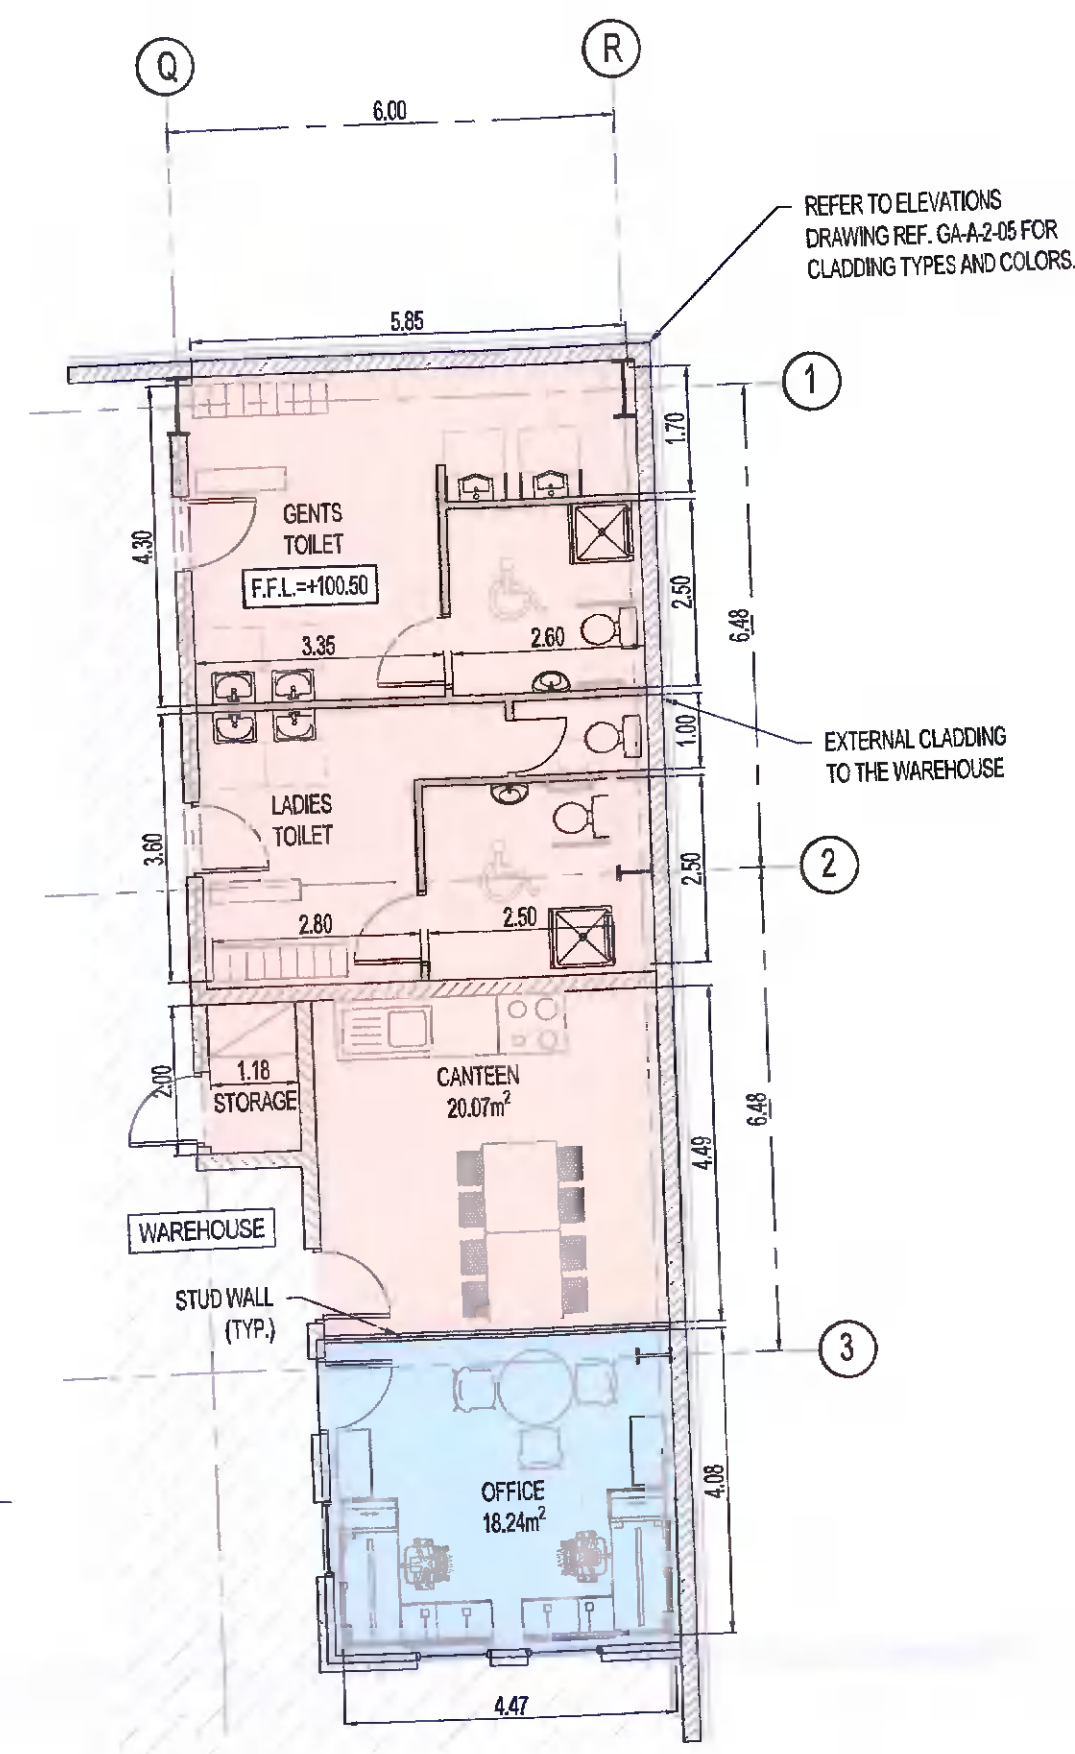

STAFF FACILITIES TOILET BLOCK - GROUND FLOOR PLAN
SCALE 1:100

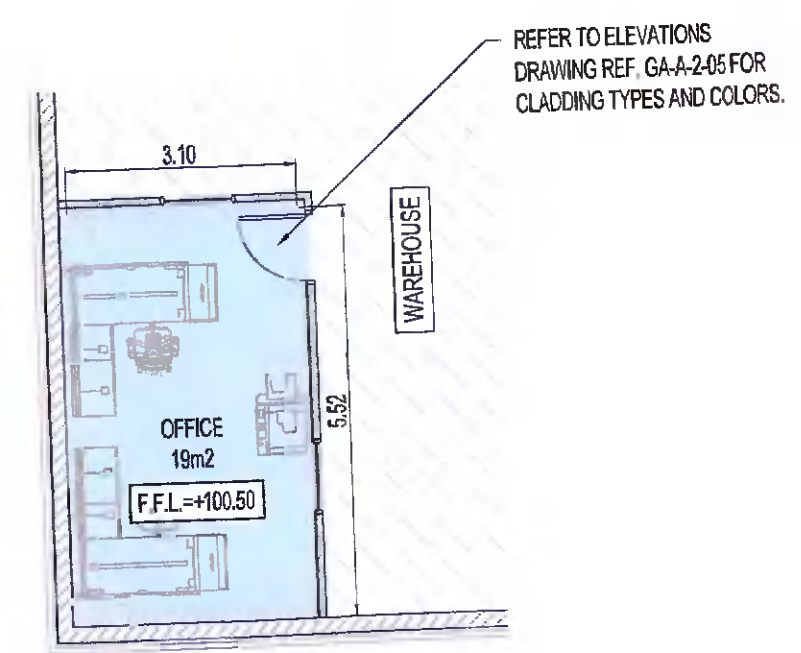

MODULAR OFFICE - GROUND FLOOR PLAN
SCALE 1:100

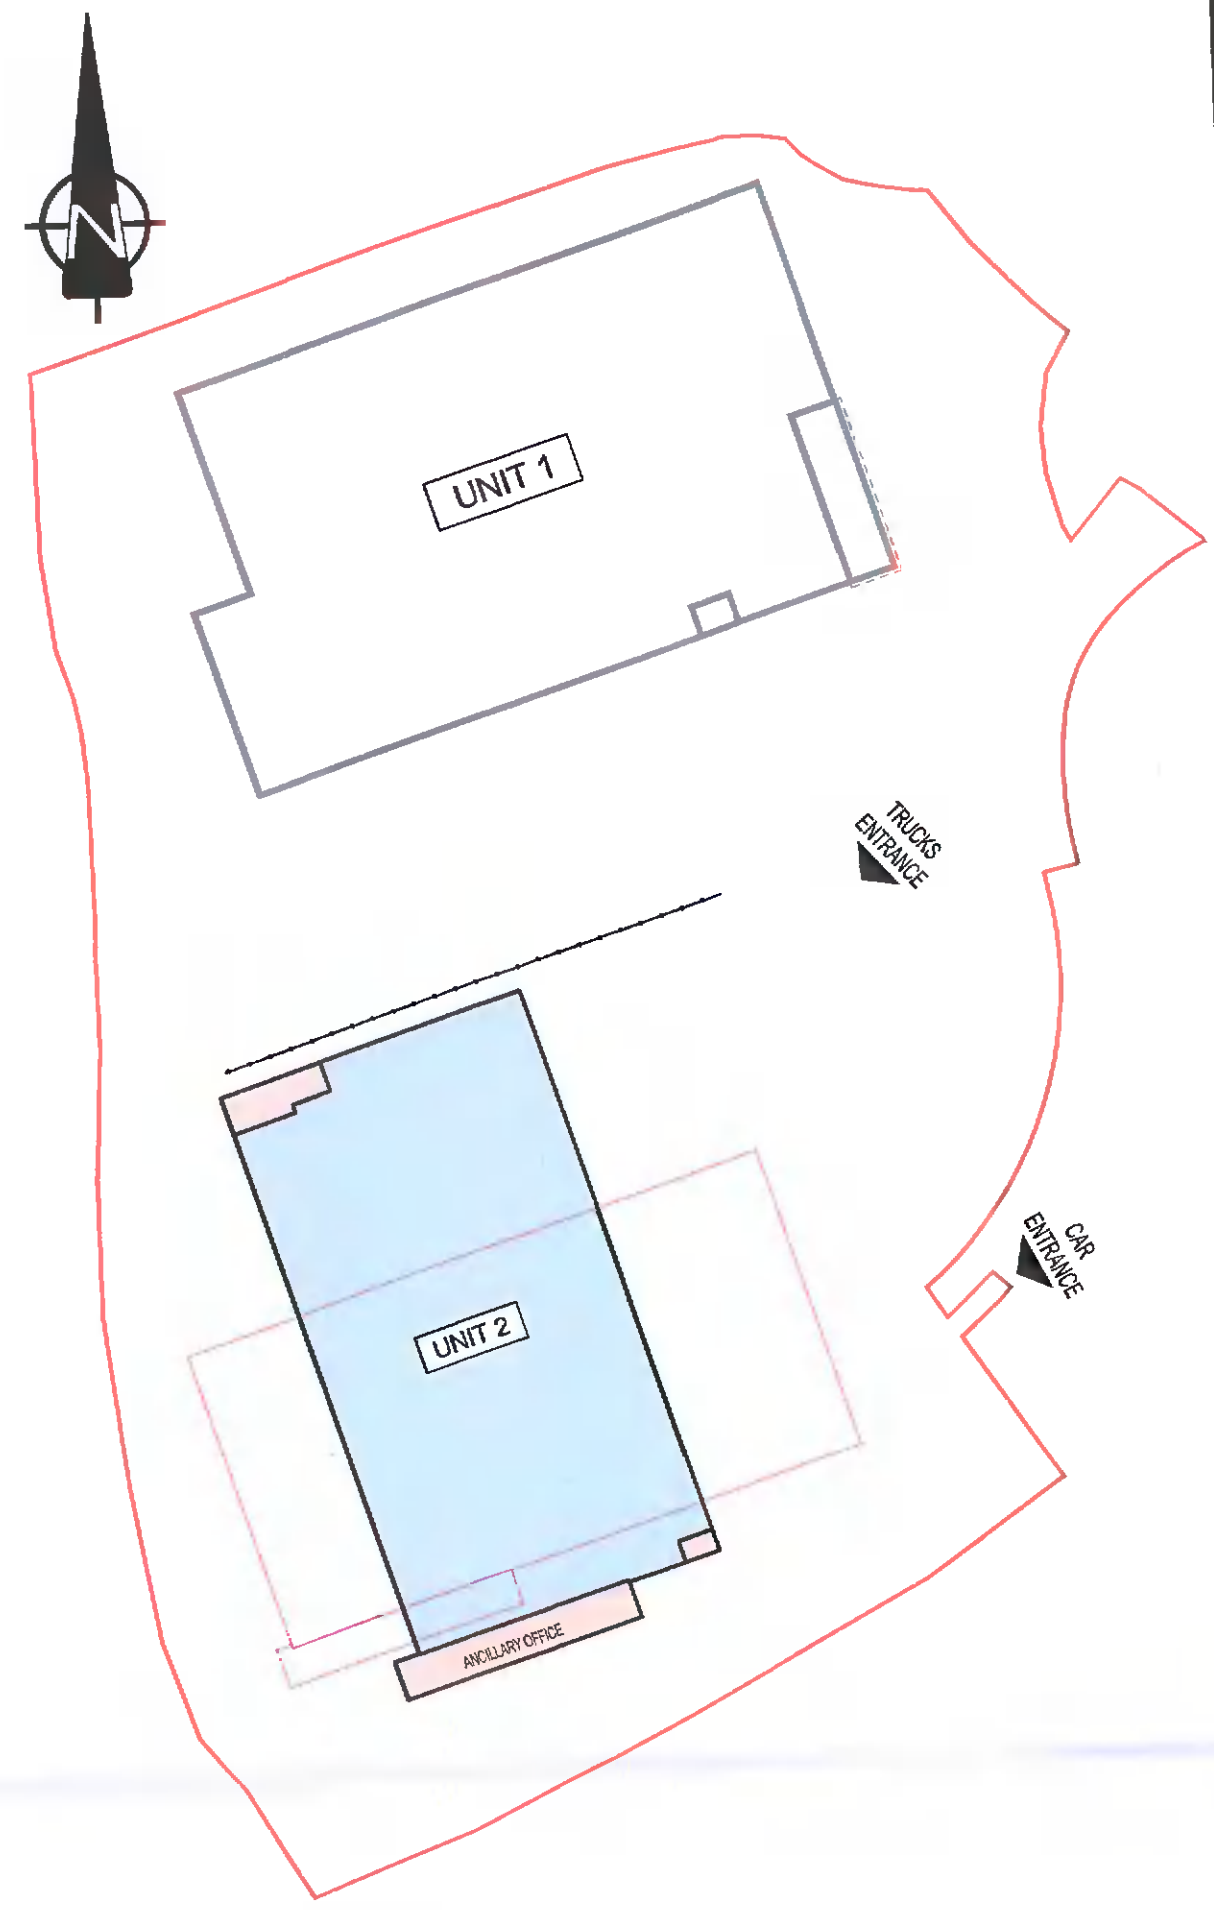

KEY PLAN
SCALE 1:1250

Rev	Date	By	CHK	App.	Position
PL8	05-02-2022	TK	PK	PK	ISSUED FOR PLANNING ADDITIONAL INFORMATION
PL7	31-05-2021	TK	PK	PK	ISSUED FOR PLANNING

Drawing State: **PLANNING AI**

Job Title: **WAREHOUSE DEVELOPMENT AT BROWNSBARN, CITYWEST CAMPUS, DUBLIN 24**

Unit 2
ANCILLARY OFFICE & WAREHOUSE TOILET BLOCK FLOOR PLANS

Author/Client: **Exeter Ireland Property IV B Limited**

KAVANAGH BURKE
CONSULTING ENGINEERS

Tel: 01 - 450 0894 Unit G3, Calmount Pk.
Fax: 01 - 426 4340 Ballymount,
Email: pkavanagh@kavanaghburke.ie Dublin 12.

Des: TK	Checked: PK	Approved: PK
Scale: 1:100	Date: FEBRUARY 2021	
Job No: D1678	Drawing No: GA-A-2-04	Rev: PL8