

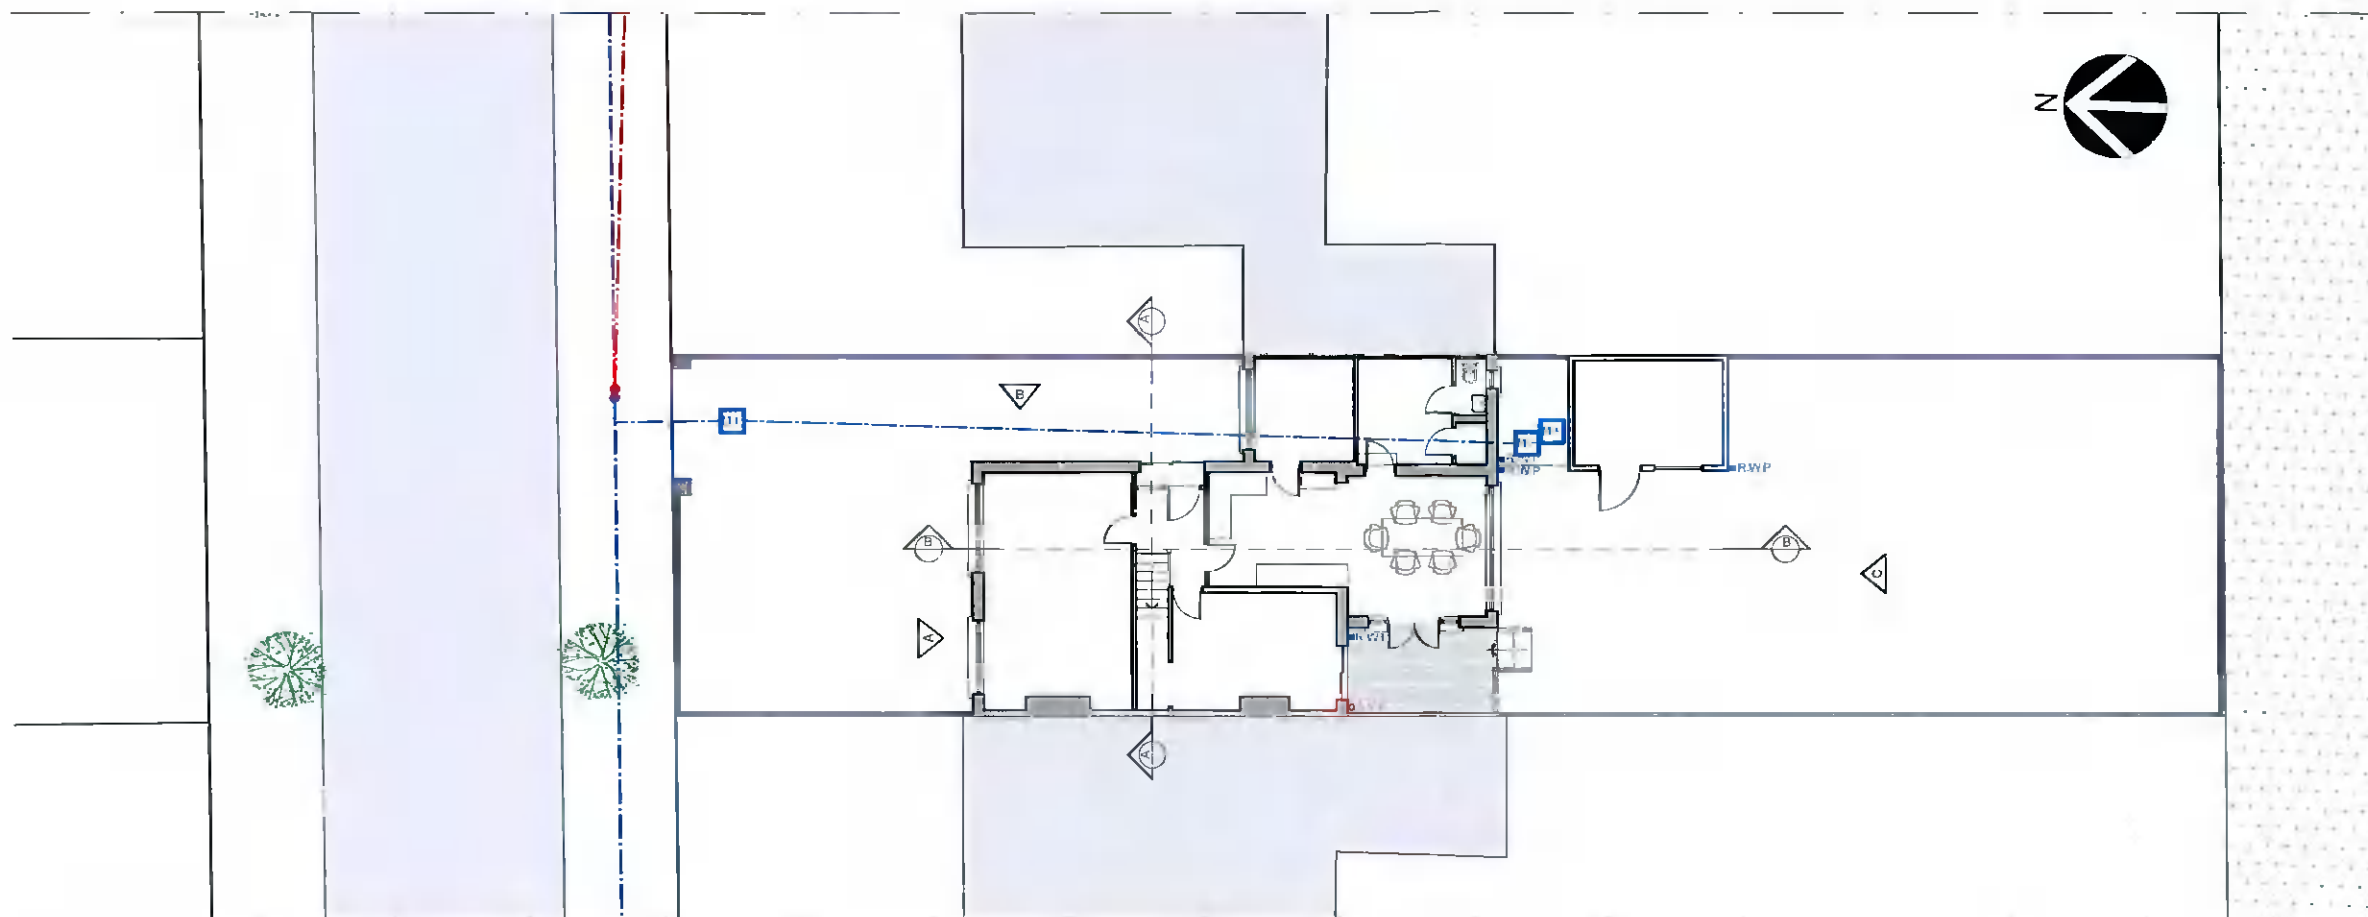
LEGEND

- EXISTING WALLS
- PROPOSED WALLS
- S.V.P
- R.W.P RAIN WATER PIPE
- G.T GULLY TRAP
- A.J ARMSTRONG JUNCTION
- M.H MAN HOLE
- F.O.U.L. W.A.T.E.R. FOUL WATER
- S.U.R.F.A.C.E. W.A.T.E.R. SURFACE WATER
- G.L. GROUND LEVEL
- F.R.L. FLAT ROOF LEVEL
- G.F.L. GROUND FLOOR LEVEL
- F.F.L. FIRST FLOOR LEVEL
- S.F.L. SECOND FLOOR LEVEL
- R.L. ROOF LEVEL
- B.F.L. BACKYARD FLOOR LEVEL



REV	DATE	DESCRIPTION

© This drawing is copyright. Figured dimensions only to be taken from this drawing. All dimensions to be checked on site. Module Design Ltd to be informed immediately of any discrepancies before work proceeds.

PROJECT NO. <b>20109</b>	SCALE(S) <b>1:200</b>	REV. <b>01</b>
-----------------------------	--------------------------	-------------------



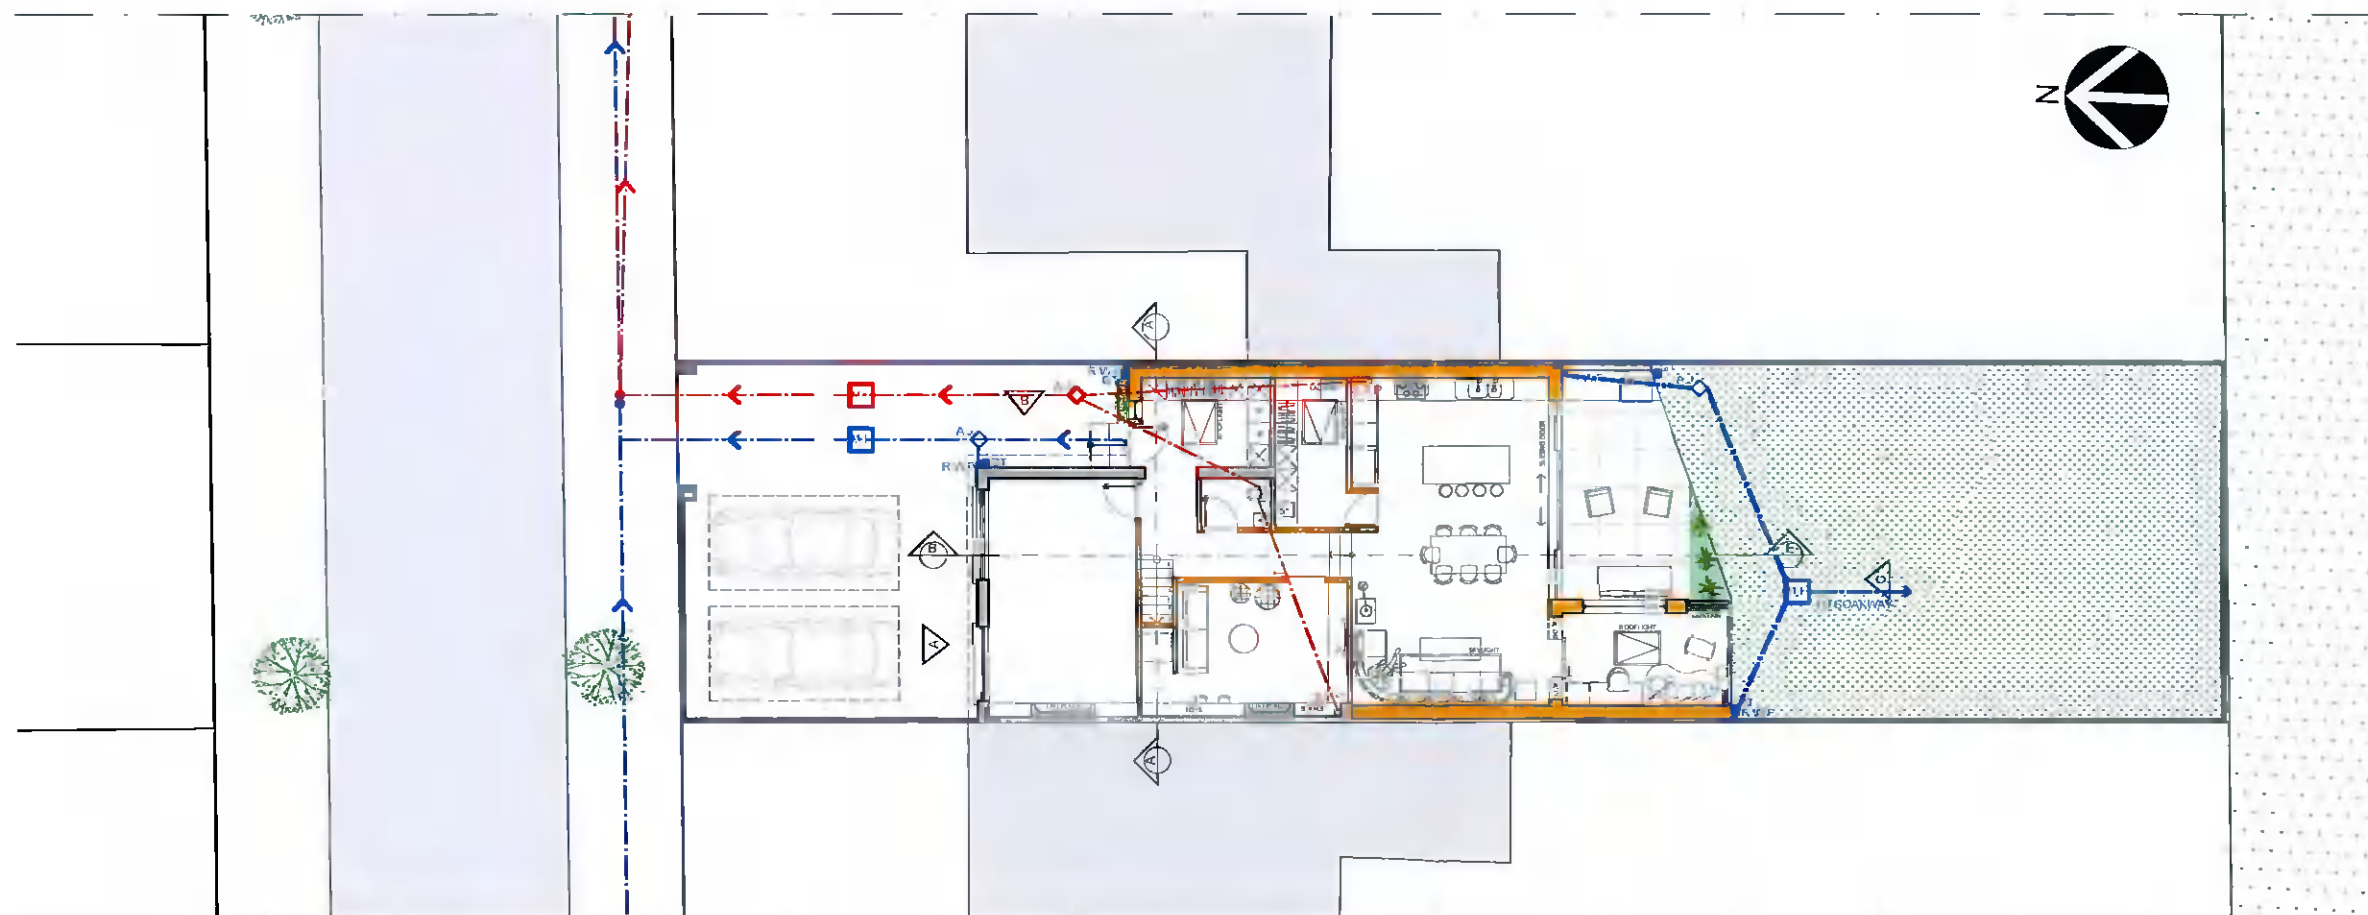**O1** EXISTING DRAINAGE PLAN  
SCALE: 1:200



**O2** PROPOSED DRAINAGE PLAN  
SCALE: 1:200

MAP SHEETS:  
3194-23  
3260-03

INCLUDES ORDNANCE SURVEY IRELAND DATA  
REPRODUCED UNDER OSI LICENSE NUMBER 10/21  
UNAUTHORISED REPRODUCTION INFRINGES ORDNANCE  
SURVEY IRELAND AND GOVERNMENT OF IRELAND  
COPYRIGHT ORDNANCE SURVEY IRELAND 2021