


NOTES

- DO NOT SCALE FROM THIS DRAWING. USE FIGURED DIMENSIONS ONLY.
- THIS DRAWING IS TO BE READ IN COLOUR AND IN CONJUNCTION WITH ALL OTHER RELEVANT ARCHITECTURAL AND ENGINEERING DRAWINGS.
- FINAL LOCATIONS OF LIGHT FITTINGS TO BE AGREED WITH ARCHITECT PRIOR TO INSTALLATION.

EXTERNAL LIGHTING LEGEND

- OA IN-GROUND RECESSED LED UPLIGHT FITTING. IP57 AND IK10 RATED.
- OB WALL MOUNTED EXTERNAL LED UP/DOWNLIGHT FITTING. IP54 RATED.
- OC WALL-MOUNTED LED FLOODLIGHT FITTING MOUNTED AT 5m ABOVE FINISHED GROUND LEVEL. 5 DEGREE TILT TO REDUCE OVERSPILL TO HOUSES ALONG HILLCREST GROVE TO THE NORTH-WEST.
- OD WALL MOUNTED EXTERNAL BULKHEAD LED LUMINAIRE WITH EYE-LID ATTACHMENT.
- PC WALL MOUNTED PHOTOCELL TO CONTROL EXTERNAL LIGHTING MOUNTED ON NORTH-WESTERN ELEVATION.
- T DENOTES THAT THE LIGHTING CIRCUIT IS CONTROLLED BY THE ABOVE PHOTOCELL AND DEDICATED TIMECLOCK MOUNTED IN LANDLORD SWITCHBOARD.

FALSE COLUR RENDERING OF REAR DELIVERY YARD

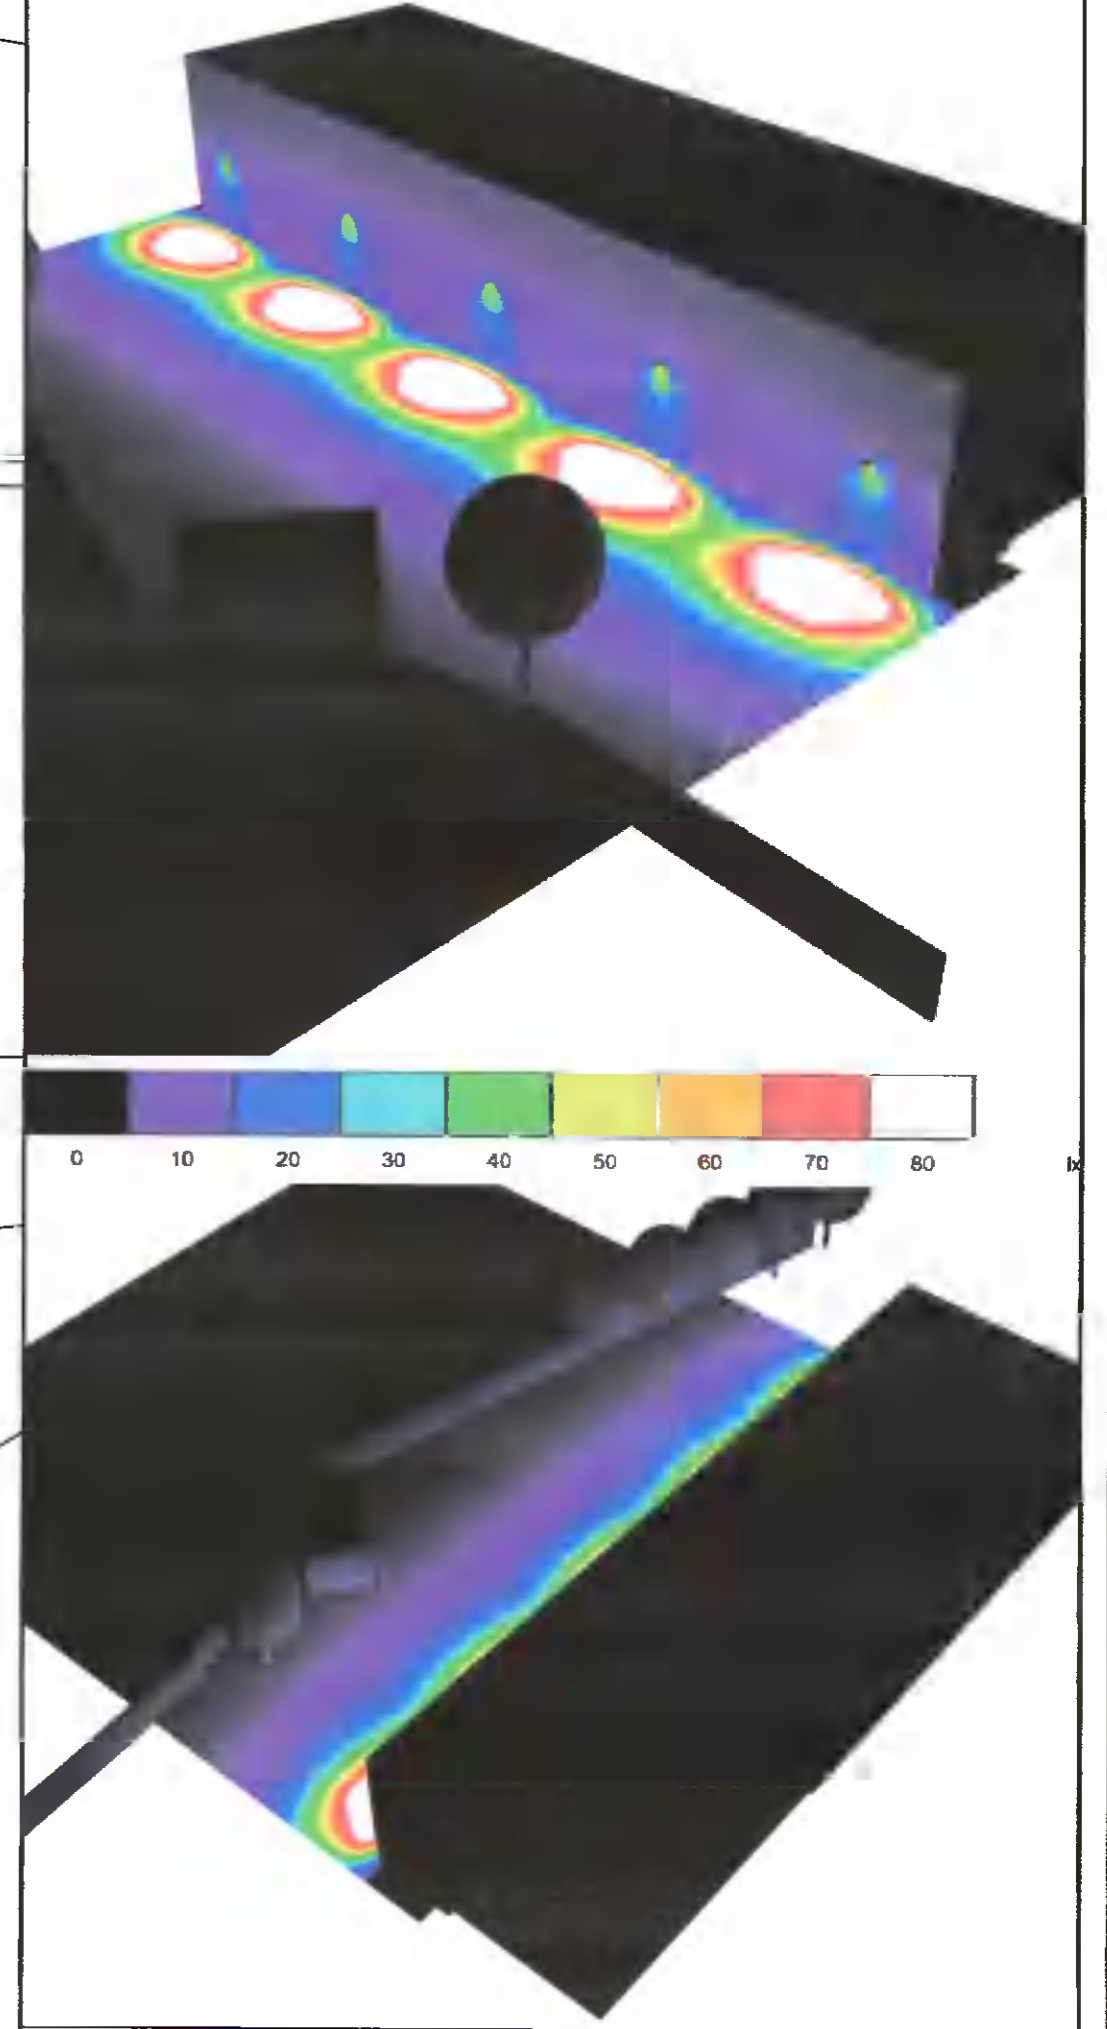

ISSUE	DESCRIPTION	DRN	ORIG	APP	DATE
PL2	ISSUED FOR PLANNING	KP	KP	DC	11/01/2022
PL1	ISSUED FOR PLANNING	KP	KP	DC	20/05/2021

CLIENT **SAVILLE IM**

MANDE CONSULTING ENGINEERS
 Unit 4 Oak Close
 Western Business Park
 Dublin 12, D12 R8C6
 T: (01) 4508485
 W: www.mande.ie
 E: info@mande.ie

PROJECT
**GROUND FLOOR RETAIL EXTENSION
 LUCAN SHOPPING CENTRE**

TITLE
**SITE PLAN
 EXTERNAL LIGHTING LAYOUT**

PROJECT No:	21020	DATE:	APRIL 2021
A1 SCALE:	1:100	DRG No.:	LUSC-MAE-XX-DR-E-6000

THIS DRAWING IS COPYRIGHTED. ALL RIGHTS RESERVED. NO PART OF THIS DRAWING MAY BE REPRODUCED, STORED IN A RETRIEVAL SYSTEM OR TRANSMITTED IN ANY FORM OR BY ANY MEANS WITHOUT THE PRIOR WRITTEN PERMISSION FROM MANDE CONSULTING ENGINEERS LTD.