


CONSULTANTS  
 CIVIL / STRUCTURAL  
 MEP ENGINEER  
 LANDSCAPE ARCH  
 ENV. CONSULTANT  
 FIRE CONSULTANT  
 QUANTITY SURVEYOR  
 MAIN CONTRACTOR

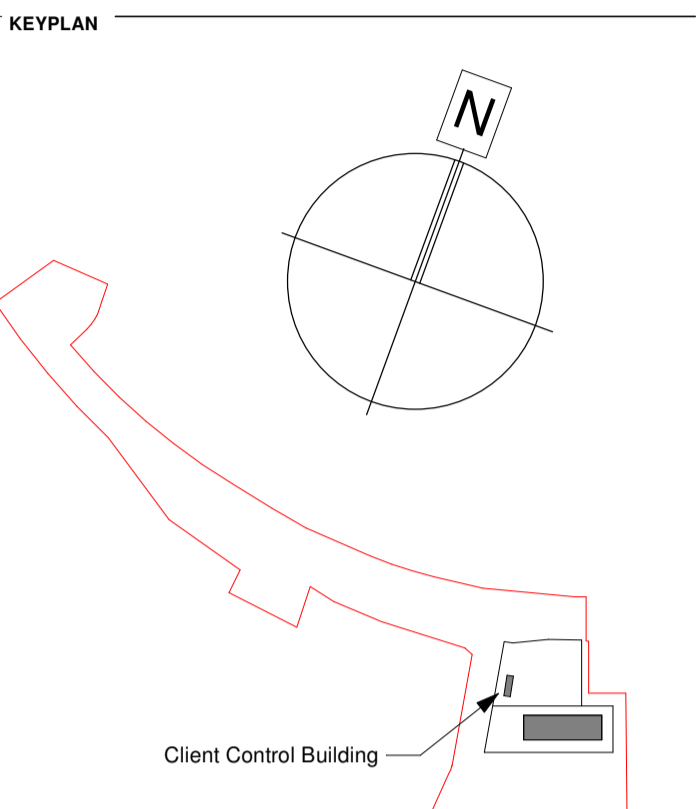

REVISIONS

REV NO.	DATE	CHK	APR	DESCRIPTION
P1	01/10/21	SL	MK	Issued For Review
P2	18/11/21	SL	MK	Issued For Review
P3	24/01/22	SL	MK	Issued For Review



**KAVANAGH TUIE ARCHITECTS**

TERMINUS MILLS CLONSKEAGH ROAD D06 XD37 IRELAND  
 T: +353 1 2188500 MAIL@KAVANAGHTUIE.IE

FILE NAME  
**CCB-KT-ZZ-ZZ-DR-A-1007-P3**

PROJECT:  
**Kilcarbery 110kV Substation & MV Client Compound**


PROJECT NO. STATUS:  
**CCB**

TITLE:  
**Client Control Building**


DATE: 13/10/21 SCALE: As indicated

DRAWN BY: SL APPR BY: MK

DWG NO. 1007 REV. P3

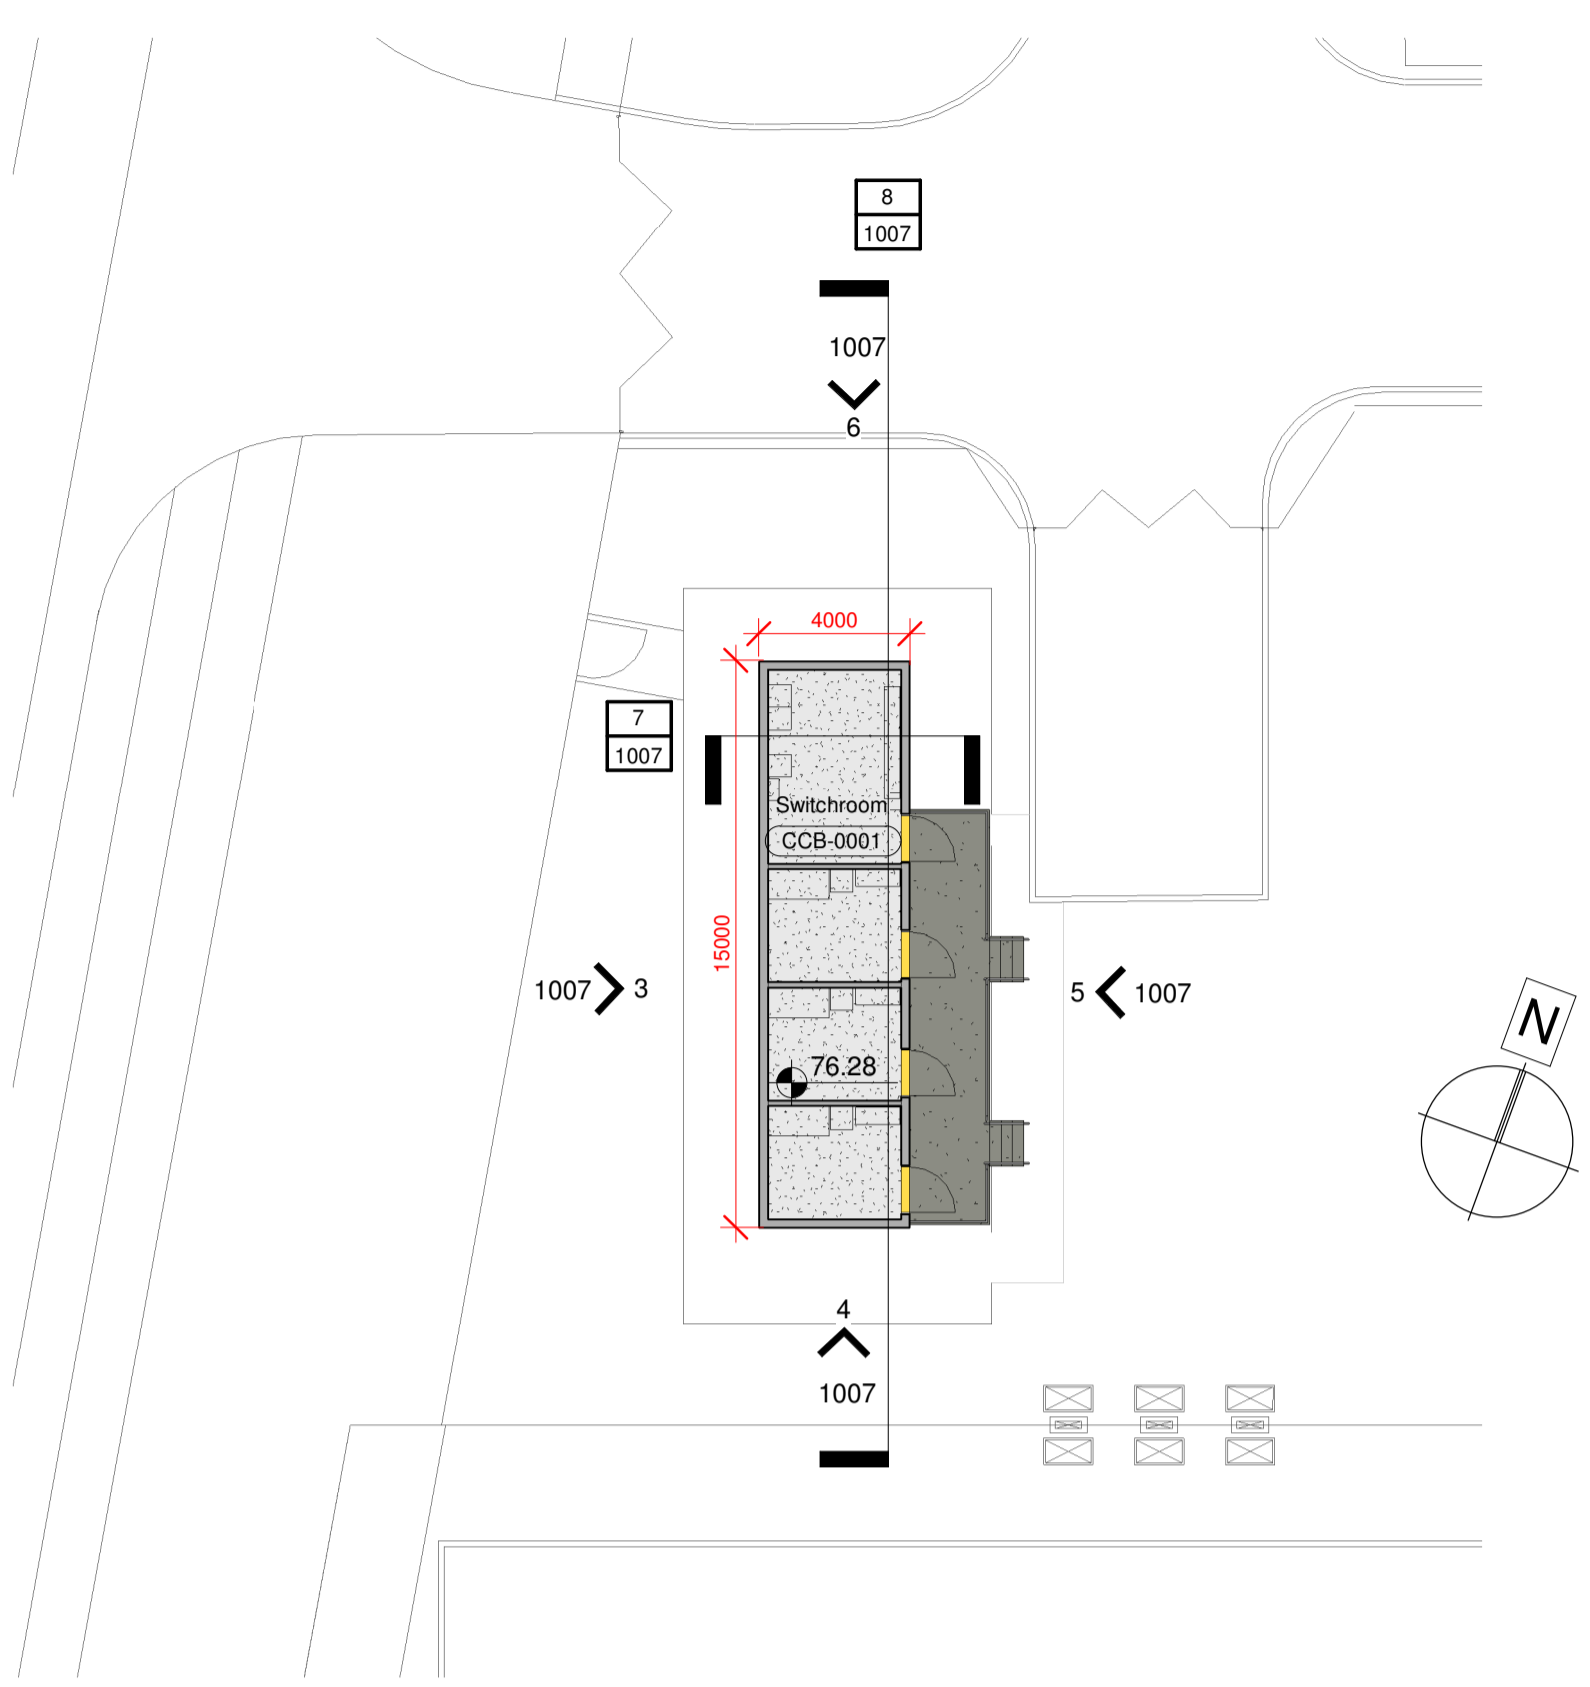


**1 1007 Ground Floor Level**  
 1 : 200

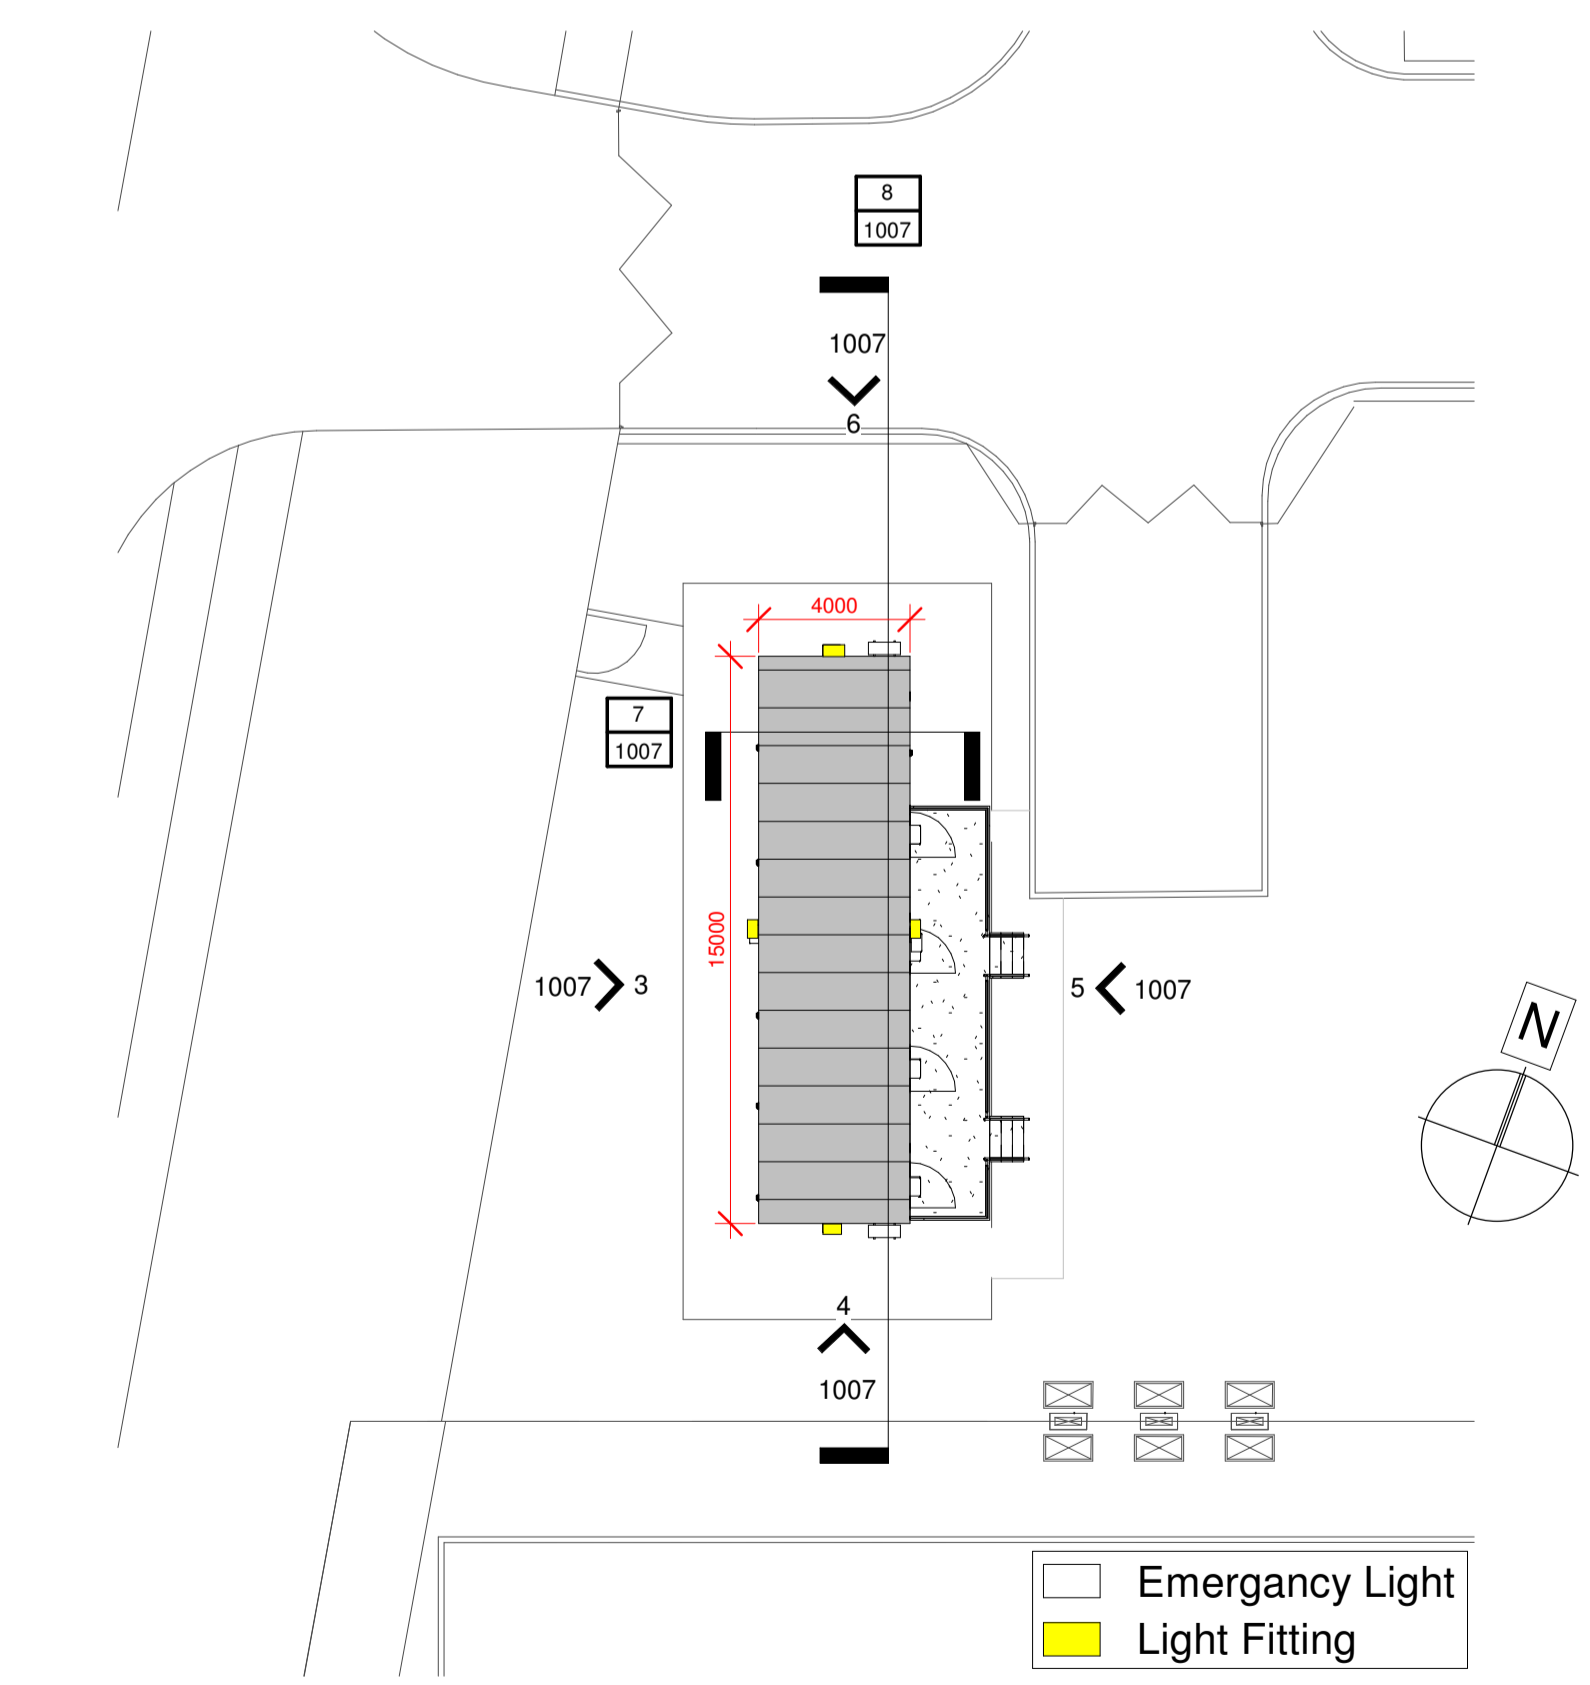


**2 1007 Roof level**  
 1 : 200


Emergency Light  
 Light Fitting

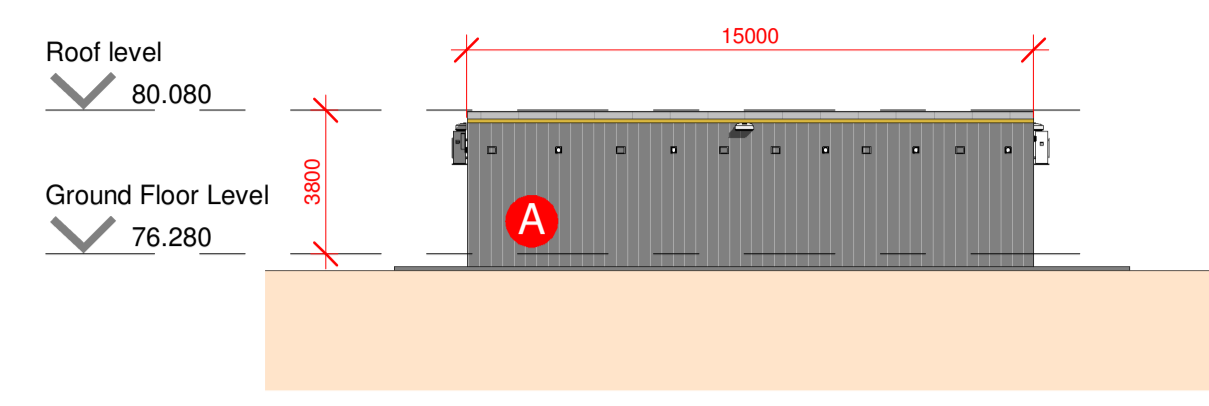


**3 1007 West Elevation**  
 1 : 200

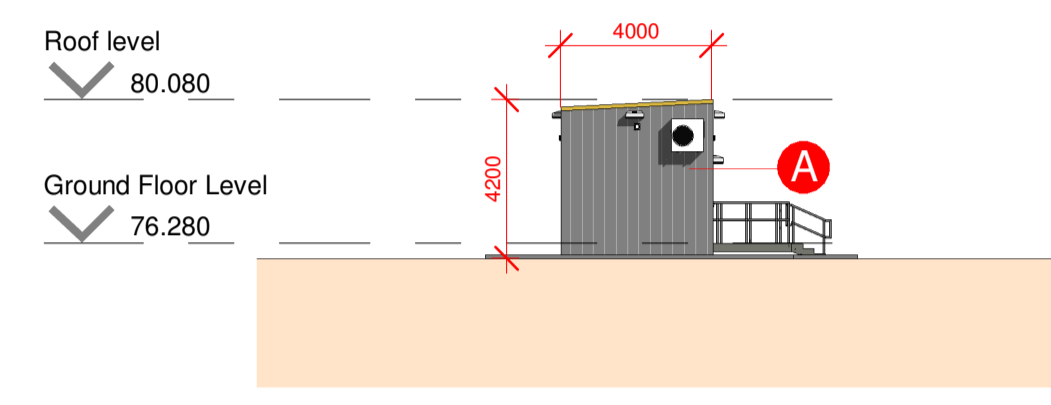

**4 1007 South Elevation**  
 1 : 200

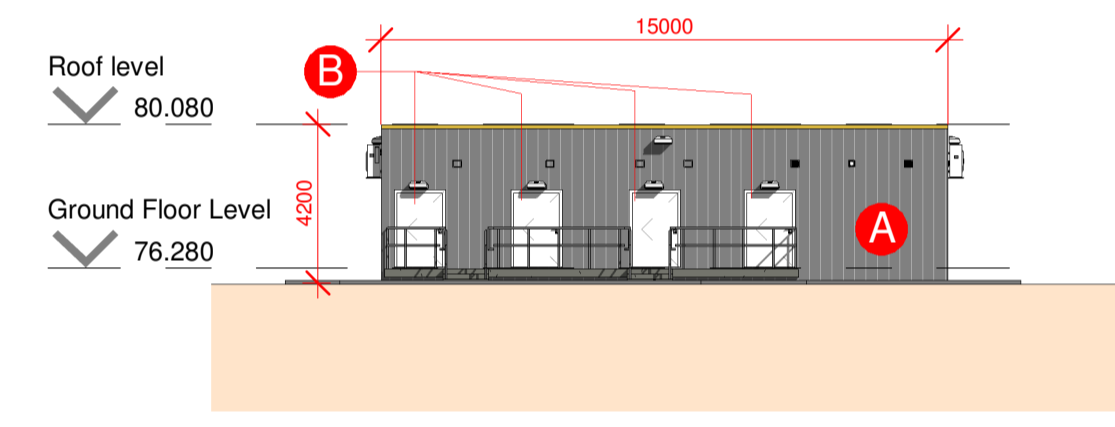


**5 1007 East Elevation**  
 1 : 200

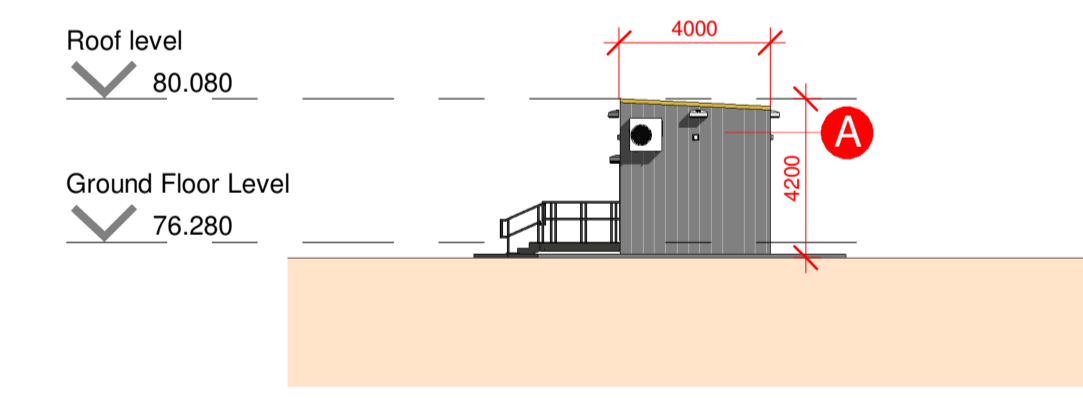


**6 1007 North Elevation**  
 1 : 200

- A** Powder Coated Profiled Metal Cladding Panels - Gull Grey or Similar
- B** Service/Escape Door - Colour to Match Cladding
- C** 50% Open Area Weathered Louvre - Colour to Match Cladding

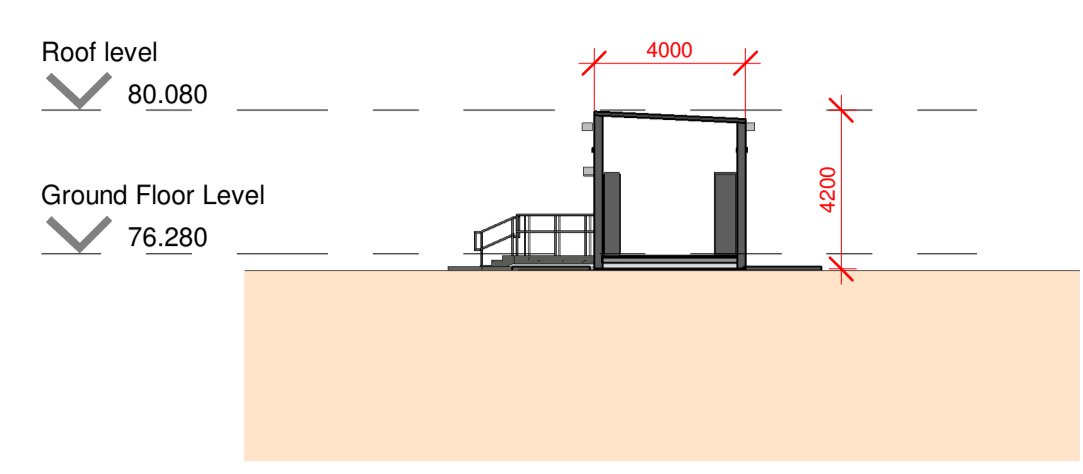

**7 1007 Section AA**  
 1 : 200

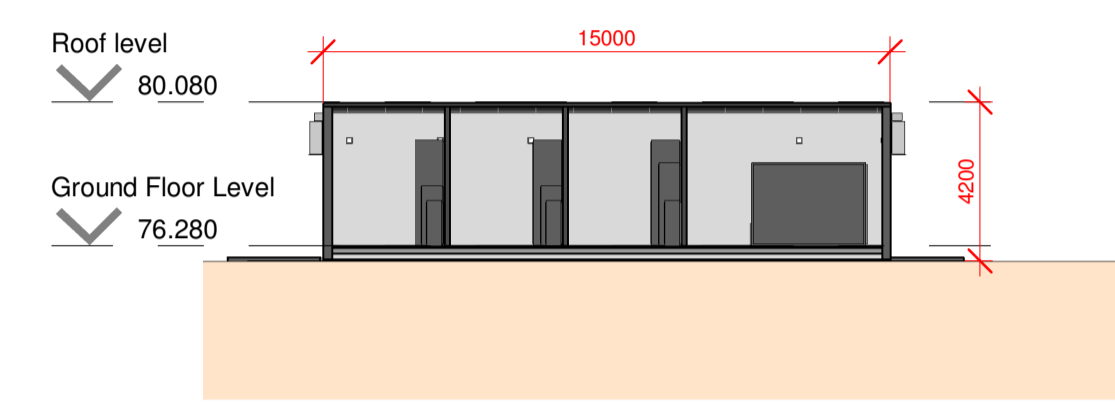

**8 1007 Section BB**  
 1 : 200