


ALL DIMENSIONS ARE IN mm UNLESS NOTED OTHERWISE

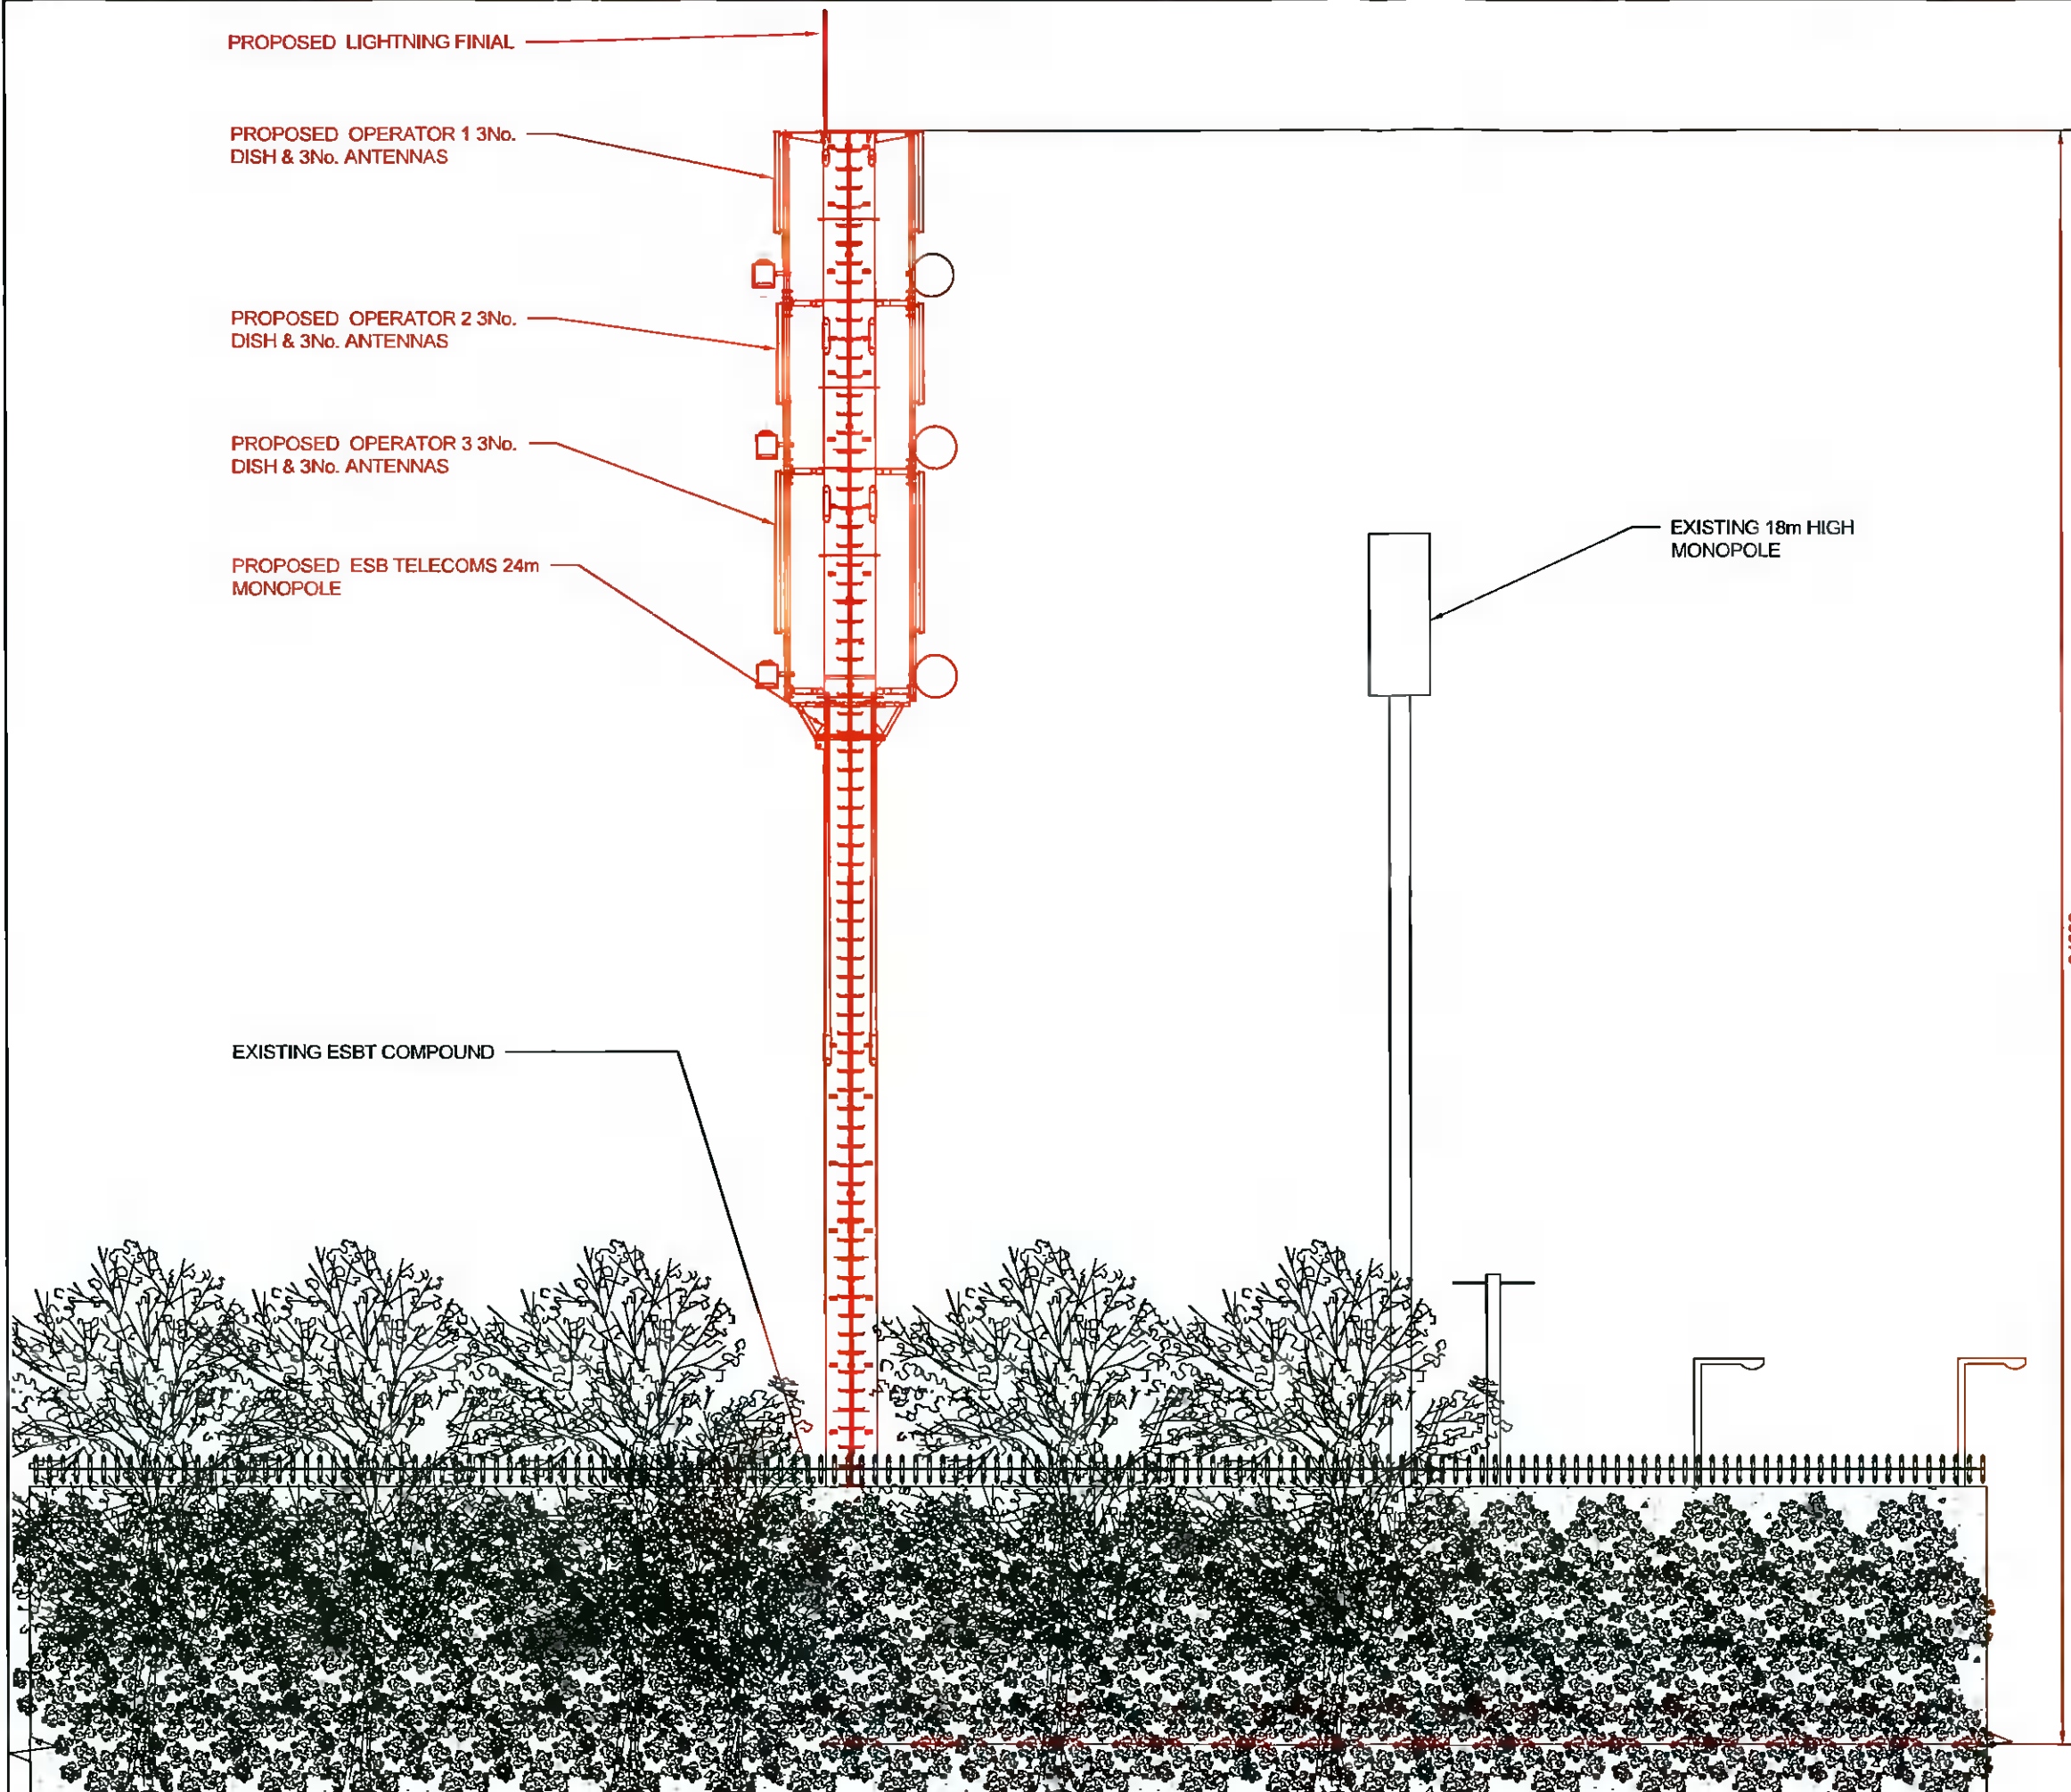

PROPOSED LIGHTNING FINIAL

PROPOSED OPERATOR 1 3No. DISH & 3No. ANTENNAS

PROPOSED OPERATOR 2 3No. DISH & 3No. ANTENNAS

PROPOSED OPERATOR 3 3No. DISH & 3No. ANTENNAS

PROPOSED ESB TELECOMS 24m MONOPOLE

EXISTING 18m HIGH MONOPOLE

EXISTING ESBT COMPOUND

24000

WEST ELEVATION  
1:100

1  
103

1.0	PLANNING DRAWING	NB	ML	RM	06/01/2022
Rev	Modification	By	Ch	Ap	Date

THIS DRAWING IS THE PROPERTY OF ALLIED CONSULTANT ENGINEERING LTD. THE DRAWING CONTAINS DATA WHICH IS CONFIDENTIAL AND MAY ONLY BE USED FOR PURPOSES EXPRESSLY AGREED WITH ALLIED CONSULTANT ENGINEERING LTD. YOU MAY NOT USE, REUSE, TRANSMIT, PUBLISH OR EXPORT ALL OR PART OF THE DRAWING OR DATA IN ANY MANNER FOR ANY OTHER PURPOSE WITHOUT THE WRITTEN PERMISSION OF ALLIED CONSULTANT ENGINEERING LTD.



Site Name

PALMERSTOWN 38kV SUBSTATION

Site Address / Contact Details

KENNELSFORT ROAD UPPER  
PALMERSTOWN  
DUBLIN 20

Drawing Title: WEST ELEVATION

Purpose of Issue: PLANNING DRAWING

DRAWING NO:  
ACE-EB-0046 -105

Date 06/01/2022	DRAWN BY: NB	REVISION: 1.0
Scale AS SHOWN	APPROVED BY: RM	

100mm  
75mm  
50mm  
25mm  
0mm

A3