



**NOTES:**

- █ RED OUTLINE INDICATES SITE BOUNDARY.
- █ GREEN OUTLINE INDICATES PROPOSED NEW WORKS THE SUBJECT OF THIS APPLICATION.
- █ PROPOSED FOUL DRAINAGE ROUTE.
- █ PROPOSED SURFACE WATER DRAINAGE ROUTE.

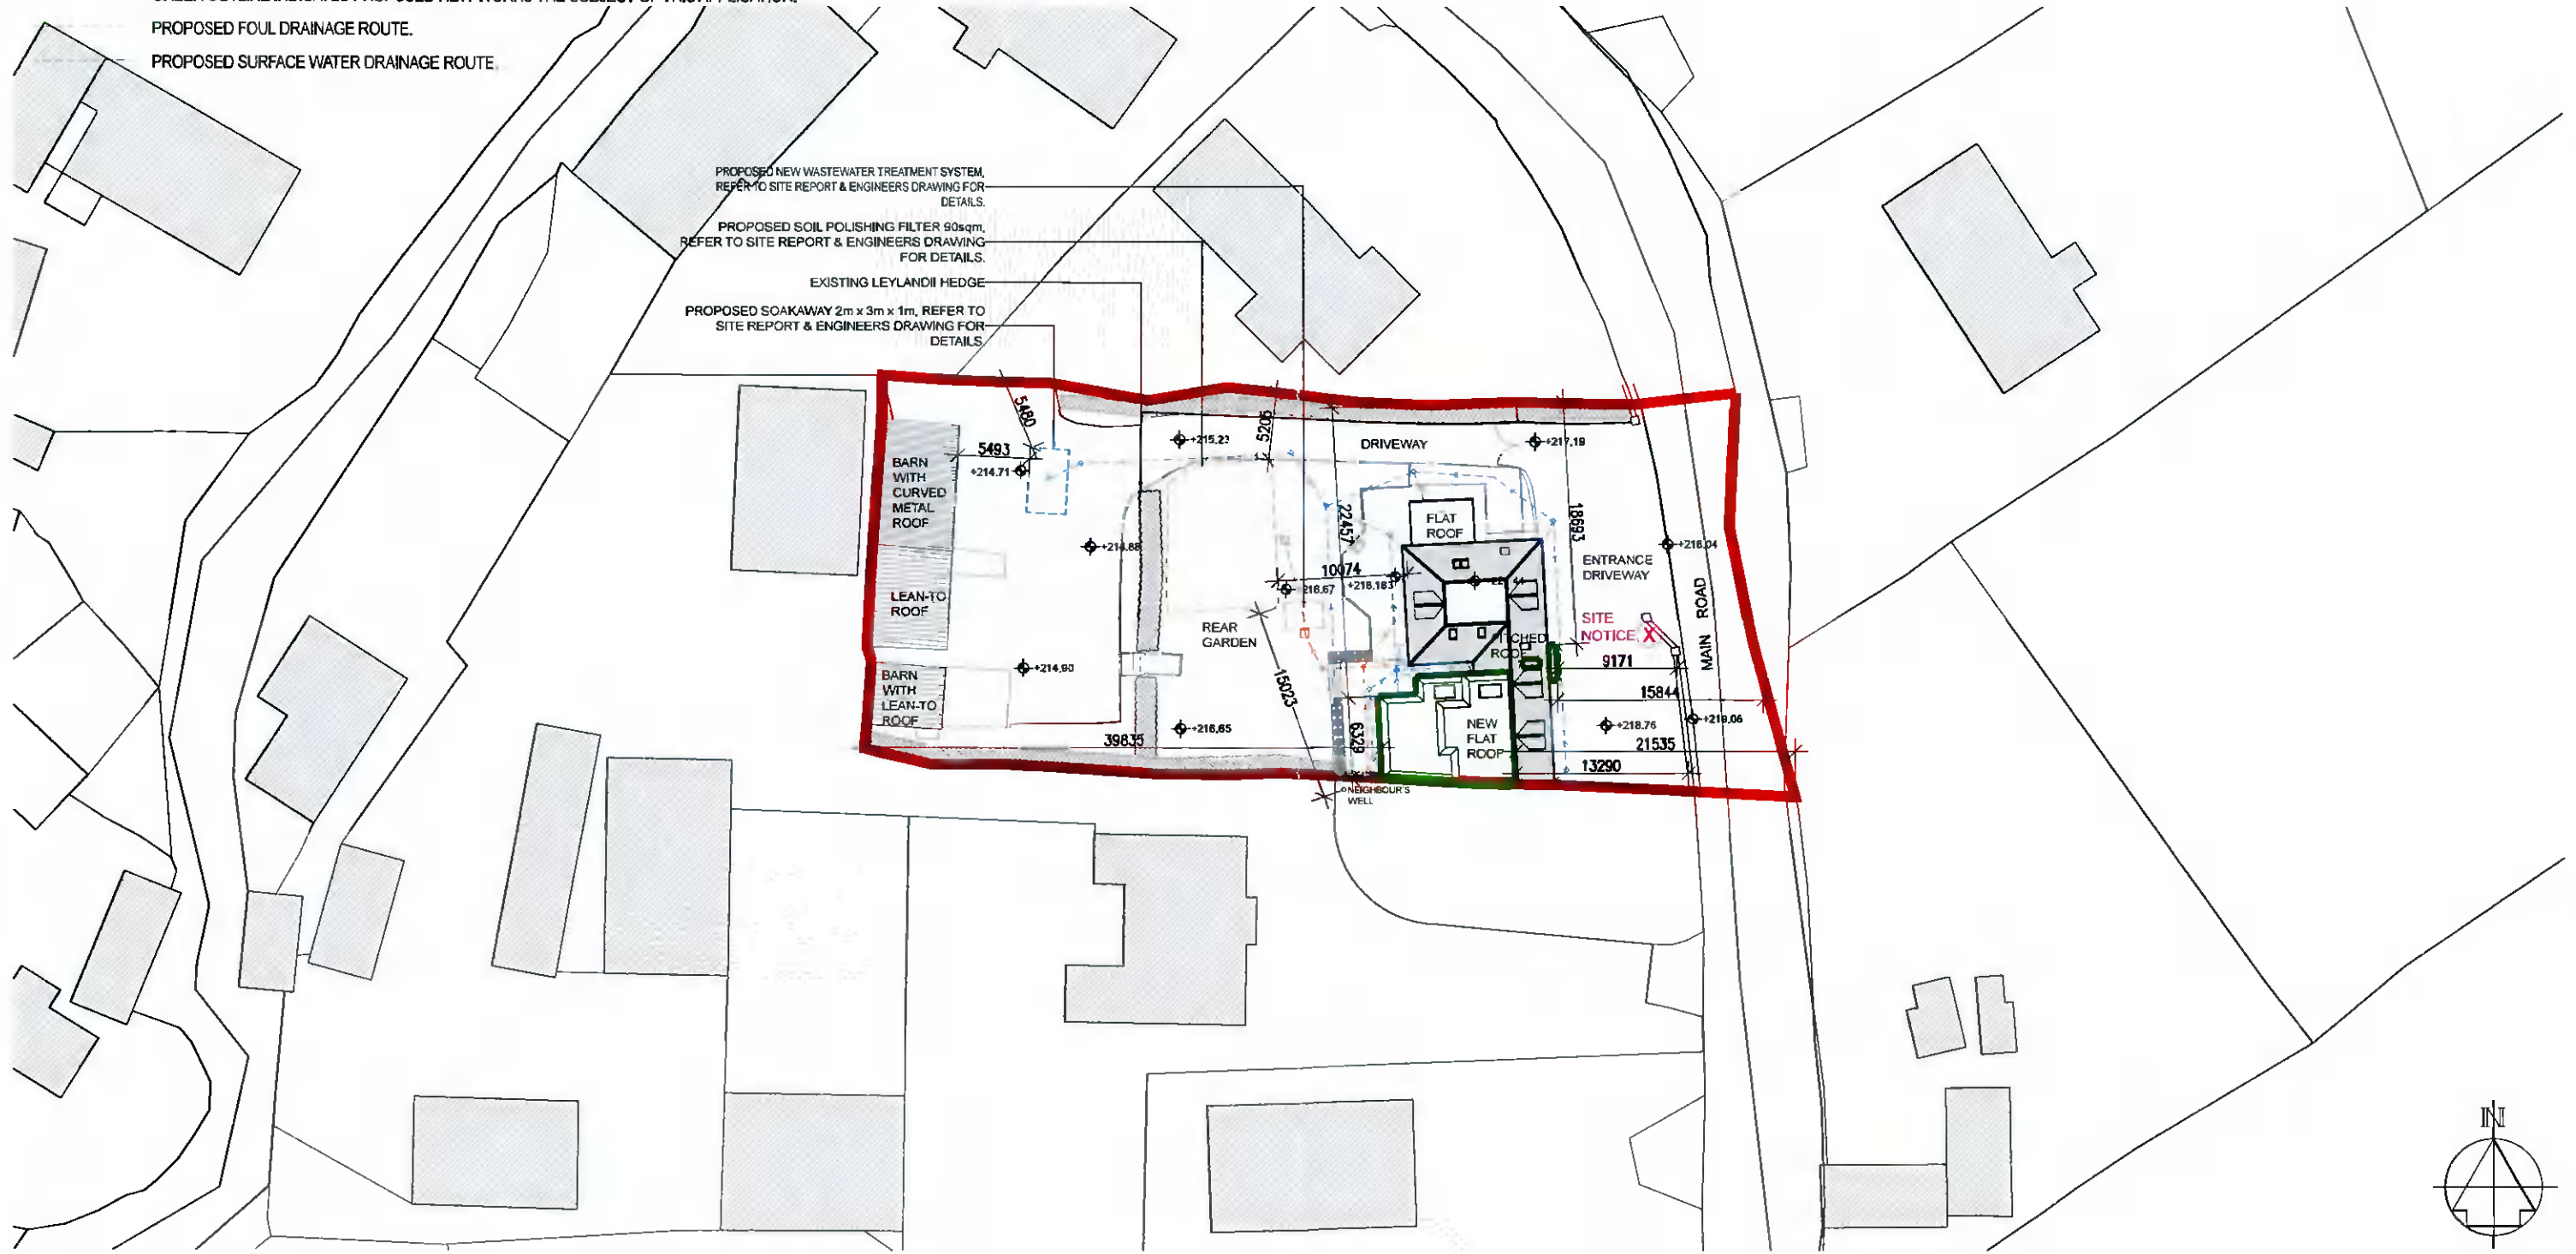

**PROPOSED SITE PLAN**  
SCALE: 1:500

**PLANNING APPLICATION DRAWING**

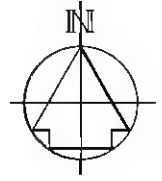

1. Copyright reserved.
2. Work to figured dimensions only. Do not scale drawing.
3. The contractor is responsible for checking all levels and dimension on site and shall refer all discrepancies to the Architect
4. Where appropriate, for details of r.c. structure, or mechanical and electrical details, see Engineers drawings
5. Proprietary items shall be fixed in strict accordance with manufacturers instructions.
6. Sizes of proprietary items shall be checked with manufacturer.
7. The contractor shall be responsible for the coordination of structure, finishes and services.

Modifications	Date	Rev.

CNOC MHUIRE, FRIARSTOWN LOWER, BOHERNABREENA, CO. DUBLIN, D24W732					
PROPOSED SITE PLAN					
Date	Format	Drawn by	Number	Scale	Rev.
31-01-22	A3	aoc	2101-PA-P003	1:500	-

**CLIENT :**  
Lynne McKeon & Seamus Foley  
Cnoc Mhuire  
Friarstown Lower  
Co. Dublin, D24W732  
Ireland

**20TENstudio**  
Avril O'Connor  
Architect  
Dip Arch B Arch Sc MRIAI  
t +353 86 8130640

46 Limekiln Road  
Terenure  
Dublin 12  
Ireland  
e 20tenstudio@gmail.com