




EXISTING GROUND FLOOR PLAN  
SCALE: 1:100



EXISTING FIRST FLOOR PLAN  
SCALE: 1:100

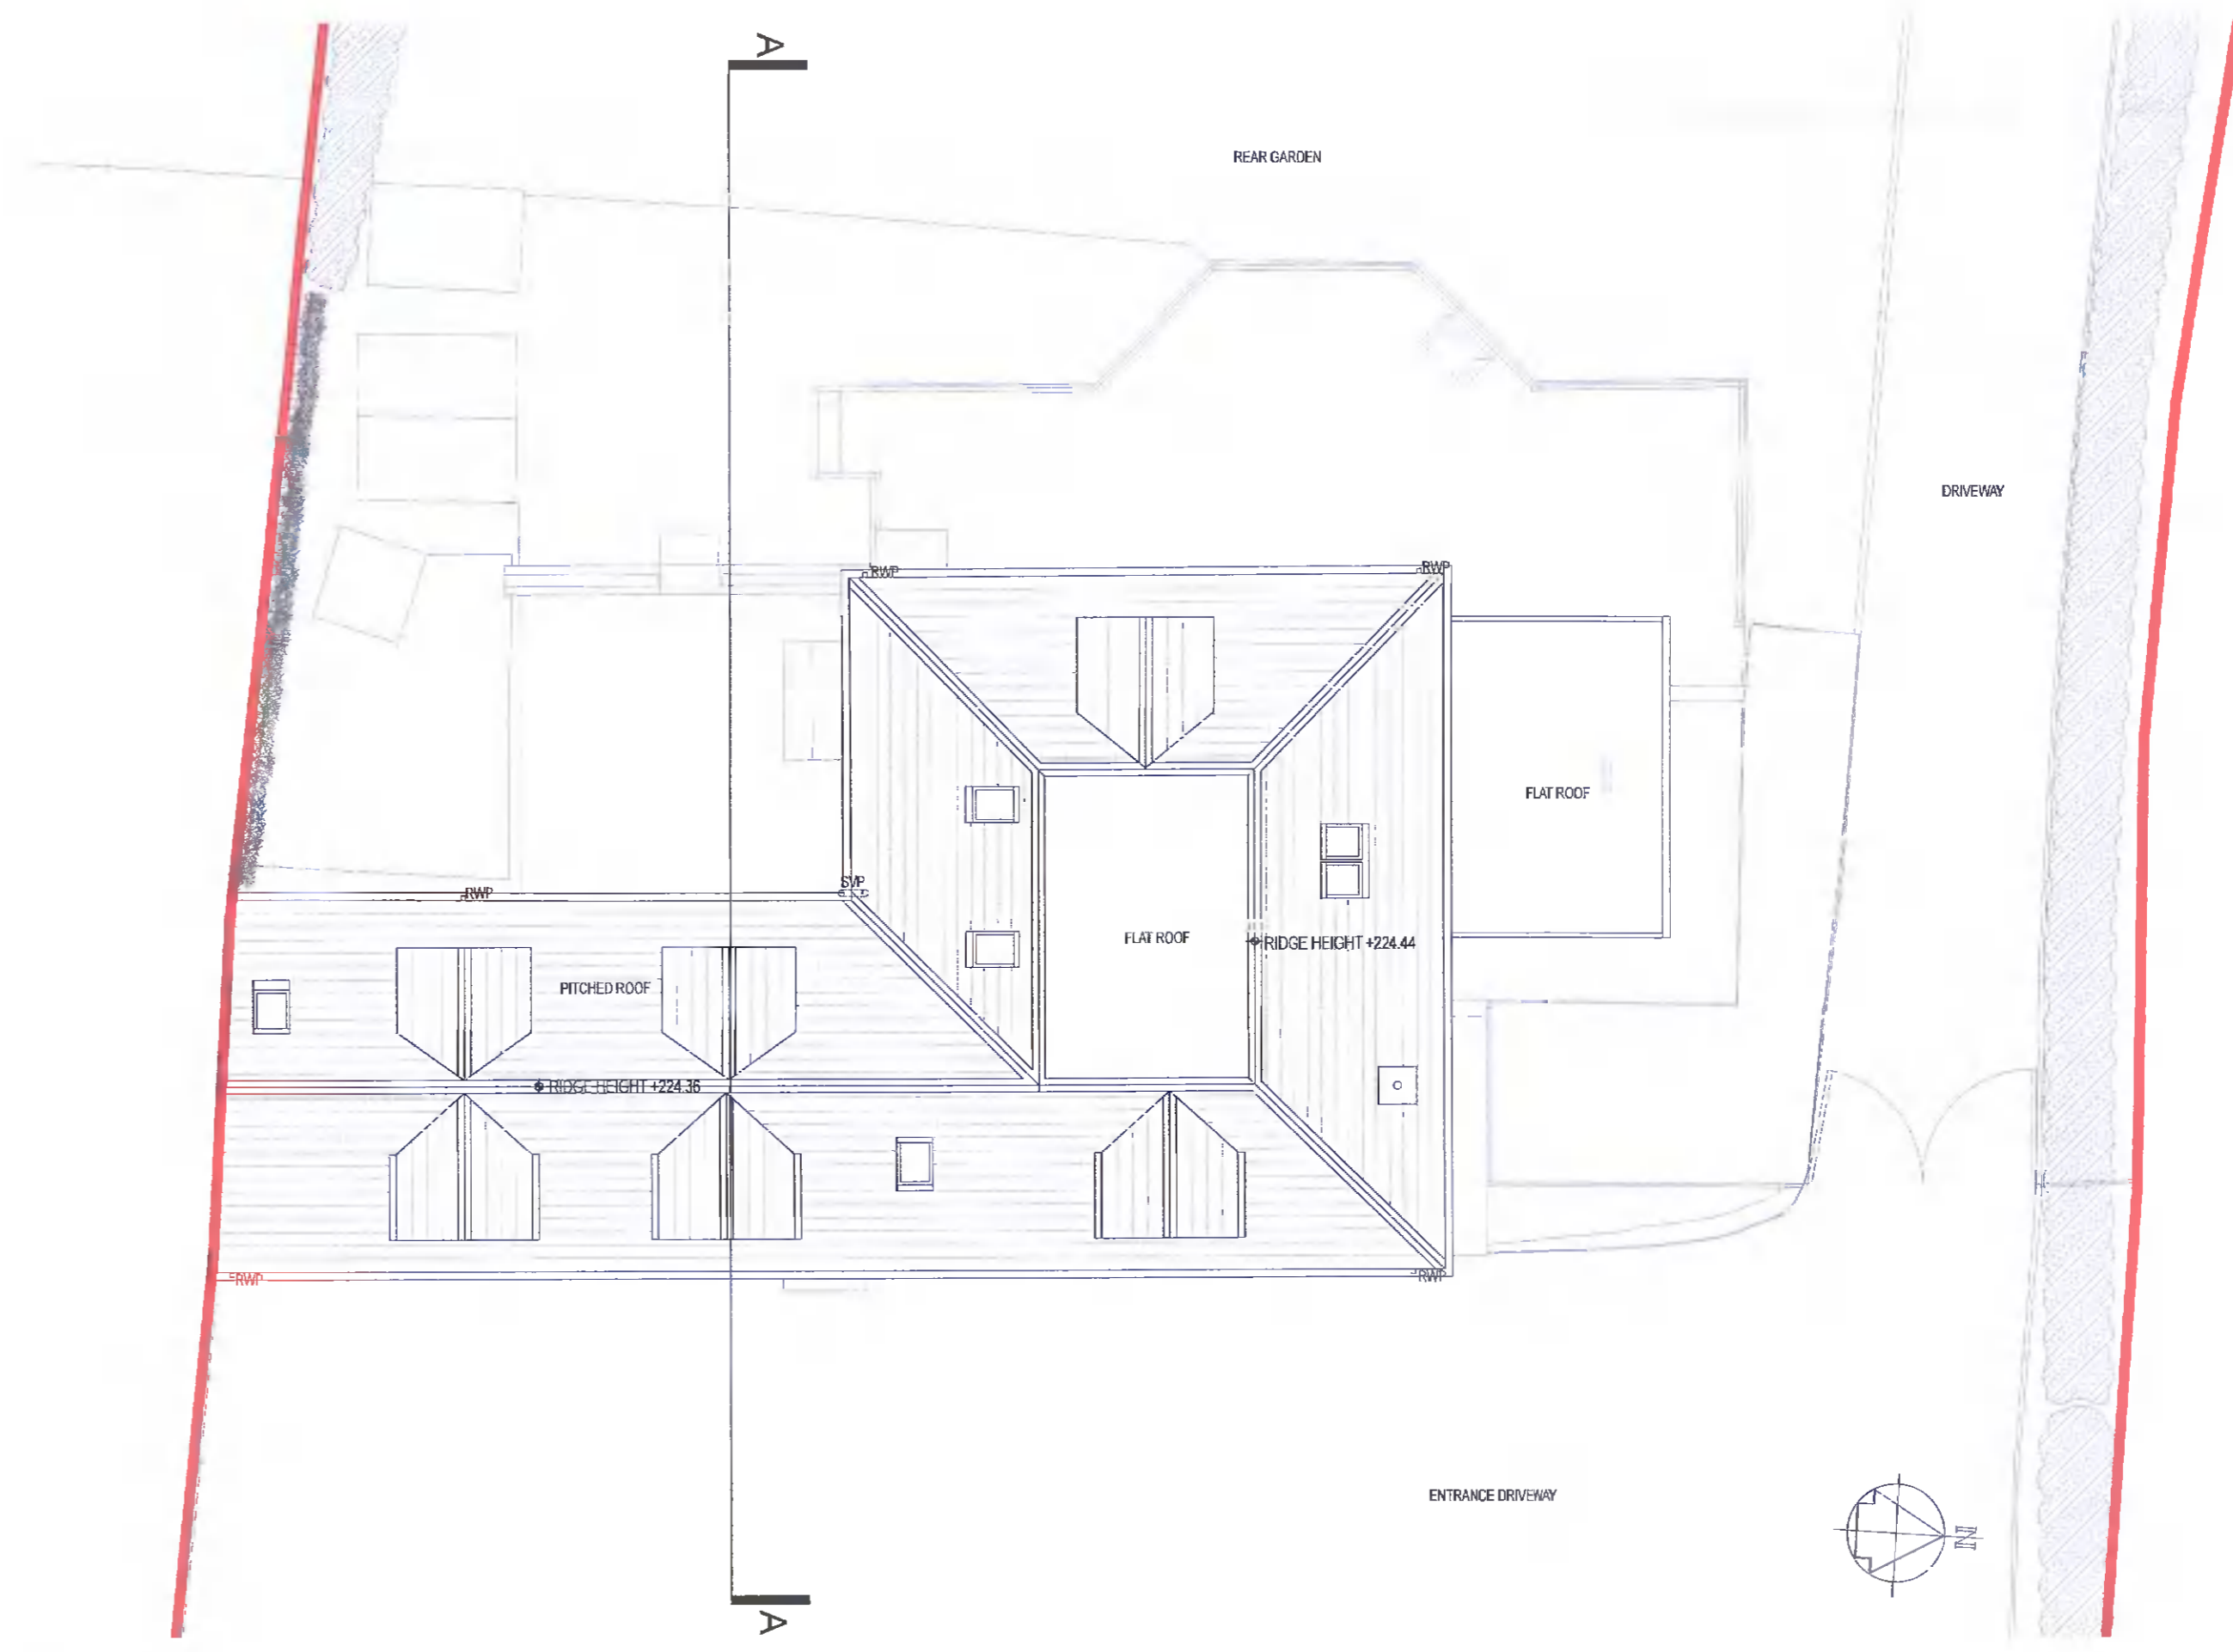

EXISTING ROOF PLAN  
SCALE: 1:100

- NOTES:**
- RED OUTLINE INDICATES SITE BOUNDARY
  - DASHED OUTLINE INDICATES EXISTING WALLS TO BE REMOVED

1. Copyright reserved.
2. Work to figure dimensions only. Do not scale drawing.
3. The contractor is responsible for checking all levels and dimension on site and shall refer all discrepancies to the Architect.
4. Where appropriate, for details of c/s, structure, or mechanical and electrical details, see Engineers drawings.
5. Proprietary items shall be fixed in strict accordance with manufacturer's instructions.
6. Sizes of proprietary items shall be checked with manufacturer.
7. The contractor shall be responsible for the coordination of structure, finishes and services.

Rev	Date	By	Check	Description

Date	Format	Drawn by	Number	Scale	Rev
31.01.22	A1	abc	2101-PA-002	1:100	-

**CNIC MUIRE, FRIARSTOWN LOWER, BOHERBARRREENA, CO. DUBLIN, D24W732**  
EXISTING GROUND FLOOR, FIRST FLOOR & ROOF PLAN

**CLIENT:**  
Lynne McKeon & Seamus Foley  
Cnic Muiire  
Friarstown Lower  
Co. Dublin, D24W732  
Ireland

**20TENstudio**  
Avril O'Connor  
Architect  
48 Linskill Road  
Terenure  
Dublin 12  
Ireland  
+353 86 8130640  
© 20tenstudio@gmail.com