


**TYPICAL ARRANGEMENT FOR STEEL PALISADE/PALLIDINE GATE**

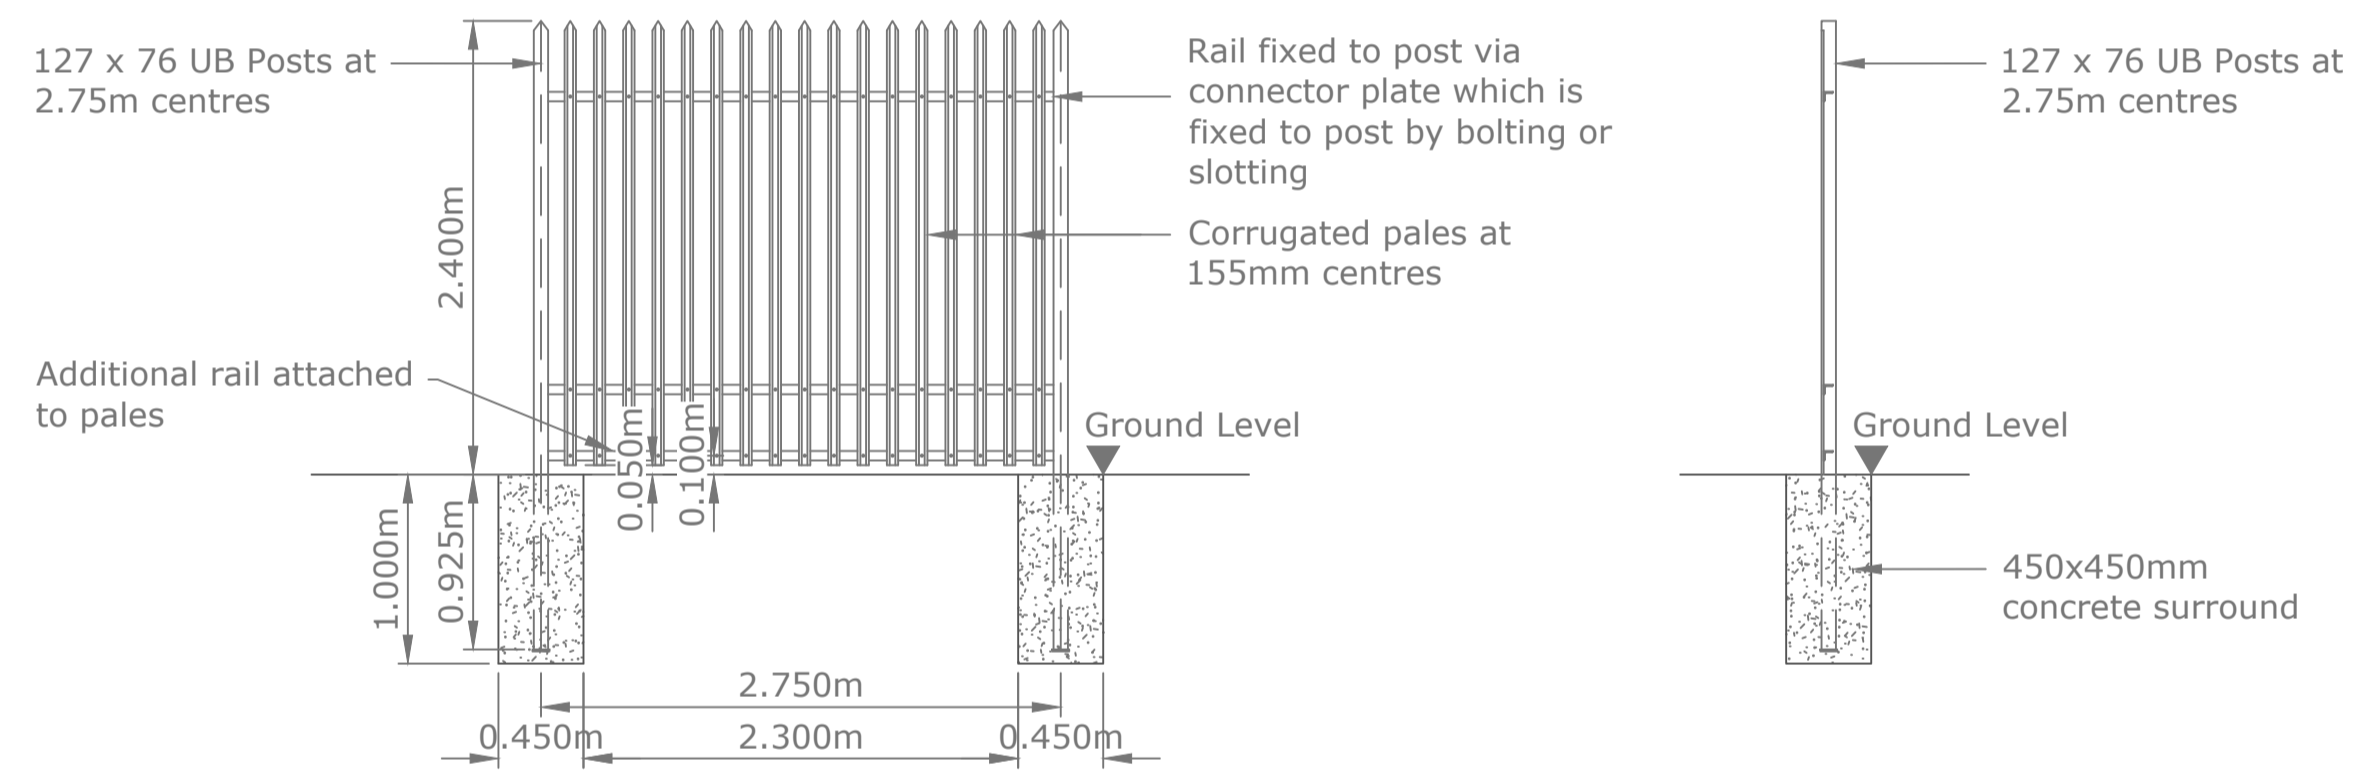


**TYPICAL ARRANGEMENT FOR STEEL PALISADE/PALLIDINE FENCE**

**NOTES:**

1. FIGURED DIMENSIONS ONLY TO BE TAKEN FROM THIS DRAWING.
2. ALL DRAWINGS TO BE CHECKED BY THE CONTRACTOR ON SITE
3. ENGINEER/EMPLOYERS REPRESENTATIVE, AS APPROPRIATE, TO BE INFORMED BY THE CONTRACTOR OF ANY DISCREPANCIES BEFORE ANY WORK COMMENCES
4. THE CONTRACTOR SHALL UNDERTAKE A THOROUGH CHECK FOR THE ACTUAL LOCATION OF ALL SERVICES/UTILITIES, ABOVE AND BELOW GROUND, BEFORE ANY WORK COMMENCES
5. ALL LEVELS SHOWN RELATE TO ORDNANCE SURVEY DATUM AT MALIN HEAD

Rev	Date	Description	By	Chkd.
A	02.03.21	PLANNING ISSUE	MN	MMcC

Client: 

Project: **PROFILE PARK POWER PLANT**

Title: **TYPICAL FENCING DETAILS**

Scale @ A1:	1:40		
Prepared by:	Checked:	Date:	
M. Nolan	M. McCarthy	March 2022	
Project Director:	S. Tinnelly		
Drawing Status:	Draft		

**TOBIN**  
CONSULTING ENGINEERS

Block 10-4, Blanchardstown Corporate Park,  
Dublin 15, Ireland.  
tel: +353-(0)1-8030406  
fax: +353-(0)1-8030409  
e-mail: dublin@tobin.ie  
www.tobin.ie

TOBIN Consulting Engineers will not be liable for any use of this document for any purpose other than that for which it was originally prepared and approved. Enquiries, where specifically and explicitly agreed, in writing, by TOBIN Consulting Engineers, copyright notice, the part of this document may be reproduced or transmitted in any form and this document shall not be relied upon by any third party for any purpose.

Drawing No.: **11069-2022** Revision: **A**