



**ELEVATION A**  
Scale 1:200

**ELEVATION B**  
Scale 1:200

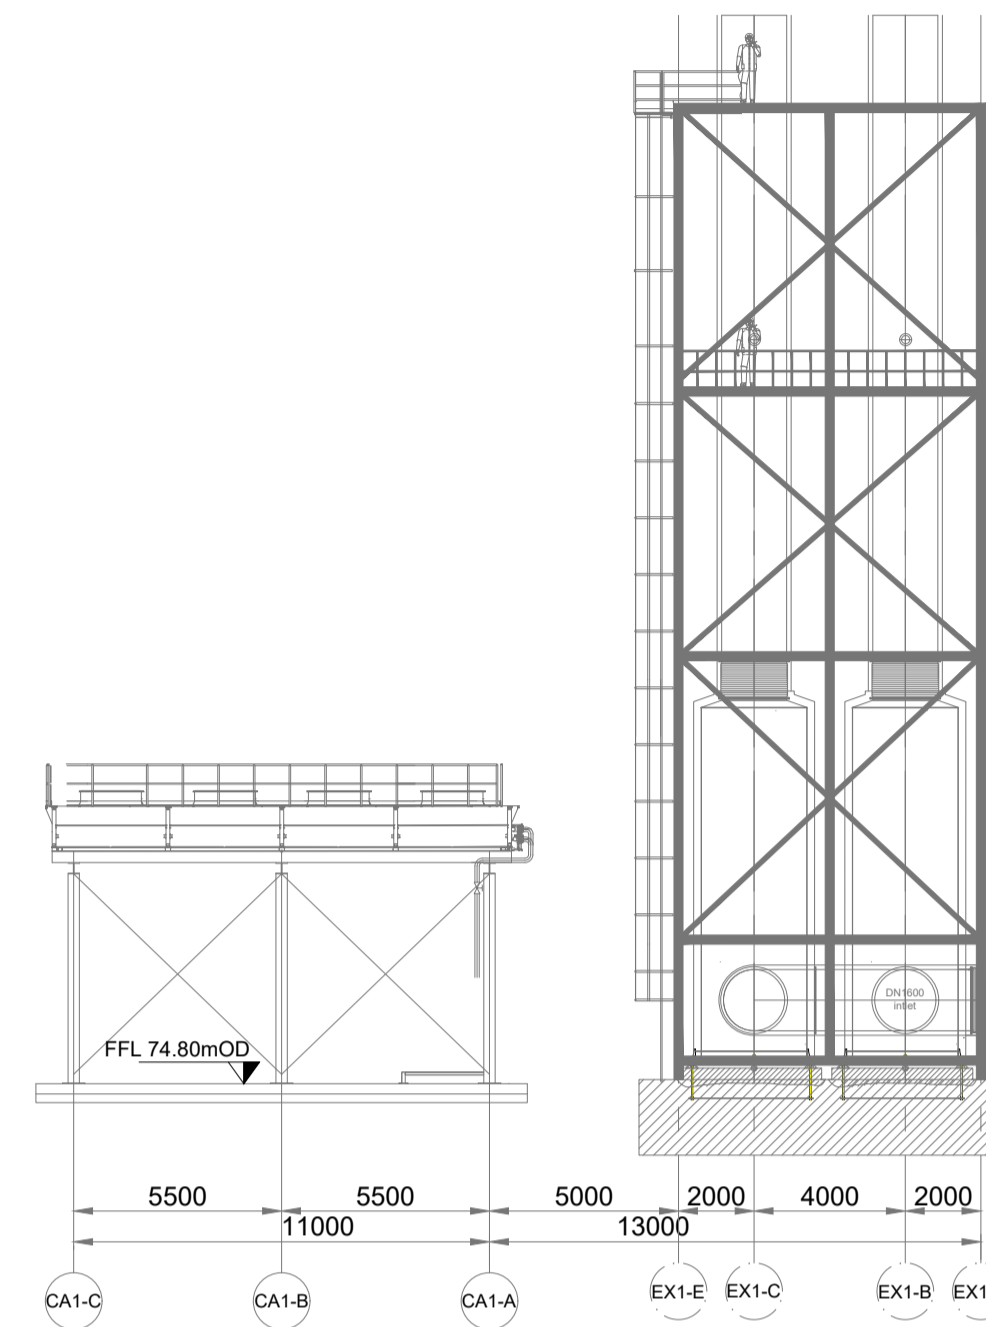


**SECTION 1-1**  
Scale 1:200

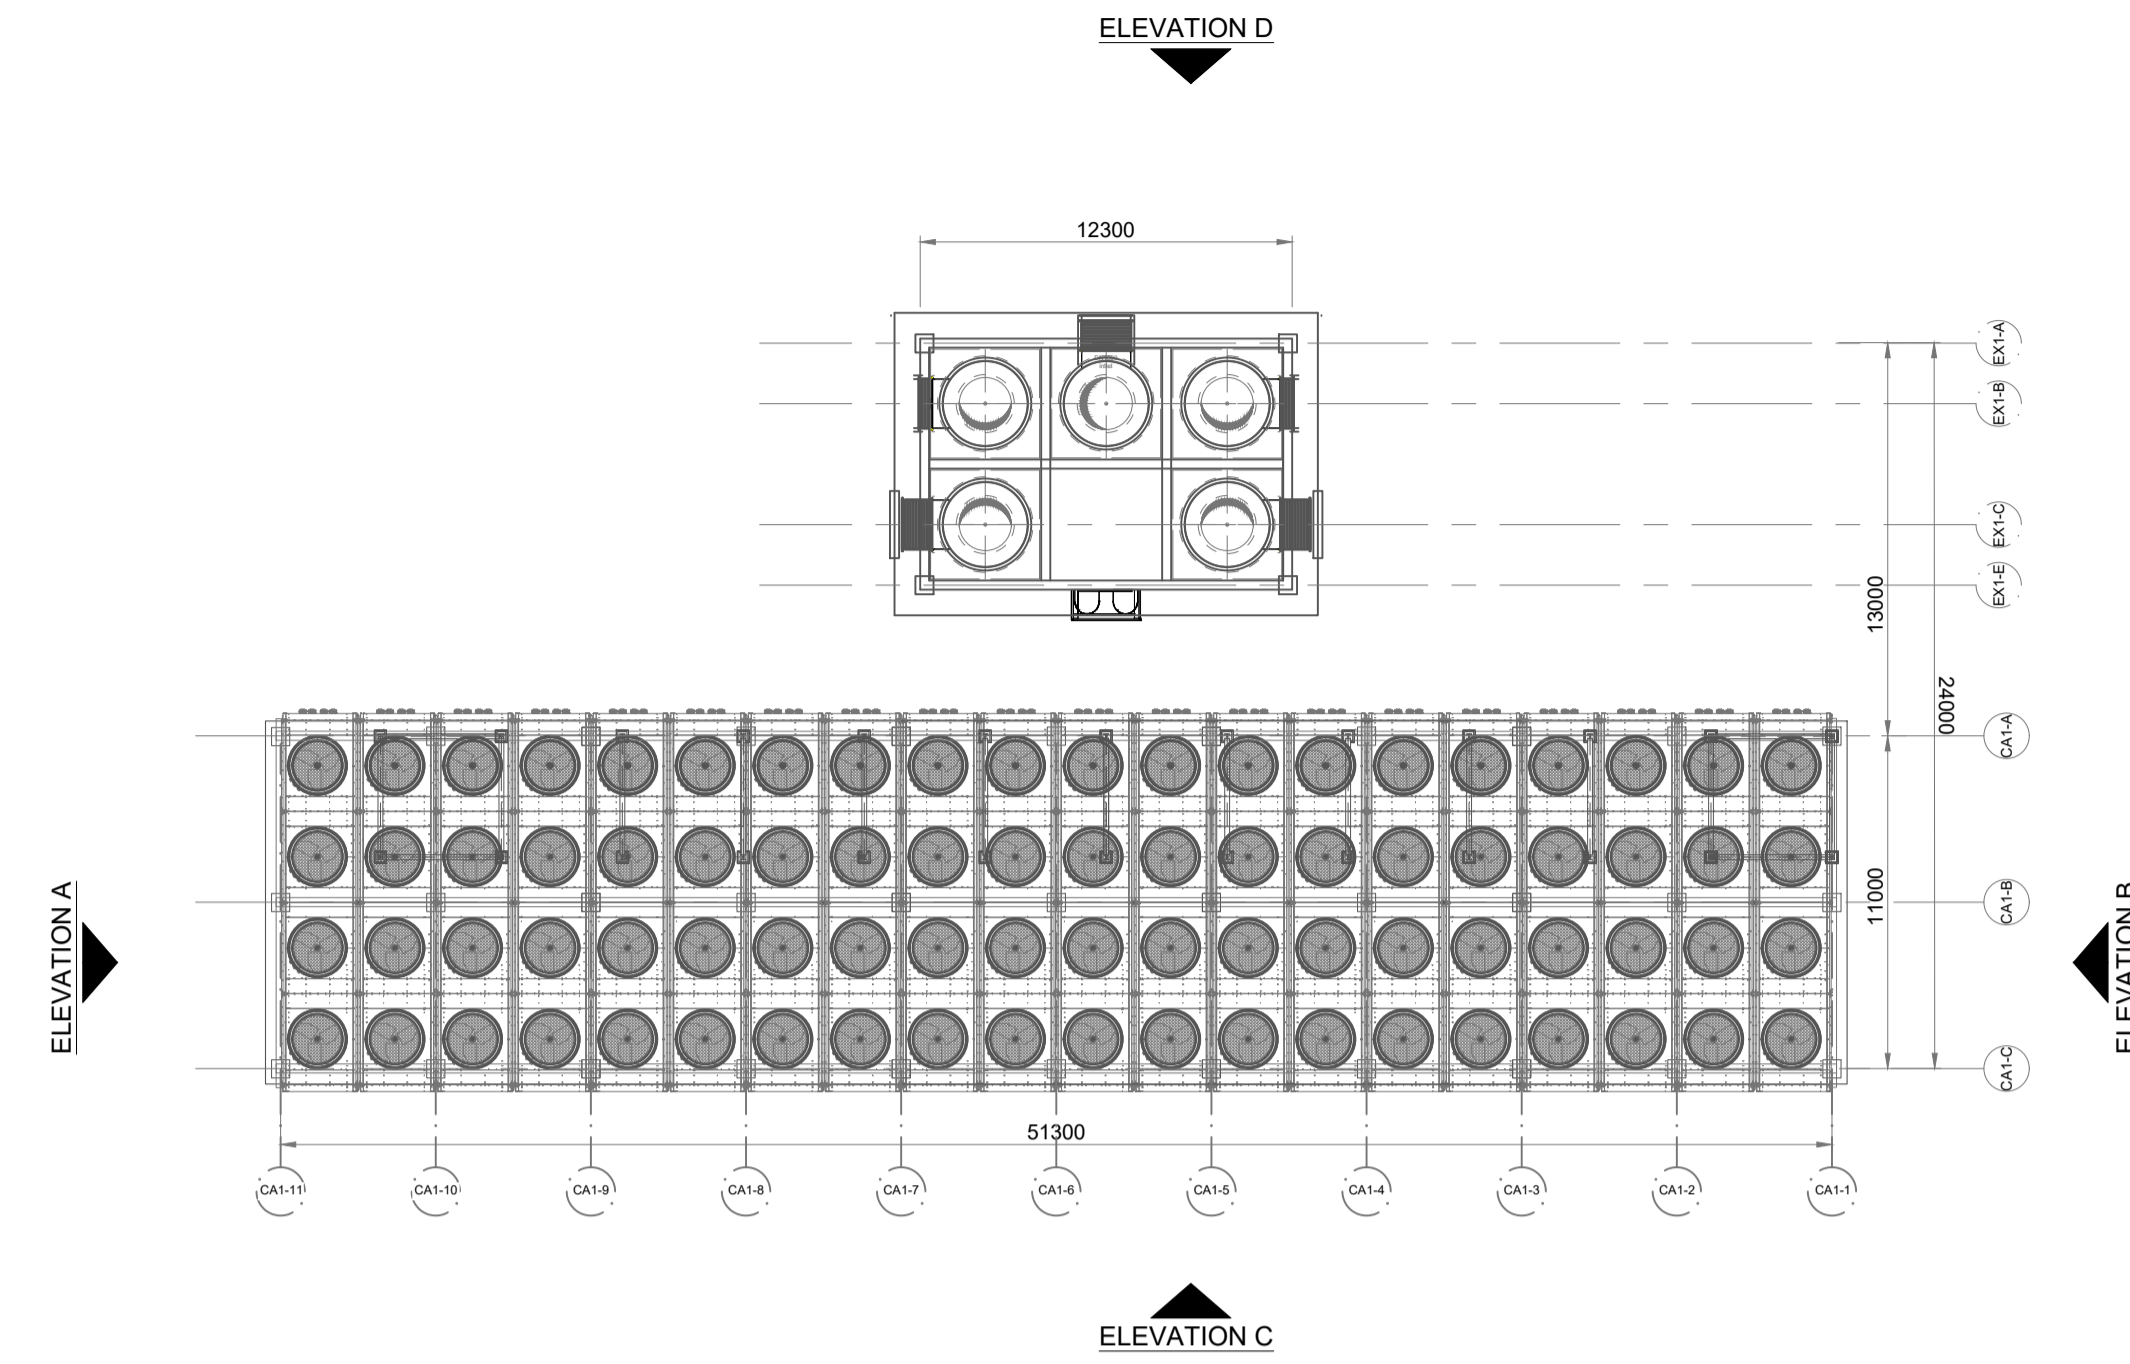


**PLAN**  
Scale 1:250

**ELEVATION C**

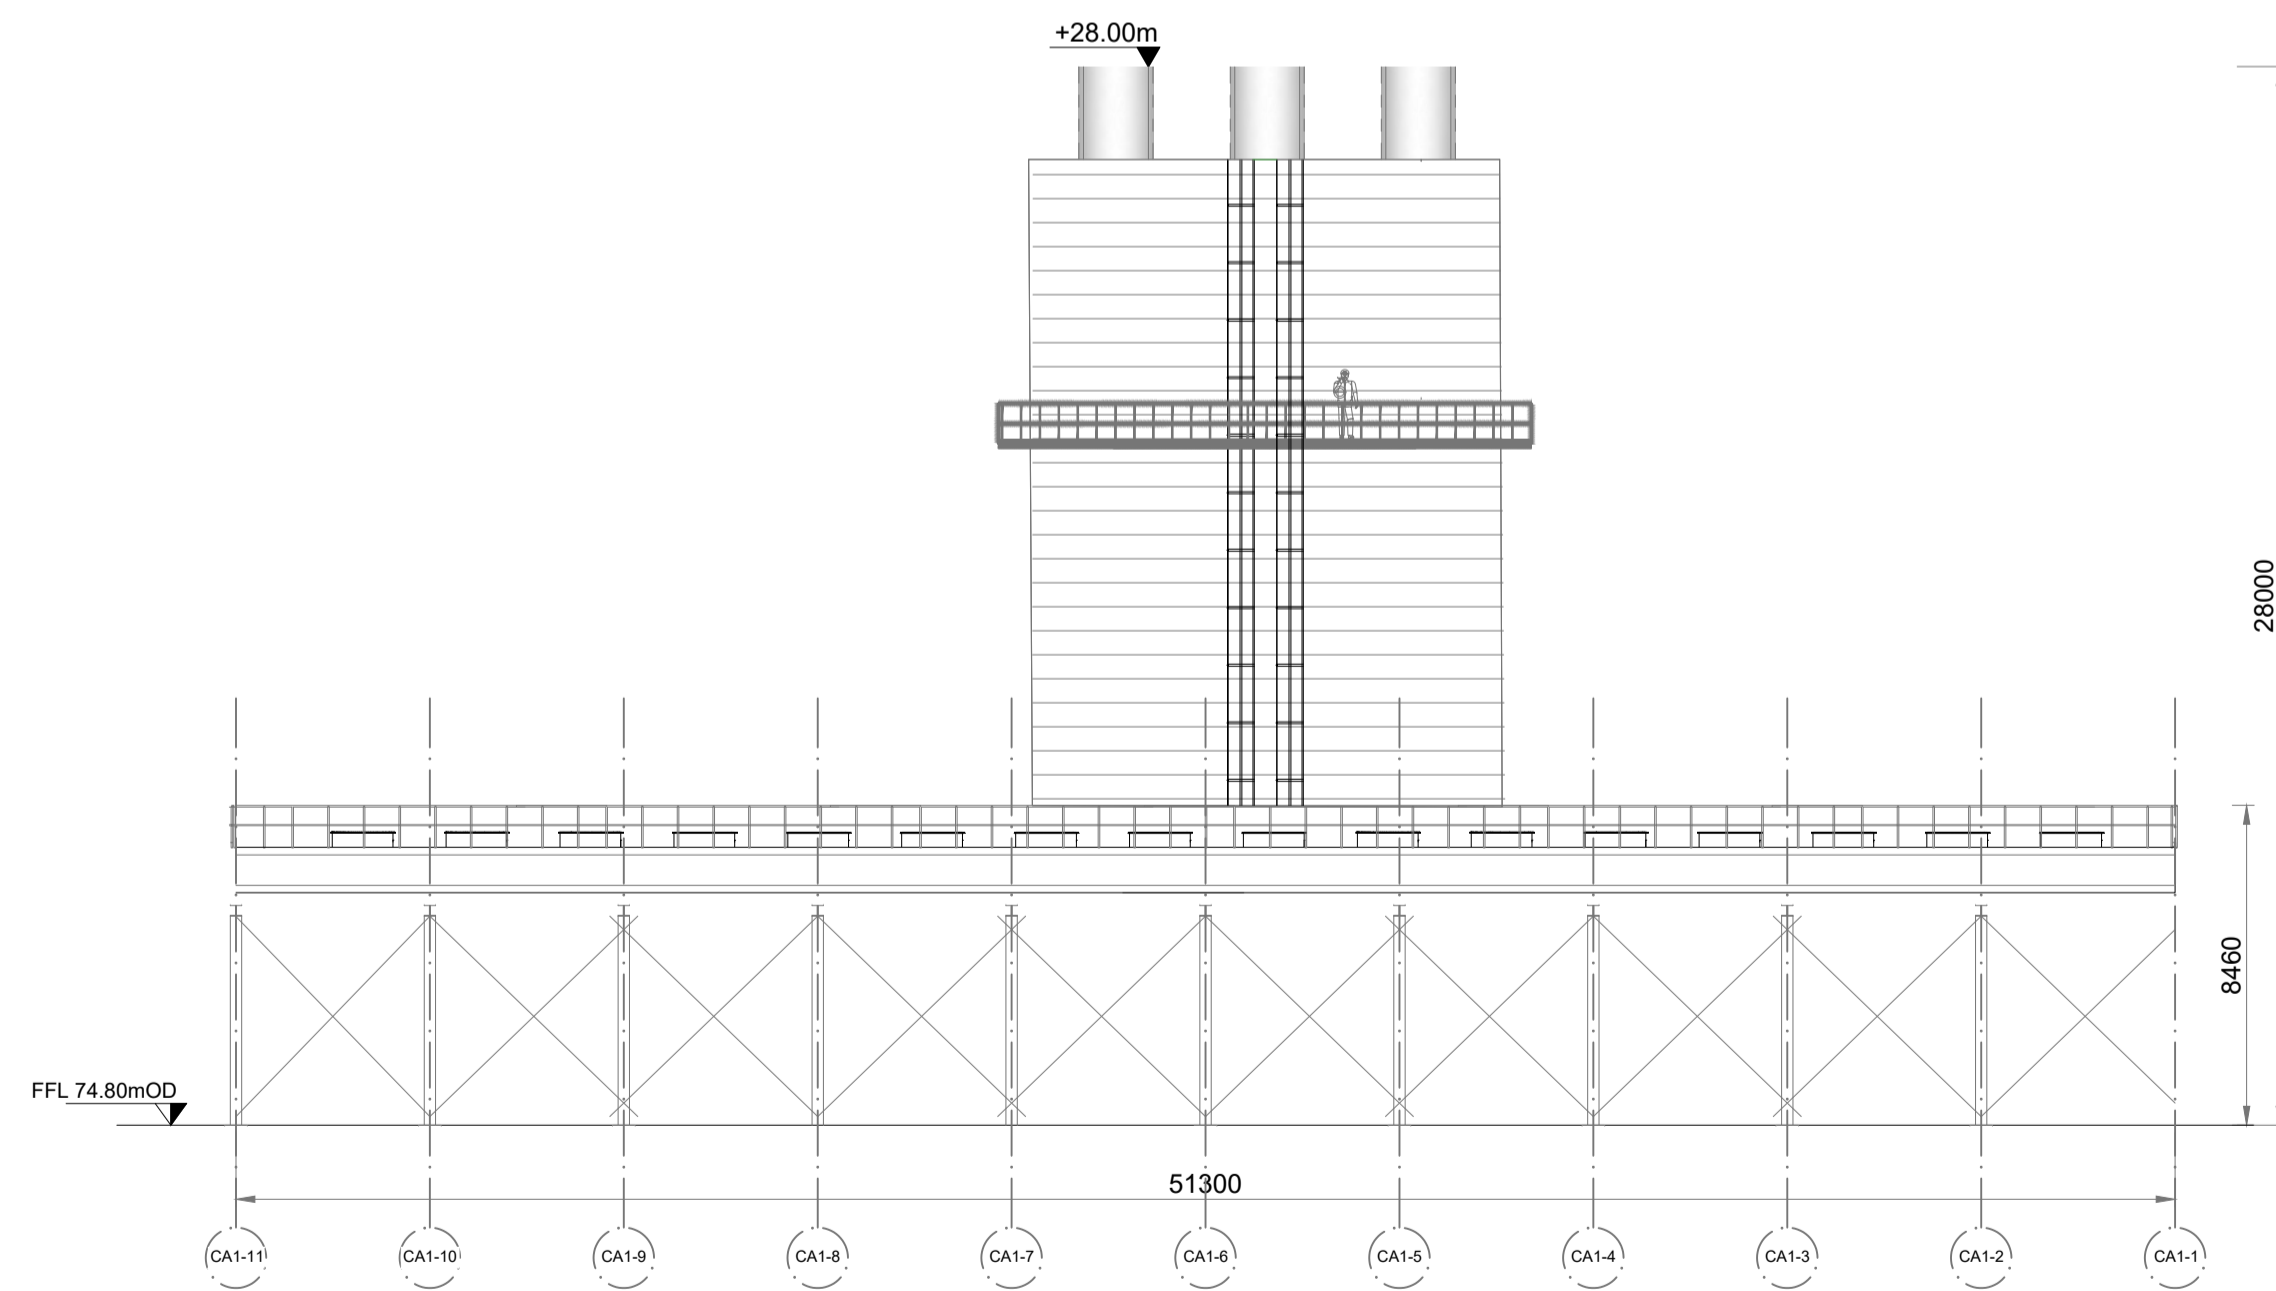

**ELEVATION C**  
Scale 1:200

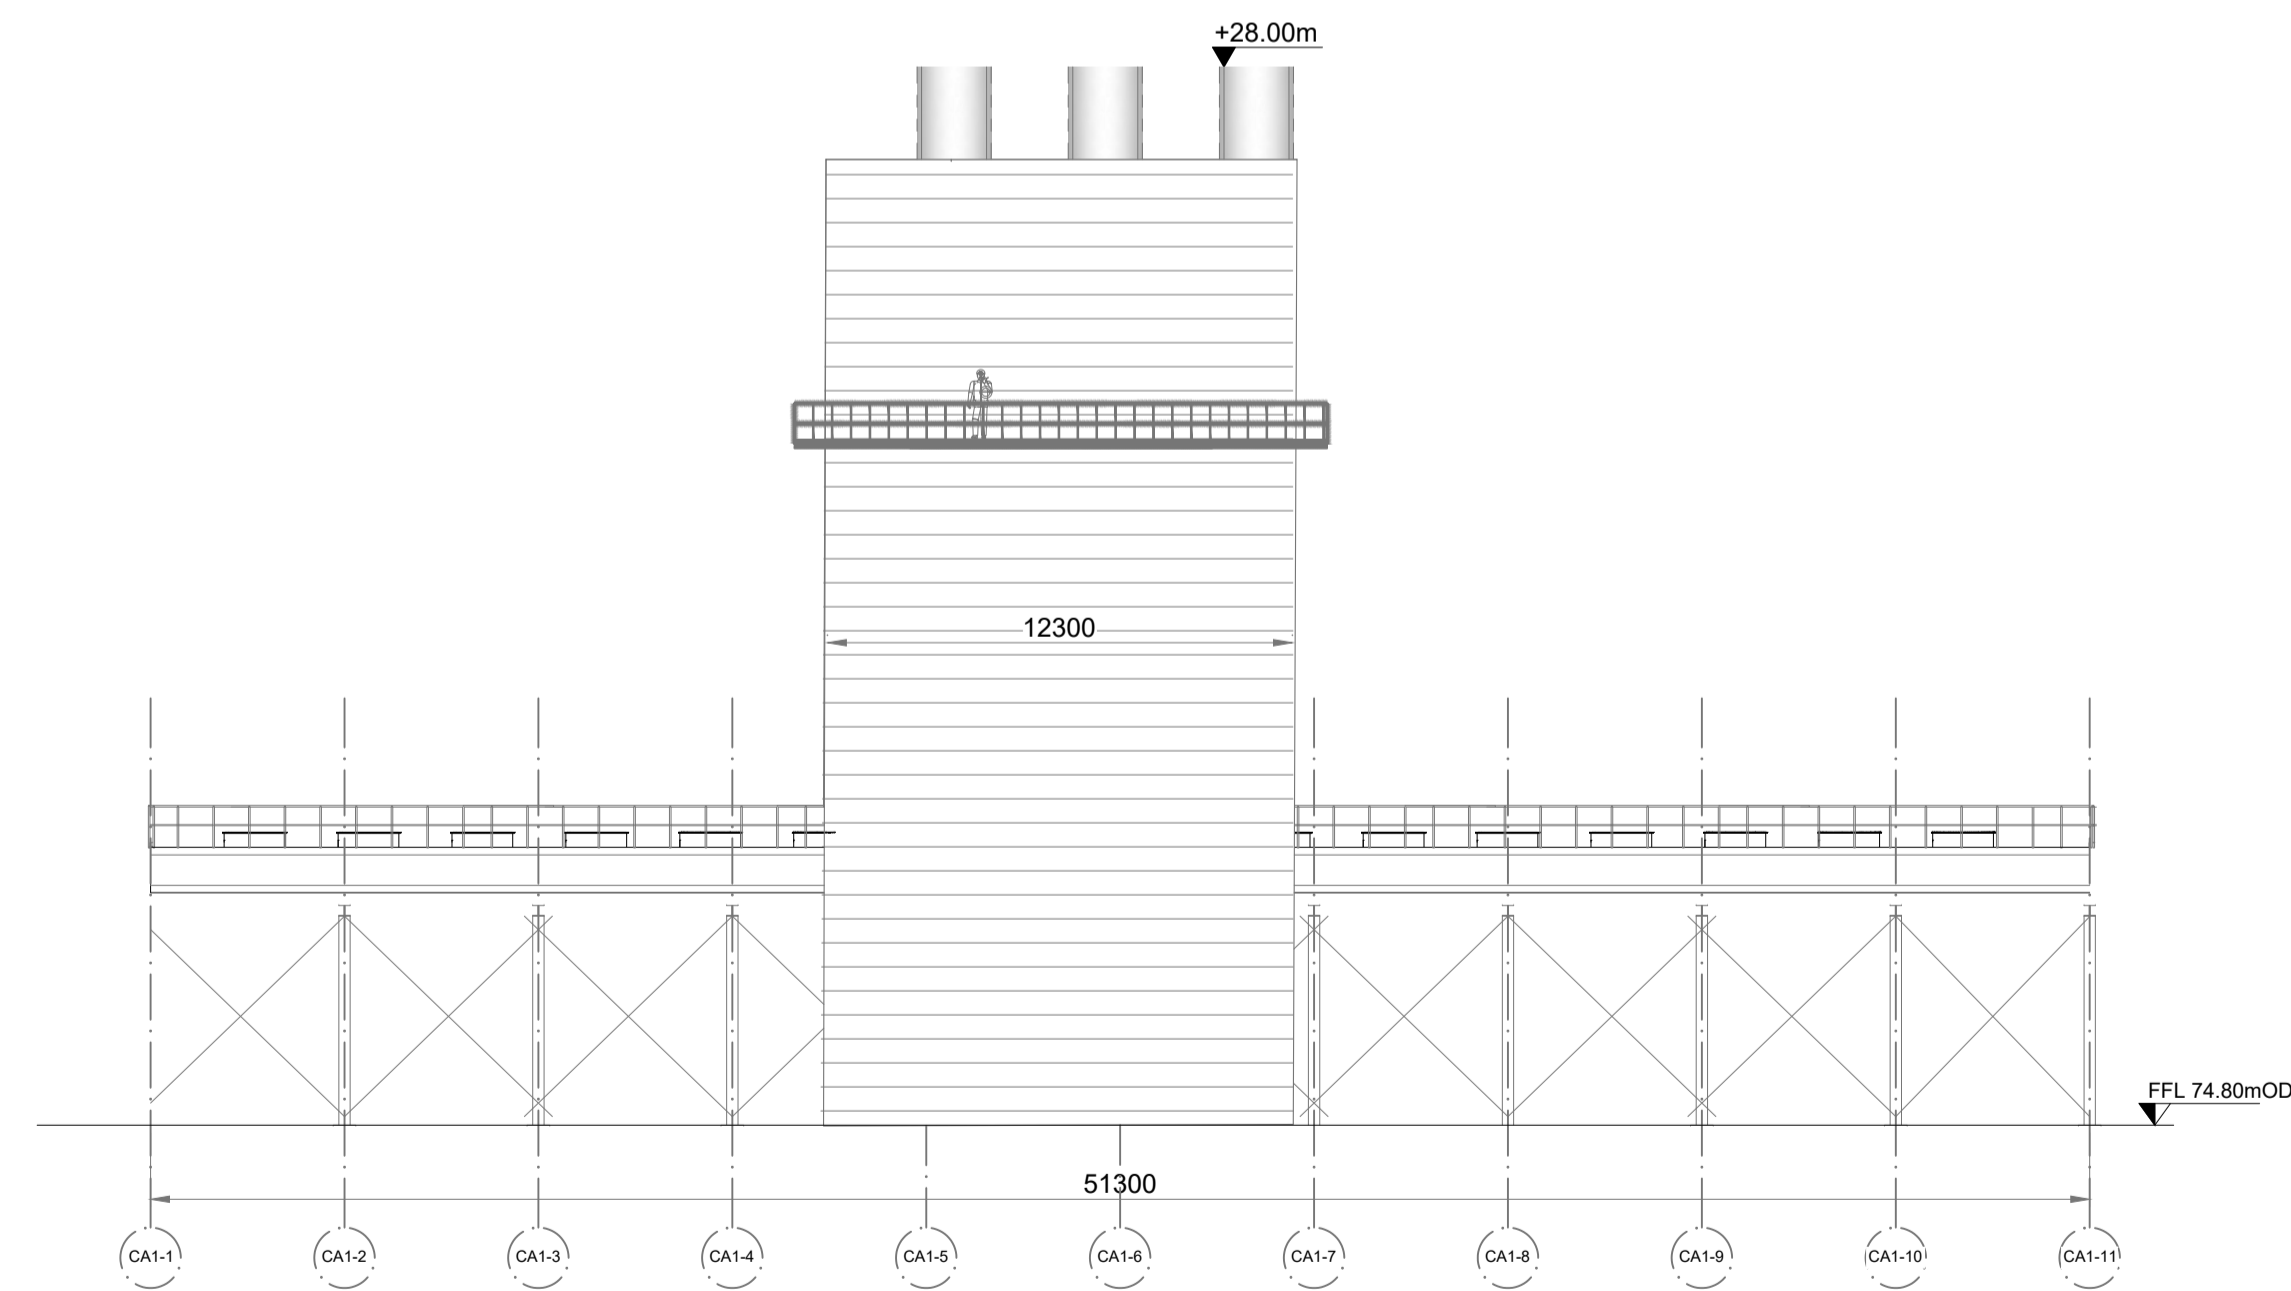

**ELEVATION D**  
Scale 1:200

As agreed with South Dublin County Council in the pre-application consultation meeting the final finishes, including cladding materials and colour codes, will be agreed with the Council post planning through planning condition. Greener Ideas Limited will ensure only Council approved finished are applied on site.

Rev	Date	Description	By	Chkd.
A	02.03.22	PLANNING ISSUE	MN	MMcC



Project:  
**PROFILE PARK  
POWER PLANT**

Title:  
**RADIATOR COOLERS &  
EXHAUST STACK  
PLAN, ELEVATIONS &  
SECTION**

Scale @ A1: **As Shown**  
Prepared by: **M. Nolan** Checked: **M. McCarthy** Date: **March 2022**  
Project Director: **S. Tinnelly**  
Drawing Status: **Planning**

**TOBIN**  
CONSULTING ENGINEERS

Block 10-4, Blanchardstown Corporate Park,  
Dublin 15, Ireland.  
tel: +353-(0)1-8030406  
fax: +353-(0)1-8030409  
e-mail: dublin@tobin.ie  
www.tobin.ie

TOBIN Consulting Engineers will not be liable for any use of this document for any purpose other than that for which it was originally prepared and approved. Except where specifically and explicitly agreed in writing by TOBIN Consulting Engineers, the copyright in this document shall not be reproduced or transmitted in any form and this document shall not be relied upon by any third party for any purpose.

Drawing No.: **11069-2043** Revision: **A**