



GAS AGI - PLAN
Scale 1:200

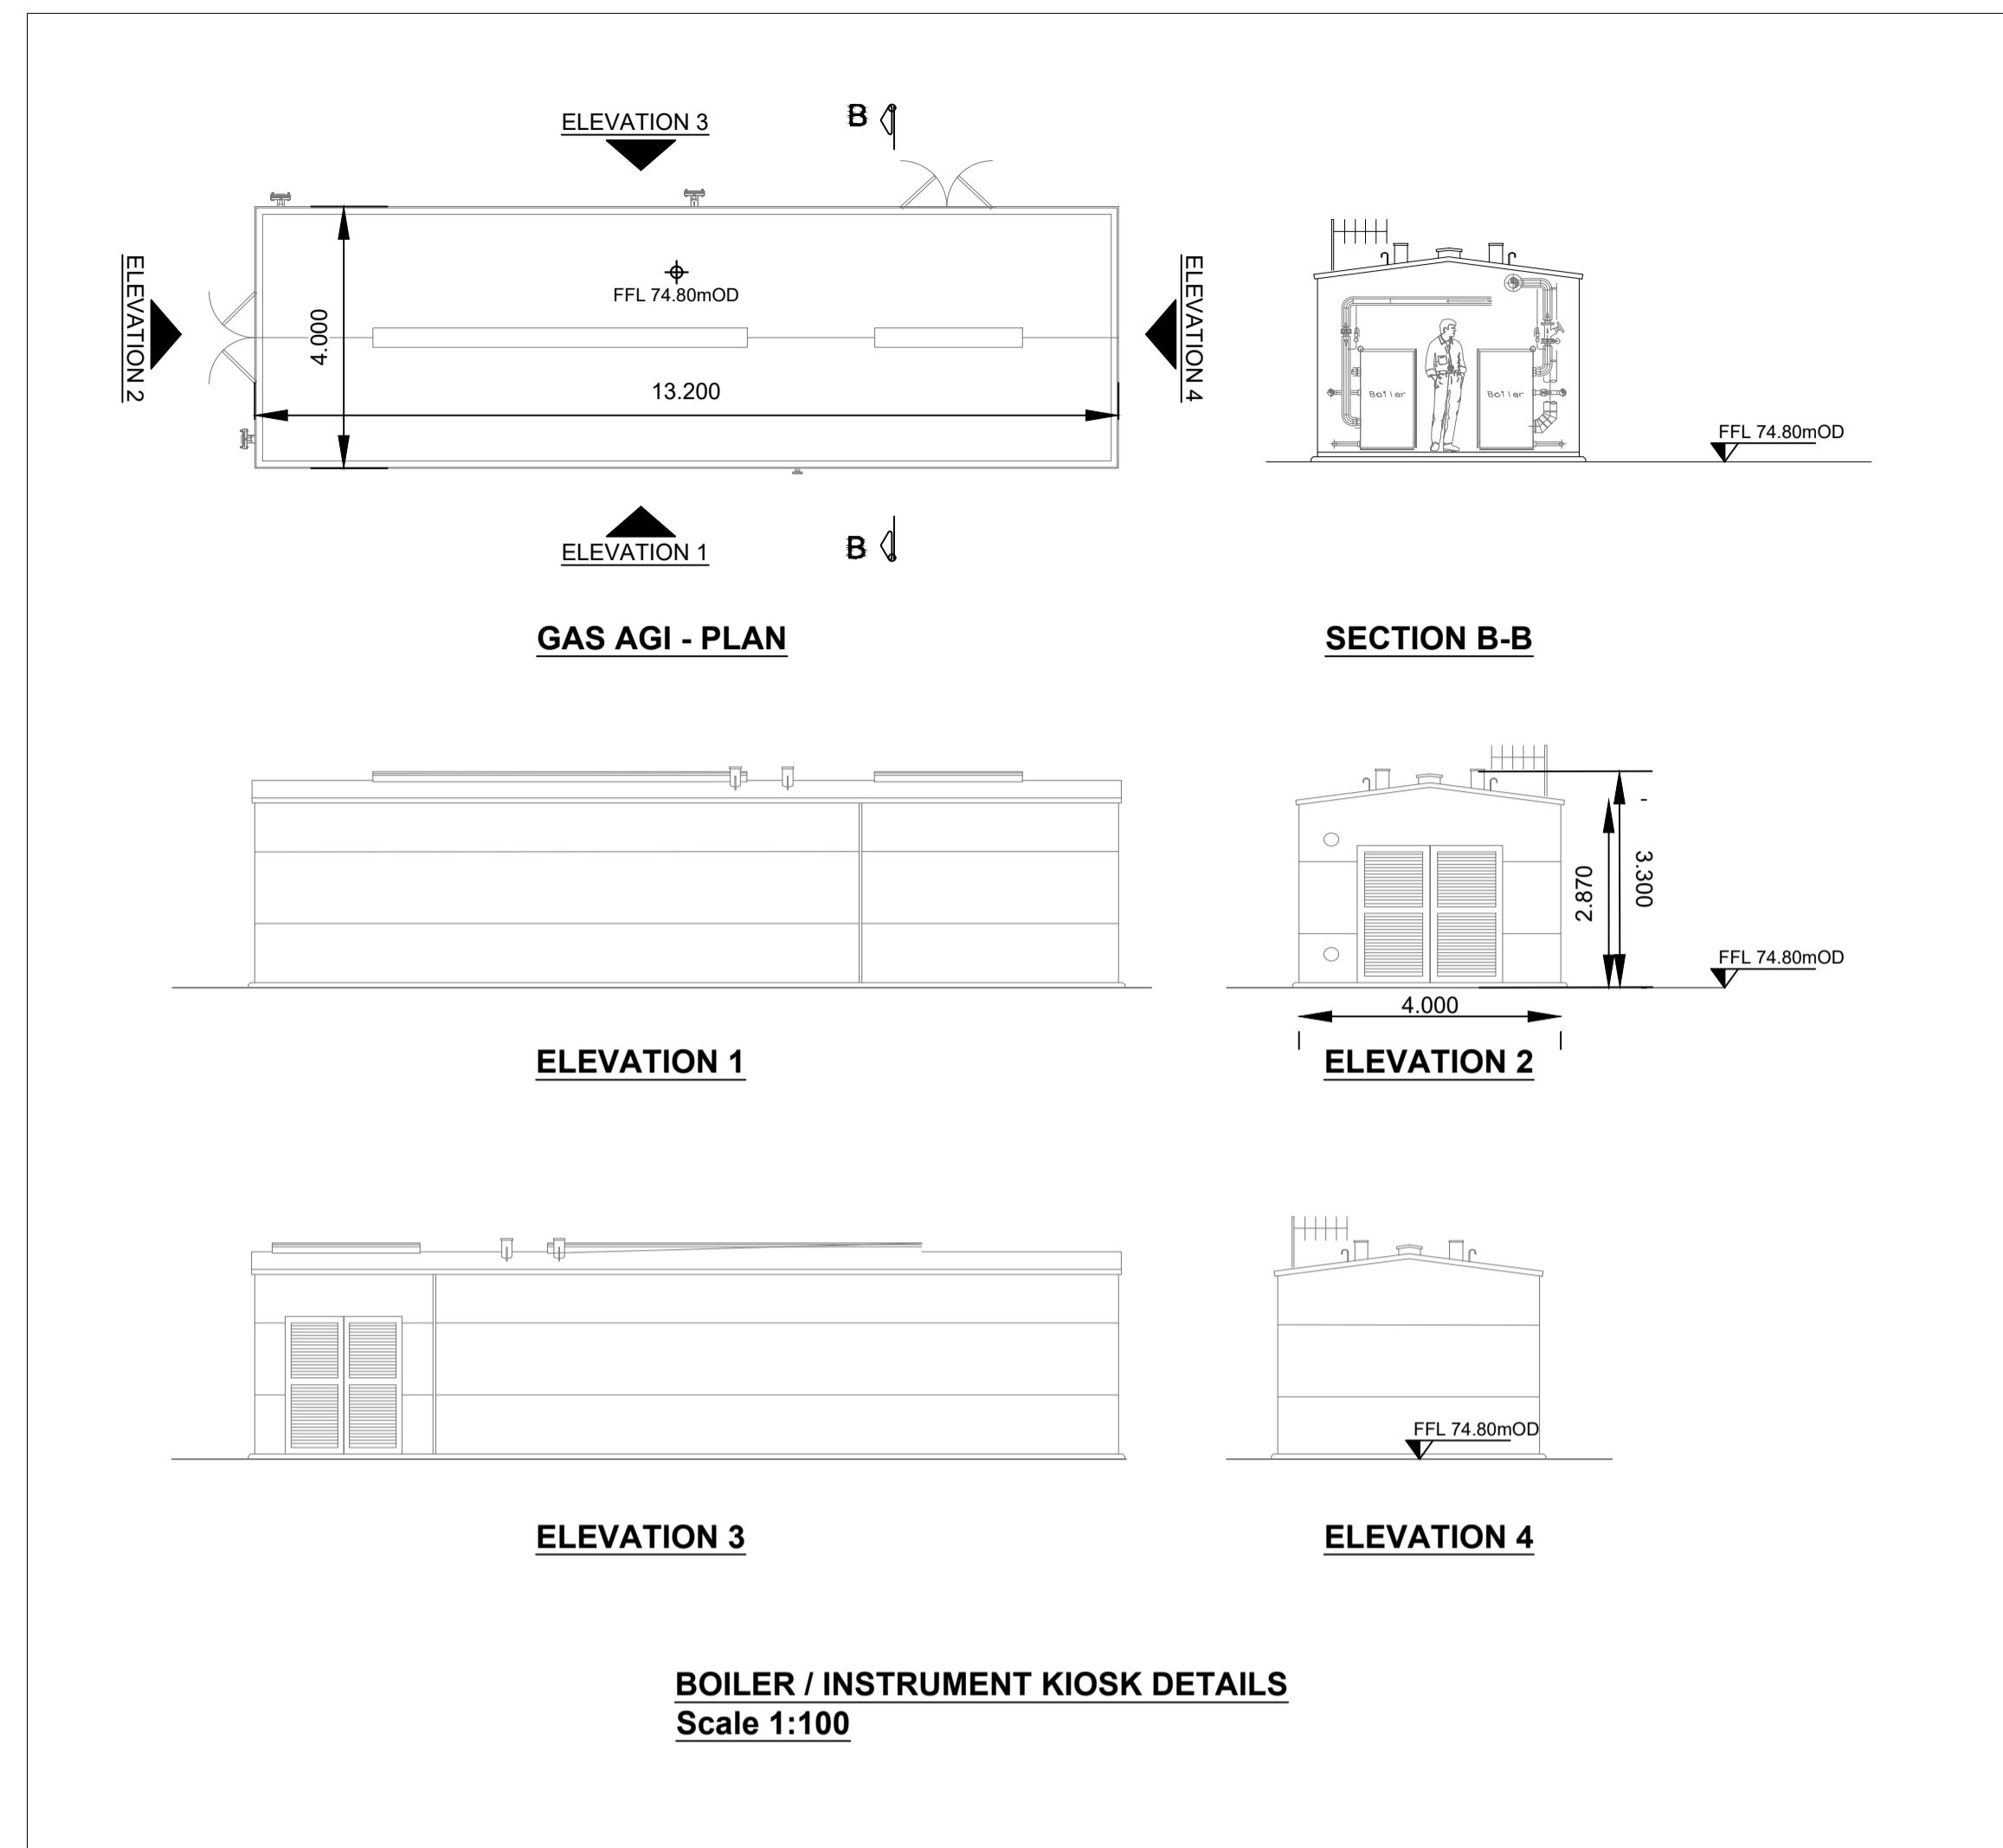

BOILER / INSTRUMENT KIOSK DETAILS
Scale 1:100

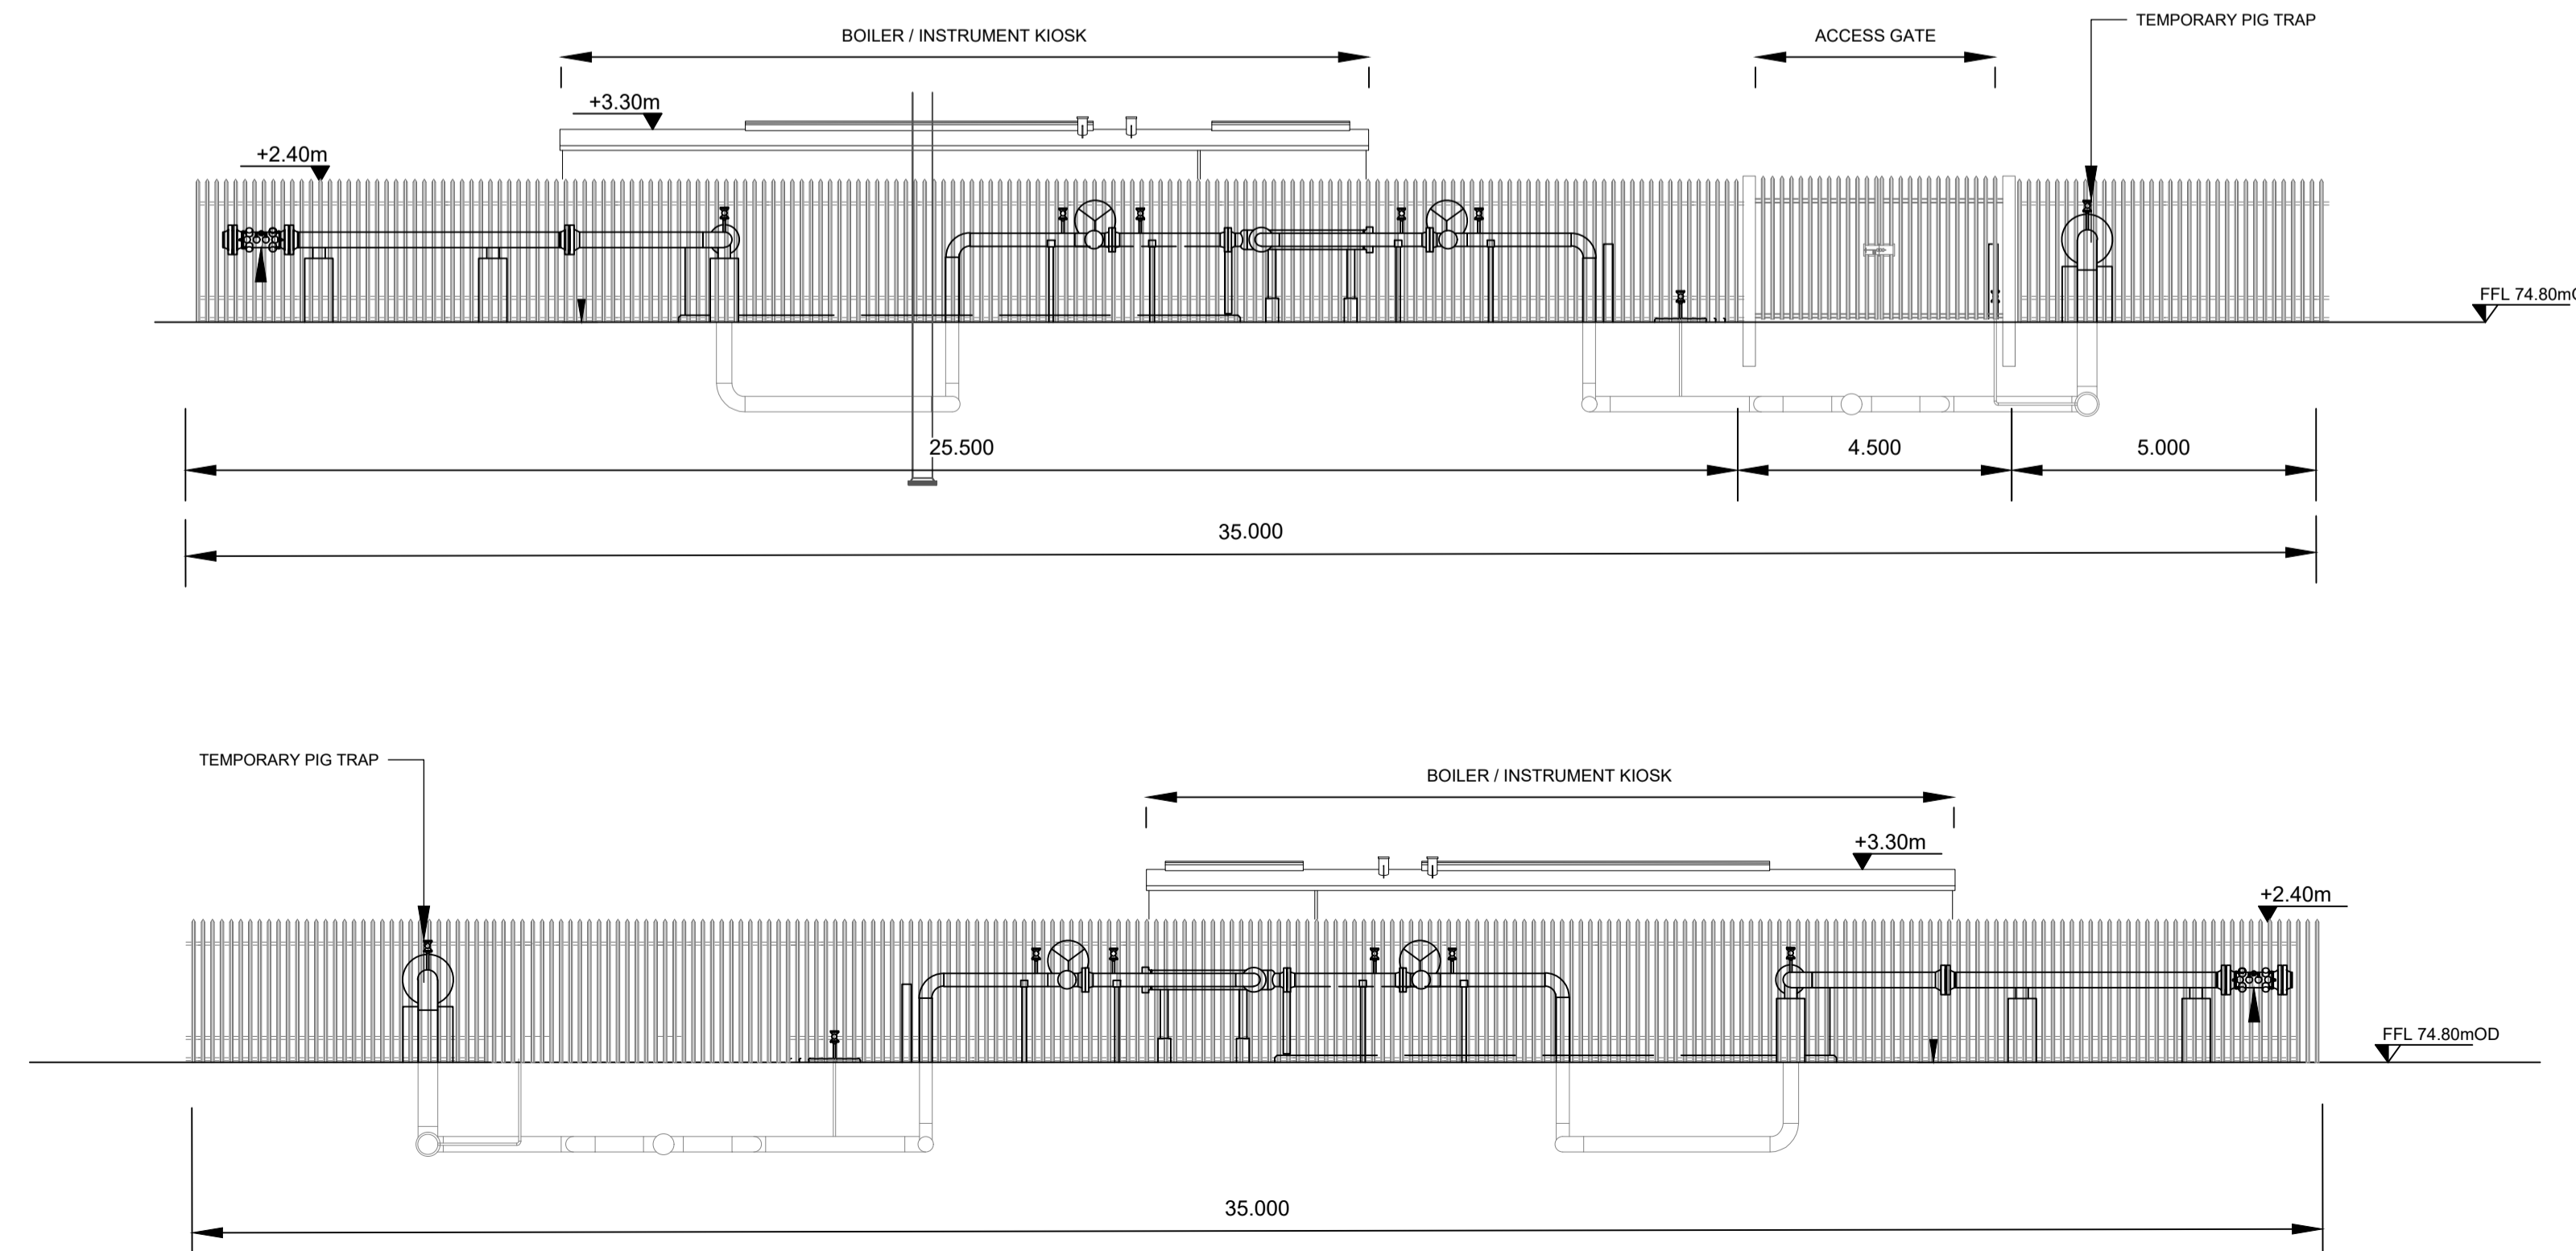


GAS AGI - ELEVATION A
Scale 1:100

GAS AGI - ELEVATION B
Scale 1:100

As agreed with South Dublin County Council in the pre-application consultation meeting the final finishes, including cladding materials and colour codes, will be agreed with the Council post planning through planning condition. Greener Ideas Limited will ensure only Council approved finishes are applied on site.

Rev	Date	Description	By	Chkd.
A	02.03.22	PLANNING ISSUE	MN	MMcC

Client: 

Project: **PROFILE PARK POWER PLANT**

Title: **GAS AGI PLAN, ELEVATIONS & SECTION**

Scale @ A1:	As Shown	
Prepared by:	Checked:	Date:
M. Nolan	M. McCarthy	March 2022
Project Director:	S. Tinnelly	
Drawing Status:	Planning	

TOBIN
CONSULTING ENGINEERS

Block 10-4, Blanchardstown Corporate Park,
Dublin 15, Ireland.
tel: +353-(0)1-8030406
fax: +353-(0)1-8030409
e-mail: dublin@tobin.ie
www.tobin.ie

Tobin Consulting Engineers will not be liable for any use of this document for any purpose other than that for which it was originally prepared and approved. Except where specifically stated explicitly agreed, no copyright or other intellectual property rights are claimed in any form and this document shall not be relied upon by any third party for any purpose.

Drawing No.: **11069-2044** Revision: **A**