




Elevation S2

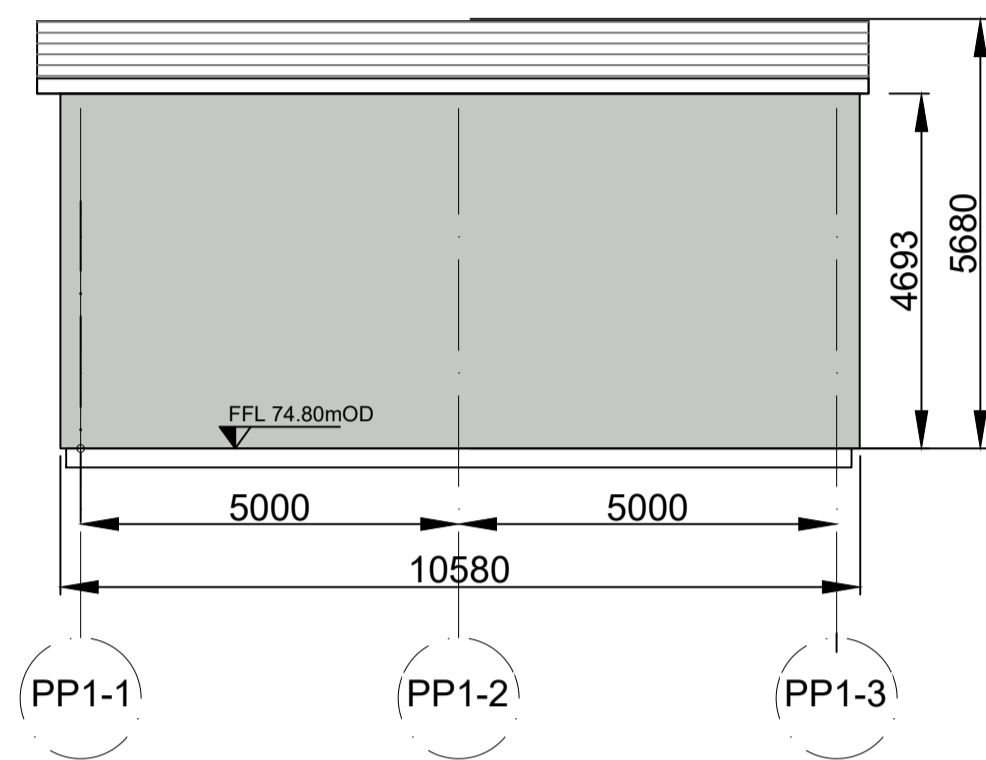


Elevation S1

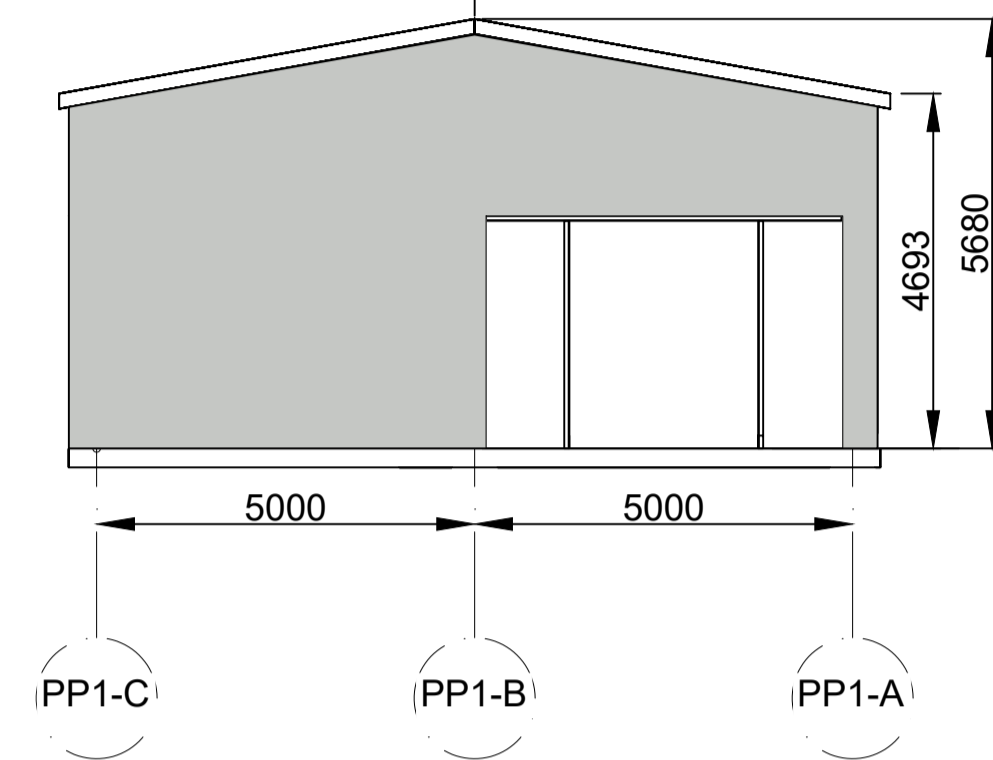


Section S2
(1:125)

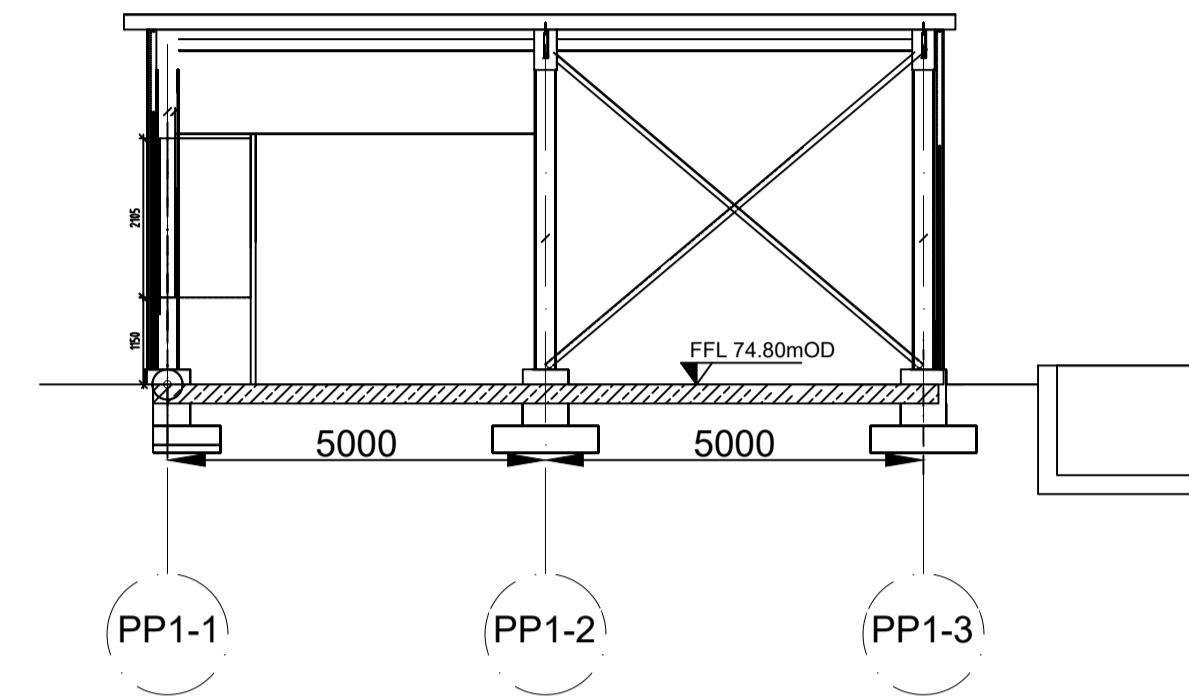



Elevation S4

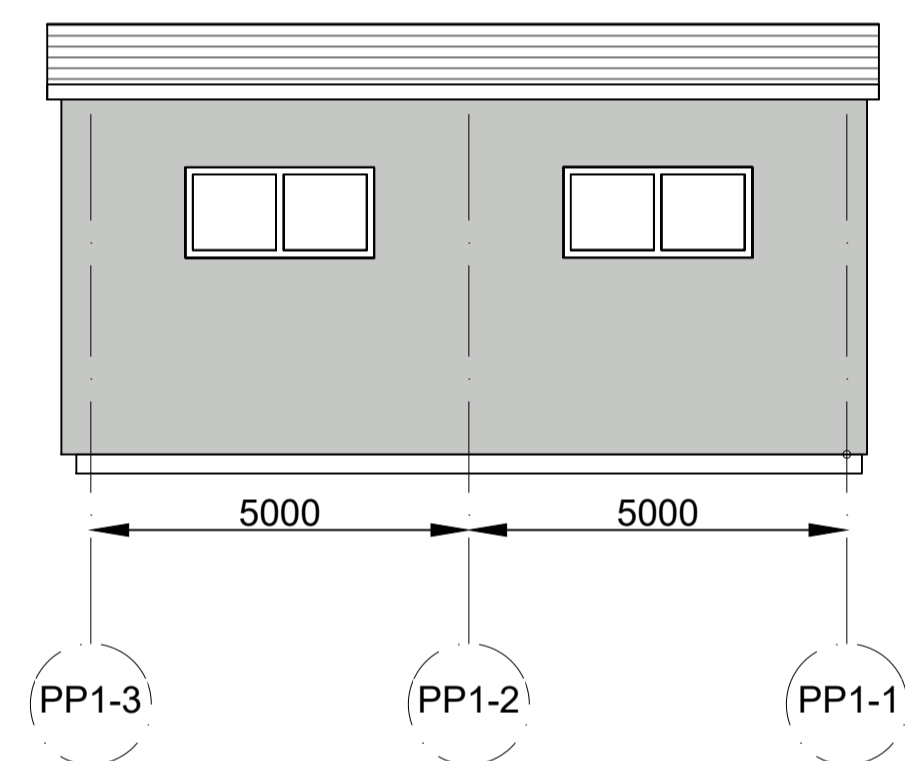

Elevation S3

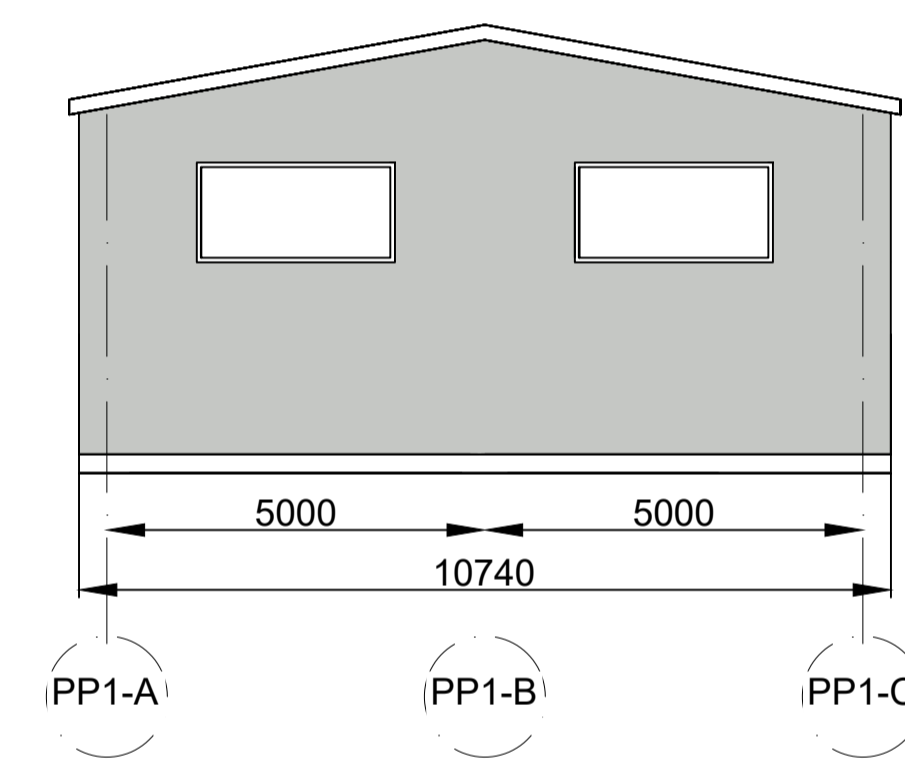

Plan

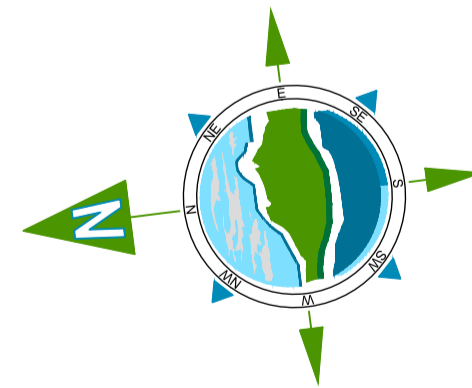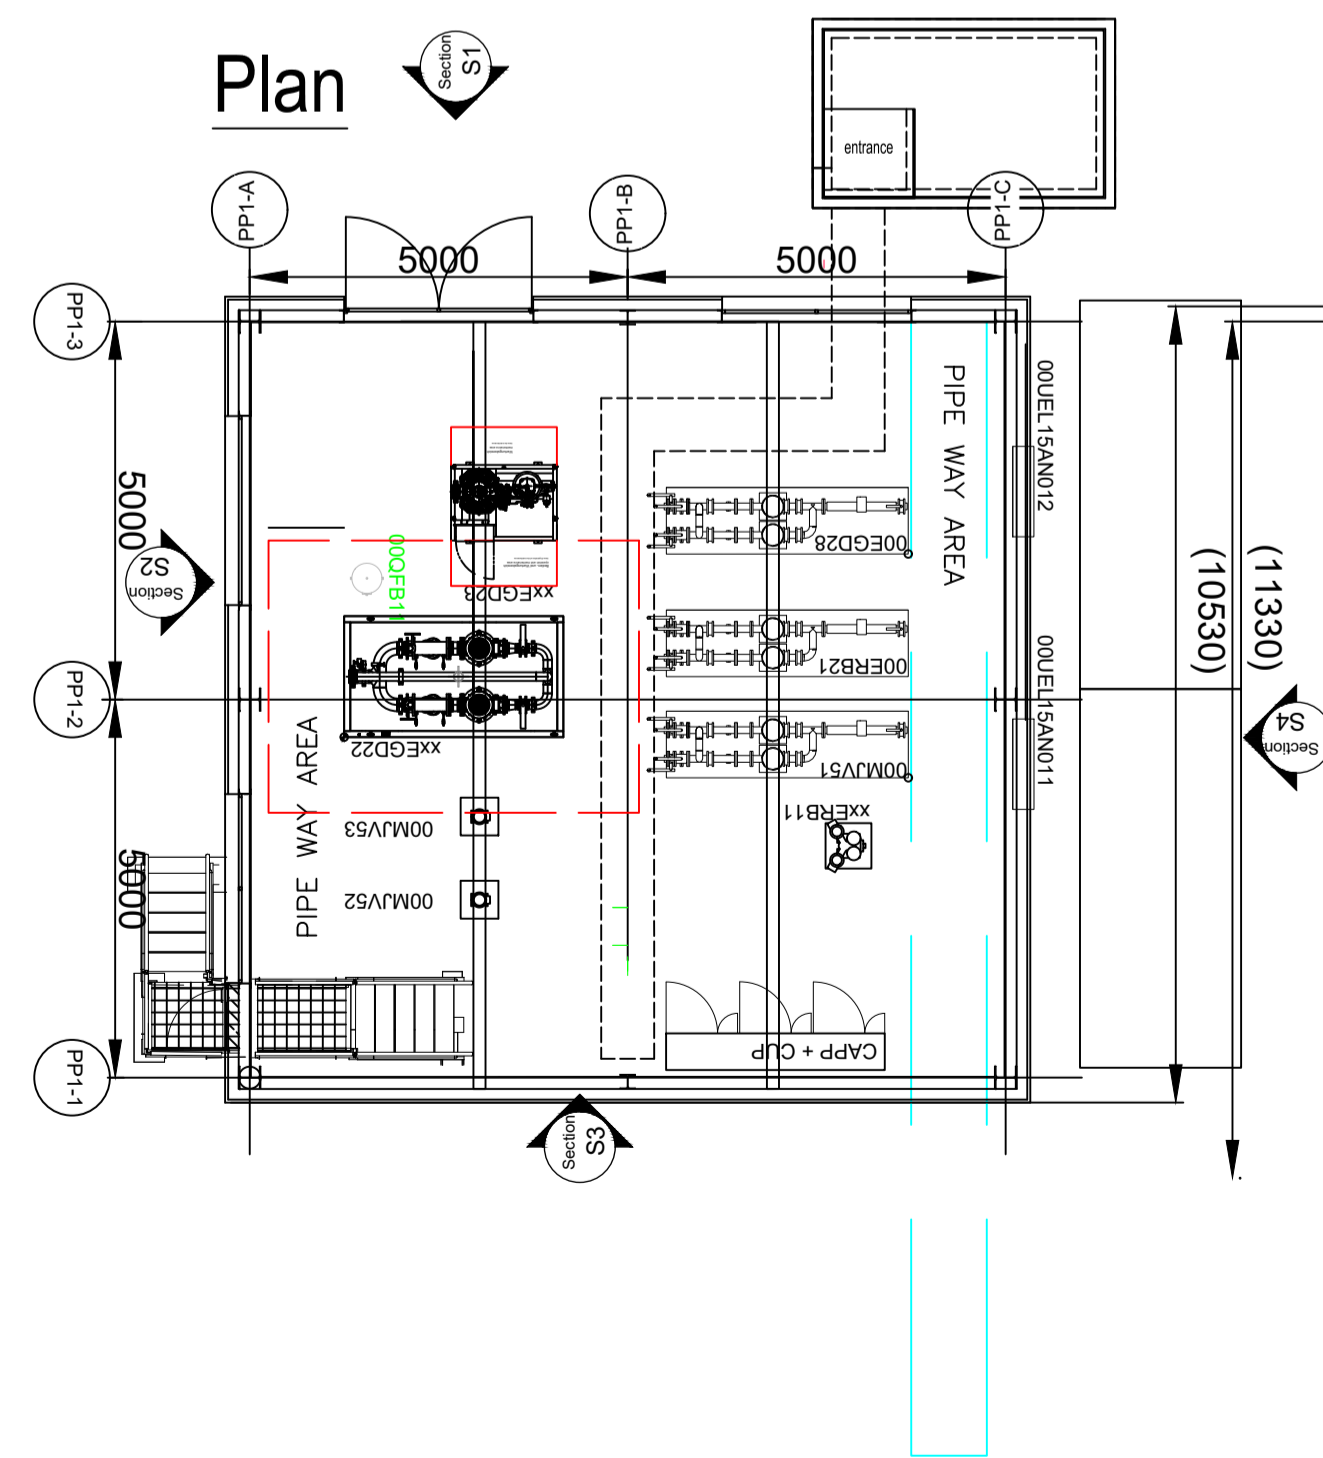

As agreed with South Dublin County Council in the pre-application consultation meeting the final finishes, including cladding materials and colour codes, will be agreed with the Council post planning through planning condition. Greener Ideas Limited will ensure only Council approved finishes are applied on site.

Rev	Date	Description	By	Chkd.
A	02.03.22	PLANNING ISSUE	MN	MMcC

Client:

Project: **PROFILE PARK POWER PLANT**

Title: **TANK FARM BUILDING PLAN, ELEVATIONS & SECTION**

Scale @ A1: 1:100

Prepared by:	Checked:	Date:
M. Nolan	M. McCarthy	March 2022
Project Director:	S. Tinnelly	
Drawing Status:	Planning	

TOBIN
CONSULTING ENGINEERS

Block 10-4, Blanchardstown Corporate Park,
Dublin 15, Ireland.
tel: +353-(0)1-8030406
fax: +353-(0)1-8030409
e-mail: dublin@tobin.ie
www.tobin.ie

Tobin Consulting Engineers will not be liable for any use of this document for any purpose other than that for which it was originally prepared and issued. Except where specifically stated explicitly agreed in writing by Tobin Consulting Engineers, its copyright holder, no part of this document may be reproduced or transmitted in any form and this document shall not be relied upon by any third party for any purpose.

Drawing No.: **11069-2047** Revision: **A**