



Note: Fire Pump Station, Water Treatment Unit, Blackstart Unit and FM200 are all housed in identical Steel Storage Containers.

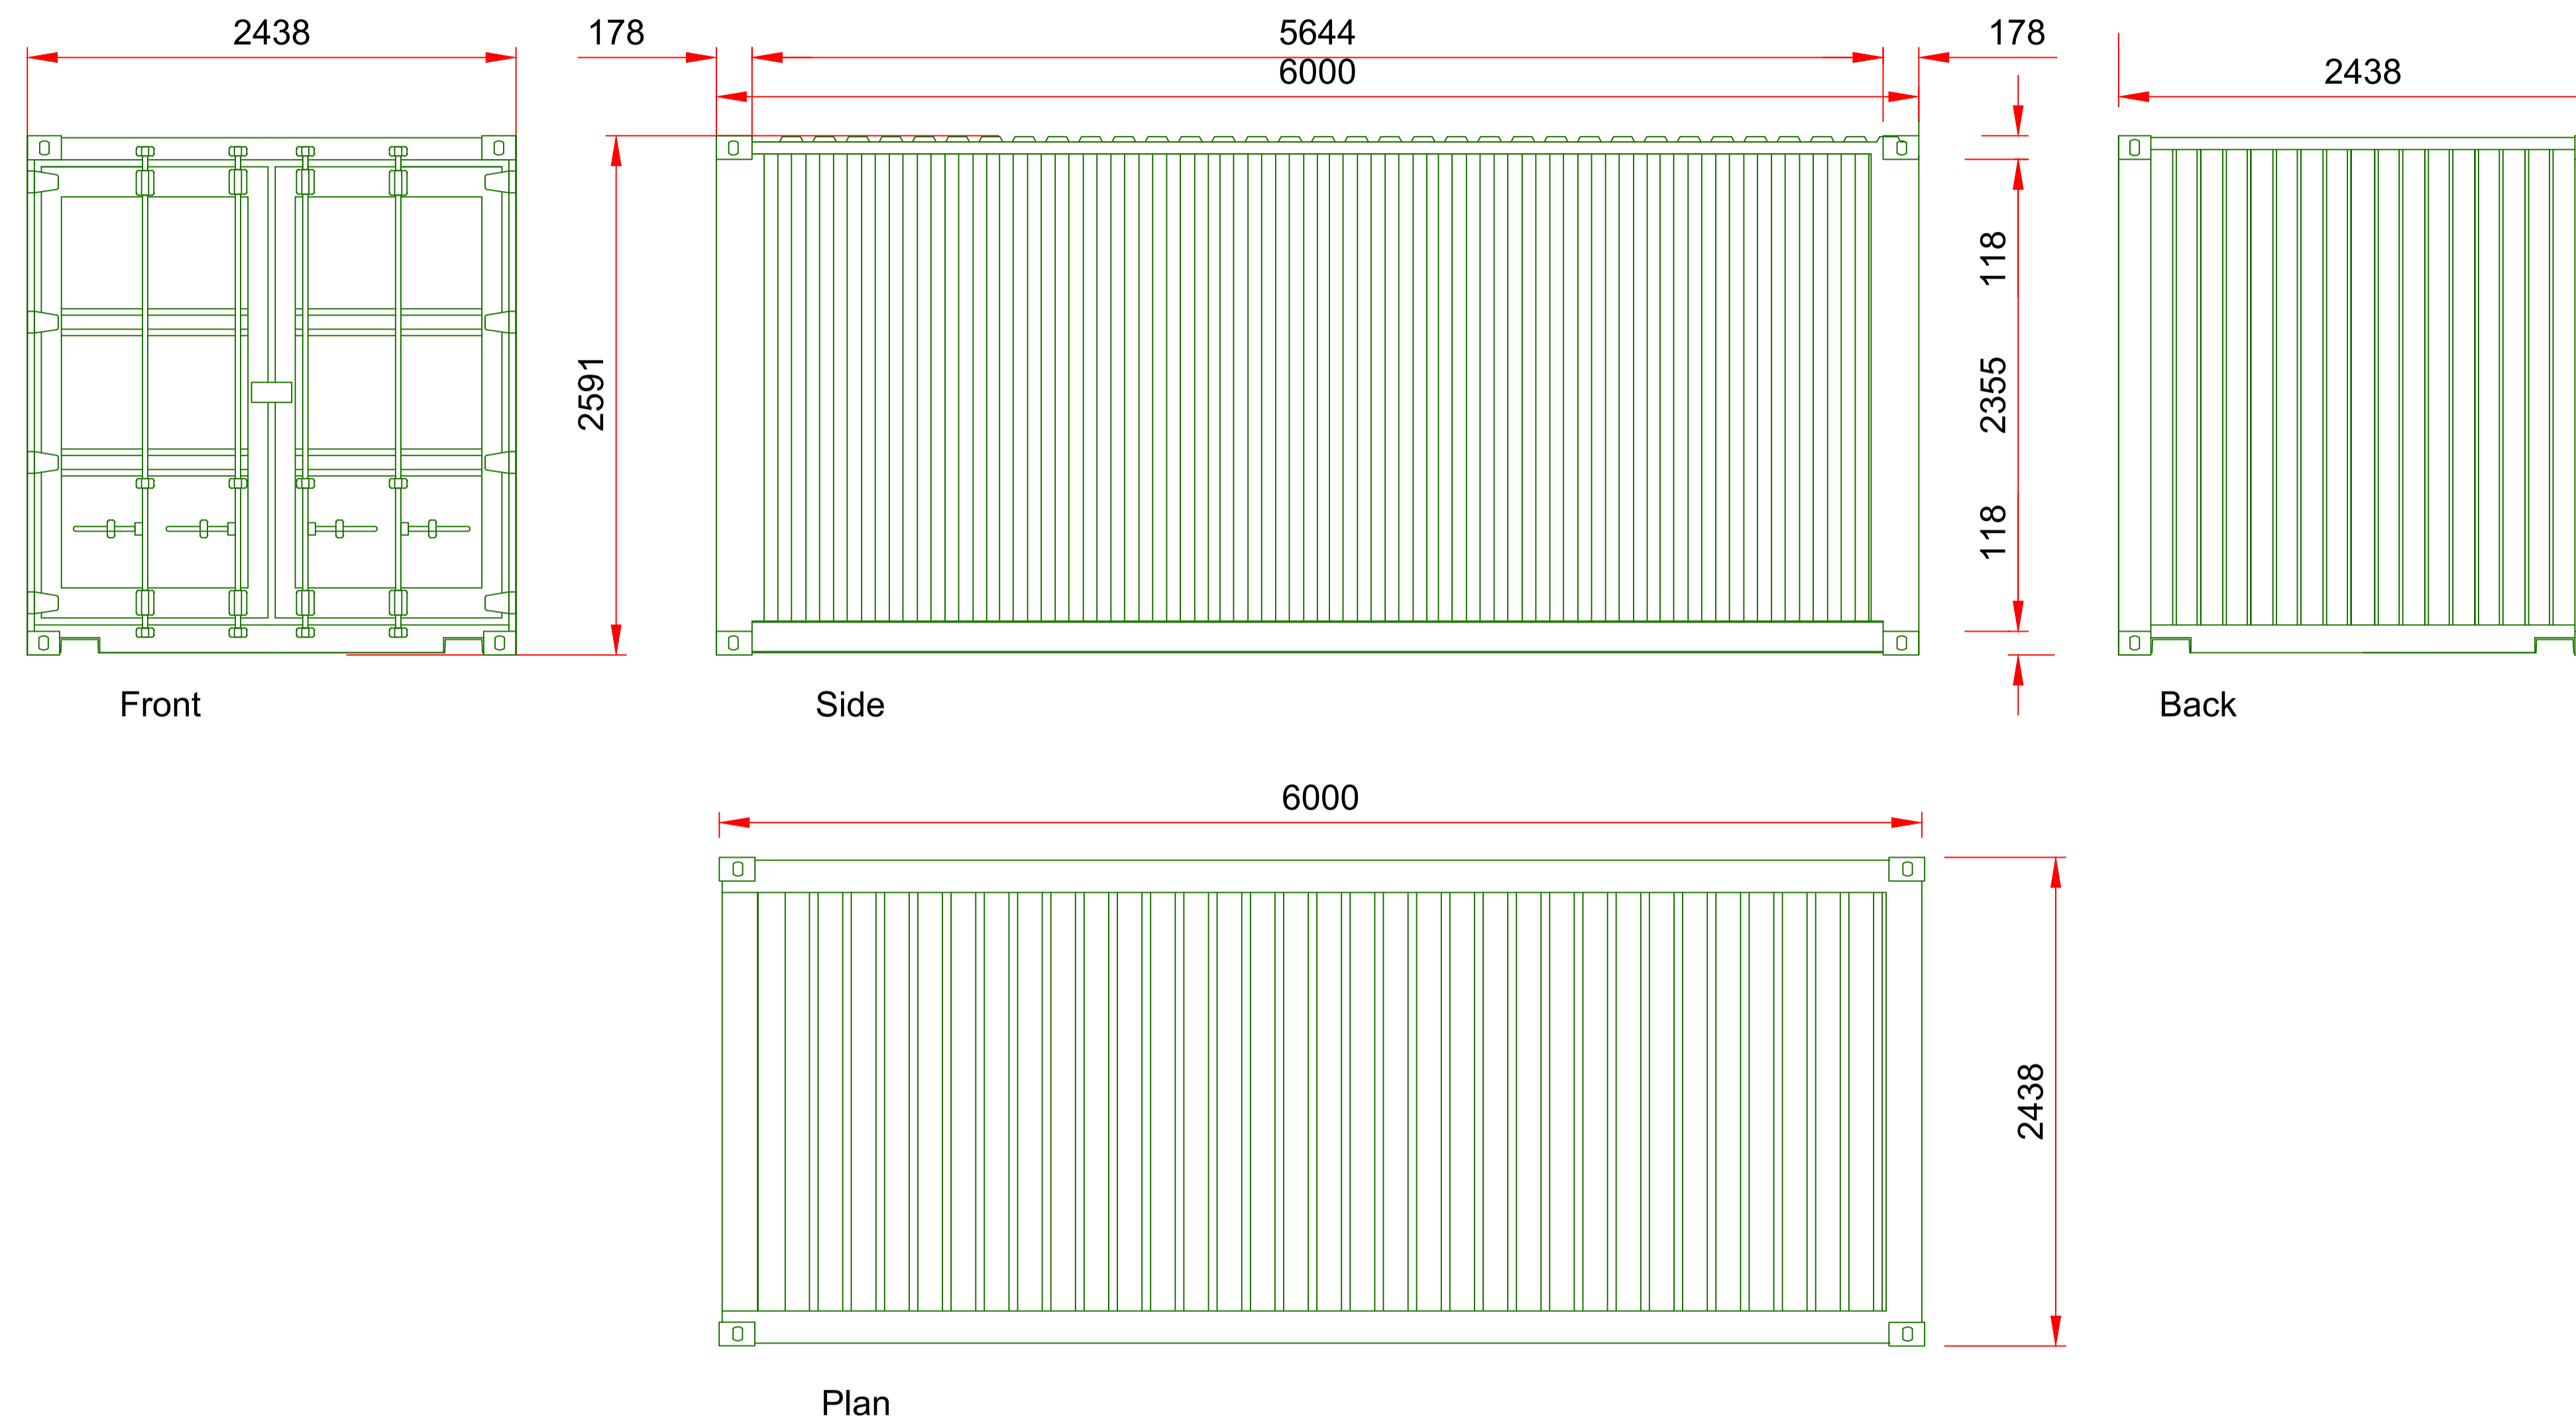

STEEL STORAGE CONTAINER ELEVATIONS AND PLAN

Rev	Date	Description	By	Chkd.
A	02.03.22	PLANNING ISSUE	MN	MMc

Client: 

Project: **PROFILE PARK POWER PLANT**

Title: **FIRE PUMP STATION, WATER TREATMENT UNIT, BLACKSTART UNIT & FM200 PLAN, ELEVATIONS & SECTION**

Scale @ A1:	1:25	
Prepared by:	Checked:	Date:
M. Nolan	M. McCarthy	March 2022
Project Director:	S. Tinnelly	
Drawing Status:	Planning	

TOBIN
CONSULTING ENGINEERS

Block 10-4, Blanchardstown Corporate Park,
Dublin 15, Ireland.
tel: +353-(0)1-8030406
fax: +353-(0)1-8030409
e-mail: dublin@tobin.ie
www.tobin.ie

TOBIN Consulting Engineers will not be liable for any use of this document for any purpose other than that for which it was originally prepared and approved. Except where specifically stated otherwise, all rights are reserved. TOBIN Consulting Engineers, its copyright holder, its staff or this document may be reproduced or transmitted in any form and this document shall not be relied upon by any third party for any purpose.

Drawing No.: **11069-2049** Revision: **A**