



ELEVATION

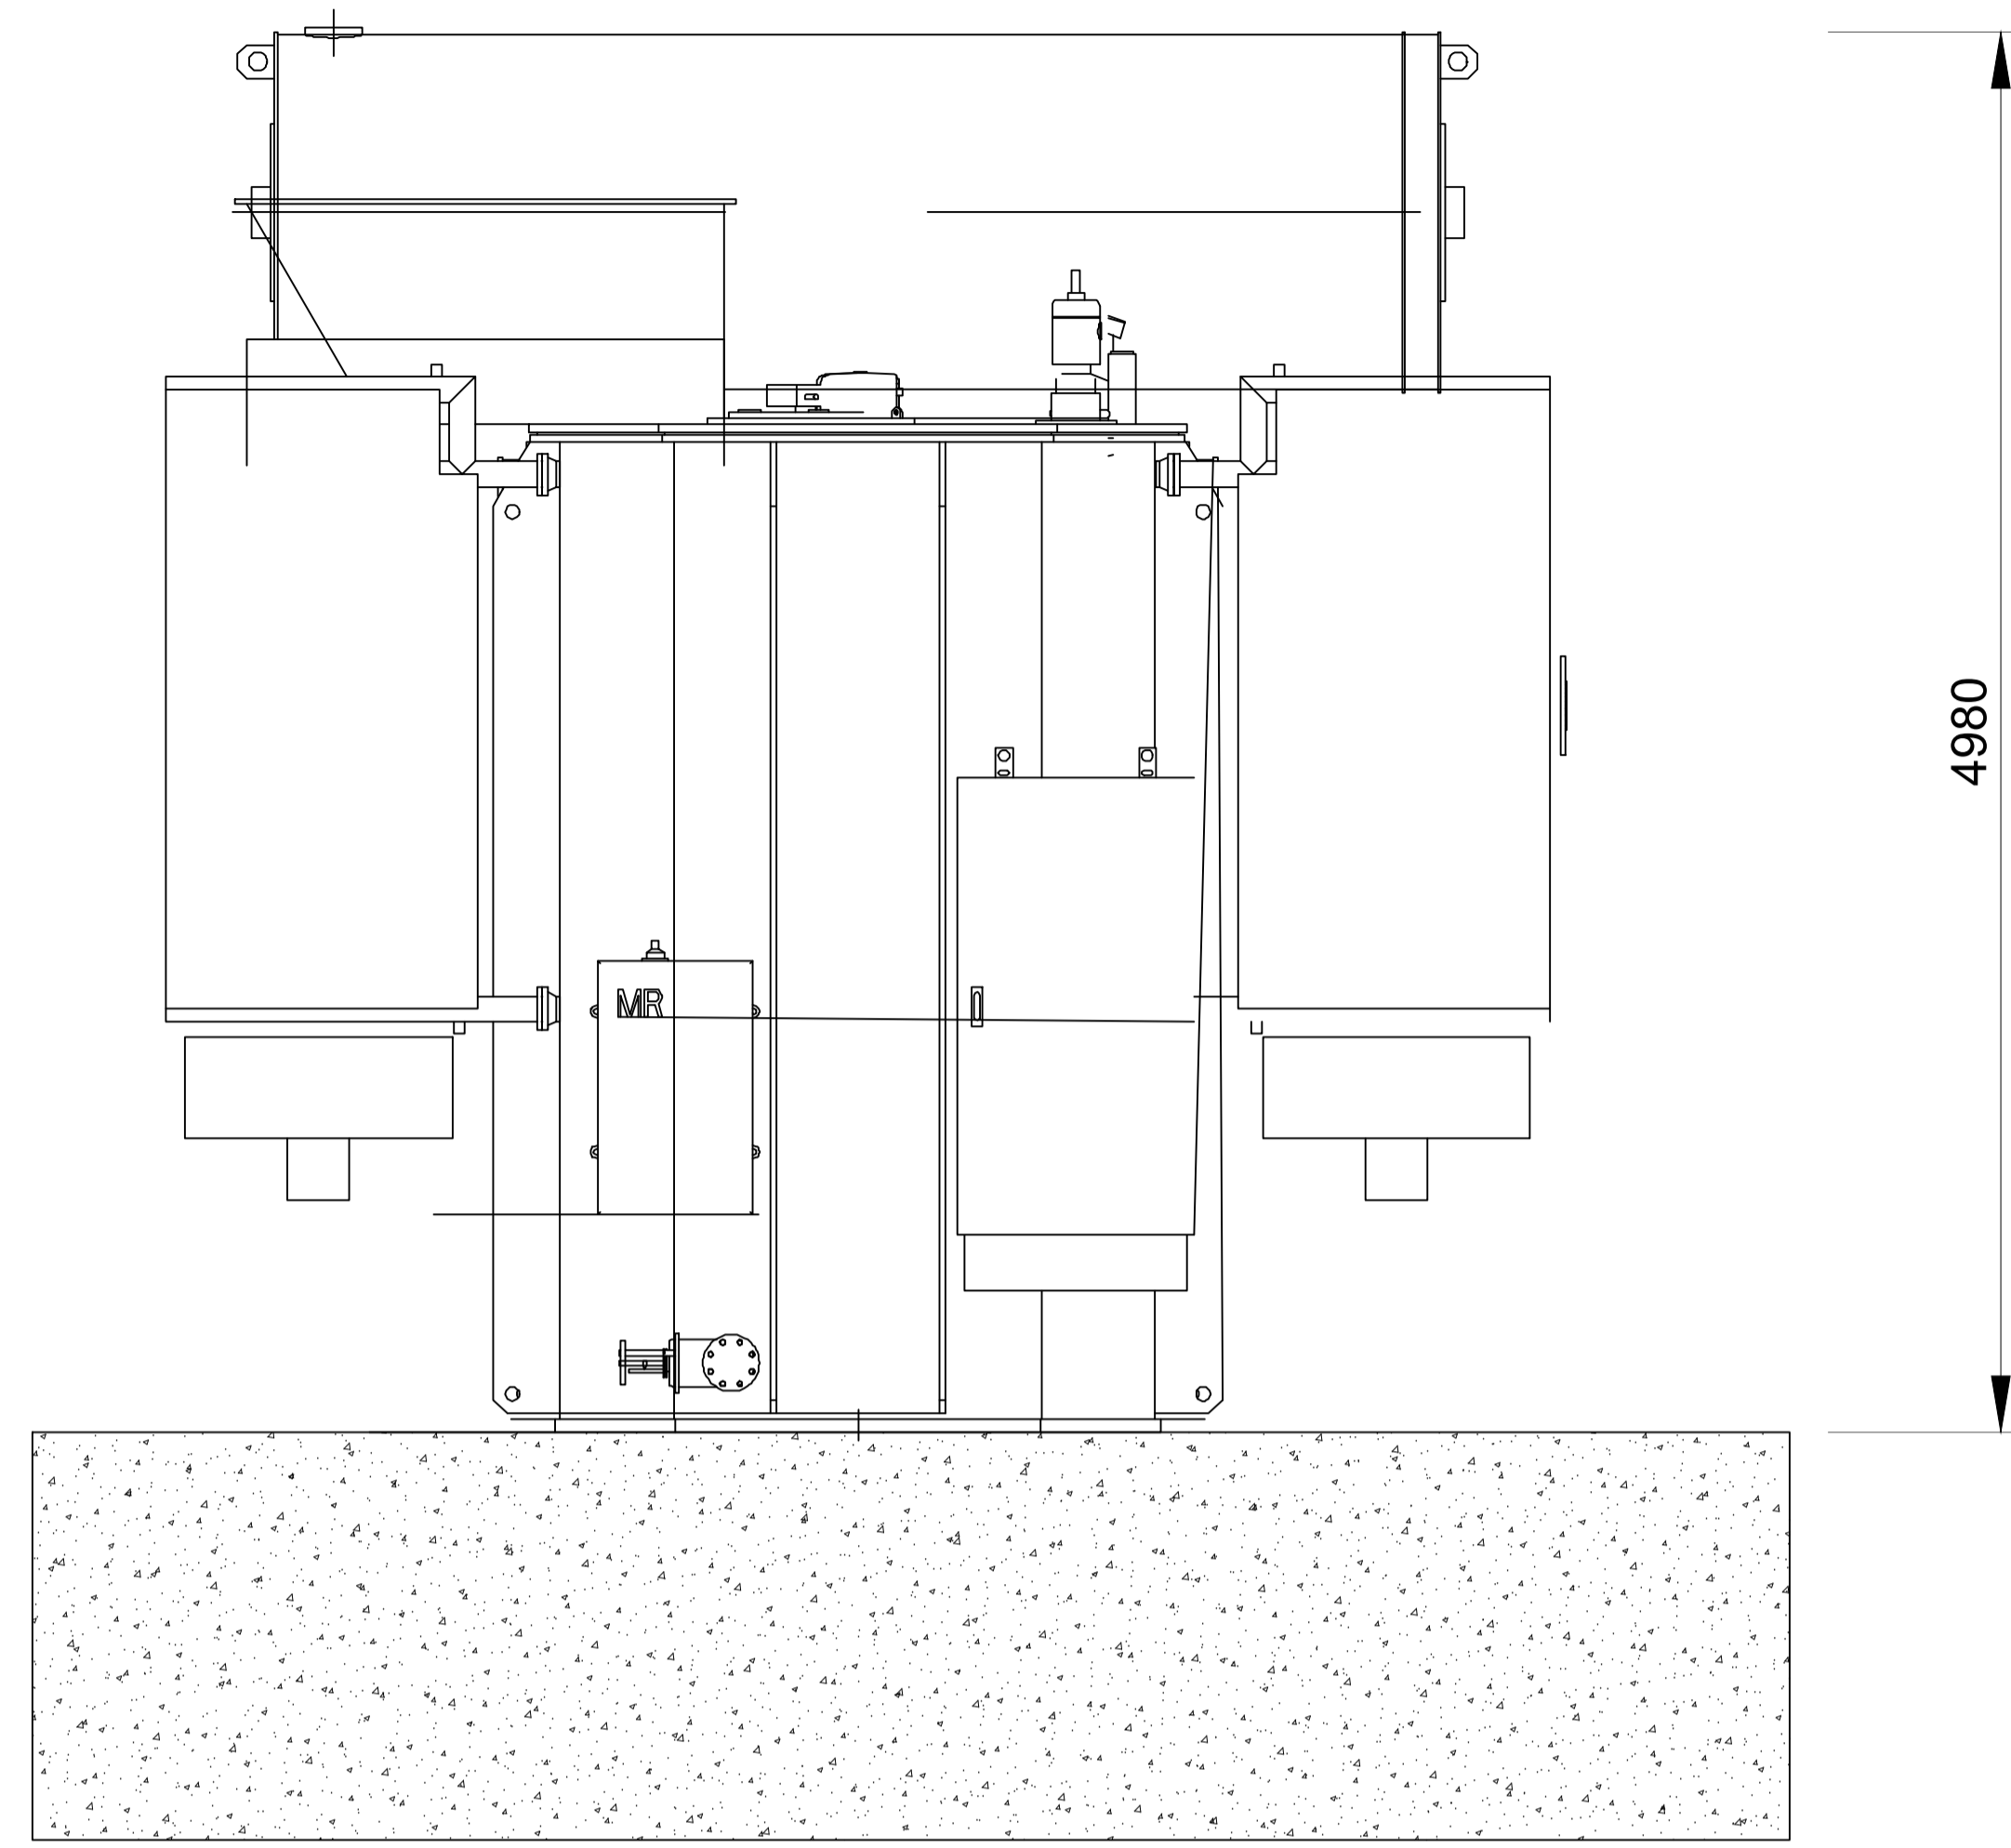


ELEVATION

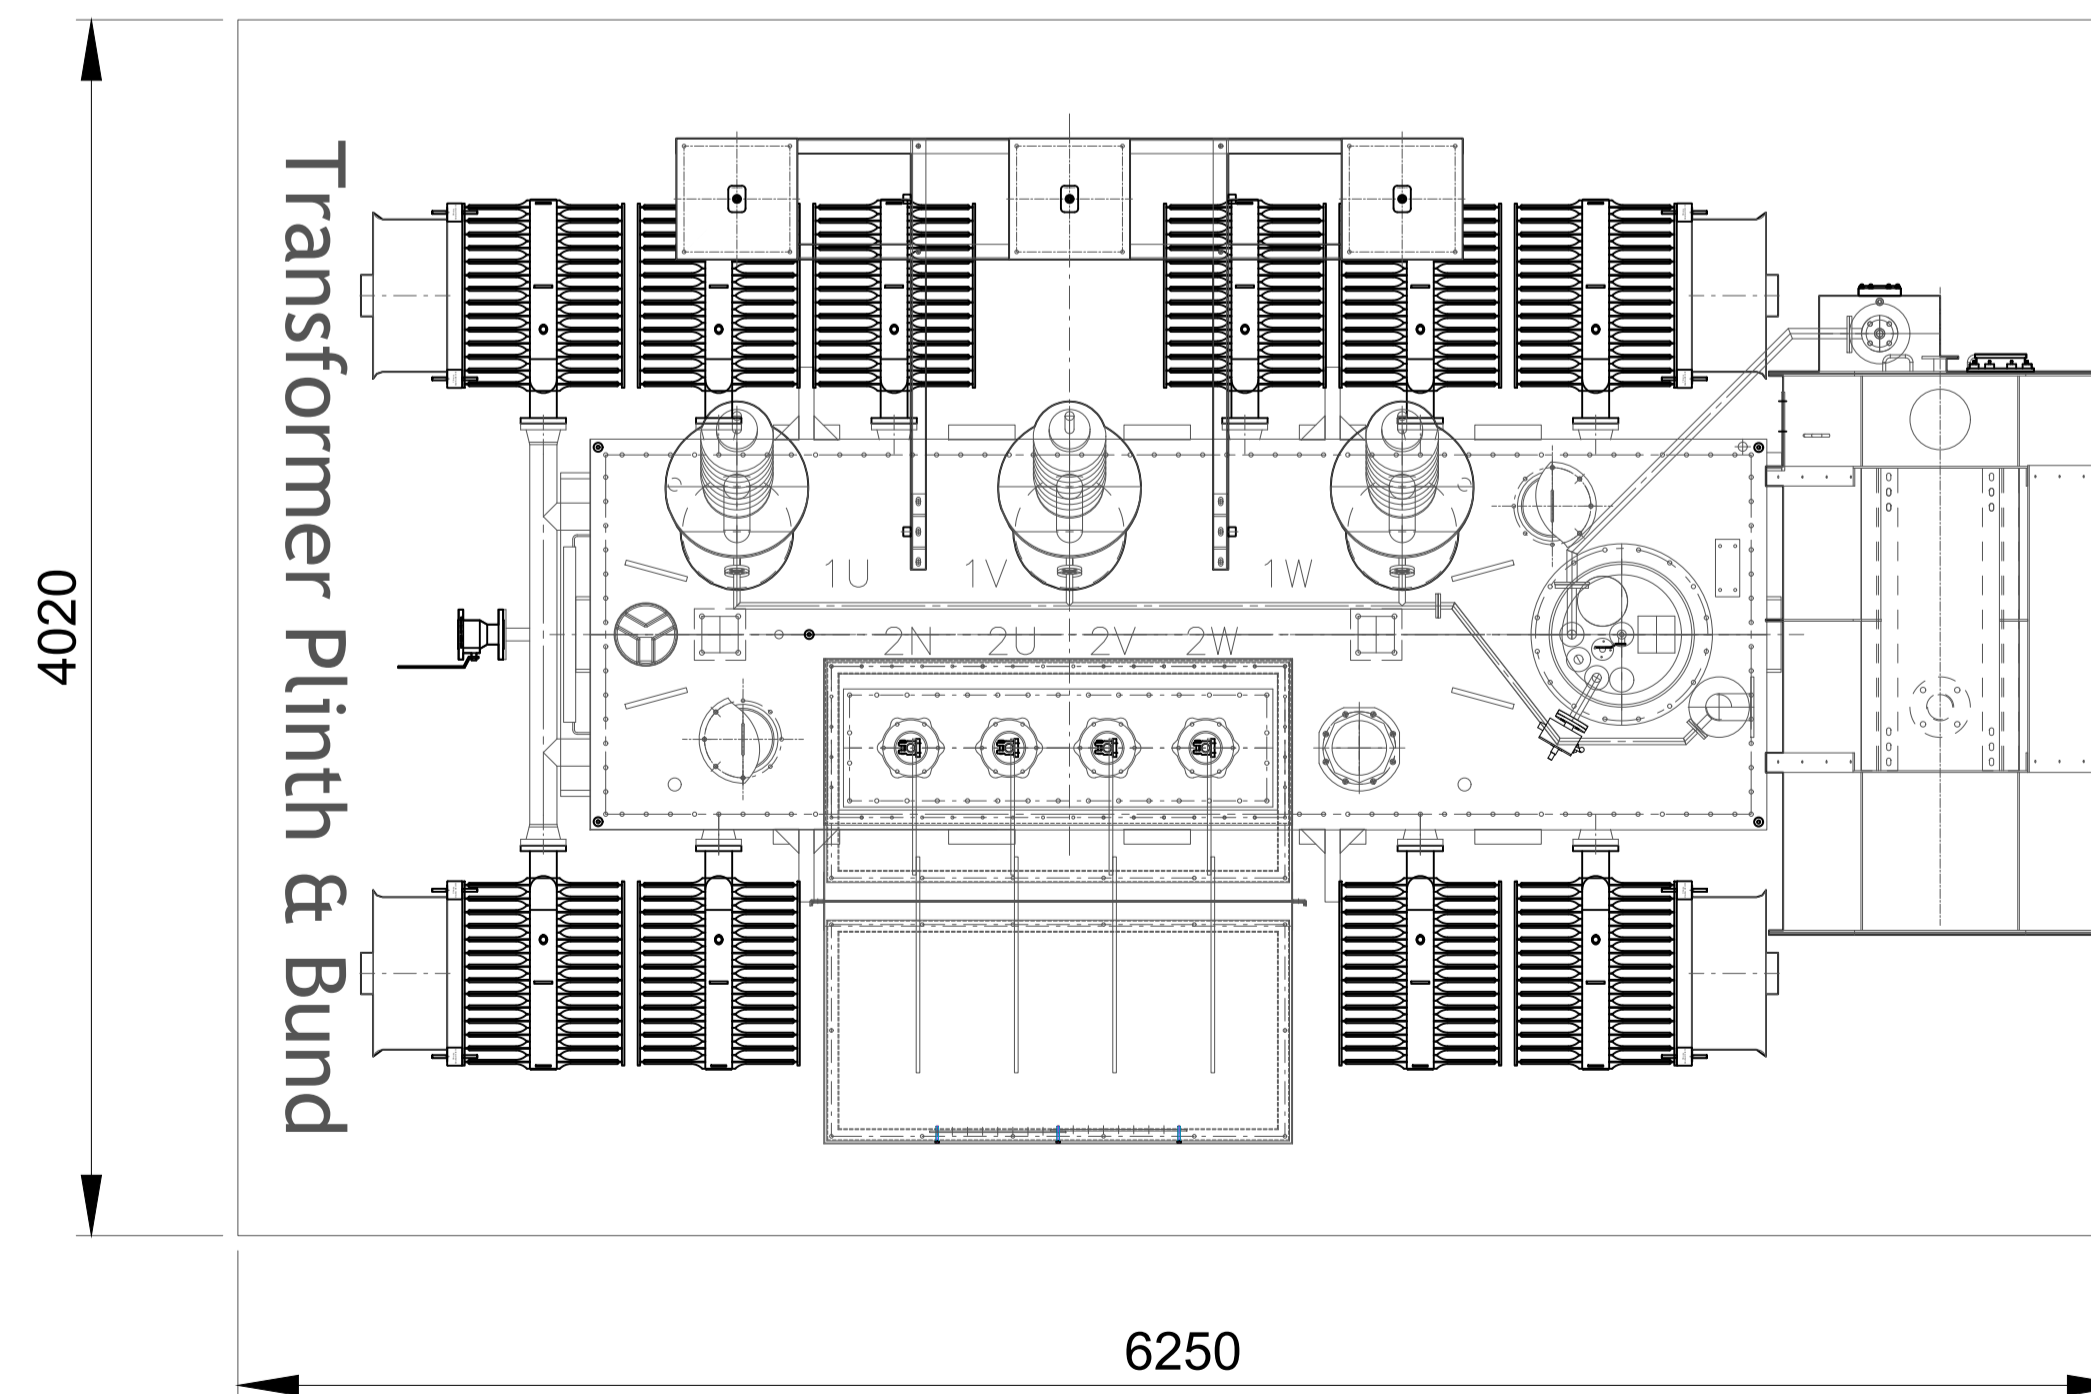

PLAN

Rev	Date	Description	By	Chkd.
A	02.03.21	PLANNING ISSUE	MN	MMcC

Client: 

Project: **PROFILE PARK POWER PLANT**

Title: **TRANSFORMER TYPICAL DETAILS**

Scale @ A1:	1:50	
Prepared by:	Checked:	Date:
M. Nolan	M. McCarthy	March 2022
Project Director:	S. Tinnelly	
Drawing Status:	Planning	

TOBIN
CONSULTING ENGINEERS

Block 10-4, Blanchardstown Corporate Park,
Dublin 15, Ireland.
tel: +353-(0)1-8030406
fax: +353-(0)1-8030409
e-mail: dublin@tobin.ie
www.tobin.ie

TOBIN Consulting Engineers will not be liable for any use of this document for any purpose other than that for which it was originally prepared and approved. Except where specifically stated explicitly agreed in writing by TOBIN Consulting Engineers, copyright in this document shall not be reproduced or transmitted in any form and this document shall not be relied upon by any third party for any purpose.

Drawing No.: **11069-2051** Revision: **A**