



1. Figured Dimensions Only to be Taken from this Drawing. All Dimensions to be Checked on Site.
2. This drawing to be read in Conjunction with all other Architectural & Engineering drawings & all other relevant drawings & Specification.

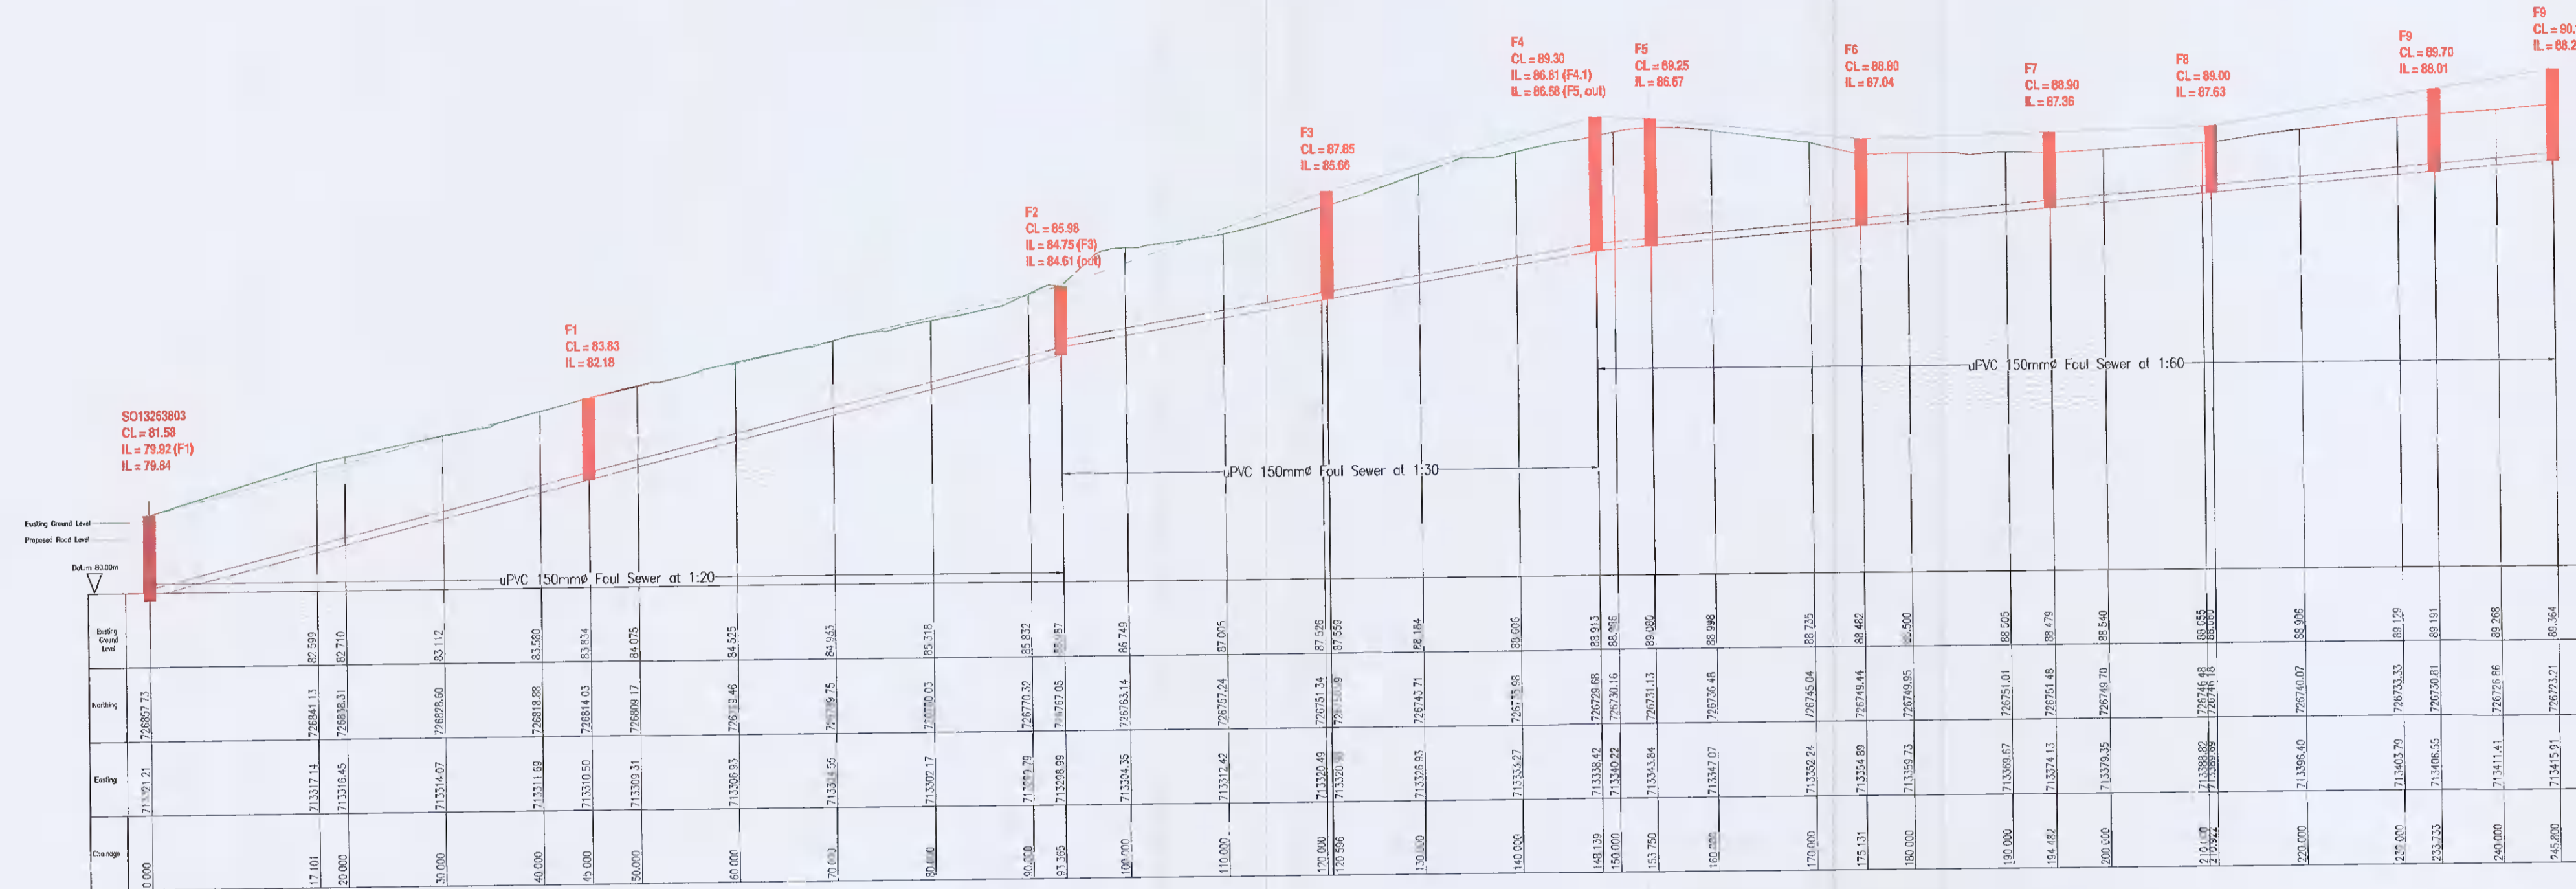

FOUL SEWER F1 TO F9 LONGITUDINAL SECTION  
Scale 1:500 Horizontal, 1:100 Vertical

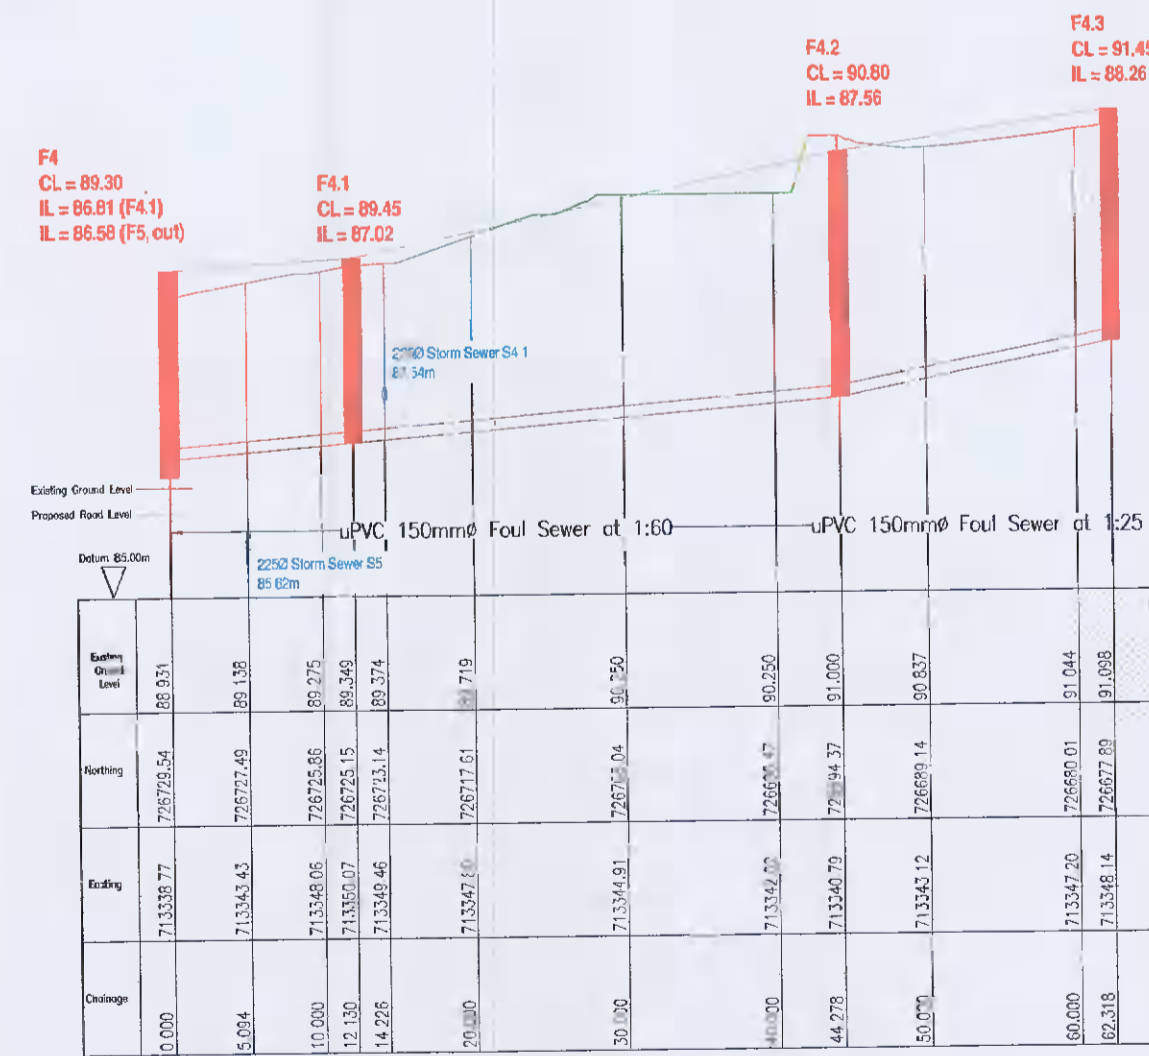

FOUL SEWER F4 TO F4.3 LONGITUDINAL SECTION  
Scale 1:500 Horizontal, 1:100 Vertical



OS Ordnance Survey Ireland License No. CLK52010610  
© Ordnance Survey Ireland & Government of Ireland

Rev	Date	By	Revision
C	11/09/22	ML	Layout Revised as per meeting on 16/11/21. Foul drainage layout and levels revised slightly.
B	16/12/20	ML	Foul drainage layout revised.

**FOR PLANNING**

Client / Architect  
**Ms Brenda Weir**

Project  
**Rookwood, Ballyboden**

Drawing Title  
**Proposed Foul Drainage Longitudinal Sections**

THIS DOCUMENT IS THE PROPERTY OF GORDON WHITE CONSULTING ENGINEERS. THE DESIGN RECOMMENDATIONS HEREIN IS STRICTLY CONFIDENTIAL. THIS DOCUMENT IS NOT TO BE USED, REPRODUCED, DISCLOSED OR OTHERWISE MADE PUBLIC IN ANY MANNER WITHOUT THE PRIOR WRITTEN PERMISSION IN WRITING OF GORDON WHITE CONSULTING ENGINEERS.  
© PROPERTY OF GORDON WHITE CONSULTING ENGINEERS

**GORDON WHITE CONSULTING ENGINEERS**  
1st Floor, 8 Marrow Hill, Lisha Drive  
Clonsilla Business Campus  
Dublin 14, D14 Y16P  
Tel: 01 476 8395  
Mobile: 089 232 6295  
Email: info@gwe.ie  
www.gwe.ie

Drawn By	ML	Scale	As shown
Latest Rev. by		Date	20 Nov '20
Eng No	G1162-21		G