


BASEMENT BLOCK E-Drainage Layout.
SCALE 1:250

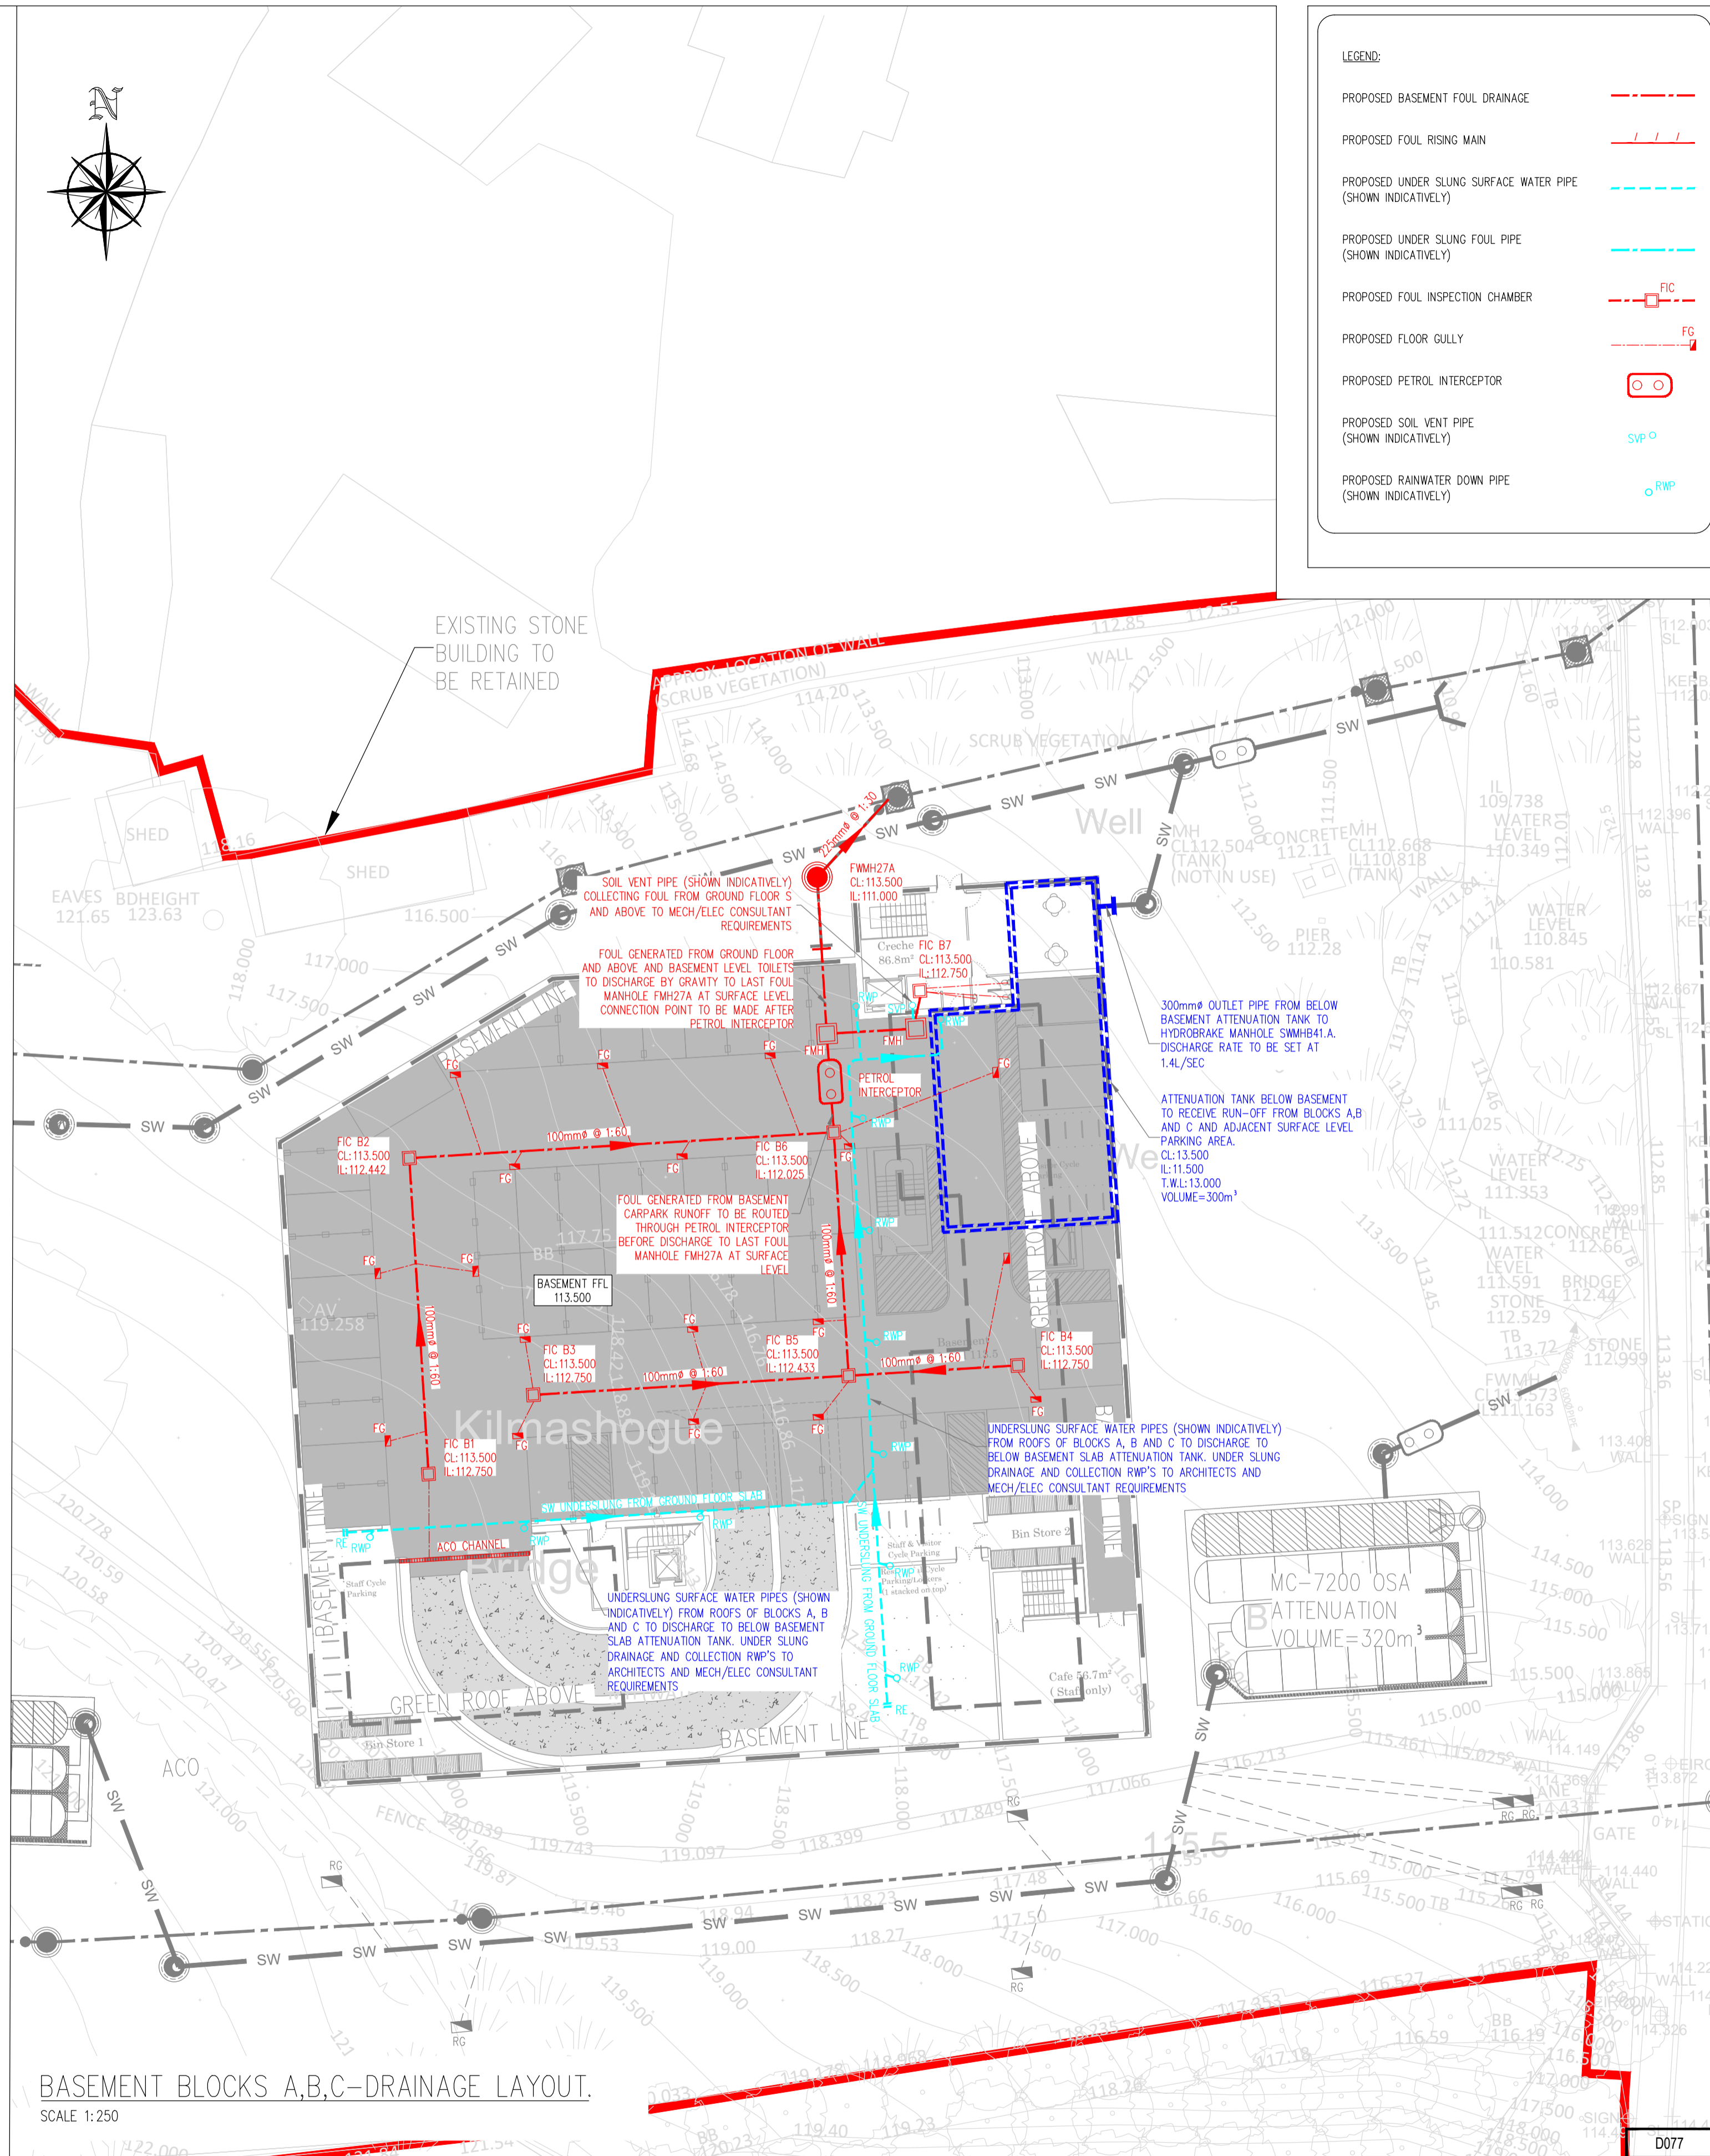

BASEMENT BLOCKS A,B,C-Drainage Layout.
SCALE 1:250

LEGEND:

PROPOSED BASEMENT FOUL DRAINAGE	---
PROPOSED FOUL RISING MAIN	—
PROPOSED UNDER SLUNG SURFACE WATER PIPE (SHOWN INDICATIVELY)	- - - -
PROPOSED UNDER SLUNG FOUL PIPE (SHOWN INDICATIVELY)	- - - -
PROPOSED FOUL INSPECTION CHAMBER	FIC
PROPOSED FLOOR GULLY	FG
PROPOSED PETROL INTERCEPTOR	PI
PROPOSED SOIL VENT PIPE (SHOWN INDICATIVELY)	SV
PROPOSED RAINWATER DOWN PIPE (SHOWN INDICATIVELY)	RWP

PLANNING DRAWING
NOT FOR CONSTRUCTION THIS DRAWING HAS BEEN ISSUED FOR INFORMATION PURPOSES ONLY AND MUST NOT BE USED FOR CONSTRUCTION UNDER ANY CIRCUMSTANCES

- NOTES**
- For setting out refer to Architect's drawings.
 - This drawing to be read in conjunction with all other Architectural and Engineering drawings and all other relevant drawings and Specifications.
 - DO NOT SCALE THIS DRAWING. Use figured dimensions only.
 - No part of this document may be reproduced or transmitted in any form or stored in any retrieval system of any nature without the written permission as copyright holder except as agreed for use on the project for which the document was originally issued.
 - Ordnance Survey Ireland Licence Number EN 0074022

Rev. No.	Date	REVISION NOTE	Dm. By	Chkd. By
P1	03.03.2022	ISSUED FOR PLANNING STAGE 3	JS	OS

Architect	JFOC Architects
Project	Edmondstown Lands
Title	Basement Drainage Layouts
Dwg. No.	EDM-CSC-GF-XX-DR-C-0030
Date	OCT 2021
Dm. by	JS
Chkd. by	OS
Apprd. by	OS
Scale	1:250@A1
Revision	P1

CS Consulting Group
DUBLIN | LONDON | LIMERICK

Head Office
19-22 Dame Street, Dublin 2.
T: +353 (0)1 5480863
e: info@csconsulting.ie
www.csconsulting.ie

Quality I.S. EN ISO 9001:2008
Environment I.S. EN ISO 14001:2004
Energy I.S. EN ISO 50001:2011
NSAI Certified Health & Safety OHSAS 18001:2007