



SPACE ALLOCATION LEGEND

Color	Room/Community Area
Blue	BREAK ROOM/COMMUNITY AREA
Light Blue	CIRCULATION
Light Green	CONFERENCE
Light Yellow	CRAFT/DUCCP GALLERIES
Light Purple	DATA CENTER
Light Orange	IDF
Light Red	LOBBY
Light Blue-Gray	MMR/POE
Light Green-Gray	NON CRITICAL SUPPORT
Light Yellow-Gray	OFFICE (CUSTOMER)
Light Purple-Gray	OFFICE (VDC)
Light Orange-Gray	SHIPPING/RECEIVING
Light Red-Gray	STORAGE (CUSTOMER)
Light Blue-Gray	STORAGE (VDC)

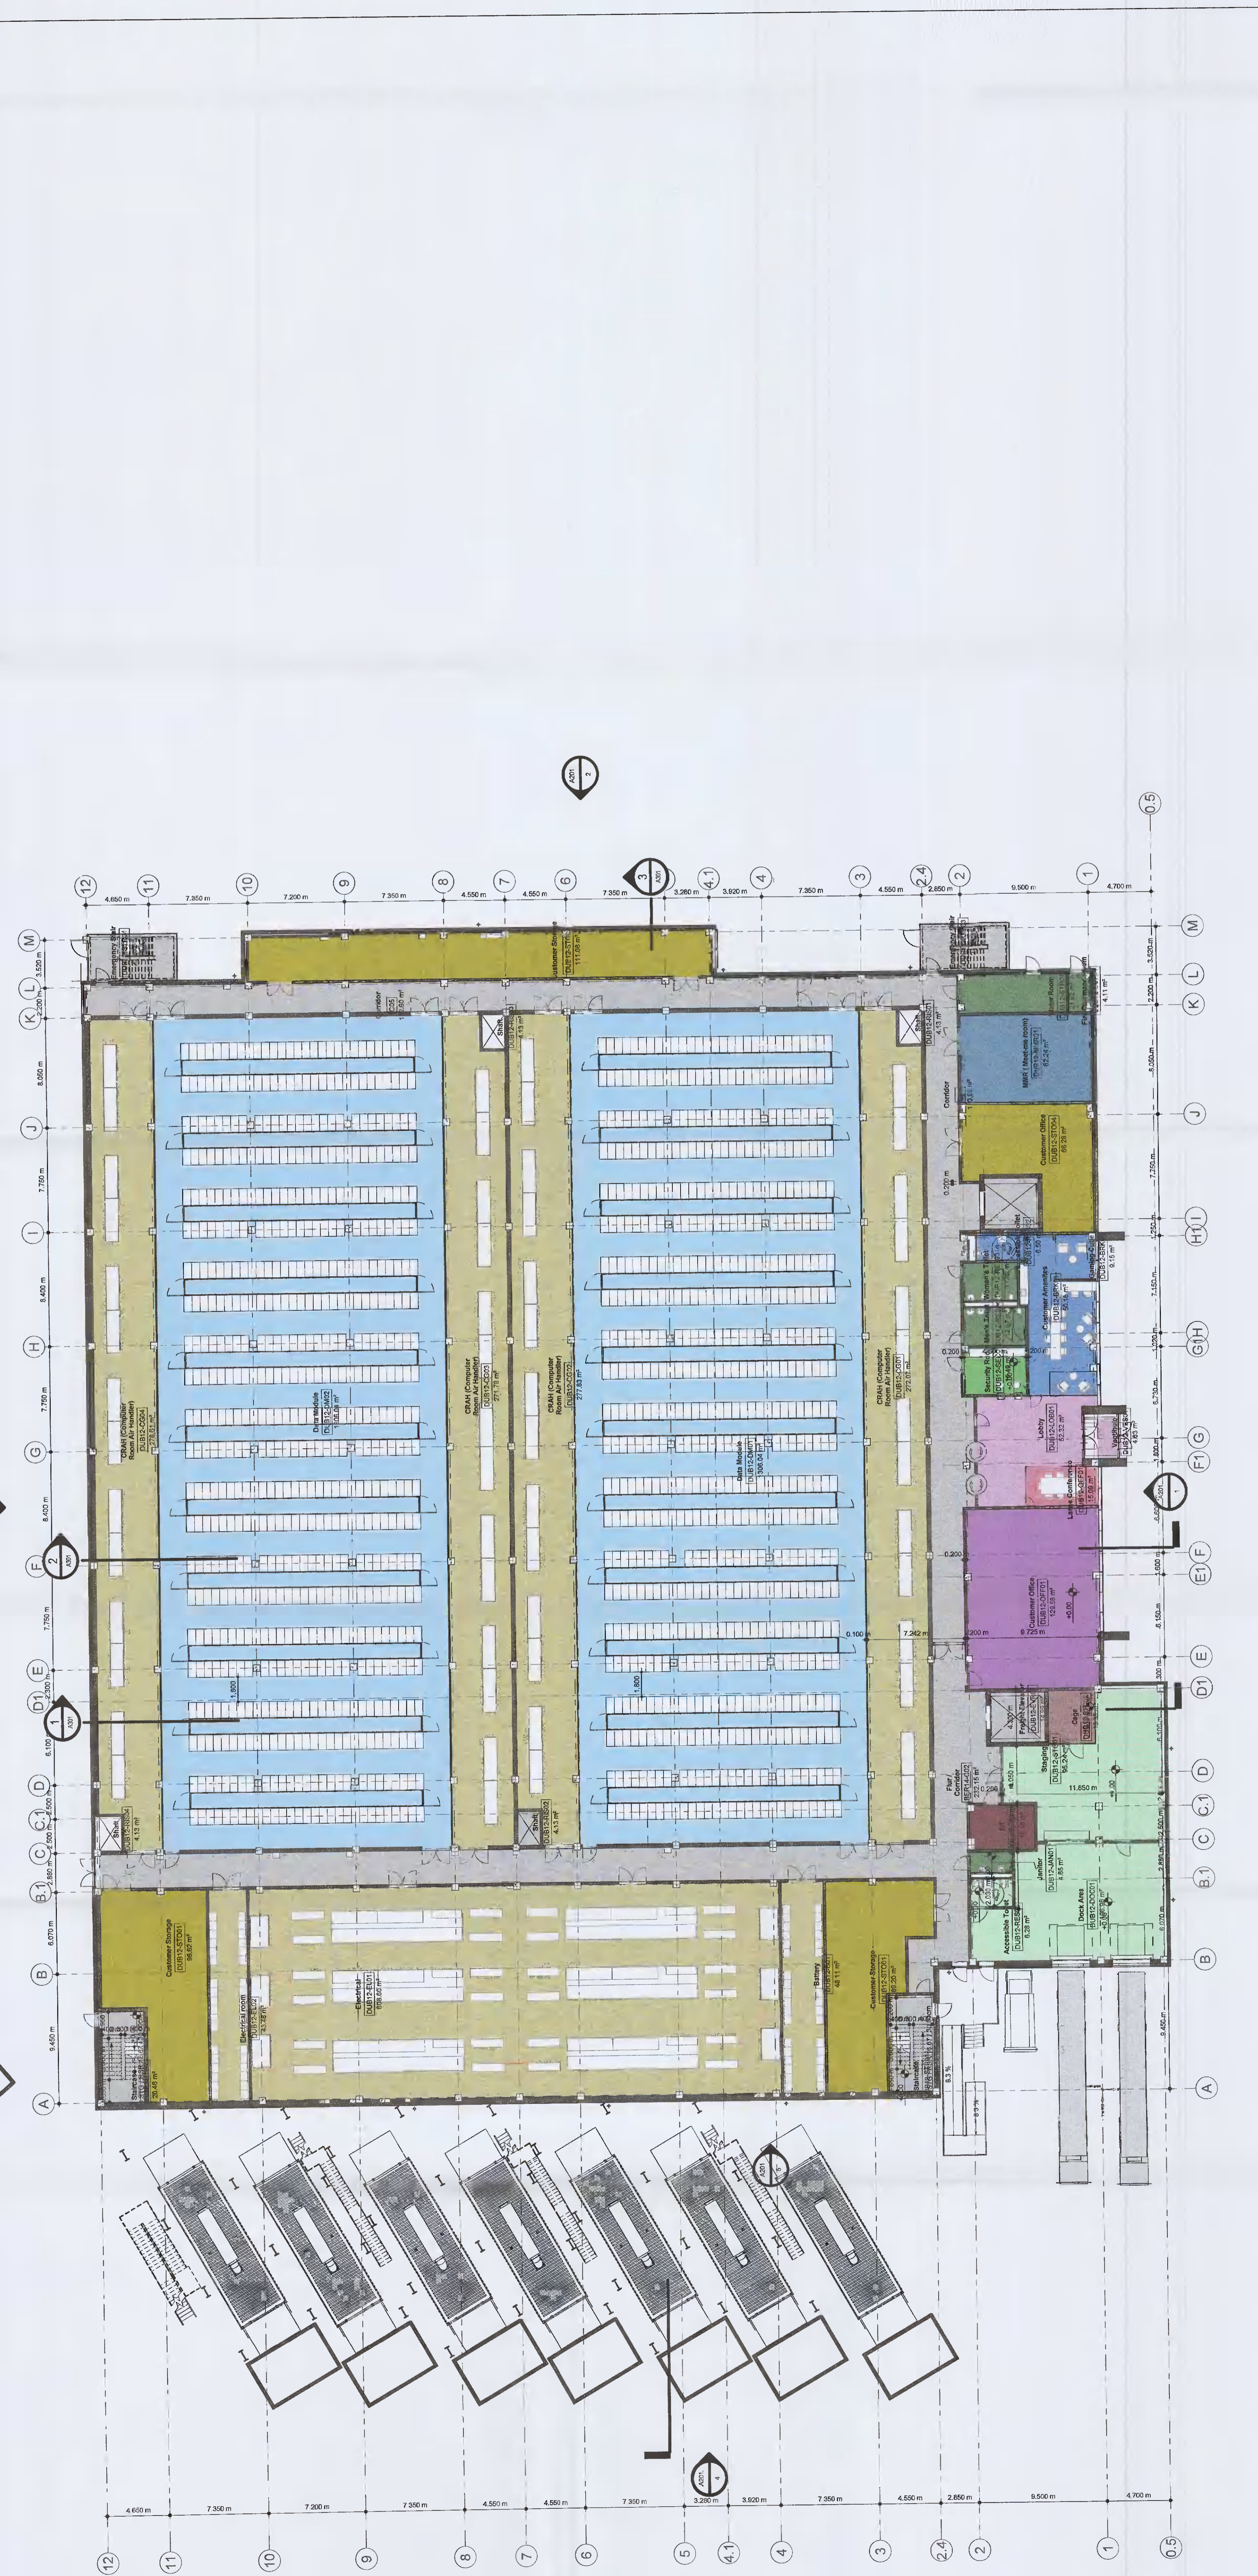

1 DUB12 OVERALL GROUND FLOOR PLAN

 SCALE: 1:200

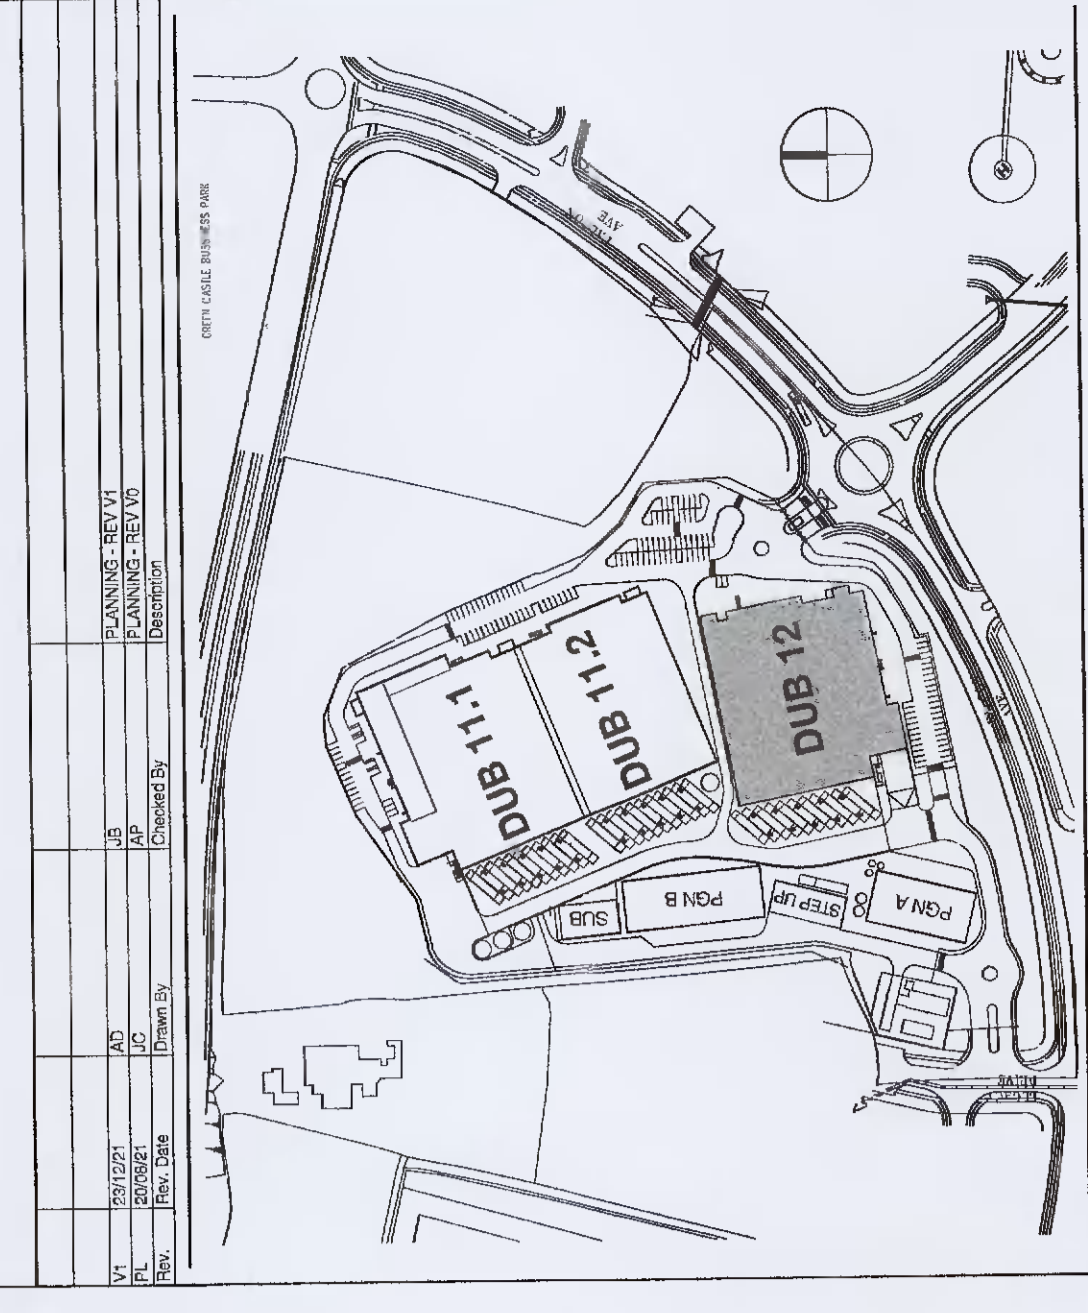

VANTAGE

 VENTURE PARTNERS

BURNS MEDONNELL

 ARCHITECTS

Hyphen

 INTERIOR ARCHITECTS

PROJECT APPROVED BY:

 APPROVED BY: J. Maguire

 APPROVED BY: J. Maguire

PROJECT: DUB12 - GROUND FLOOR PLAN

 DATE: 23/12/21

DRAWING NO: A110

PLANNING SUBMITTAL

 NOT FOR

 CONSTRUCTION