


FINISHES LEGEND


REF	MATERIAL
A	Insulated Metal Sandwich Panel - Tronolium FTV
B	Insulated Metal Sandwich Panel - Tronolium FTV
C	Insulated Metal Sandwich Panel - Tronolium FTV
D	Insulated Metal Sandwich Panel - Tronolium FTV
E	Insulated Metal Sandwich Panel - Tronolium FTV
F	Insulated Metal Sandwich Panel - Tronolium FTV
G	Insulated Metal Sandwich Panel - Tronolium FTV
H	Insulated Metal Sandwich Panel - Tronolium FTV
I	Insulated Metal Sandwich Panel - Tronolium FTV
J	Pre-preg carbon fibre reinforced plastic
K	Pre-preg carbon fibre reinforced plastic
L	Pre-preg carbon fibre reinforced plastic
M	Pre-preg carbon fibre reinforced plastic
N	Pre-preg carbon fibre reinforced plastic
O	Pre-preg carbon fibre reinforced plastic
P	Pre-preg carbon fibre reinforced plastic
Q	Pre-preg carbon fibre reinforced plastic
R	Pre-preg carbon fibre reinforced plastic
S	Pre-preg carbon fibre reinforced plastic
T	Pre-preg carbon fibre reinforced plastic

COLOUR


Grey RAL 7008
White RAL 9003
Black RAL 9005
Blue RAL 5010
Yellow RAL 1023
Light Grey RAL 7001
Dark Grey RAL 7002
Light Grey RAL 7005
Dark Grey RAL 7006
Light Grey RAL 7008
Dark Grey RAL 7009
Light Grey RAL 7010
Dark Grey RAL 7011
Light Grey RAL 7012
Dark Grey RAL 7013
Light Grey RAL 7014
Dark Grey RAL 7015
Light Grey RAL 7016
Dark Grey RAL 7017
Light Grey RAL 7018
Dark Grey RAL 7019
Light Grey RAL 7020
Dark Grey RAL 7021
Light Grey RAL 7022
Dark Grey RAL 7023
Light Grey RAL 7024
Dark Grey RAL 7025
Light Grey RAL 7026
Dark Grey RAL 7027
Light Grey RAL 7028
Dark Grey RAL 7029
Light Grey RAL 7030
Dark Grey RAL 7031
Light Grey RAL 7032
Dark Grey RAL 7033
Light Grey RAL 7034
Dark Grey RAL 7035
Light Grey RAL 7036
Dark Grey RAL 7037
Light Grey RAL 7038
Dark Grey RAL 7039
Light Grey RAL 7040
Dark Grey RAL 7041
Light Grey RAL 7042
Dark Grey RAL 7043
Light Grey RAL 7044
Dark Grey RAL 7045
Light Grey RAL 7046
Dark Grey RAL 7047
Light Grey RAL 7048
Dark Grey RAL 7049
Light Grey RAL 7050
Dark Grey RAL 7051
Light Grey RAL 7052
Dark Grey RAL 7053
Light Grey RAL 7054
Dark Grey RAL 7055
Light Grey RAL 7056
Dark Grey RAL 7057
Light Grey RAL 7058
Dark Grey RAL 7059
Light Grey RAL 7060
Dark Grey RAL 7061
Light Grey RAL 7062
Dark Grey RAL 7063
Light Grey RAL 7064
Dark Grey RAL 7065
Light Grey RAL 7066
Dark Grey RAL 7067
Light Grey RAL 7068
Dark Grey RAL 7069
Light Grey RAL 7070
Dark Grey RAL 7071
Light Grey RAL 7072
Dark Grey RAL 7073
Light Grey RAL 7074
Dark Grey RAL 7075
Light Grey RAL 7076
Dark Grey RAL 7077
Light Grey RAL 7078
Dark Grey RAL 7079
Light Grey RAL 7080
Dark Grey RAL 7081
Light Grey RAL 7082
Dark Grey RAL 7083
Light Grey RAL 7084
Dark Grey RAL 7085
Light Grey RAL 7086
Dark Grey RAL 7087
Light Grey RAL 7088
Dark Grey RAL 7089
Light Grey RAL 7090
Dark Grey RAL 7091
Light Grey RAL 7092
Dark Grey RAL 7093
Light Grey RAL 7094
Dark Grey RAL 7095
Light Grey RAL 7096
Dark Grey RAL 7097
Light Grey RAL 7098
Dark Grey RAL 7099
Light Grey RAL 7100
Dark Grey RAL 7101
Light Grey RAL 7102
Dark Grey RAL 7103
Light Grey RAL 7104
Dark Grey RAL 7105
Light Grey RAL 7106
Dark Grey RAL 7107
Light Grey RAL 7108
Dark Grey RAL 7109
Light Grey RAL 7110
Dark Grey RAL 7111
Light Grey RAL 7112
Dark Grey RAL 7113
Light Grey RAL 7114
Dark Grey RAL 7115
Light Grey RAL 7116
Dark Grey RAL 7117
Light Grey RAL 7118
Dark Grey RAL 7119
Light Grey RAL 7120
Dark Grey RAL 7121
Light Grey RAL 7122
Dark Grey RAL 7123
Light Grey RAL 7124
Dark Grey RAL 7125
Light Grey RAL 7126
Dark Grey RAL 7127
Light Grey RAL 7128
Dark Grey RAL 7129
Light Grey RAL 7130
Dark Grey RAL 7131
Light Grey RAL 7132
Dark Grey RAL 7133
Light Grey RAL 7134
Dark Grey RAL 7135
Light Grey RAL 7136
Dark Grey RAL 7137
Light Grey RAL 7138
Dark Grey RAL 7139
Light Grey RAL 7140
Dark Grey RAL 7141
Light Grey RAL 7142
Dark Grey RAL 7143
Light Grey RAL 7144
Dark Grey RAL 7145
Light Grey RAL 7146
Dark Grey RAL 7147
Light Grey RAL 7148
Dark Grey RAL 7149
Light Grey RAL 7150
Dark Grey RAL 7151
Light Grey RAL 7152
Dark Grey RAL 7153
Light Grey RAL 7154
Dark Grey RAL 7155
Light Grey RAL 7156
Dark Grey RAL 7157
Light Grey RAL 7158
Dark Grey RAL 7159
Light Grey RAL 7160
Dark Grey RAL 7161
Light Grey RAL 7162
Dark Grey RAL 7163
Light Grey RAL 7164
Dark Grey RAL 7165
Light Grey RAL 7166
Dark Grey RAL 7167
Light Grey RAL 7168
Dark Grey RAL 7169
Light Grey RAL 7170
Dark Grey RAL 7171
Light Grey RAL 7172
Dark Grey RAL 7173
Light Grey RAL 7174
Dark Grey RAL 7175
Light Grey RAL 7176
Dark Grey RAL 7177
Light Grey RAL 7178
Dark Grey RAL 7179
Light Grey RAL 7180
Dark Grey RAL 7181
Light Grey RAL 7182
Dark Grey RAL 7183
Light Grey RAL 7184
Dark Grey RAL 7185
Light Grey RAL 7186
Dark Grey RAL 7187
Light Grey RAL 7188
Dark Grey RAL 7189
Light Grey RAL 7190
Dark Grey RAL 7191
Light Grey RAL 7192
Dark Grey RAL 7193
Light Grey RAL 7194
Dark Grey RAL 7195
Light Grey RAL 7196
Dark Grey RAL 7197
Light Grey RAL 7198
Dark Grey RAL 7199
Light Grey RAL 7200

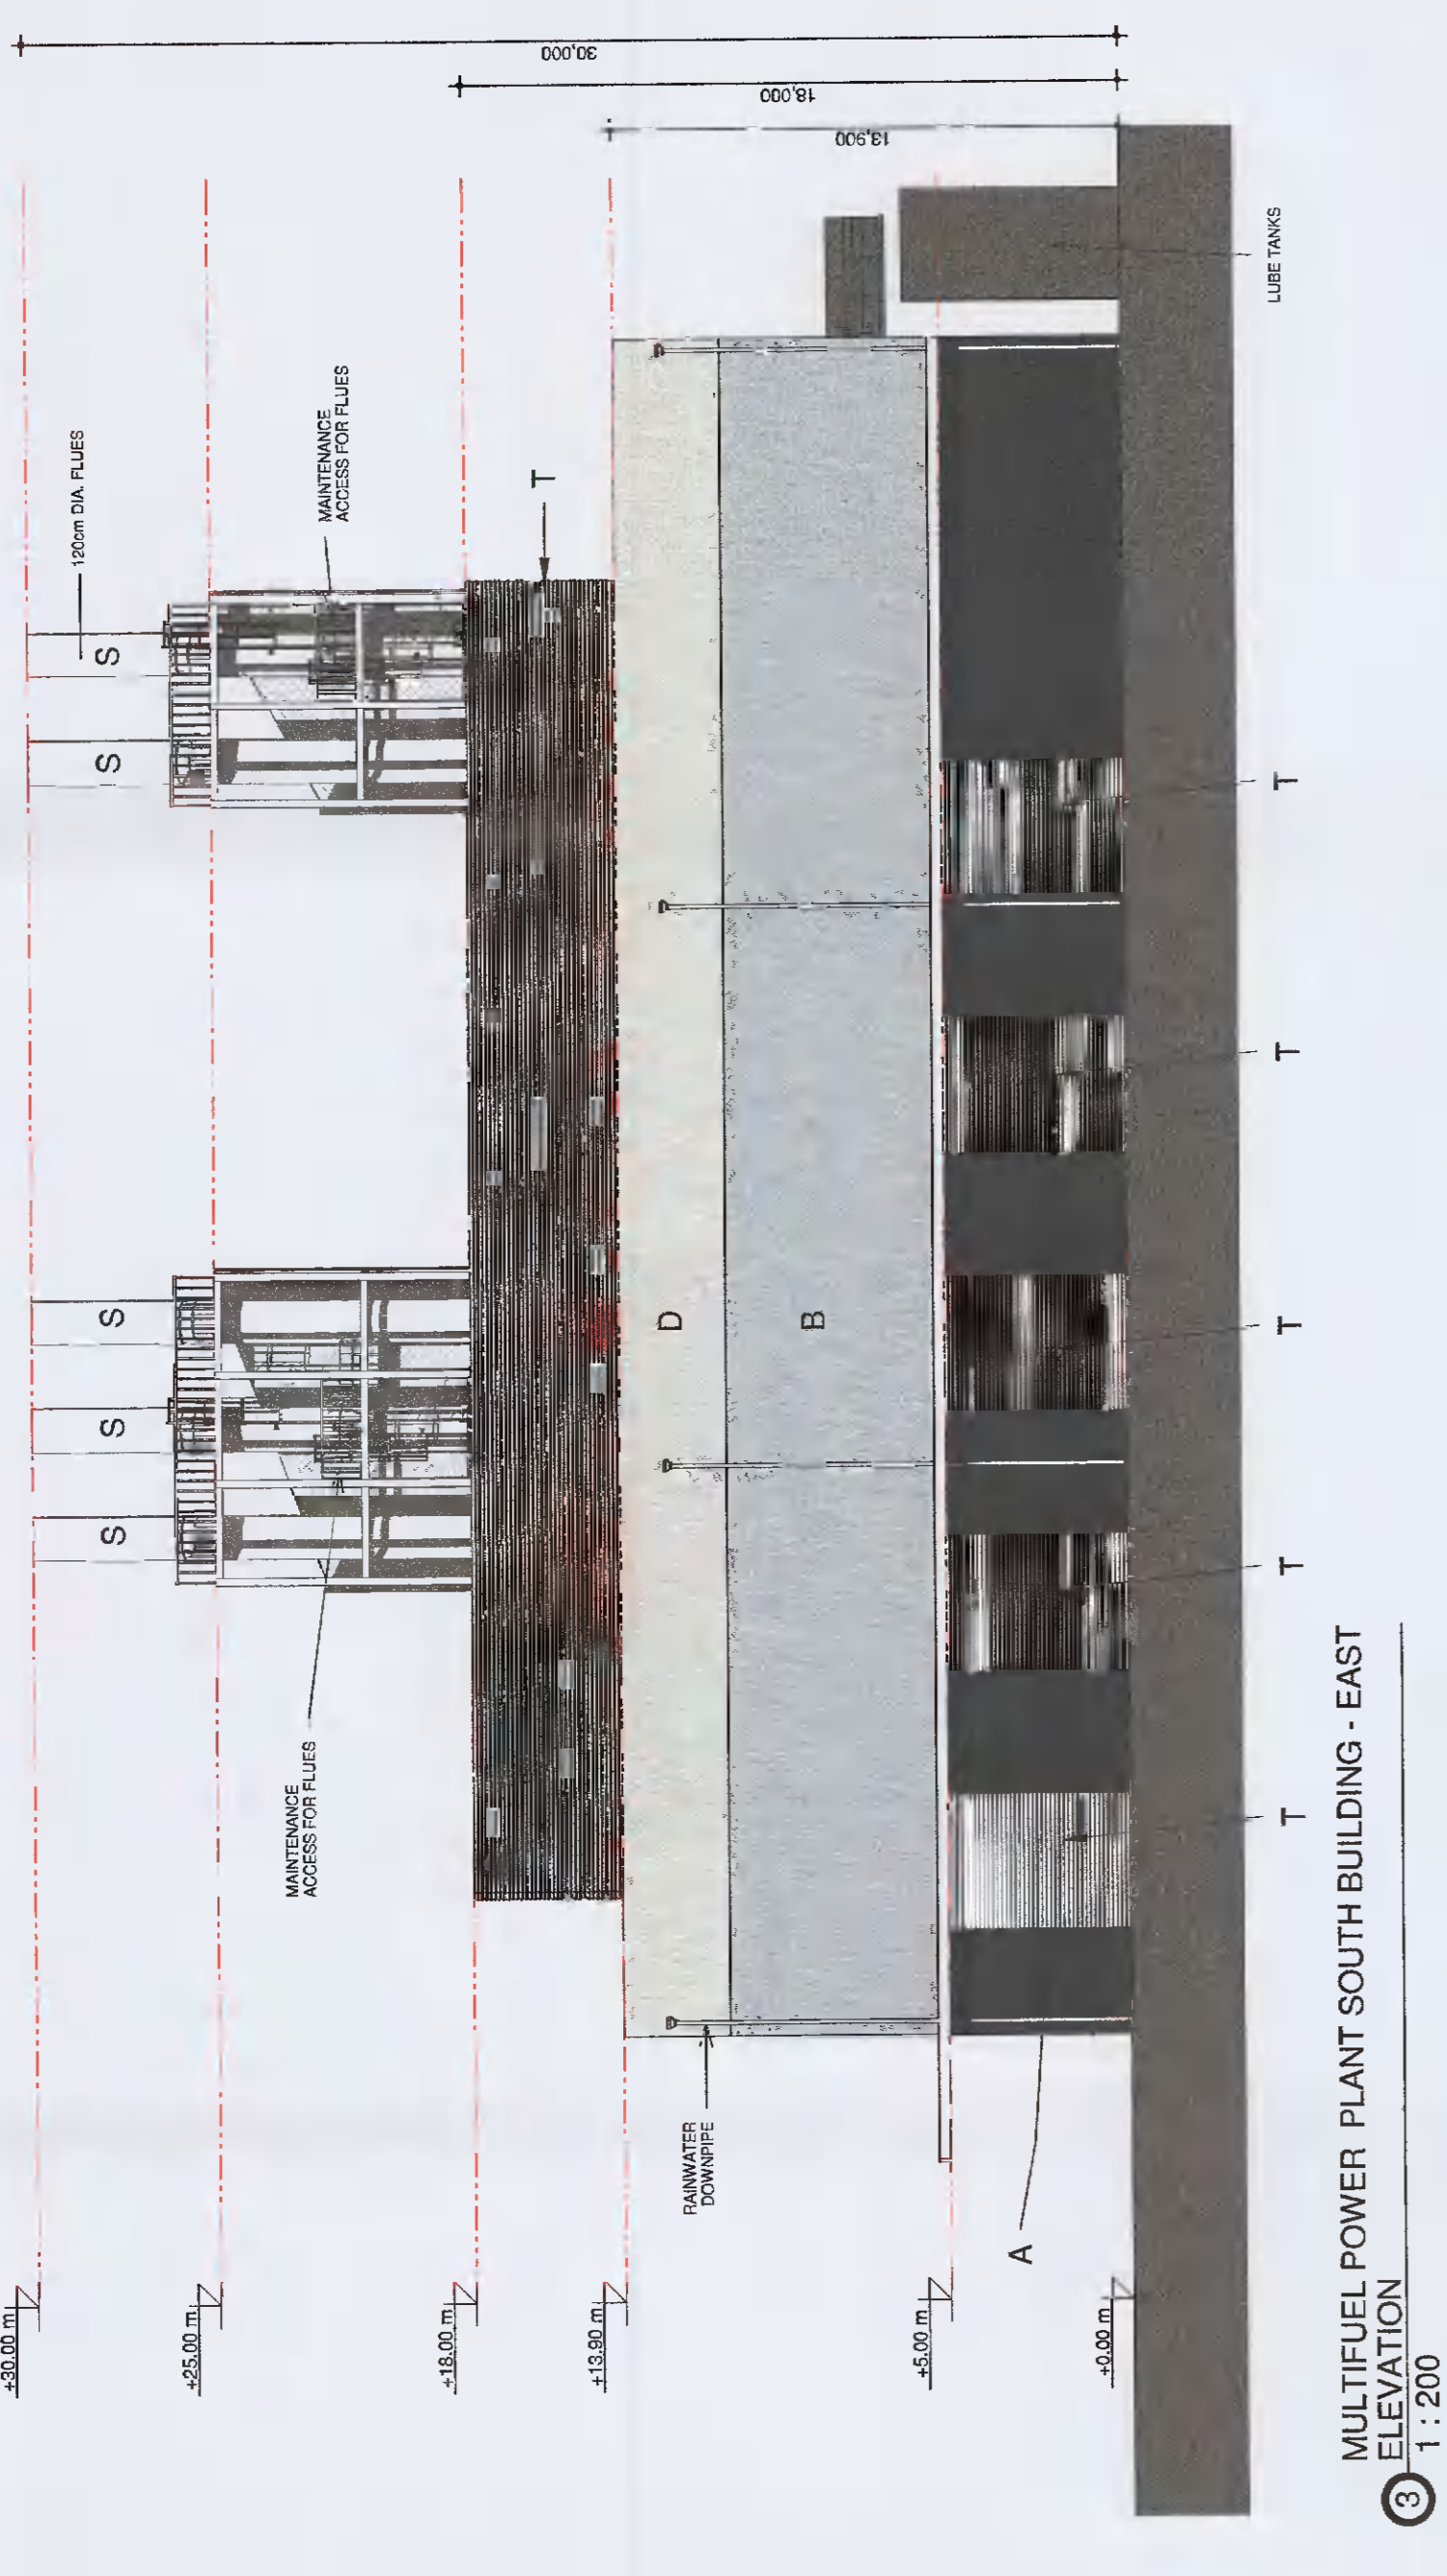


3 MULTIFUEL POWER PLANT SOUTH BUILDING - EAST ELEVATION 1:200

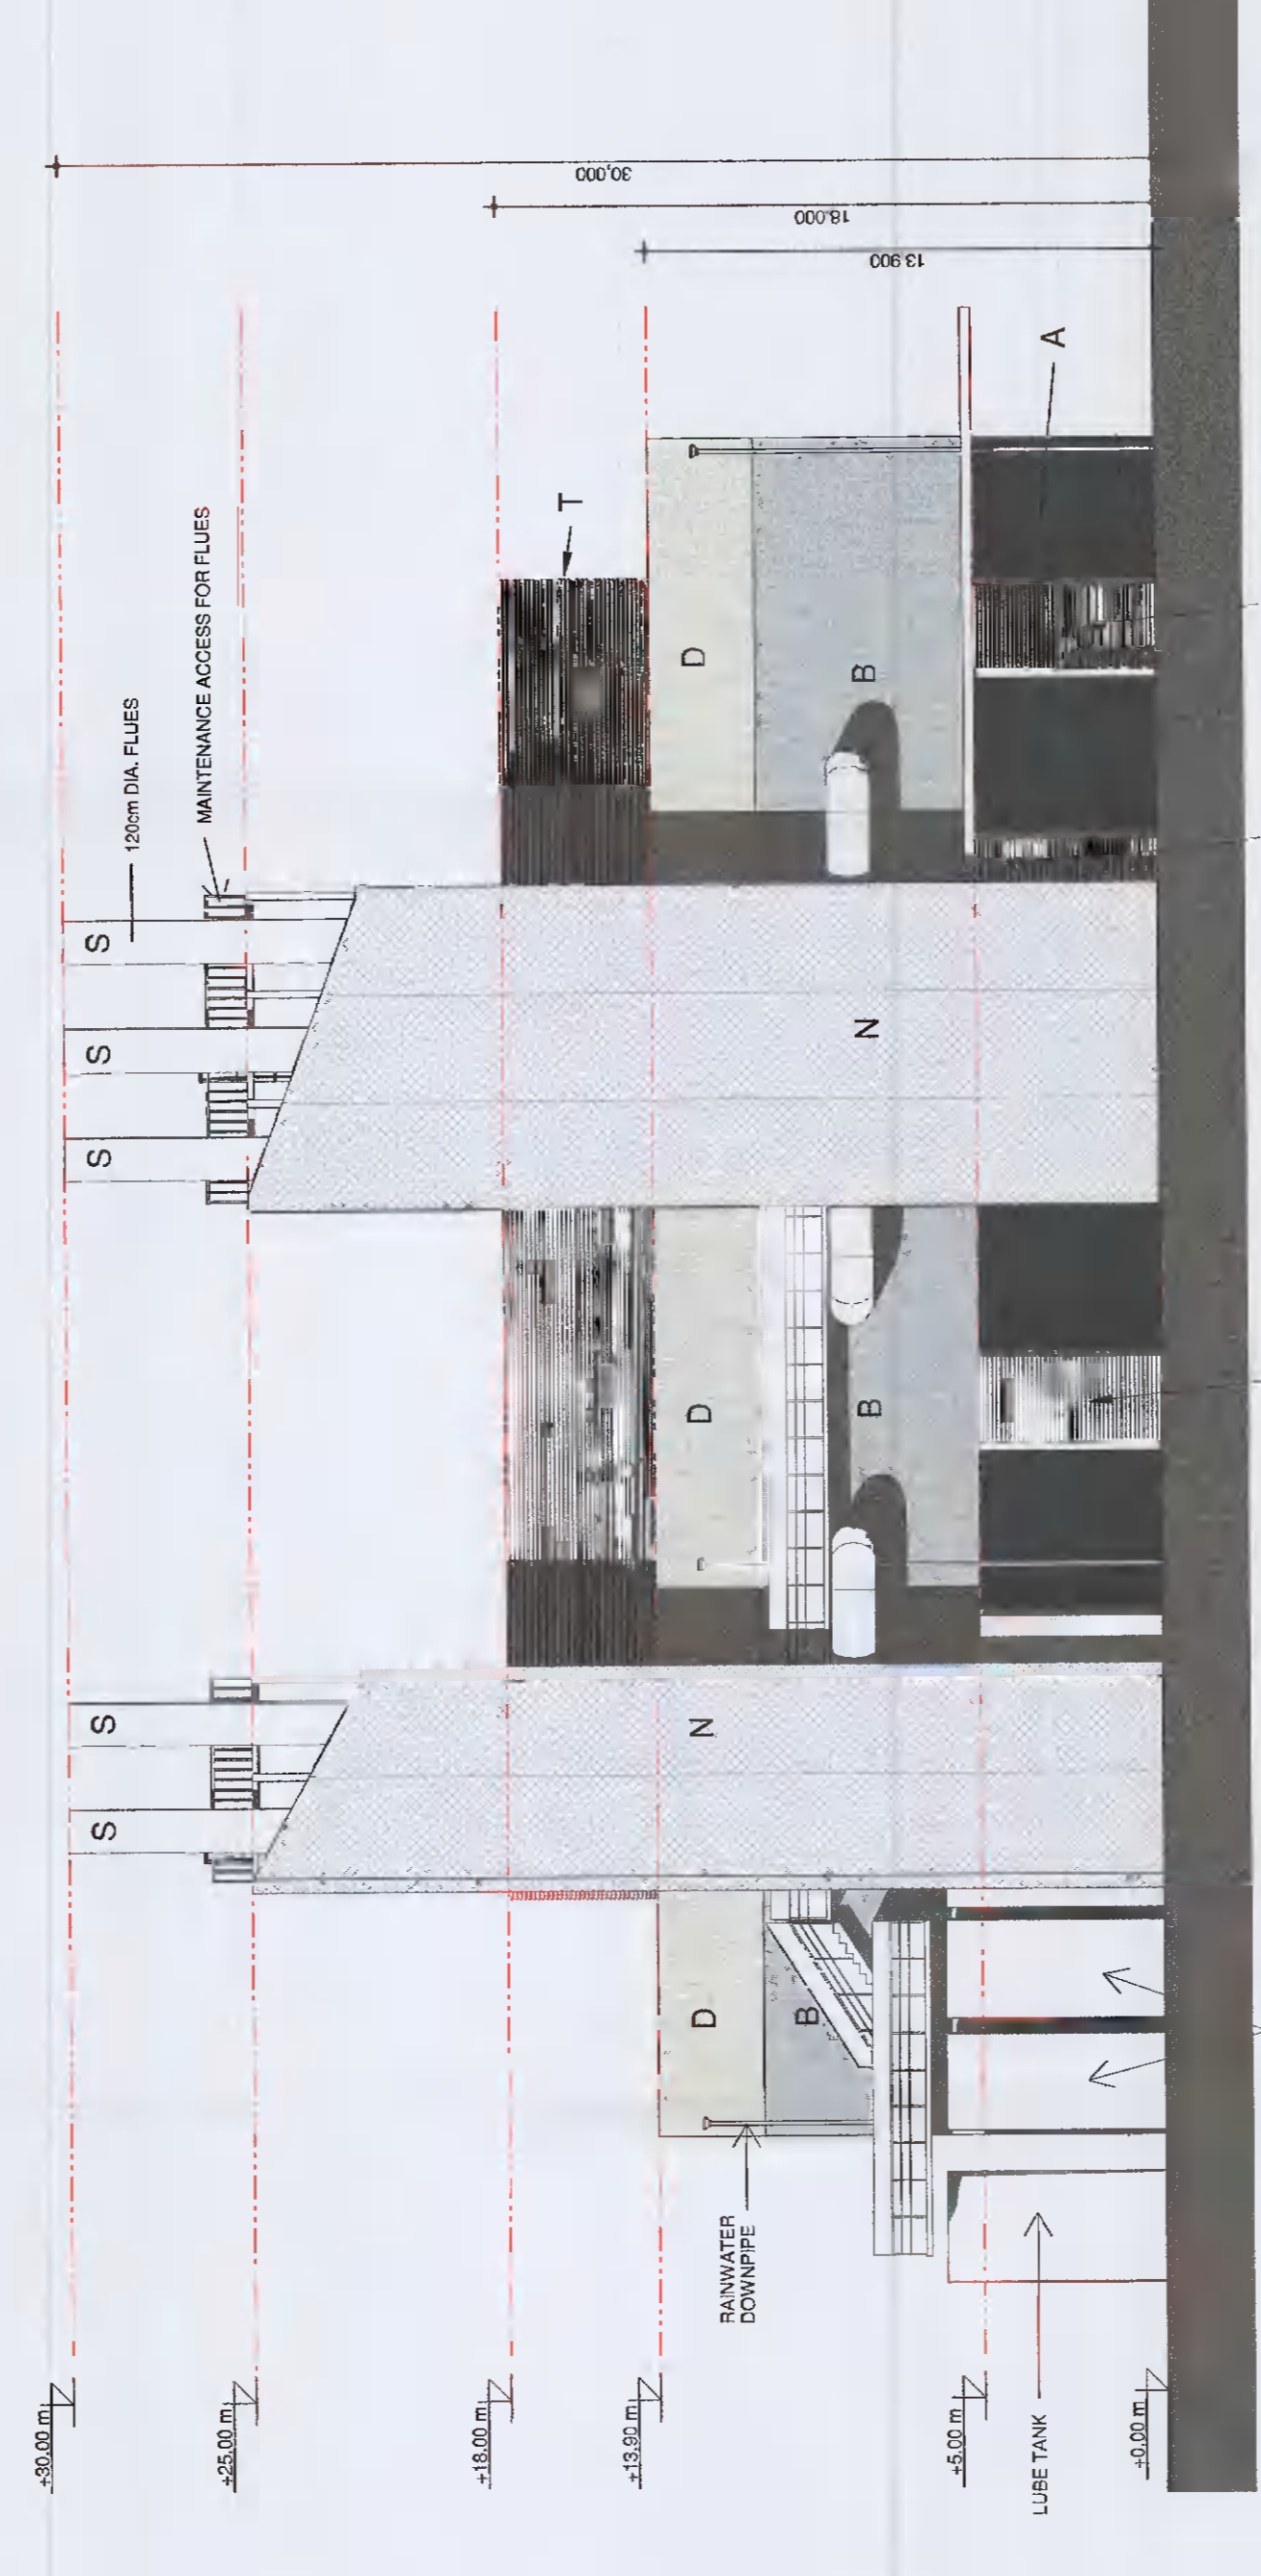


4 MULTIFUEL POWER PLANT SOUTH BUILDING - WEST ELEVATION 1:200

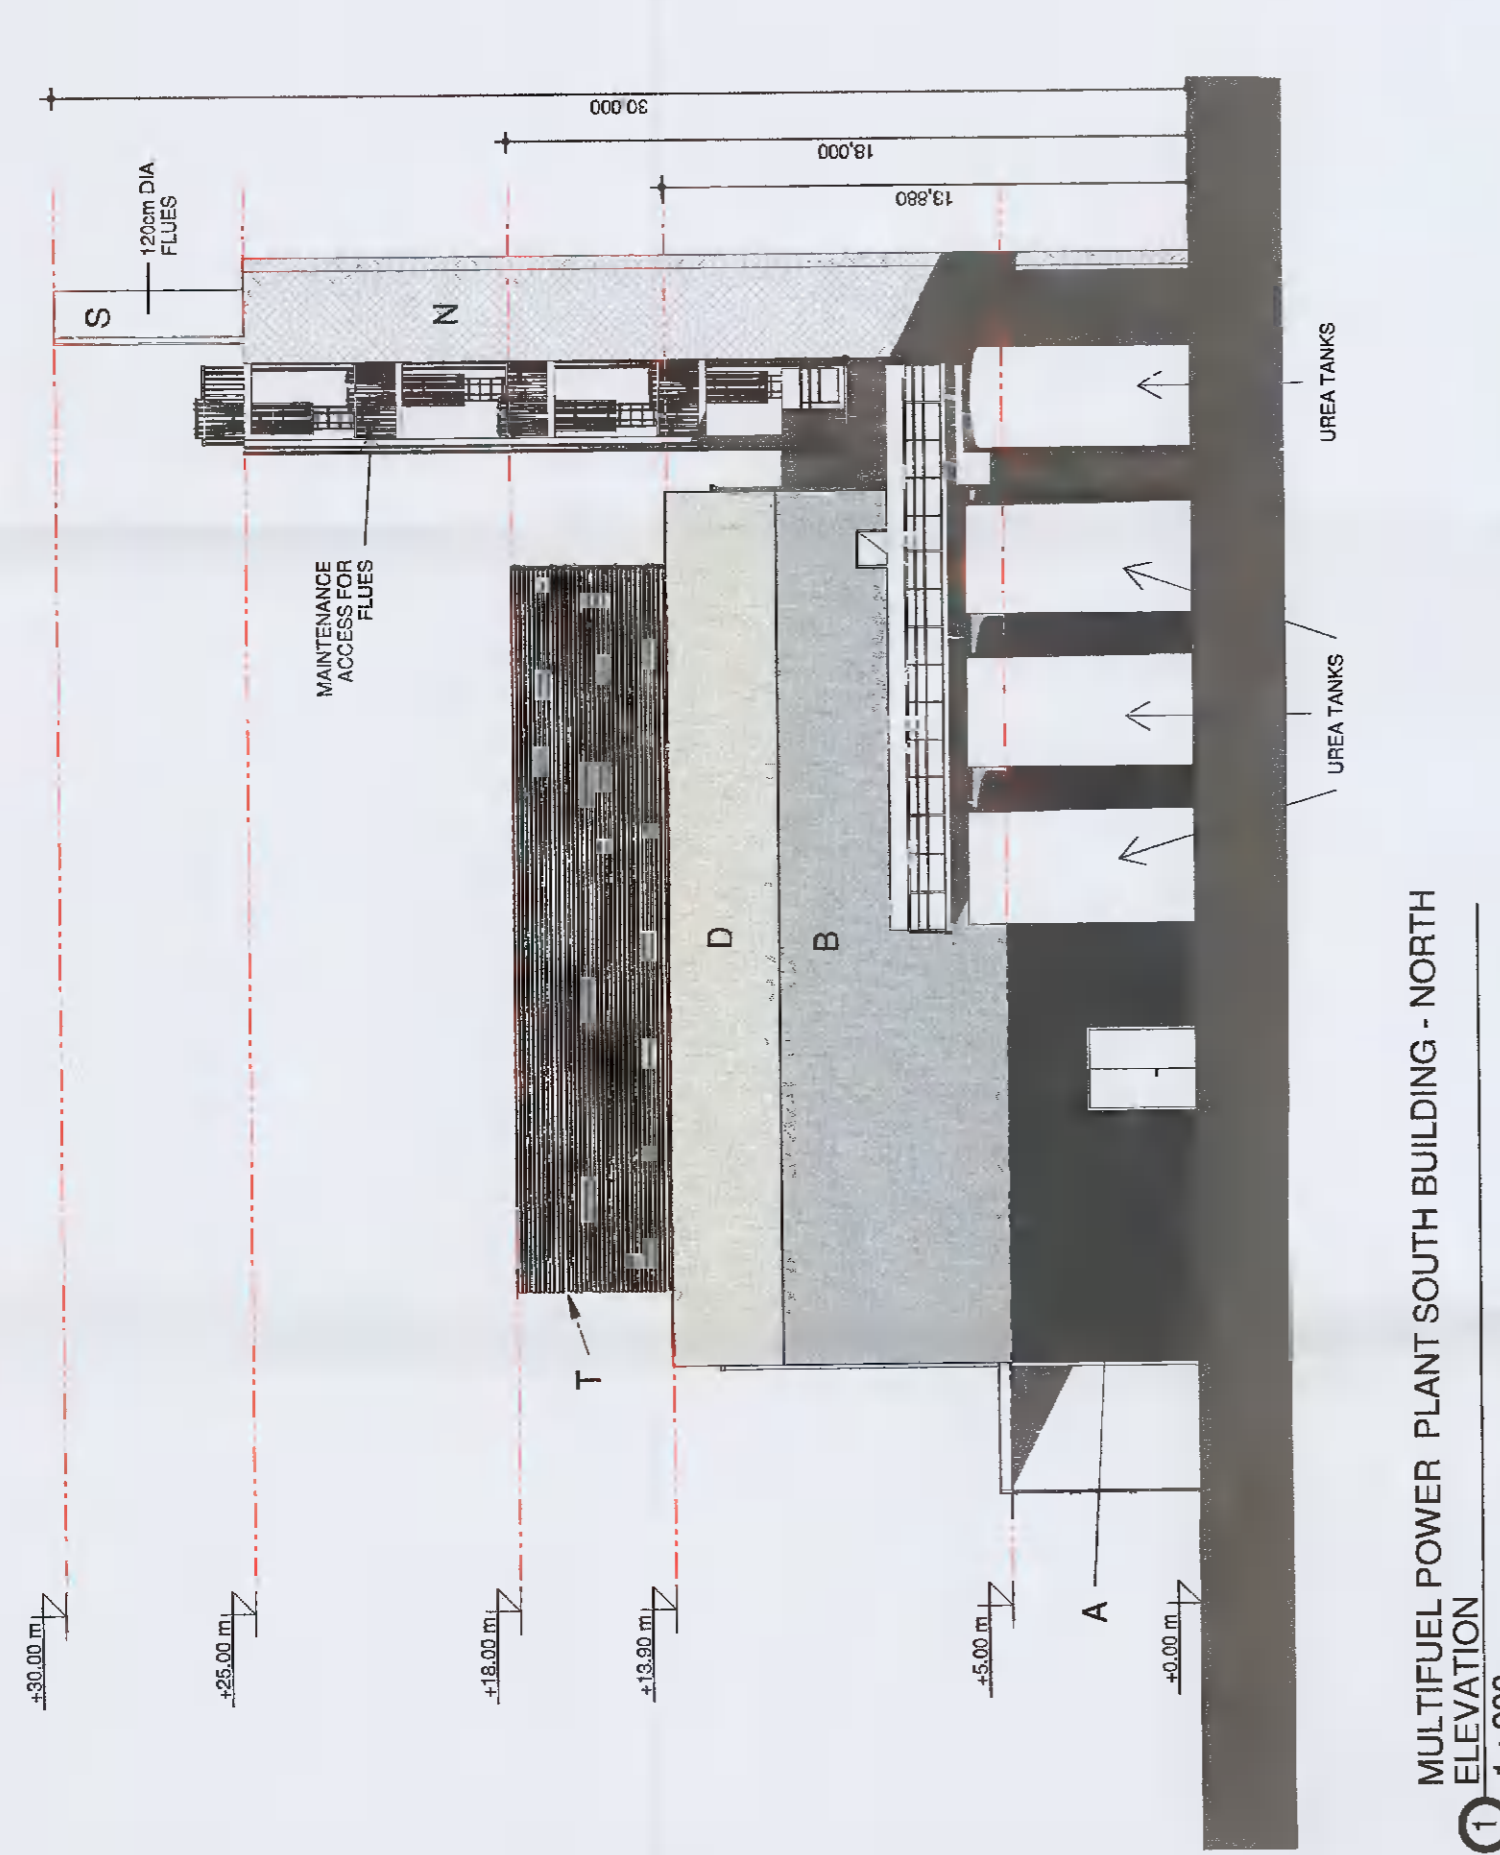


1 MULTIFUEL POWER PLANT SOUTH BUILDING - NORTH ELEVATION 1:200

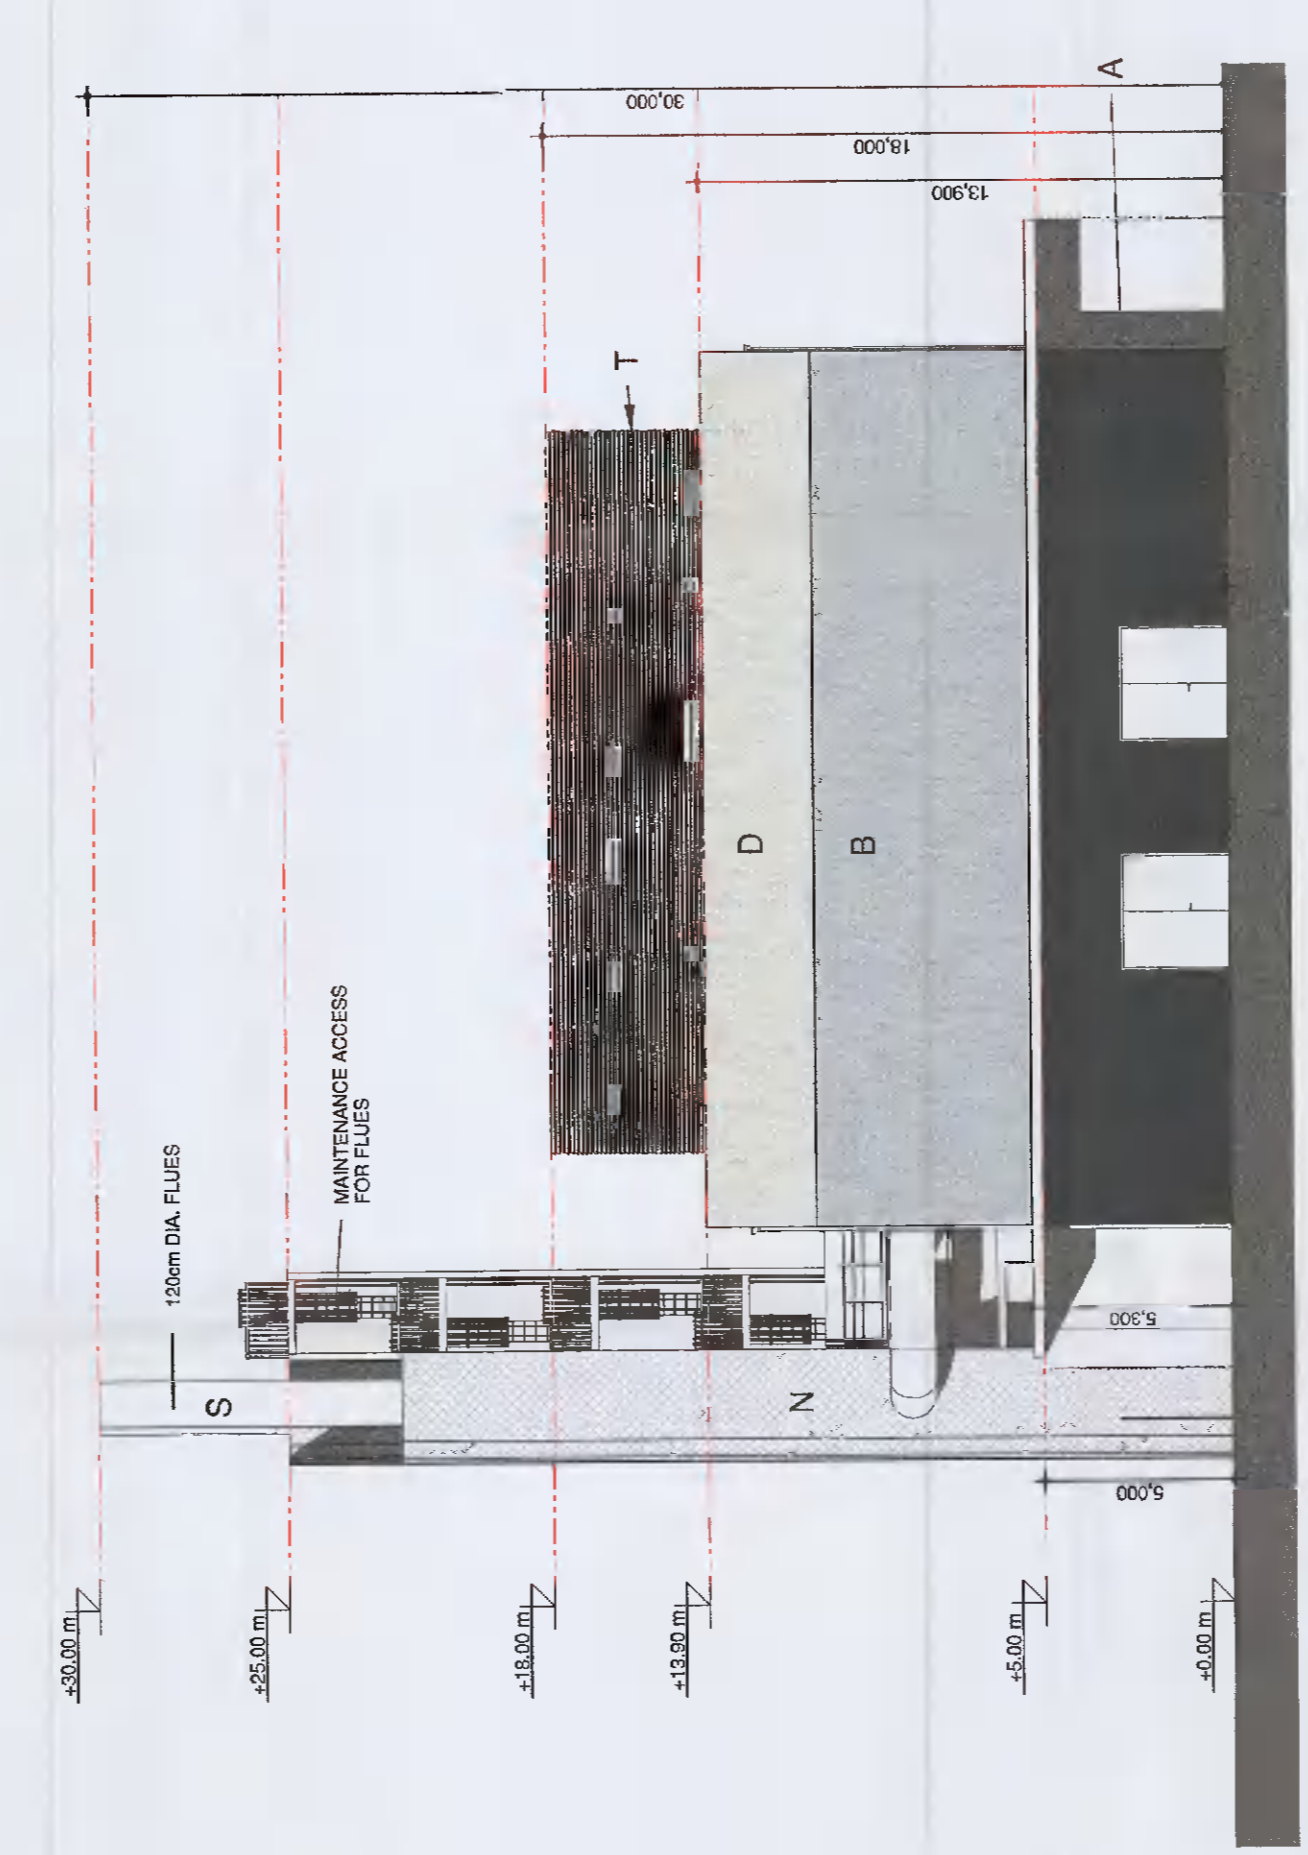

2 MULTIFUEL POWER PLANT SOUTH BUILDING - SOUTH ELEVATION 1:200

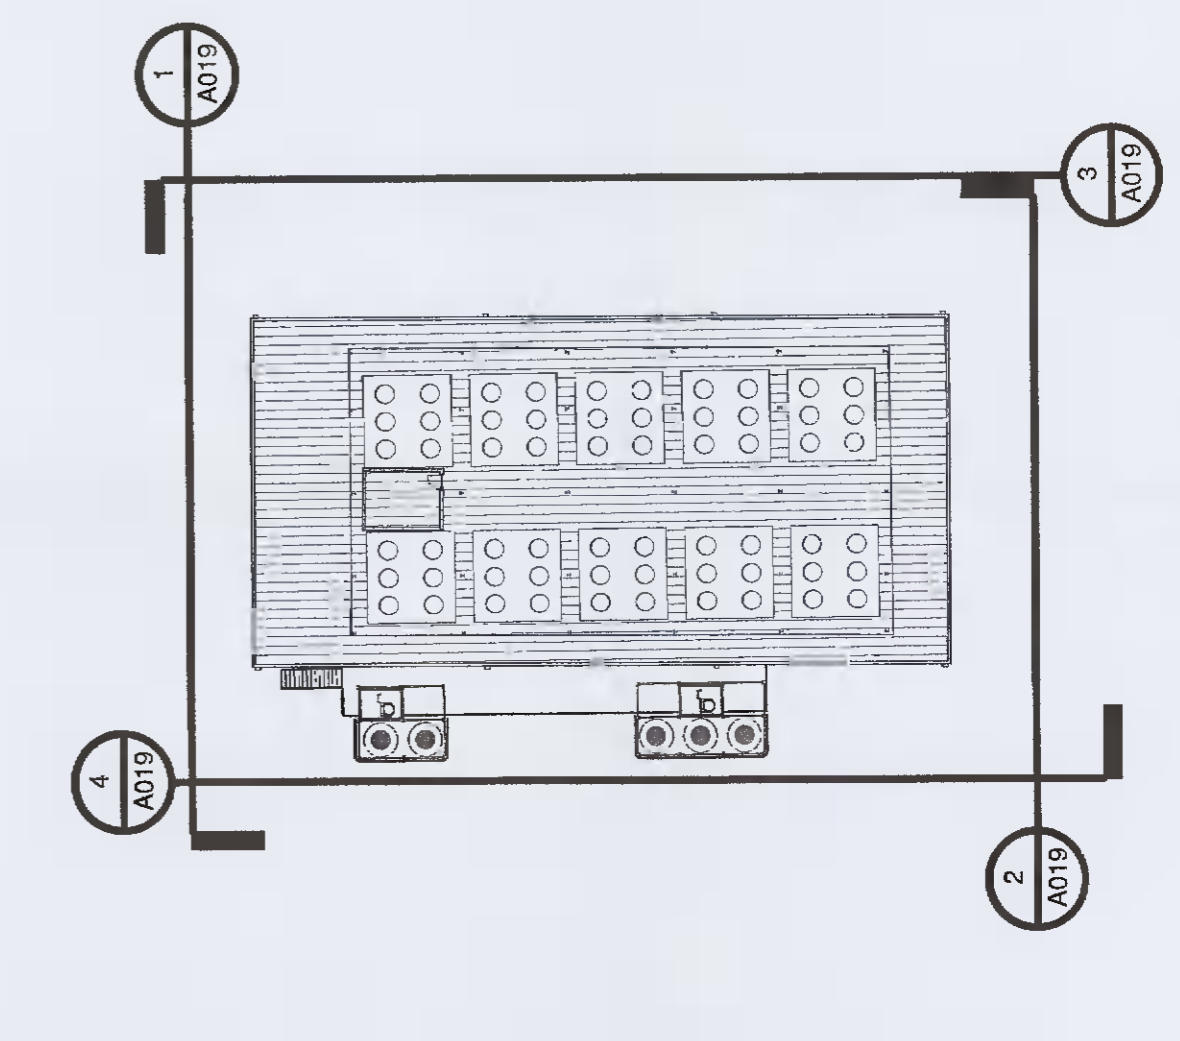

5 MULTIFUEL POWER PLANT SOUTH BUILDING - KEY PLAN 1:500

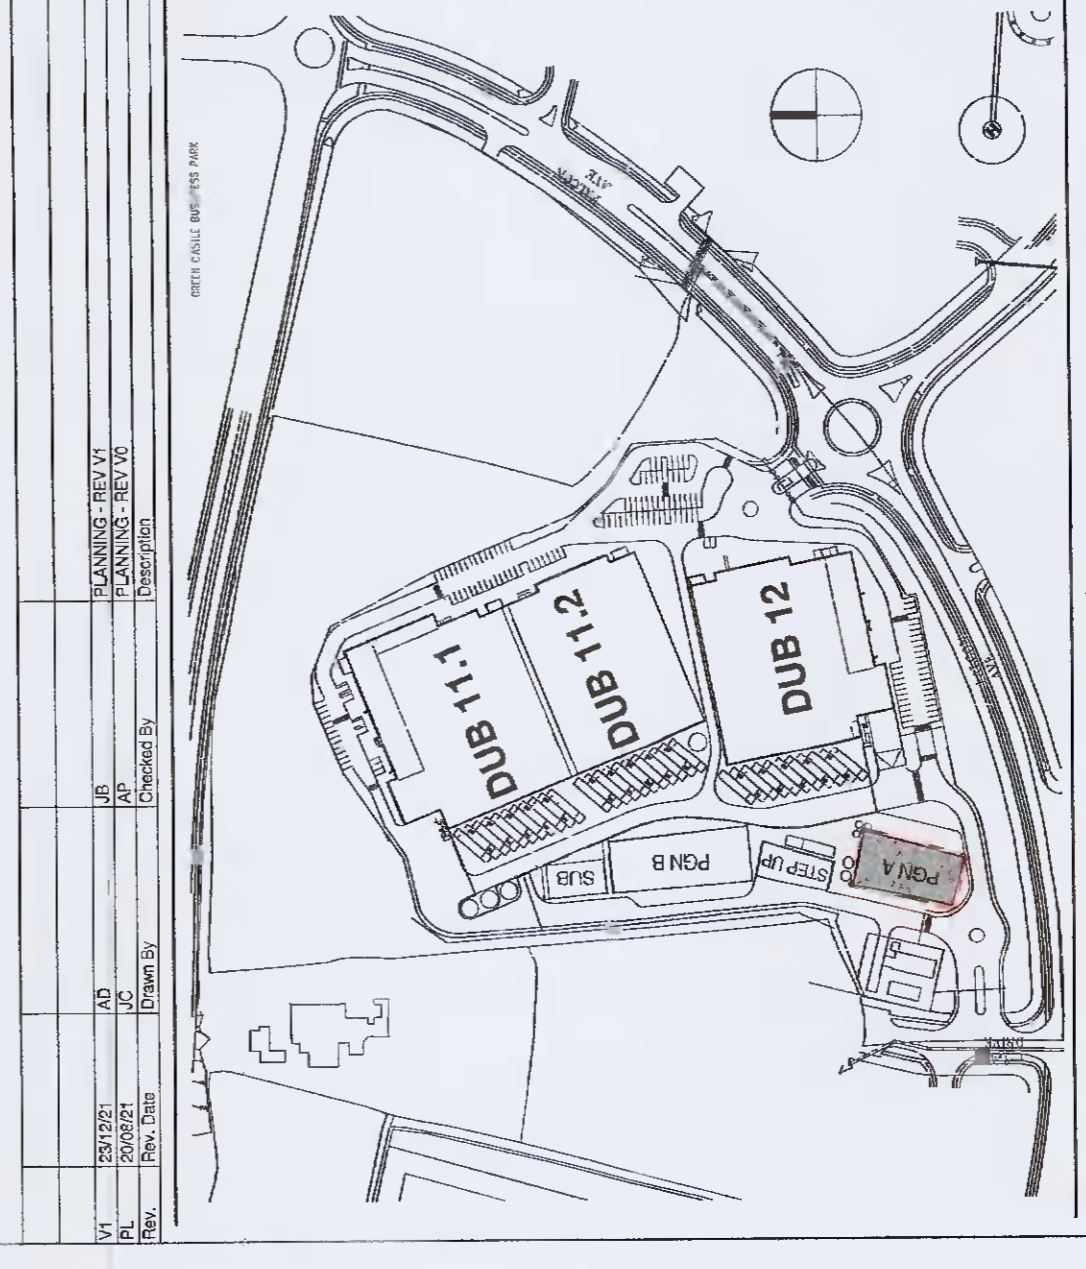

VANTAGE DATA CENTRES
Approved Engineer
Engineer's Name: J. Edgell
Date: 03/12/21

BURNS MEDONNELL
Approved Designer & Engineer
Engineer's Name: J. Edgell
Date: 03/12/21

Hyphen
Approved Architect
Architect's Name: J. Edgell
Date: 03/12/21

Checked by: J. Edgell
Approved by: J. Edgell
Project address: Profile Park, Dublin 22, Ireland
53°19'1.40"N, 6°28'40.80"W

Drawn by: A. O'Leary
Date: 03/12/21
Rev Code: DUB1-DR-ZZ-A019-V1-PL-BMD_V1

Project Name: MultiFuel Power Plant Building - South Elevations
Drawing Number: A019
Project Location: Profile Park, Dublin 22, Ireland
Coordinates: 53°19'1.40"N, 6°28'40.80"W
Drawing Date: 03/12/21
Drawing Rev: V1
Drawing Code: DUB1-DR-ZZ-A019-V1-PL-BMD_V1

PLANNING SUBMITTAL
NOT FOR
CONSTRUCTION