


MULTIFUEL POWER PLANT SOUTH BUILDING - GROUND PLAN
 1:200


MULTIFUEL POWER PLANT SOUTH BUILDING - MEZZANINE FLOOR PLAN
 1:200

MULTIFUEL POWER PLANT SOUTH BUILDING - ROOF PLAN
 1:200


MULTIFUEL POWER PLANT SOUTH BUILDING - ROOF PLAN CHILLER DECK
 1:200

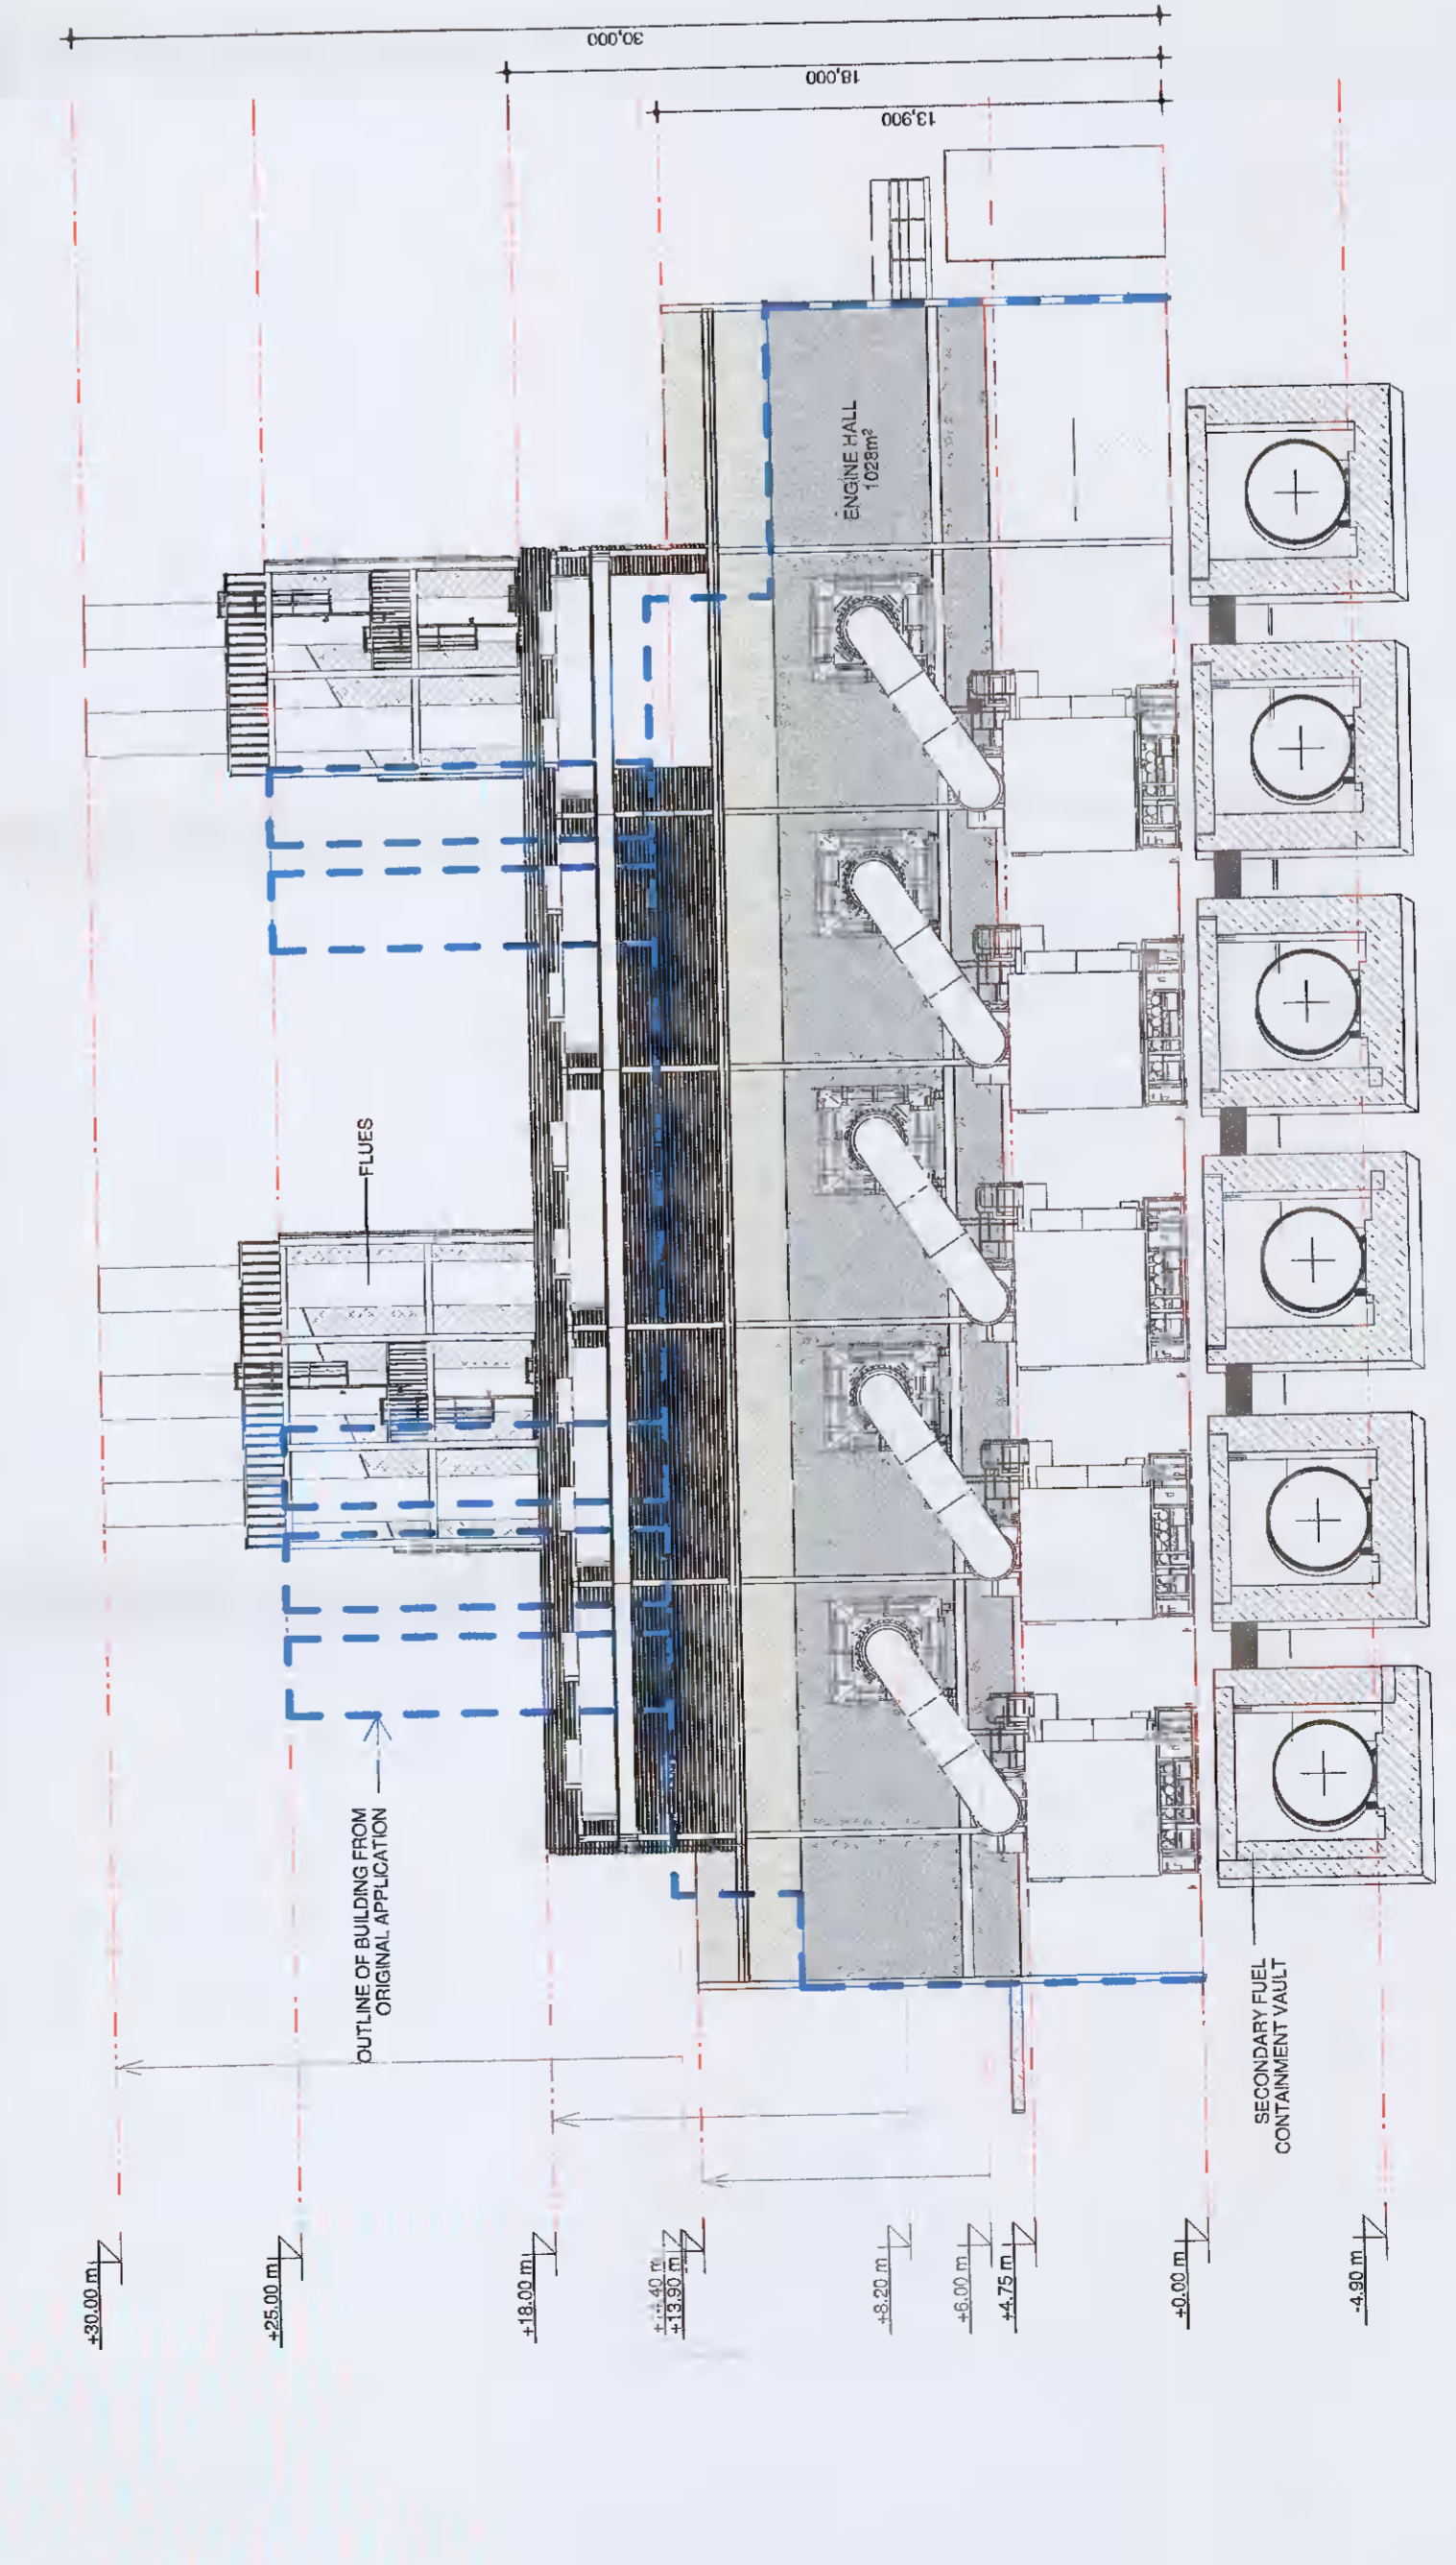

MULTIFUEL POWER PLANT SOUTH BUILDING - LONGITUDINAL SECTION
 1:200

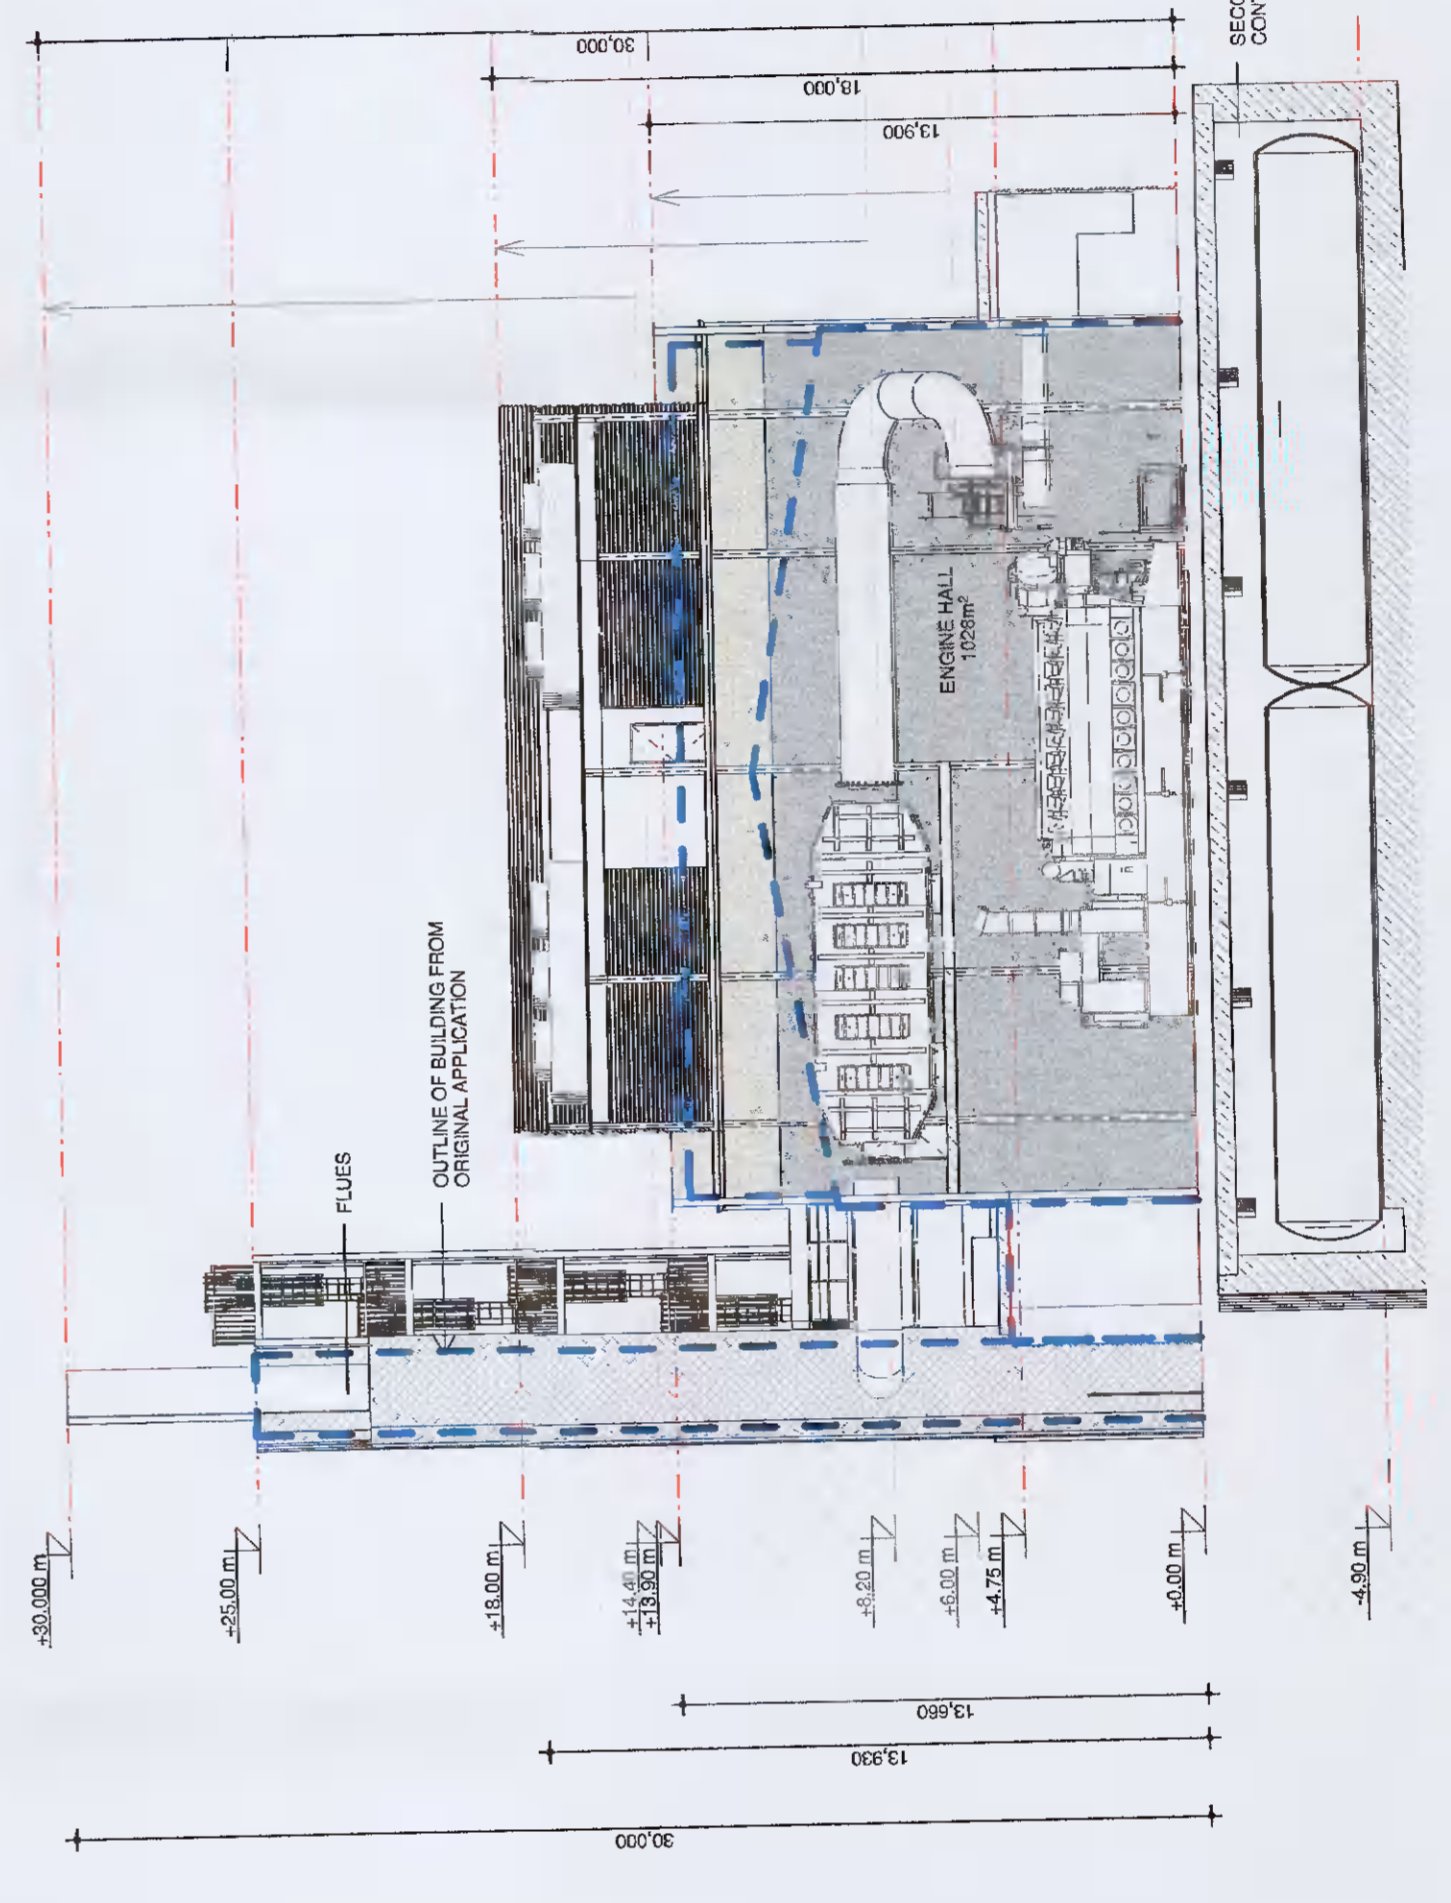

MULTIFUEL POWER PLANT SOUTH BUILDING - CROSS SECTION
 1:200

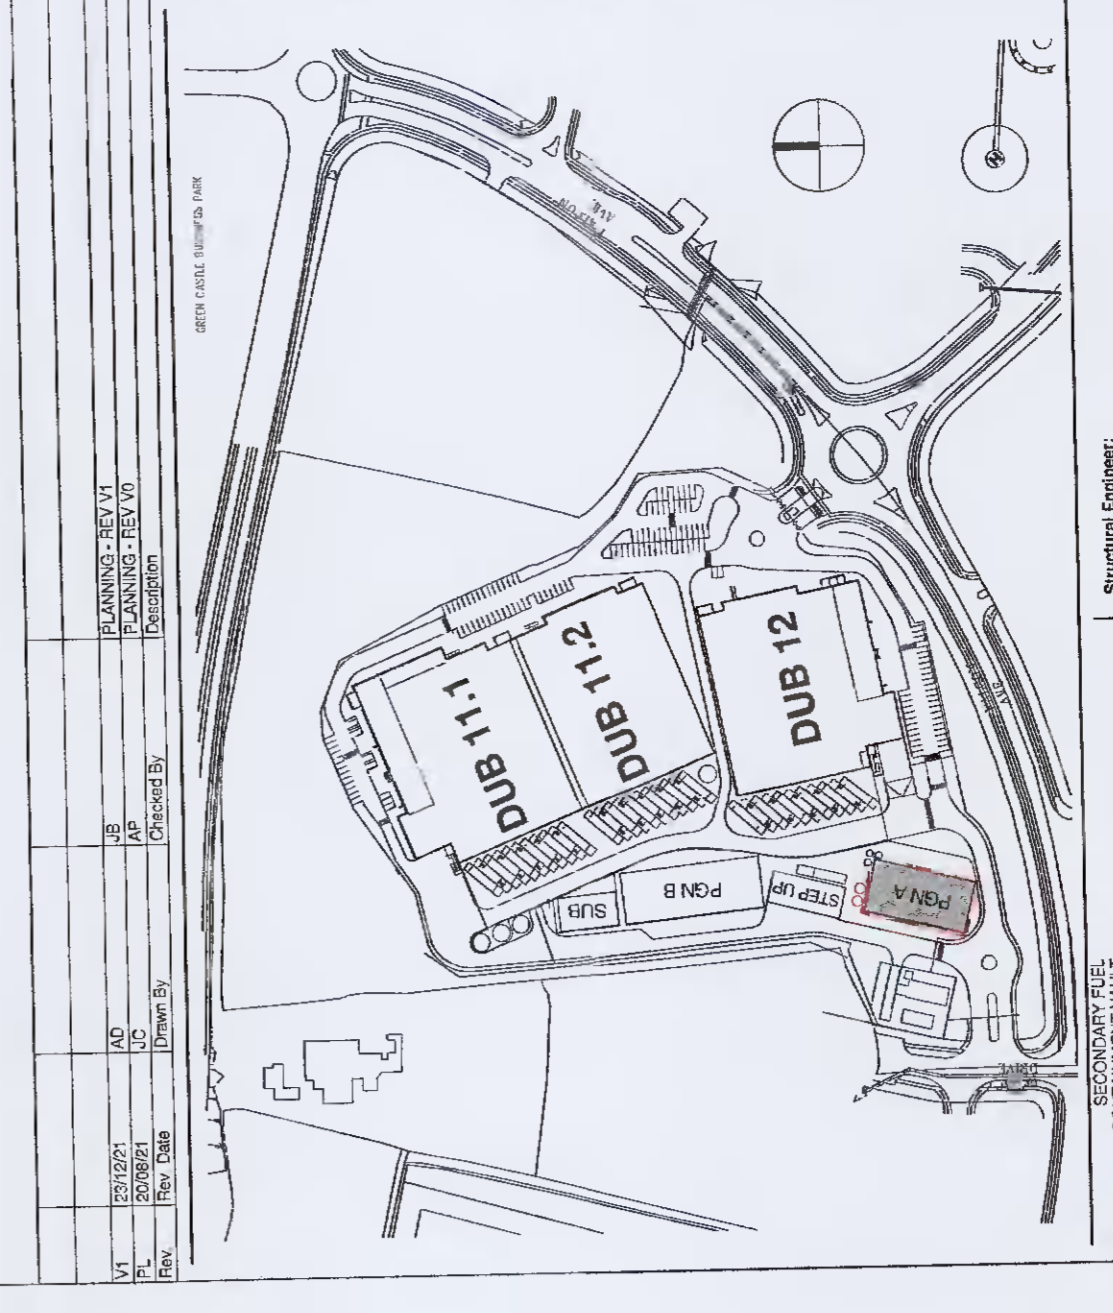

VANTAGE D.P. CONSULTANTS		Project Manager & Engineer	
Project: CONTRACTOR'S PLAN		Project No:	150001
Author: J. J. O'Connell		Engineer:	150001
Burns & McDonnell		Checked by:	J. J. O'Connell
Hyphen		Drawn by:	A. Mulvaney
Hyphen Architects Ltd		Scale:	1:200
100, St. Andrew's Place, 1st Floor, Dublin 1, Ireland			

Project: Dublin 22, Ireland
 53°19'40"N, 6°28'40"W

Project Name: MULTIFUEL POWER PLANT BUILDING - SOUTH
 Drawing No: A018
 Date: 15/08/21
 Rev: 01
 Rev Code: DUB-CR-ZZ-A018-V1-PL-RMD V1

PLANNING SUBMITTAL
 NOT FOR
 CONSTRUCTION