



FINISHES LEGEND


REF	MATERIAL	COLOUR RAL	SWATCH
A	Insulated Metal Sandwich Panel Treatment FTV	Light Grey RAL 7035	
B	Insulated Metal Sandwich Panel Treatment FTV	White RAL 9010	
C	Insulated Metal Sandwich Panel Treatment FTV	White RAL 9010	
D	Insulated Metal Sandwich Panel Treatment FTV	White RAL 9010	
E	Insulated Metal Sandwich Panel Treatment FTV	White RAL 9010	
F	Insulated Metal Sandwich Panel Treatment FTV	White RAL 9010	
G	Insulated Metal Sandwich Panel Treatment FTV	White RAL 9010	
H	Aluminium Curtain Wall System Spandrel F19520	White RAL 9010	
I	Aluminium Curtain Wall System Spandrel F19520	White RAL 9010	
J	Aluminium Curtain Wall System Spandrel F19520	White RAL 9010	
K	Aluminium Curtain Wall System Spandrel F19520	White RAL 9010	
L	Aluminium Curtain Wall System Spandrel F19520	White RAL 9010	
M	Aluminium Curtain Wall System Spandrel F19520	White RAL 9010	
N	Aluminium Curtain Wall System Spandrel F19520	White RAL 9010	
O	Aluminium Curtain Wall System Spandrel F19520	White RAL 9010	
P	Aluminium Curtain Wall System Spandrel F19520	White RAL 9010	
Q	Aluminium Curtain Wall System Spandrel F19520	White RAL 9010	
R	Aluminium Curtain Wall System Spandrel F19520	White RAL 9010	
S	Aluminium Curtain Wall System Spandrel F19520	White RAL 9010	
T	Aluminium Curtain Wall System Spandrel F19520	White RAL 9010	

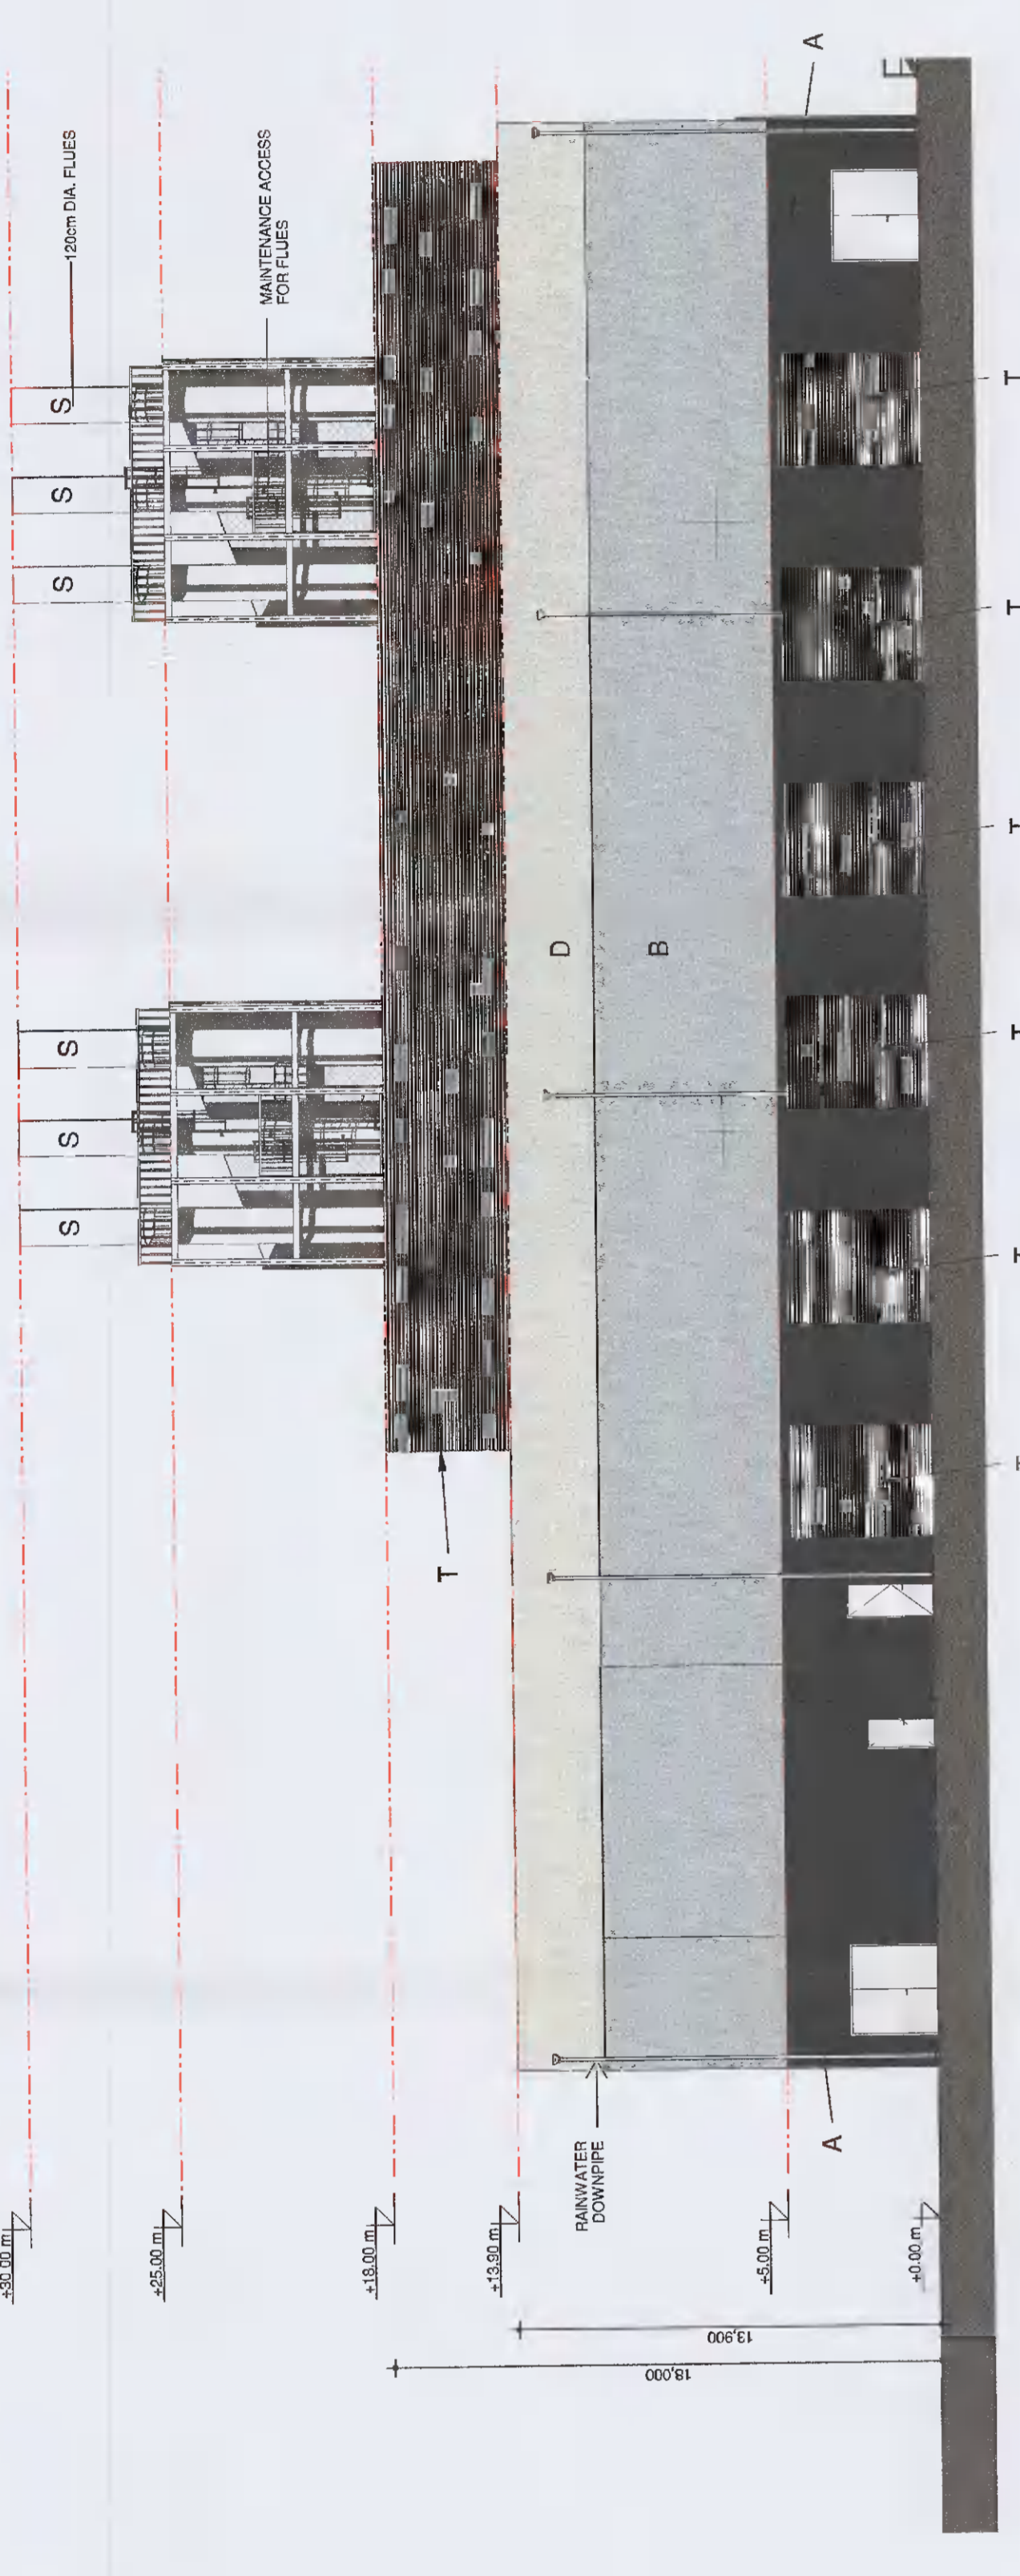


MULTIFUEL POWER PLANT NORTH BUILDING - EAST
 ELEVATION
 1:200

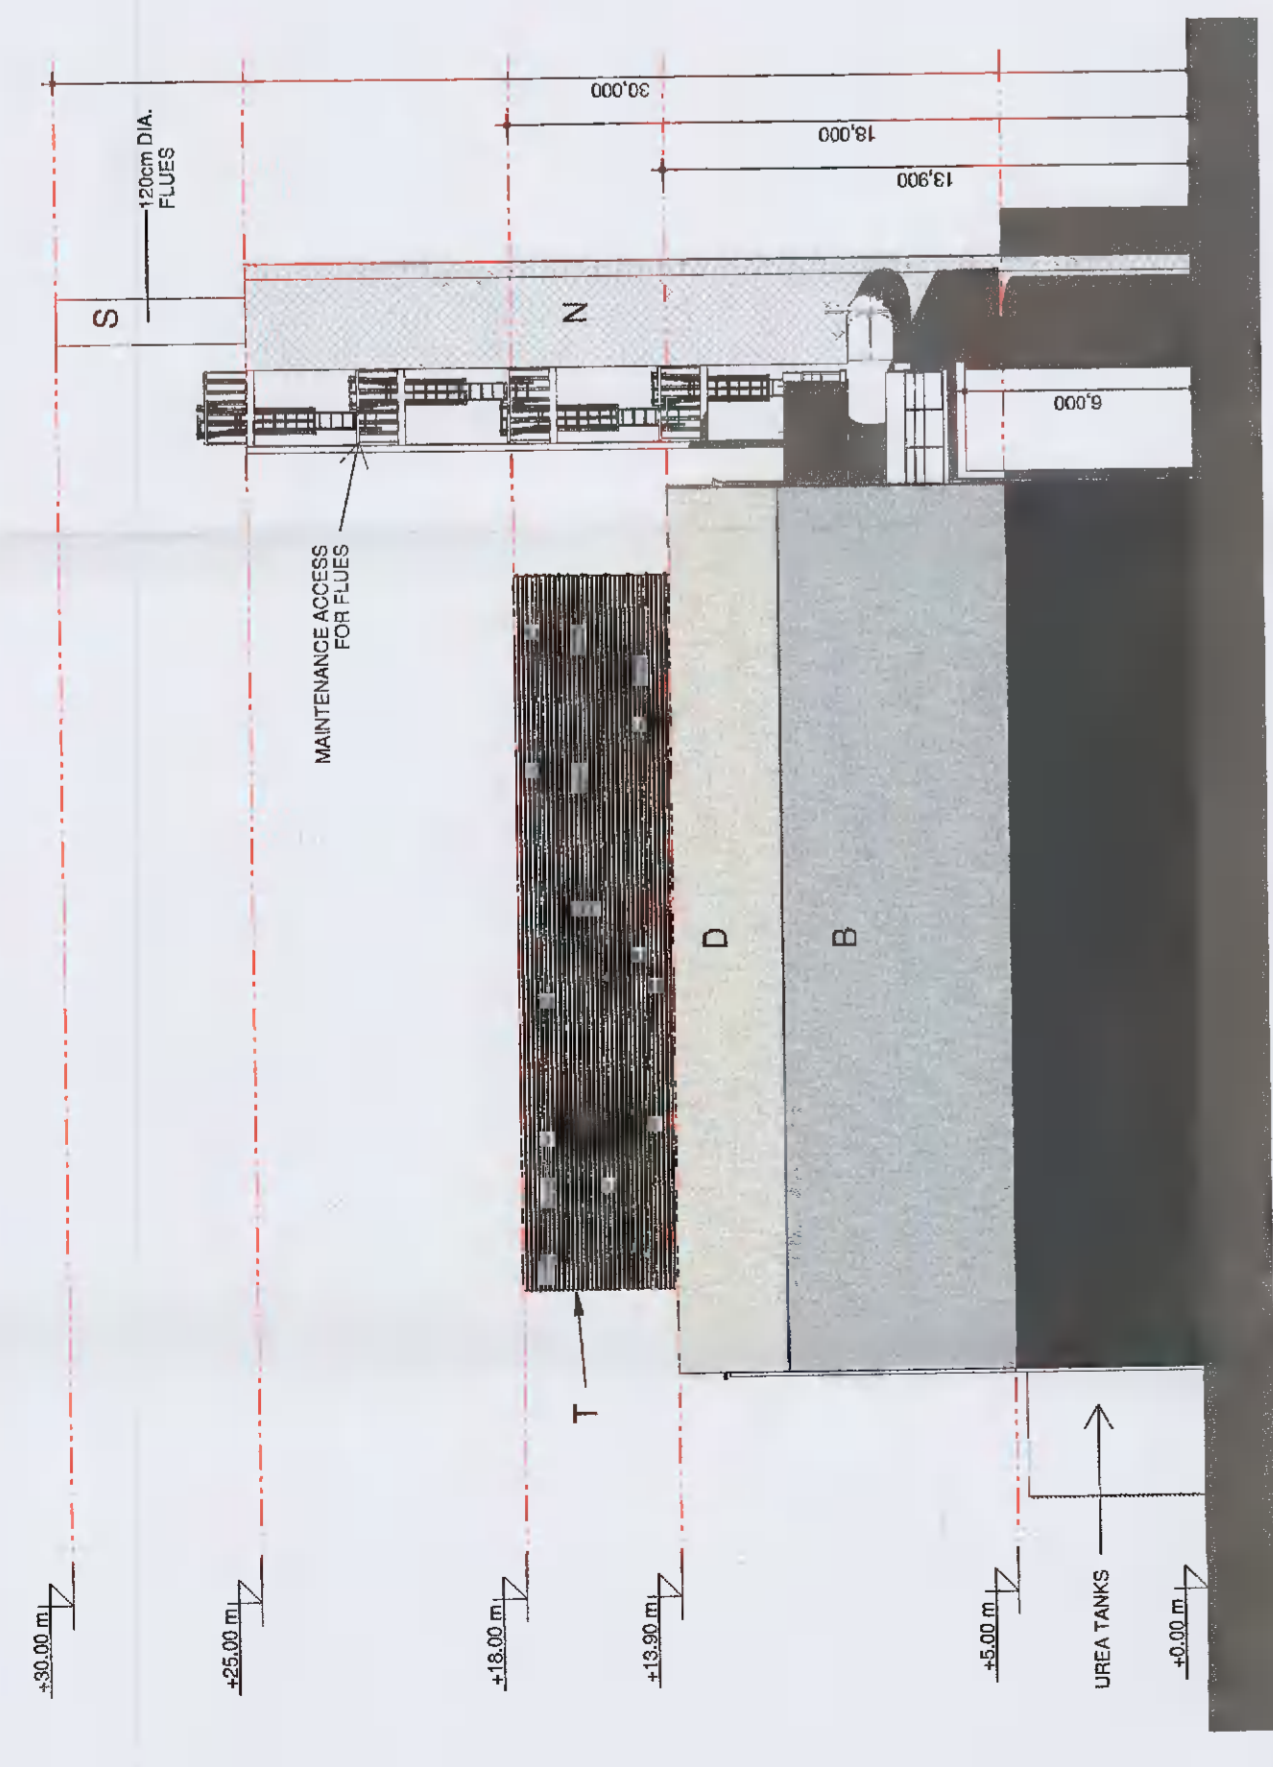


MULTIFUEL POWER PLANT NORTH BUILDING - NORTH
 ELEVATION
 1:200

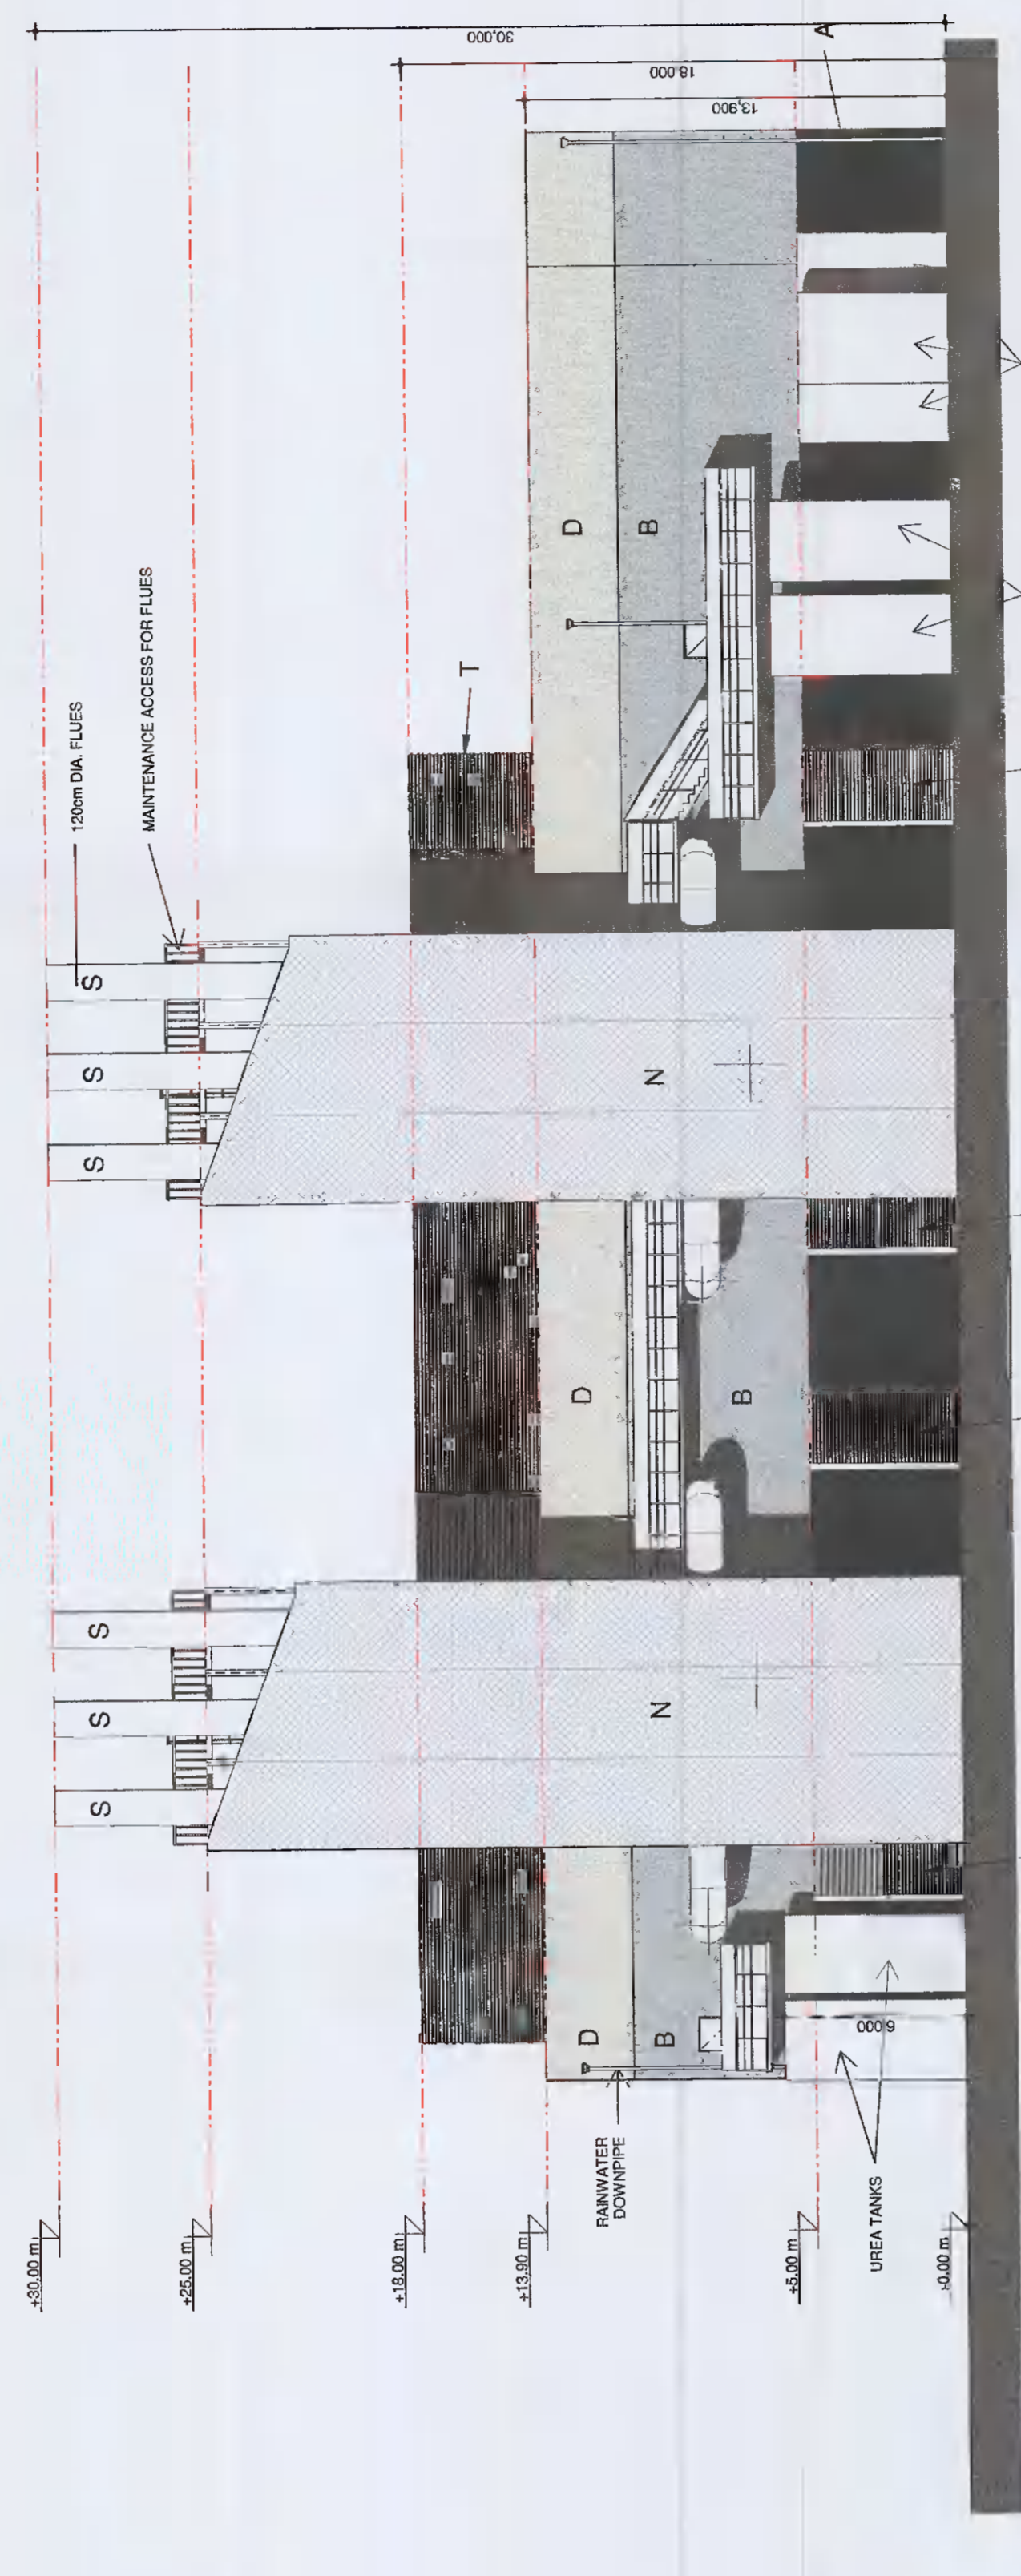


MULTIFUEL POWER PLANT NORTH BUILDING - WEST
 ELEVATION
 1:200

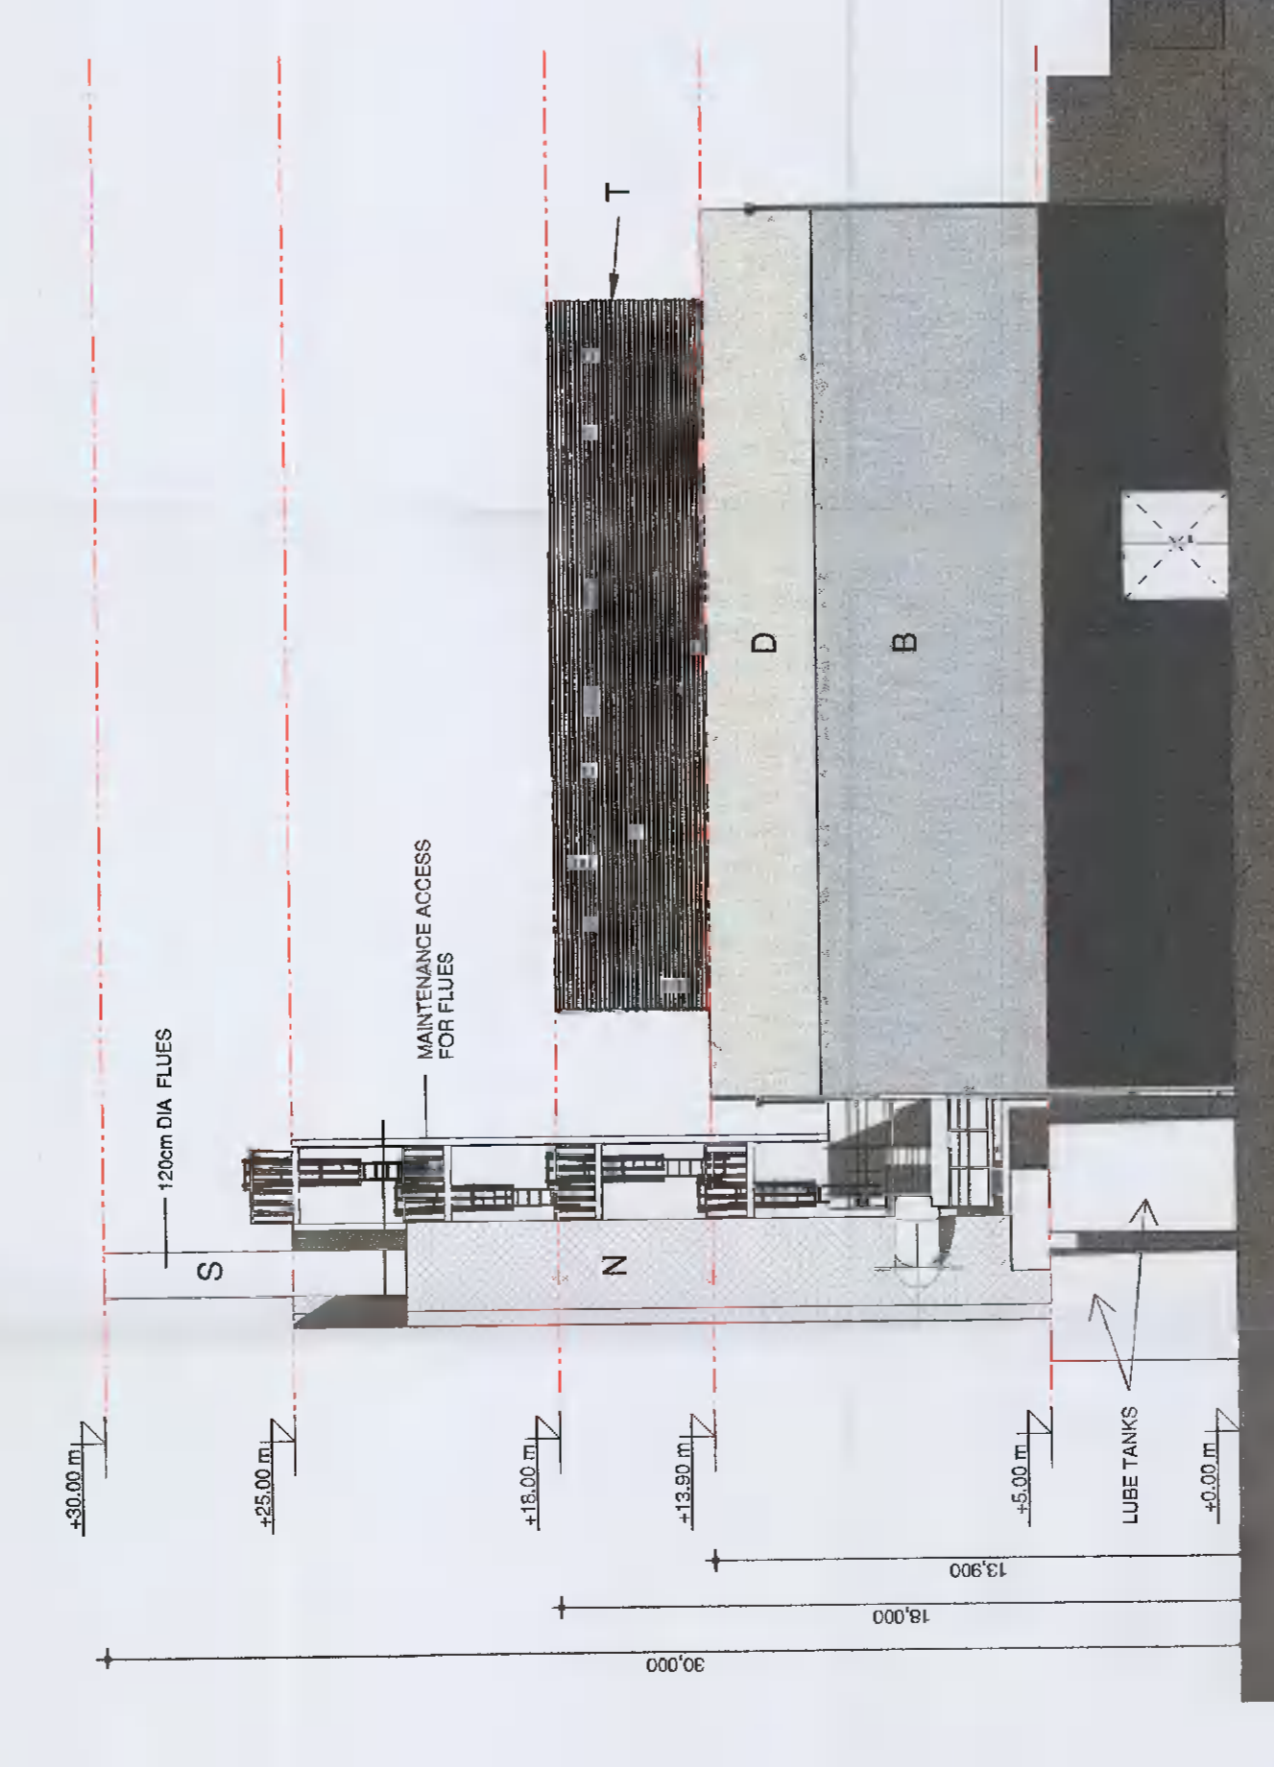

MULTIFUEL POWER PLANT NORTH BUILDING - SOUTH
 ELEVATION
 1:200

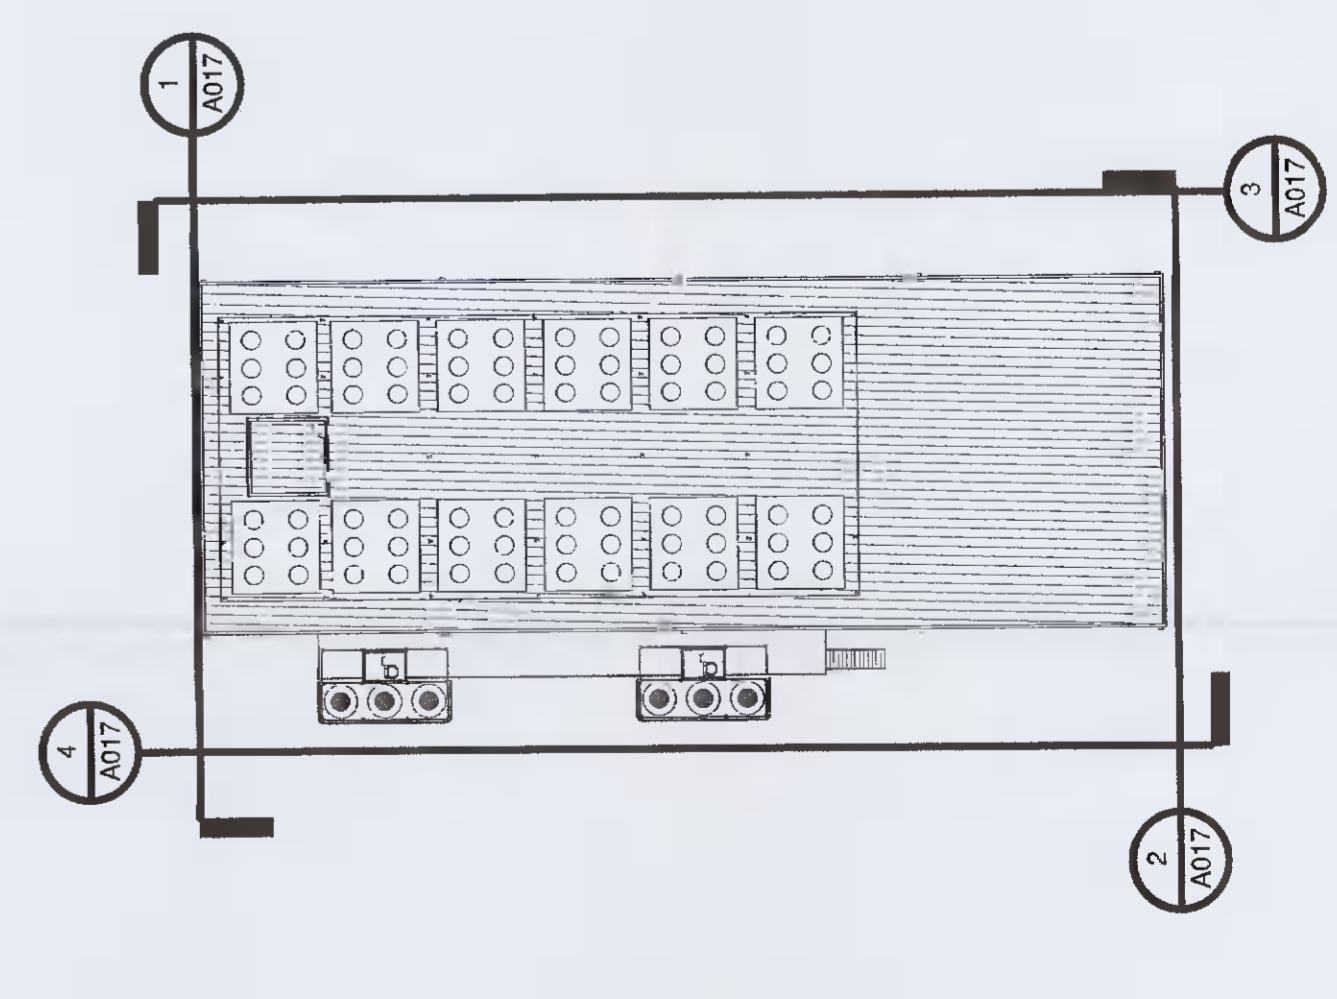

MULTIFUEL POWER PLANT NORTH BUILDING - KEY PLAN
 1:500

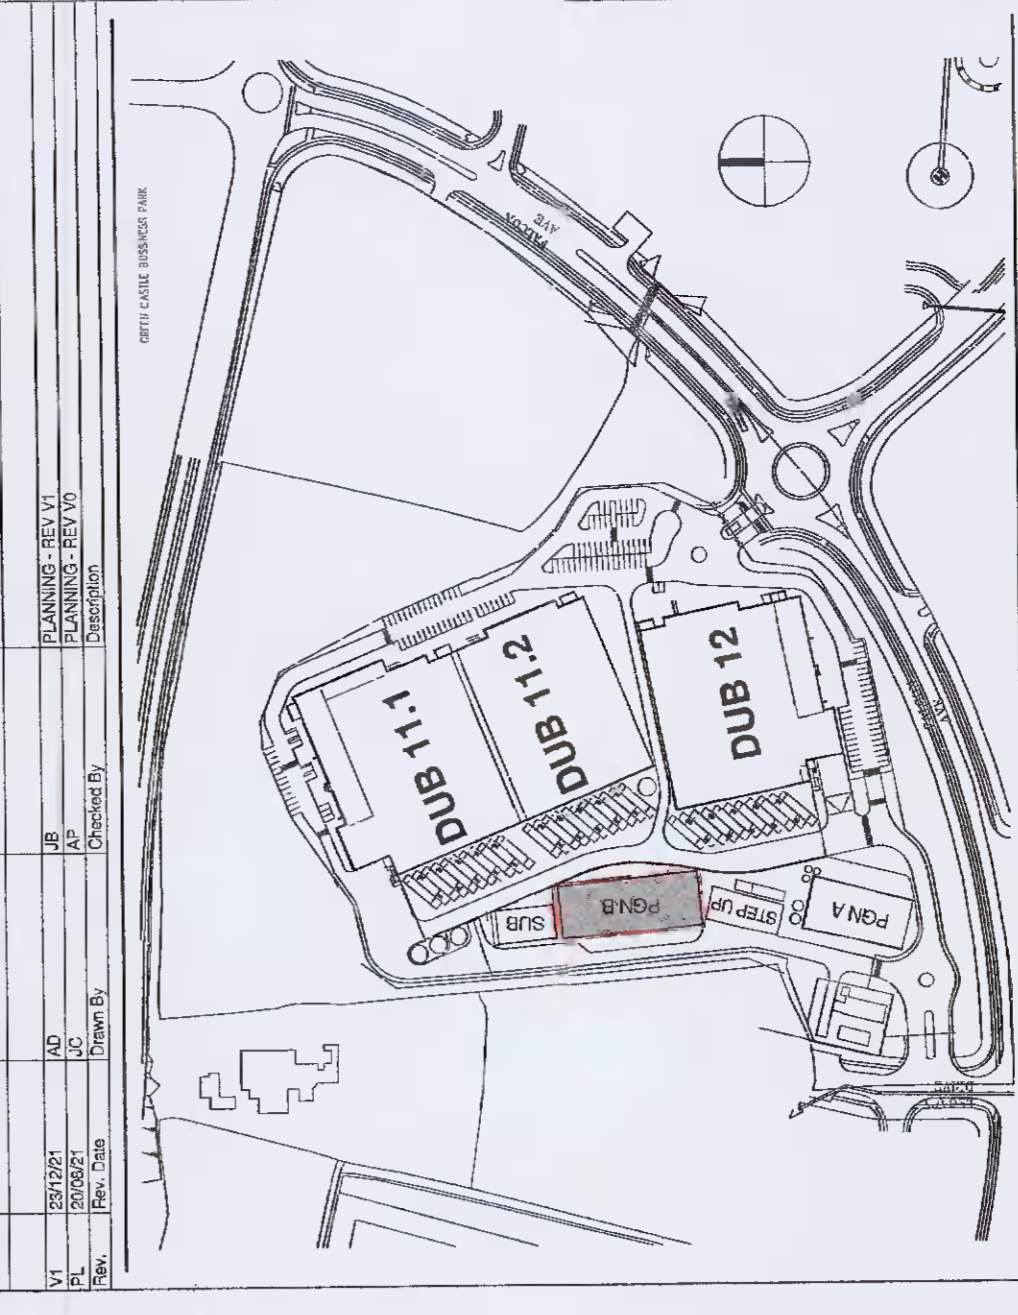

VANTAGE
 VENTURE IN ARCHITECTURE

BURNS MEDONNELL
 2 Connors Avenue, Dublin 15, Ireland
 www.burnsmcd.com

Hyphen
 Hyphen Architecture Ltd
 100 North Circular Road, Dublin 15, Ireland
 www.hyphen.ie

Project name: Multifuel Power Plant Building - North Elevations
 Drawing No: A017
 Date: 05/12/21
 Scale: PL
 Rev: 01
 Project address: Profile Park, Dublin 22, Ireland
 53°19'1.40"N, 6°28'40.86"W

PLANNING SUBMITTAL
 NOT FOR
 CONSTRUCTION