
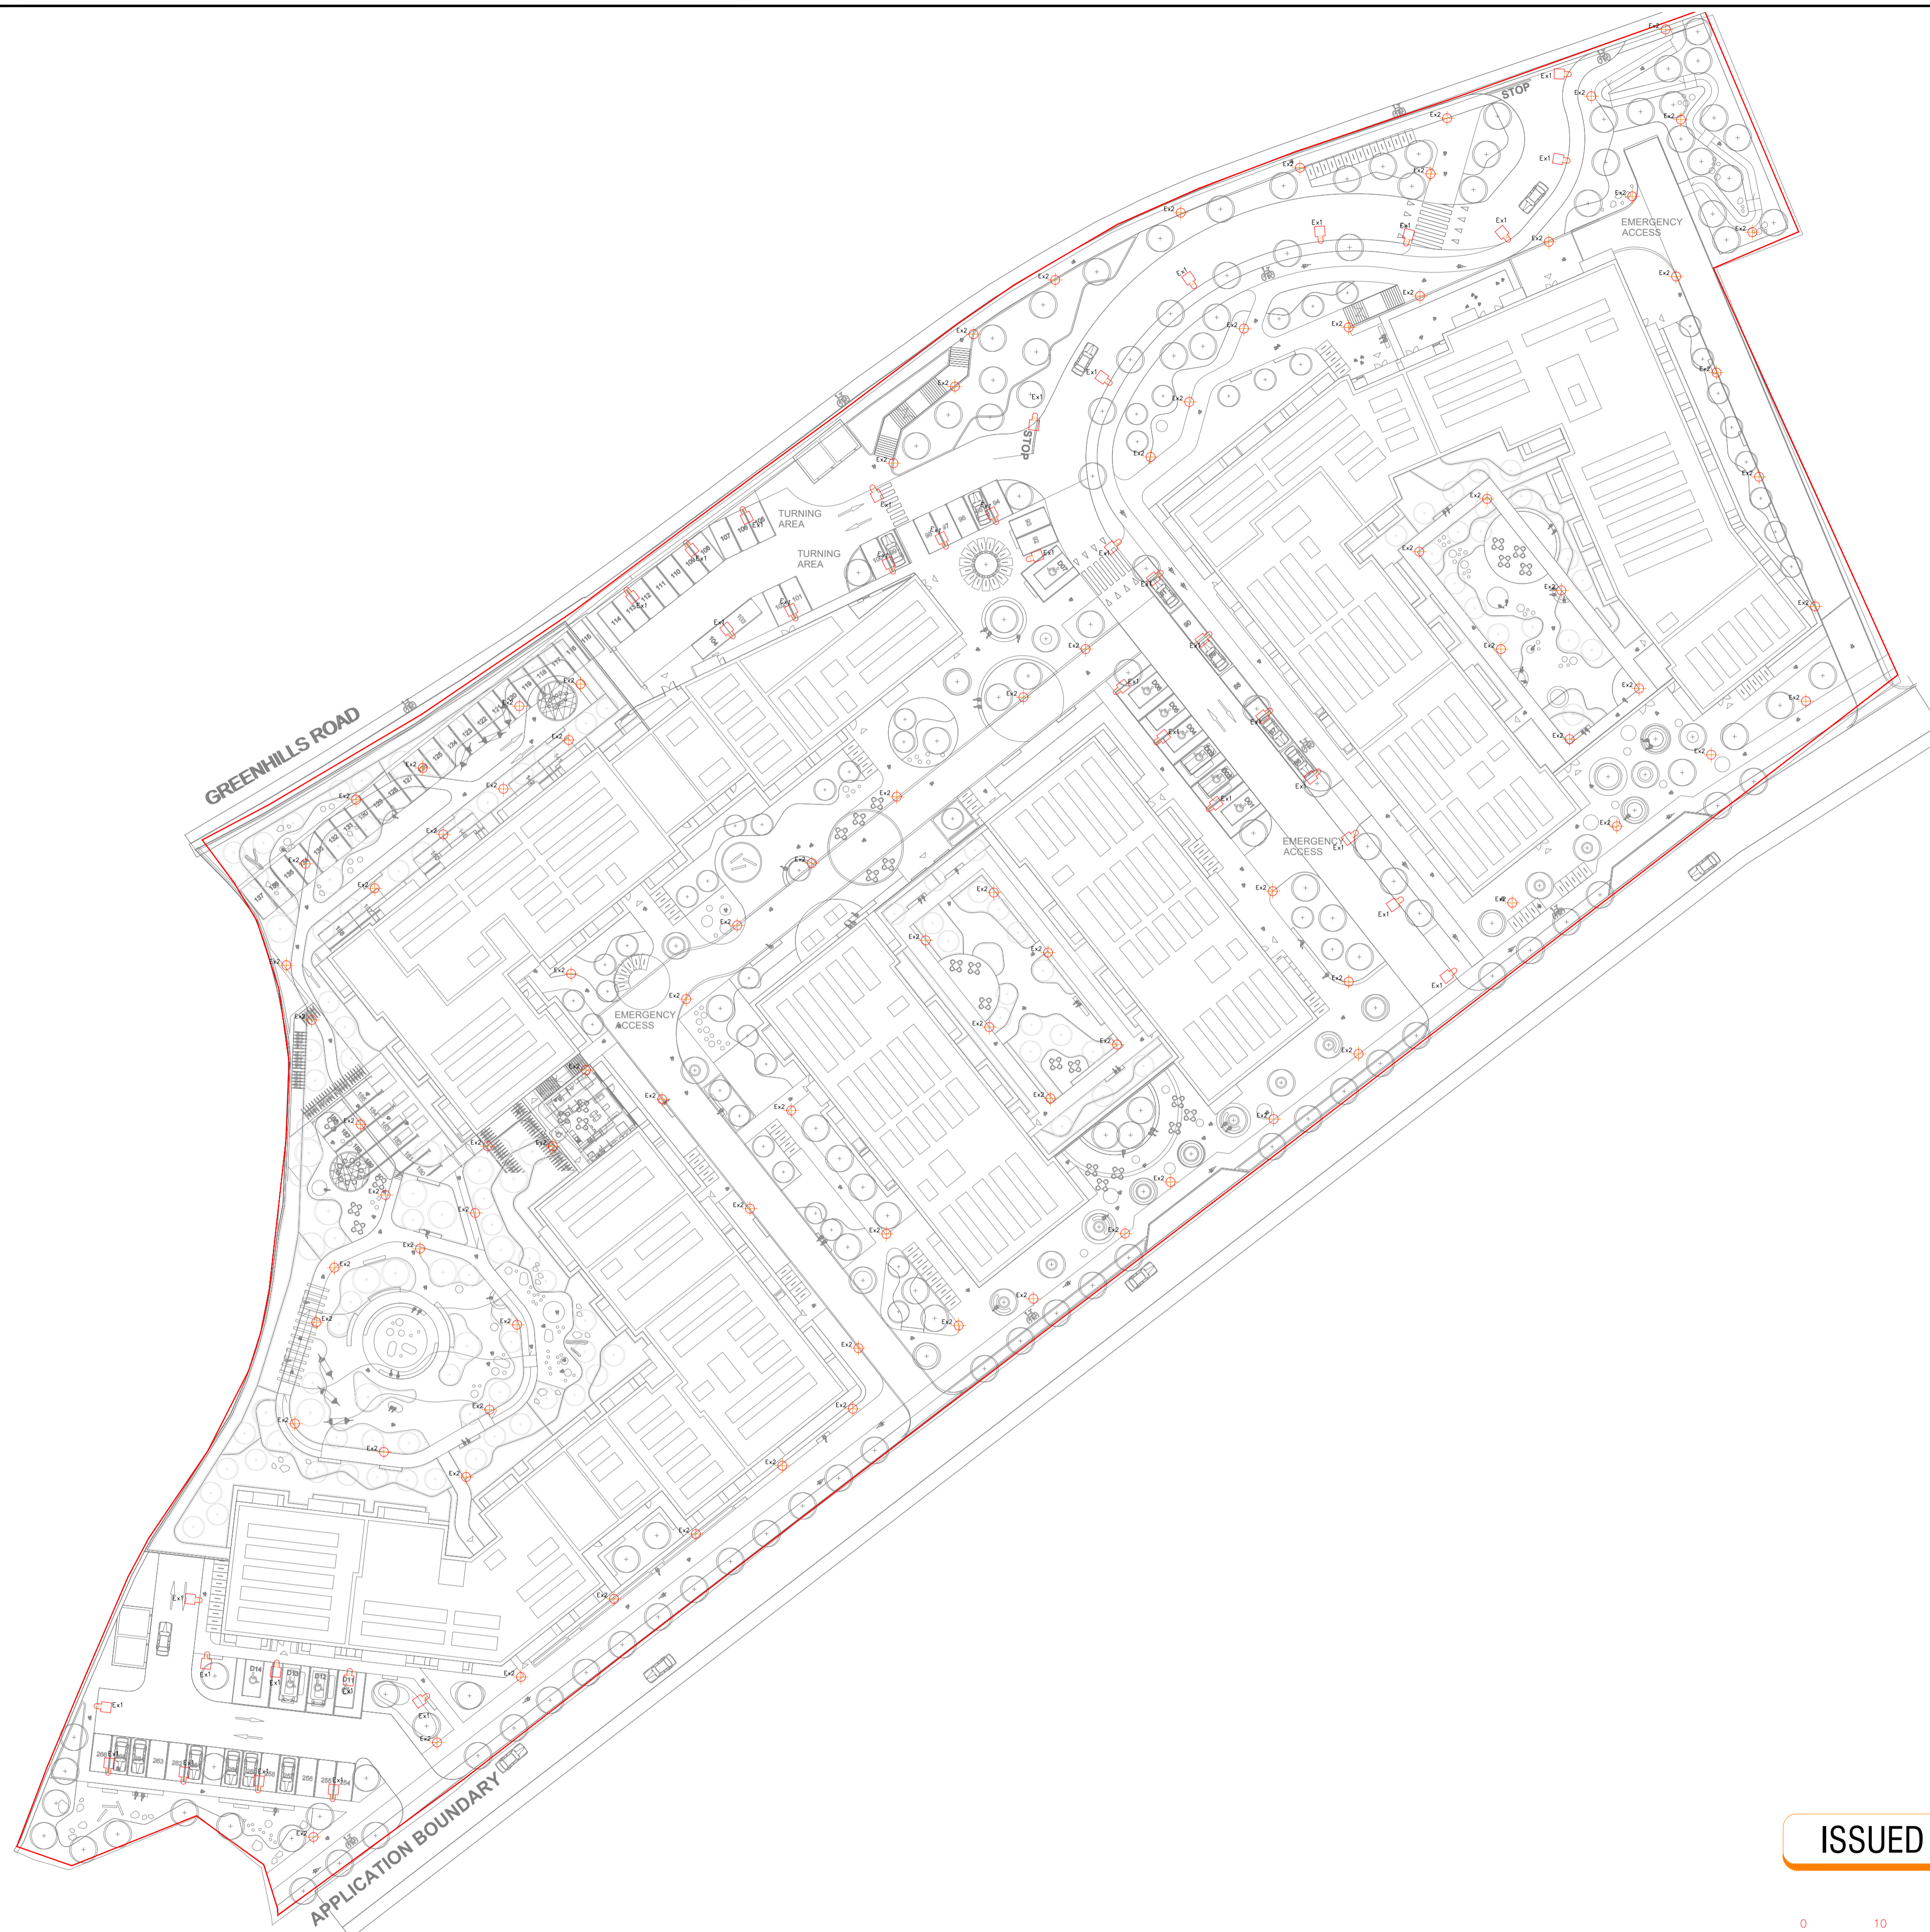



No part of this document may be re-produced or transmitted in any form or stored in any retrieval system of any nature without the written permission from Homan O'Brien Associates as copyright holder except as agreed for use on the project for which the document was originally issued. © Homan O'Brien Associates Copyright.

Symbols Reference:

- Ex1  Thorn Isaro (Code 96634352) 27W LED, 3375Lm, 3000K.
- Ex2  Thorn Johanna LED (Code 96221655) 31W LED, 2061Lm, 3000K, IP66, IK09, c/w 6M Mounting Pole.




Lighting Type EX1
Thorn Isaro

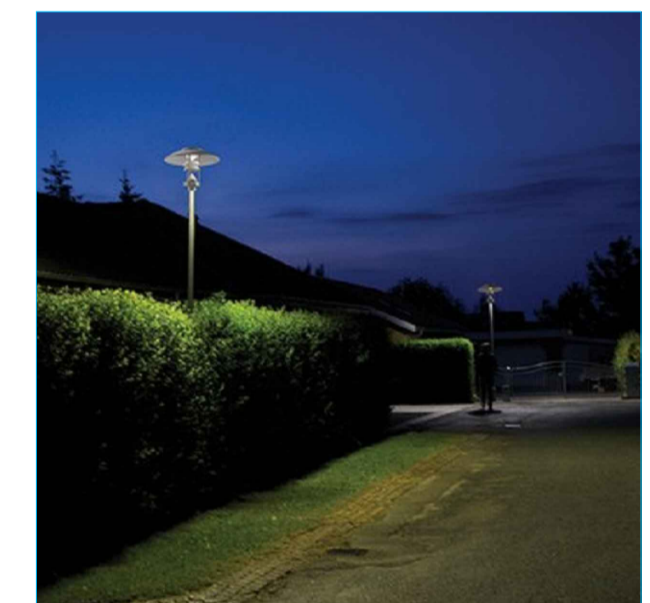

Lighting Type EX2
Thorn Johanna LED

 ISSUED FOR PLANNING



Revision	Issue: P-Preliminary T-Tender CN-Construction A-Approval I-Information	Date	Checked	Revision	Issue: P-Preliminary T-Tender CN-Construction A-Approval I-Information	Date	Checked
	Issued for Planning.	01-06-2021	P01				C.H.
	Issued for Information.	31-05-2021	103				C.H.
	Issued for Information.	26-04-2021	102				C.H.
	Issued for Information.	16-04-2021	101				C.H.

HOMAN O'BRIEN Consulting Engineers
 89 Booterstown Avenue, Blackrock, Co. Dublin.
 Telephone: 2056300, Fax: 2056301
 E-mail: info@homanobrien.ie
 Web: www.homanobrien.ie

Former Chadwicks Site, Greenhills Road, Walkinstown, Dublin. Steeplefield Limited

Electrical Services Installation C+W O'Brien Architects
 Site Layout No. 1 Sarsfield Quay, Dublin 7.
 Site Lighting Layout

Drawing Number	Date	Scale	Drawn	Checked	Issue
2034-E1000	12-04-2021	Refer to Scalebar	K.M/R.B.	S.O.B.	P01