


Proposed Block Plan & Drainage Layout
SCALE 1:200

 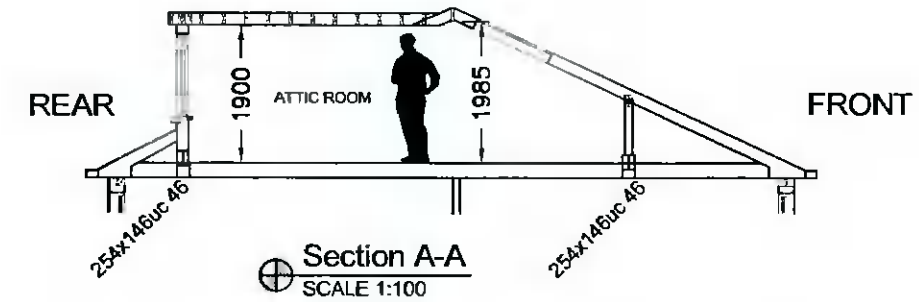


Rafter insulation Kingspan K7 100mm between rafters with Kingspan K18 37.5mm plasterboard backed.

Dormer wall insulation Kingspan K8 80mm wall between timbers & K18 37.5mm plasterboard backed.

Dormer roof insulation Kingspan K7 100mm in joists & K18 37.5mm plasterboard backed.

DRAINAGE LEGEND



P	ISSUED FOR PLANNING	TW	MAR' 2022
REV:	REVISION TITLE:	DRN:	CHD: DATE:

Architectural Planning

4 CARRIGMORE CLOSE, AYLESBURY,
Dublin 24 - Ph: 01 4148358

CLIENT:
STUART & CHRISTINA VALENTINE

JOB TITLE:
PROPOSED WORKS AT 95 DALEPARK ROAD,
AYLESBURY, TALLAGHT, DUBLIN 24

TITLE:
**PROPOSED BLOCK PLAN,
DRAINAGE LAYOUT & SECTION
A-A**

SCALE: as shown INITIALS: TW DATE: FEB' 2022

JOB No: S478 DRAWING No: 004 REV: P

THIS DRAWING IS ISSUED FOR PLANNING PERMISSION ONLY, AND IS NOT A CONSTRUCTION DRAWING

NOTES:
This drawing is to be read in conjunction with all relevant Engineers drawings.
Do not scale use figured dimensions ONLY.
All dimensions in millimeters unless otherwise stated.
All dimensions to be checked on site.
All building works to comply with current building regulations & in accordance with Homebond Standards.