


A10084

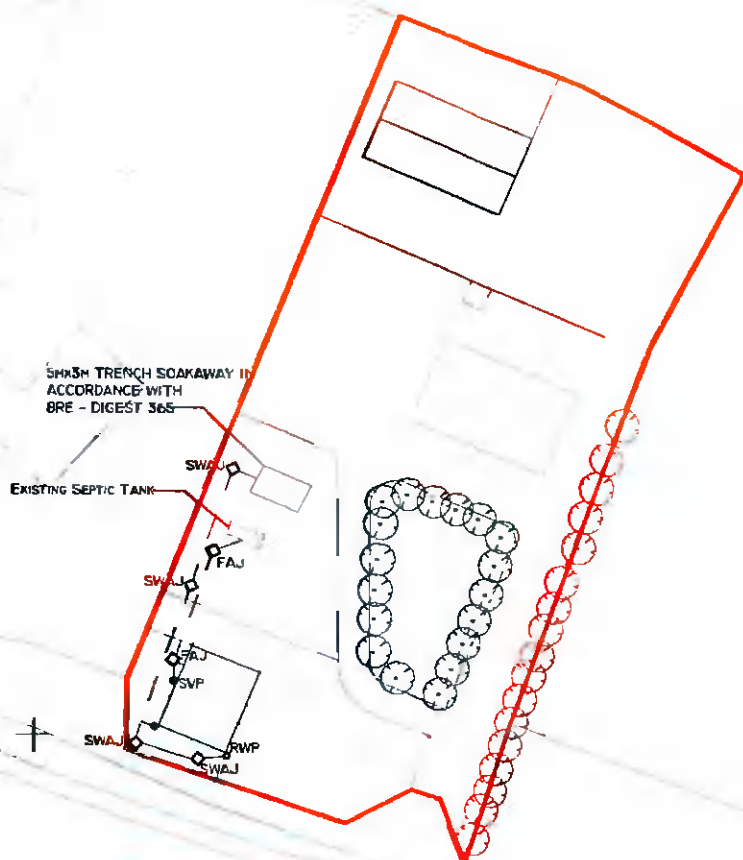

MCDONAGH'S LANE

RP	ISSUED FOR RETENTION PERMISSION	JW	JW	SEP 2017
REV	REVISION TITLE	DPN	CHK	DATE

APPLICANT B. McDONAGH JUNIOR	
Jason Walsh Architectural & Engineering 81 ARD MOR DRIVE TALLAGHT Dublin 24 Phone: 085 8070 432 Email: gj.services@gmail.com	JOB TITLE RETENTION PERMISSION FOR SINGLE STOREY TIMBER STRUCTURE AT MCDONAGH'S LANE BRITTAS, COUNTY DUBLIN
THIS DRAWING IS ISSUED FOR RETENTION PERMISSION AND IS NOT A CONSTRUCTION DRAWING	

DRAWING TITLE DRAINAGE LAYOUT		
SCALE 1:500	INITIALS JW	DATE 22/09/2017
JOB NO BMcDJ/17	DRAWING NO BMcDJ/17/05	REV RP

244.63