



1 GA - CCB - GROUND FLOOR PLAN
1 : 100

CCB = CLIENT CONTROL BUILDING

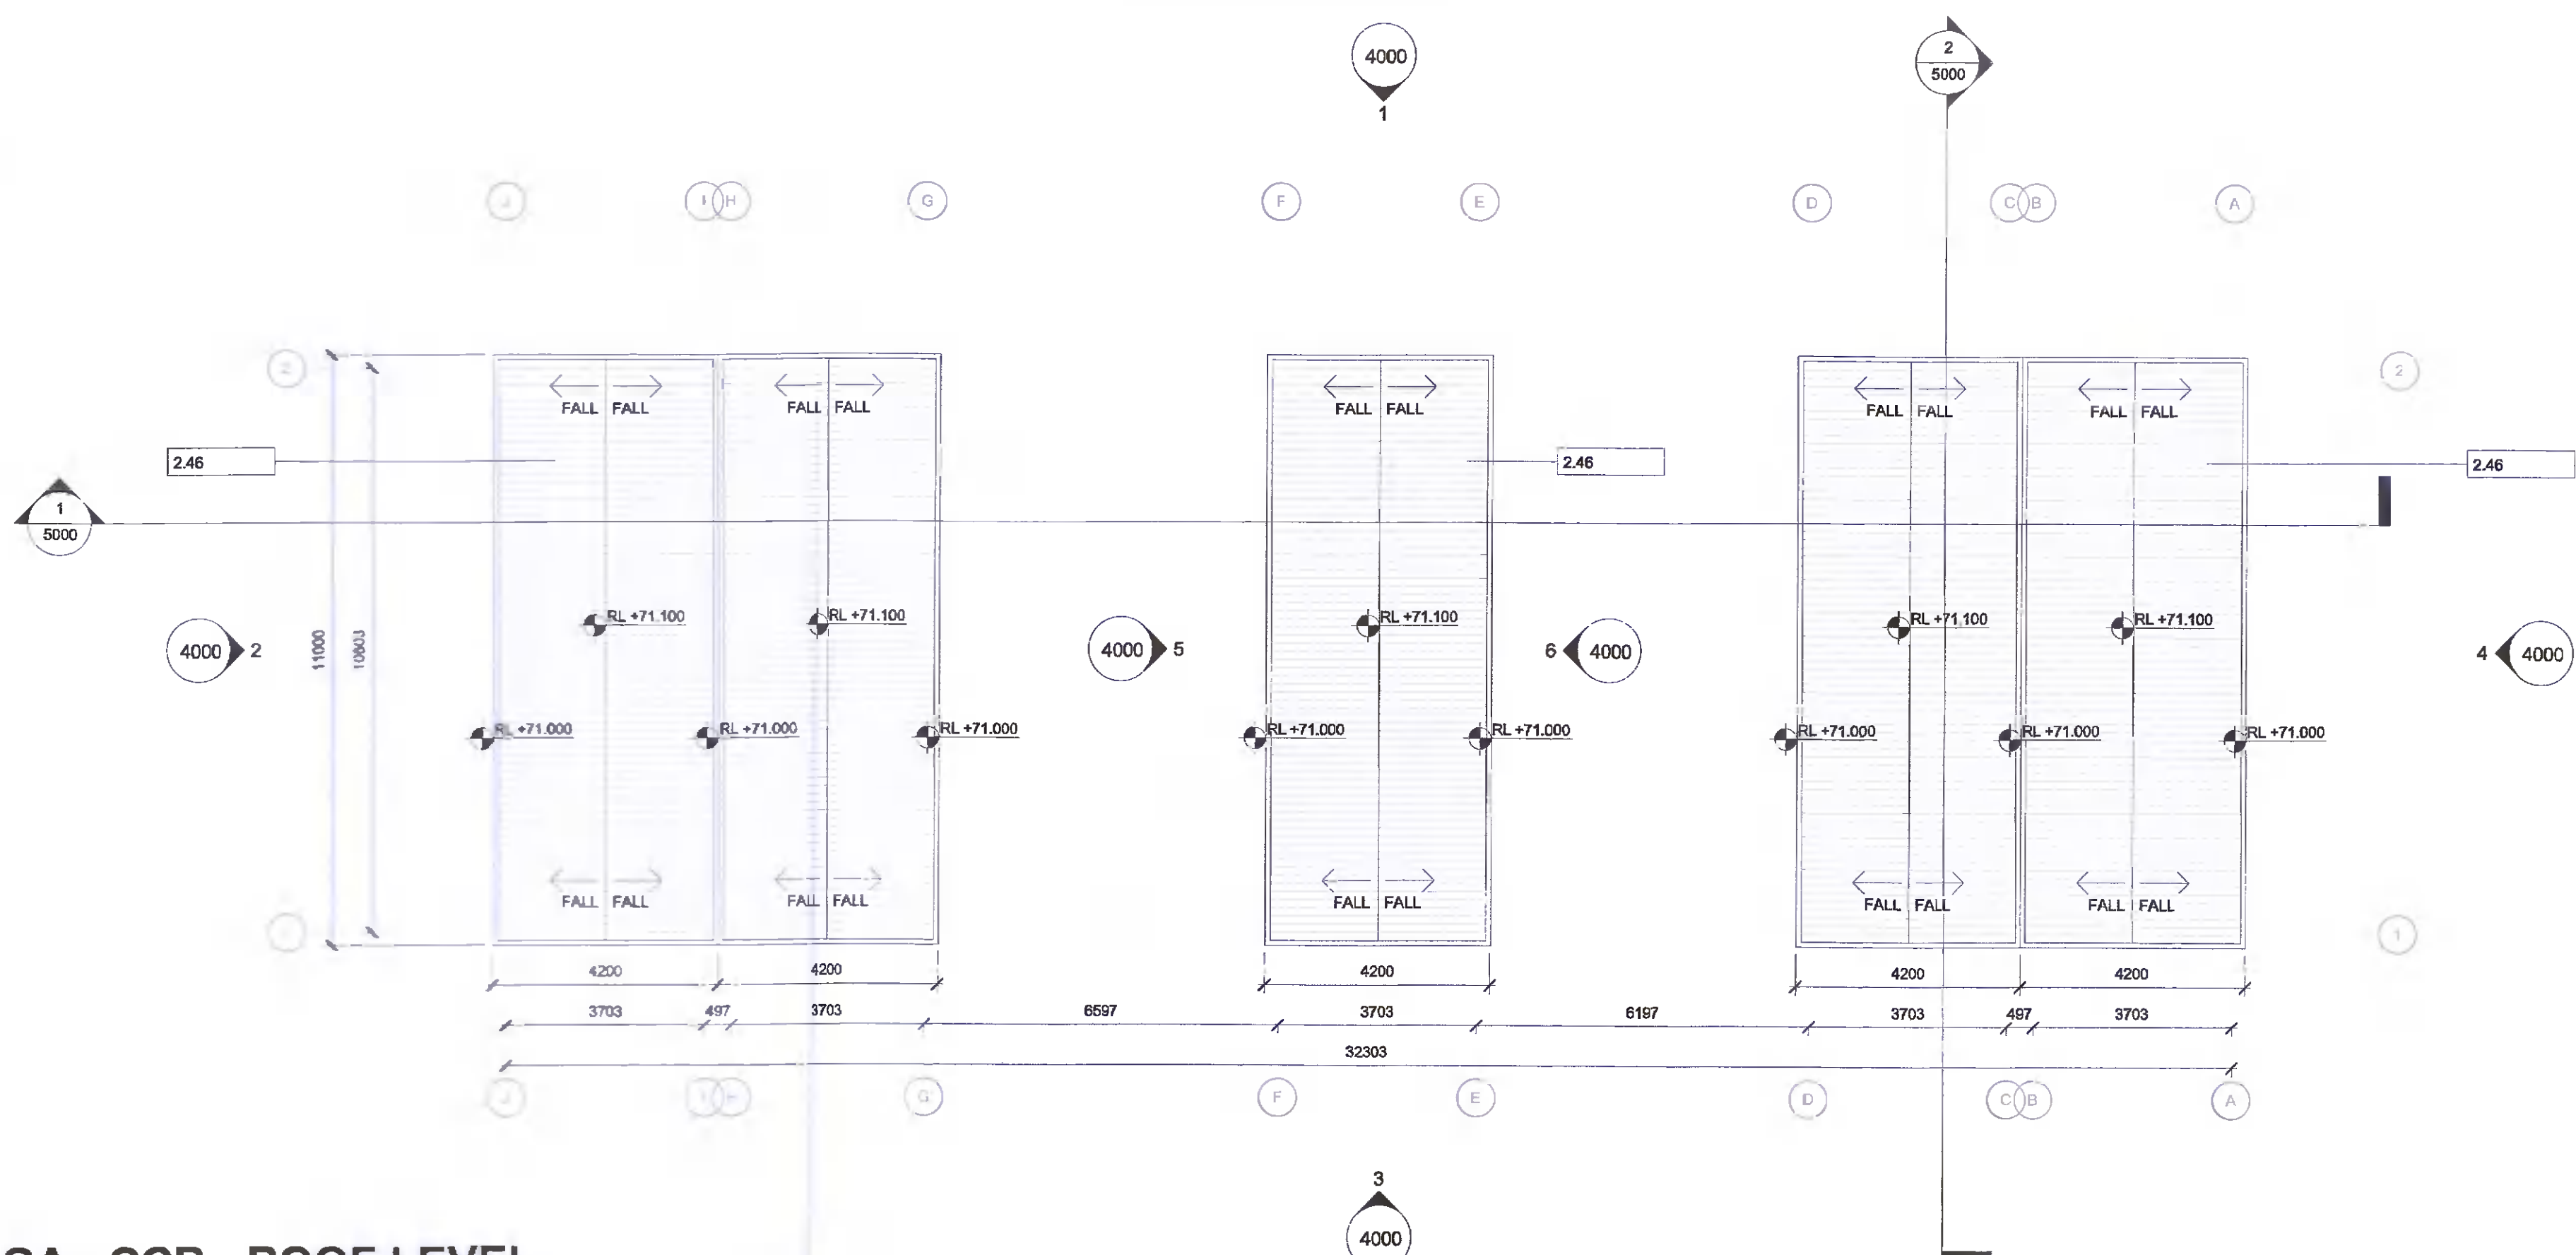

2 GA - CCB - ROOF LEVEL
1 : 100

CCB = CLIENT CONTROL BUILDING

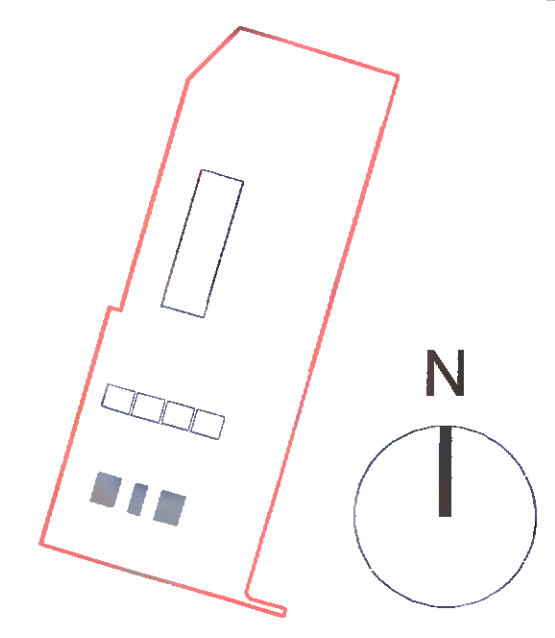

KEY PLAN

CLIENT

edgeconnex
BCEI
BURR COMPUTER ENVIRONMENTS, INC.

10400 Rodgers Road
Houston, Texas 77070
Phone: 281-374-8644
Fax: 281-374-8992

HV Main Contractor

H&MV
ENGINEERING
ELECTRICAL & MECHANICAL

STRUCTURAL ENGINEER

Clifton Scannell Emerson
Associates

ARCHITECT

Henry J Lyons

LEGEND

Keynote Legend	
Key Value	Keynote Text
2.4	EXTERNAL GRADE STEEL DOORS POWDER COATED, FINISH - COLOUR RAL 7012 BASALT
2.45	CORRUGATED METAL PANEL TO MATCH THE COLOUR OF THE SELECTED CLADDING PANELS ON GIS BUILDING, FINISH - COLOUR RAL 7012 BASALT
2.46	CORRUGATED METAL ROOF, FINISH - COLOUR RAL 7012 BASALT

NOTES

DISCIPLINE

Henry J Lyons

PROJECT

ESSDUB98 - KISHOGE 110kV
SUBSTATION

Rev	Date	Description	By	Ckd
P1	14/04/2022	ISSUED FOR PLANNING	CDA	JM

CONFIDENTIAL INFORMATION: This drawing/document and all design details, inventions or developments covered or derived thereby are confidential and the exclusive property of the owner (or its affiliates), which reserve all rights in this drawing/document. Copying, reproduction, duplication, or distribution to a third party, in whole or in part, is forbidden unless expressly authorised in writing.

Drawn by CDA	Checked by JM	Date 01/10/21
Scale (@ A1) 1 : 100	Status code A1	Project number 95018

Drawing Title
PROPOSED CLIENT CONTROL BUILDING FLOOR PLANS

Drawing Number (Project Code-Originator-Volume-Level-Type-Role-Sheet no.) ESSDUB98- HJL- 02- XX- DR- A-2000	Revision P1
---	-----------------------