




**1** PERMITTED GA - ESB BUILDING GROUND FLOOR PLAN  
SCALE: 1:100

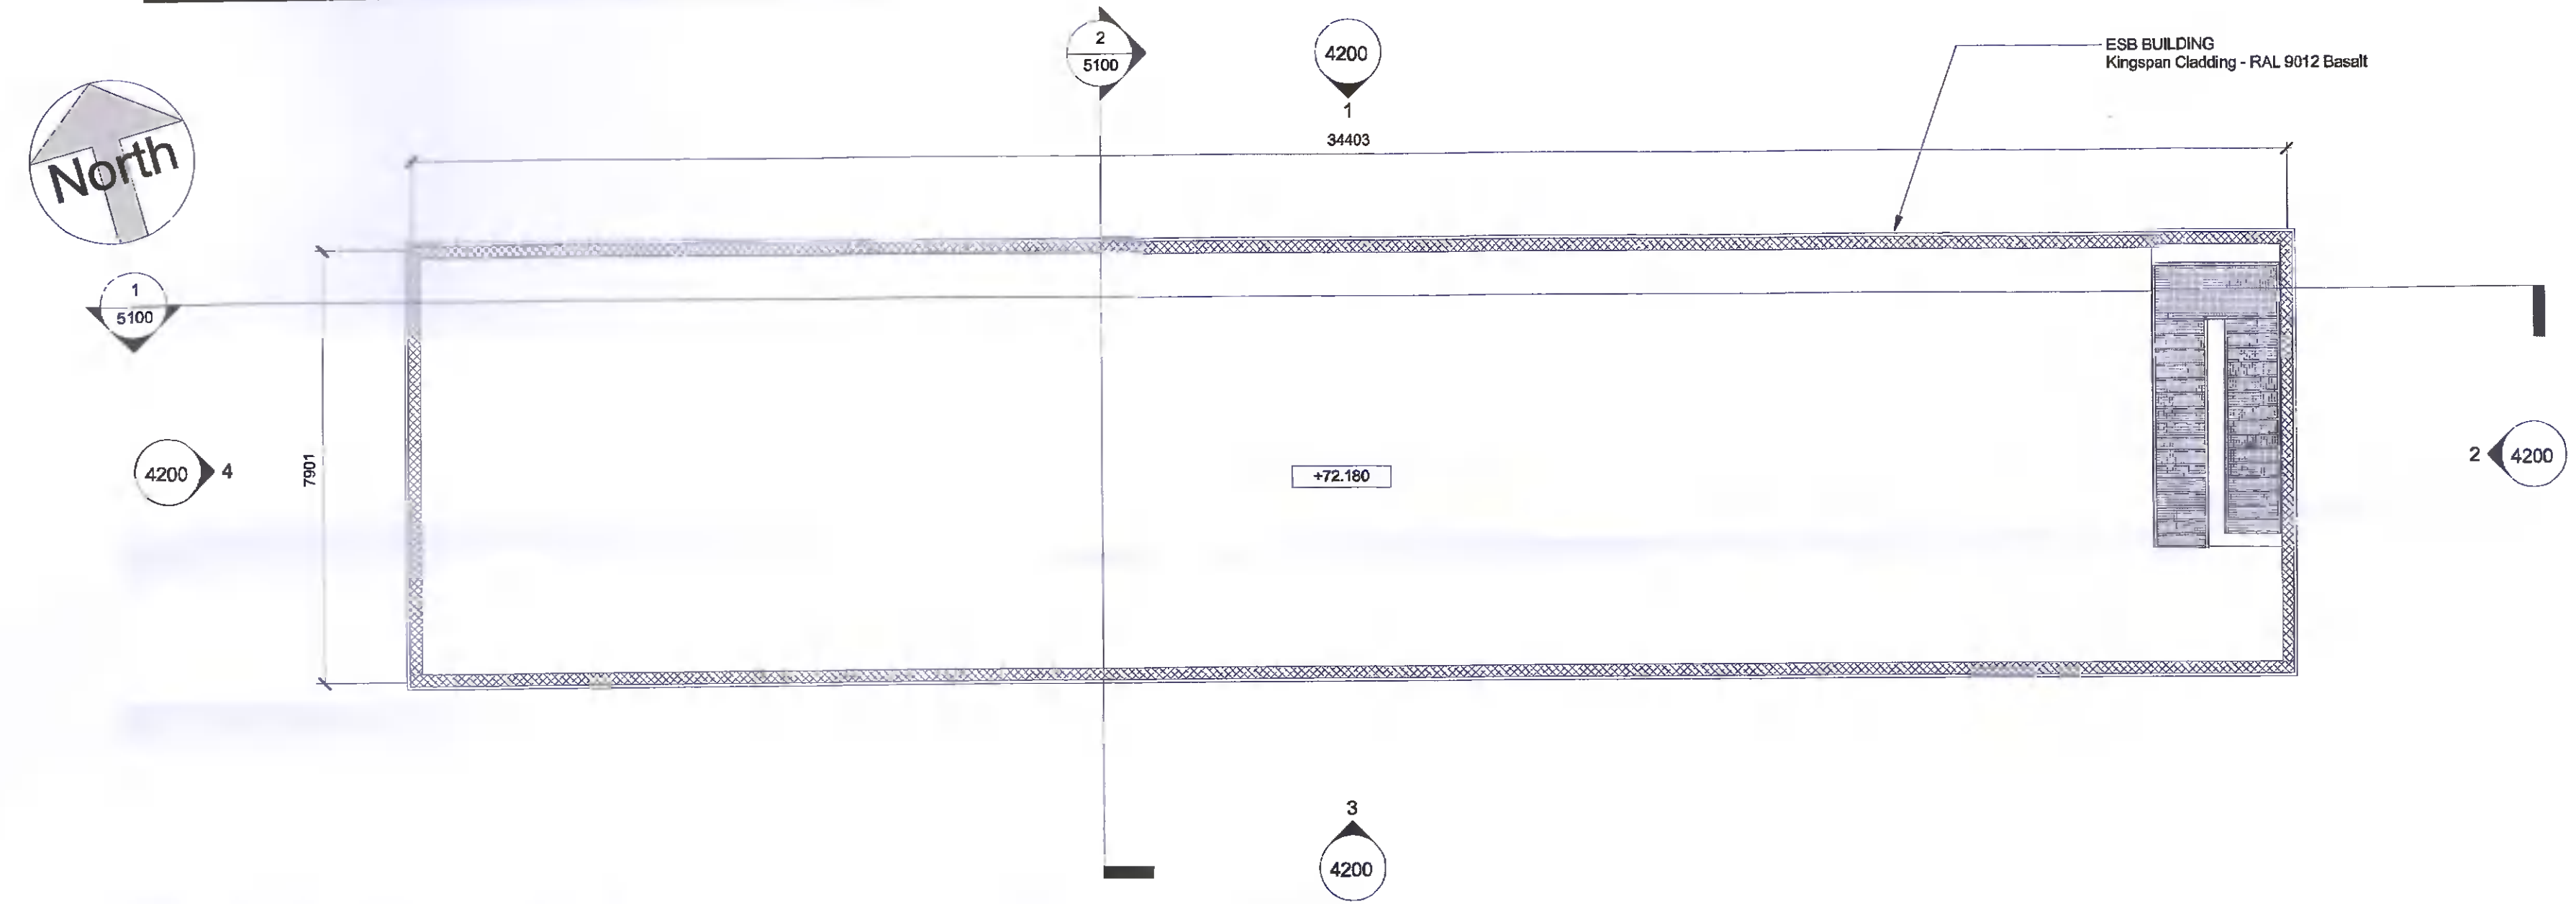


**2** PERMITTED GA - ESB BUILDING FIRST FLOOR PLAN  
SCALE: 1:100

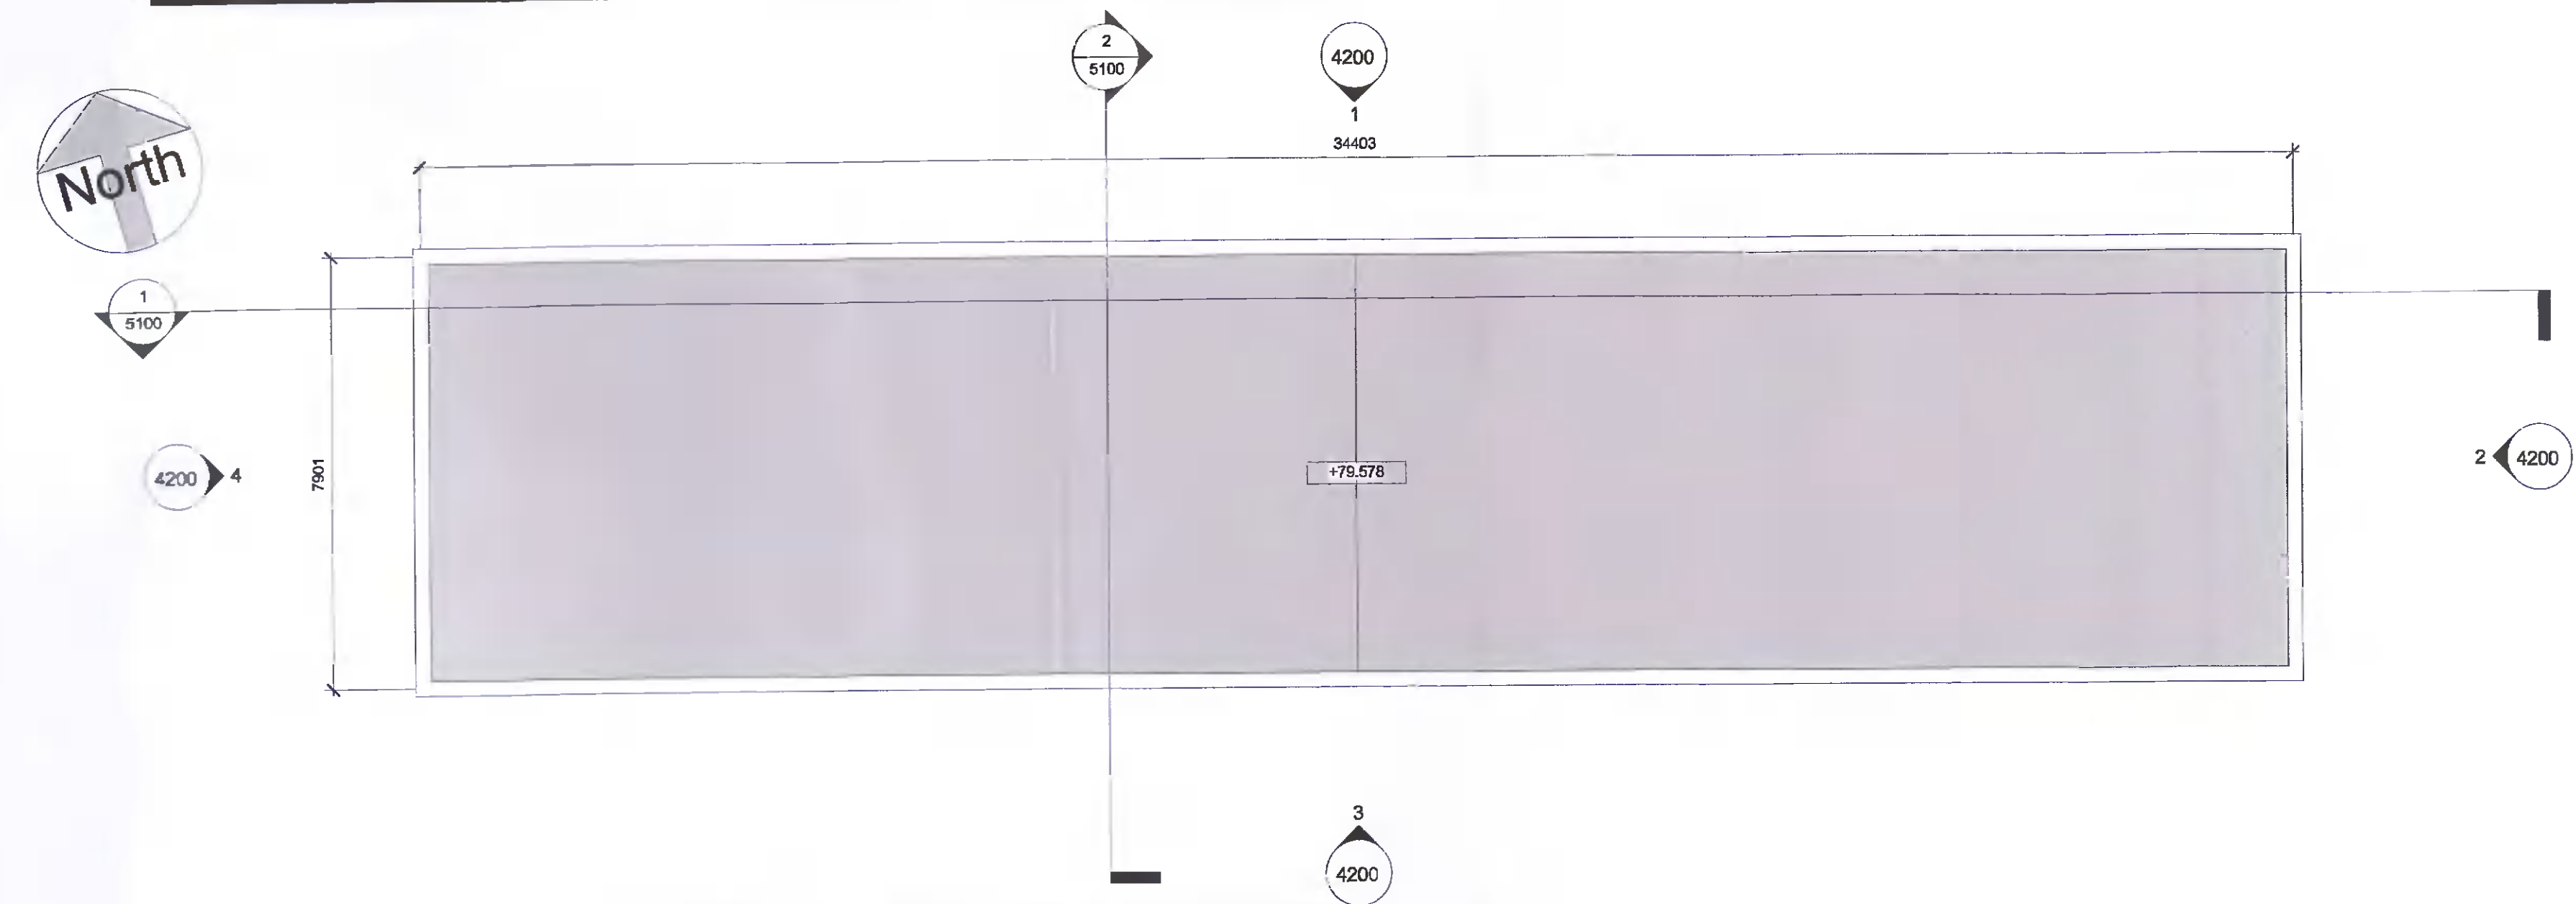


**3** PERMITTED GA - ESB BUILDING ROOF PLAN  
SCALE: 1:100

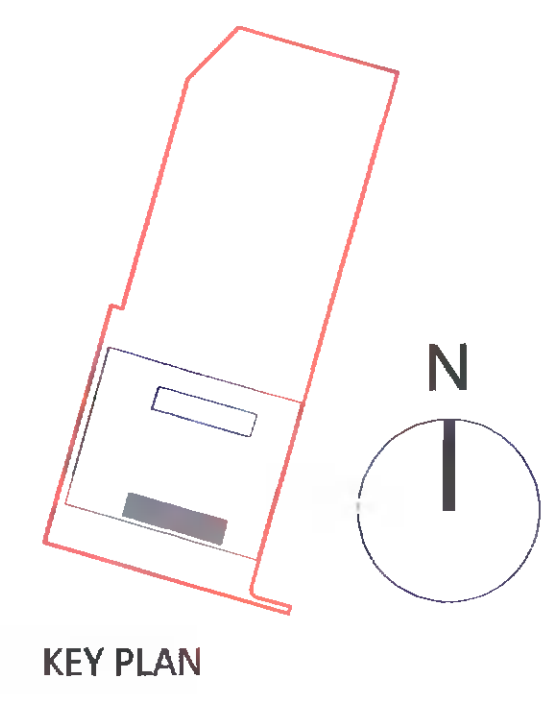

CLIENT  
  
  
 BURR COMPUTER ENVIRONMENTS, INC.  
 10400 Rodgers Road Phone: 281-374-8644  
 Houston, Texas 77070 Fax: 281-374-8992

HV Main Contractor  

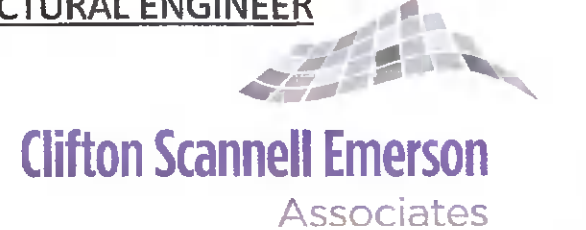
STRUCTURAL ENGINEER  


ARCHITECT  
**Henry J Lyons**

LEGEND

NOTES

DISCIPLINE  
**Henry J Lyons**

PROJECT  
 ESSDUB98 - KISHOGE 110kV  
 SUBSTATION

Rev	Date	Description	By	Ckd
P1	14/04/2022	ISSUED FOR PLANNING	CDA	JM

CONFIDENTIAL INFORMATION: This drawing/document and all design details, inventions or developments covered or derived thereby are confidential and the exclusive property of the owner (or its affiliates), which reserve all rights in the drawing/document. Copying, reproduction, duplication, or distribution to a third party, in whole or in part, is forbidden unless expressly authorised in writing.

Drawn by CDA	Checked by JM	Date 26/11/21
Scale (@ A1) 1:100	Status code A1	Project number 950918

Drawing Title  
**PERMITTED ESB BUILDING  
 PLANS**

Drawing Number  
 (Project Code-Originator-Volume-Level-Type-Role-Sheet no.)  
 ESSDUB98- HJL- 04- XX- DR- A-2200 **P1**