

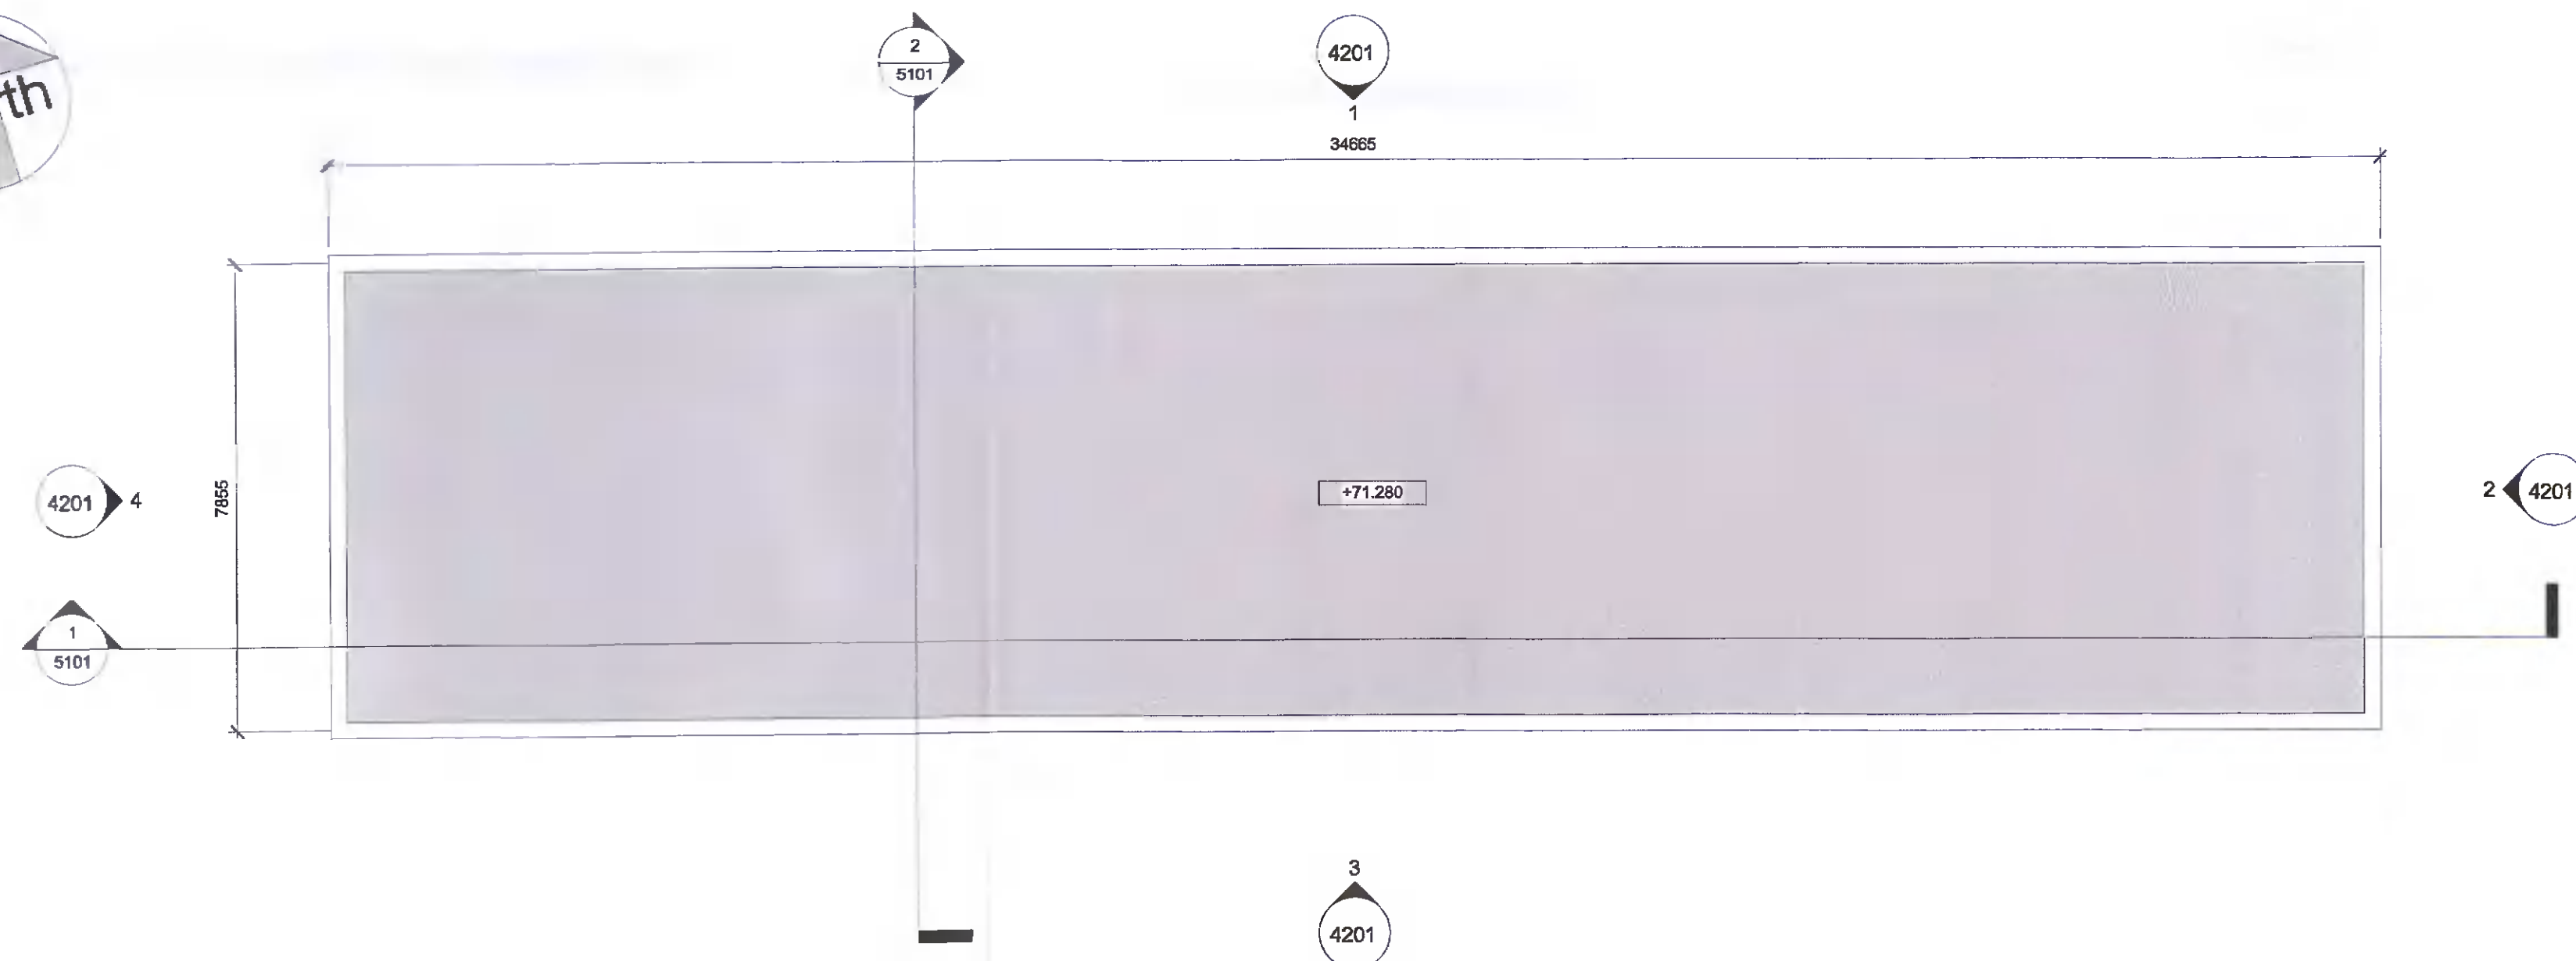


1 PERMITTED GA - TRANSFORMER BUILDING GROUND FLOOR PLAN
SCALE: 1 : 100

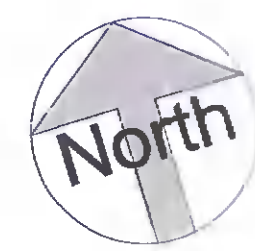

2 PERMITTED GA - TRANSFORMER BUILDING ROOF PLAN
SCALE: 1 : 100

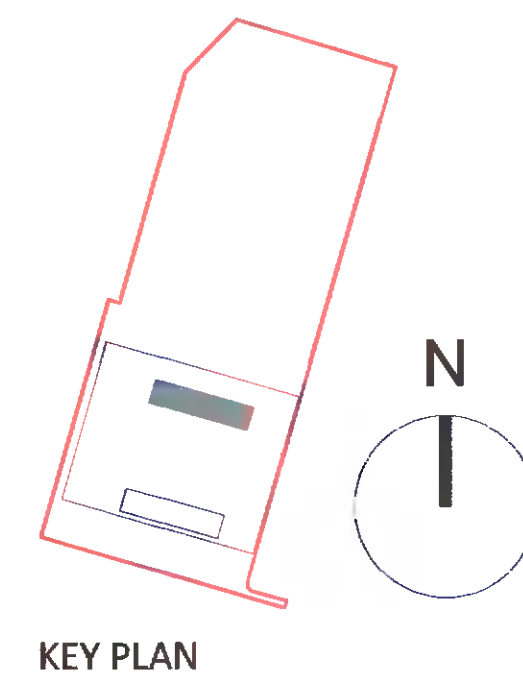

KEY PLAN

CLIENT




10400 Rodgers Road
Houston, Texas 77070
Phone: 281-374-8644
Fax: 281-374-8992

HV Main Contractor



STRUCTURAL ENGINEER

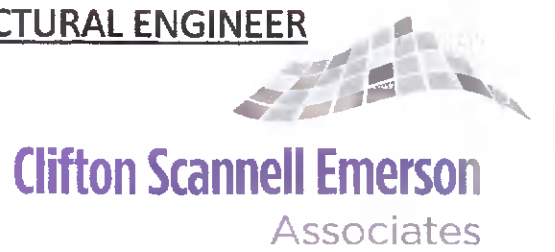

ARCHITECT

Henry J Lyons

LEGEND

NOTES

DISCIPLINE

Henry J Lyons

PROJECT

ESSDUB98 - KISHOGE 110kV
SUBSTATION

Rev	Date	Description	By	Ckd
P1	14/04/2022	ISSUED FOR PLANNING	CDA	JM

CONFIDENTIAL INFORMATION: This drawing/document and all design, details, inventions or developments covered or derived thereby are confidential and the exclusive property of the owner (or its affiliates), which reserve all rights in the drawing/document. Copying, reproduction, duplication, or distribution to a third party, in whole or in part, is forbidden unless expressly authorised in writing.

Drawn by CDA	Checked by JM	Date 26/11/21
Scale (@ A1) 1 : 100	Status code A1	Project number 950918

Drawing Title
**PERMITTED TRANSFORMER
BUILDING PLANS**

Drawing Number (Project Code-Originator-Volume-Level-Type-Role-Sheet no.) ESSDUB98- HJL- 04- XX- DR- A-2201	Revision P1
---	-----------------------