



1 GA - TRANSFORMER YARD - EAST ELEVATION
1 : 100

2 GA - TRANSFORMER YARD - WEST ELEVATION
1 : 100

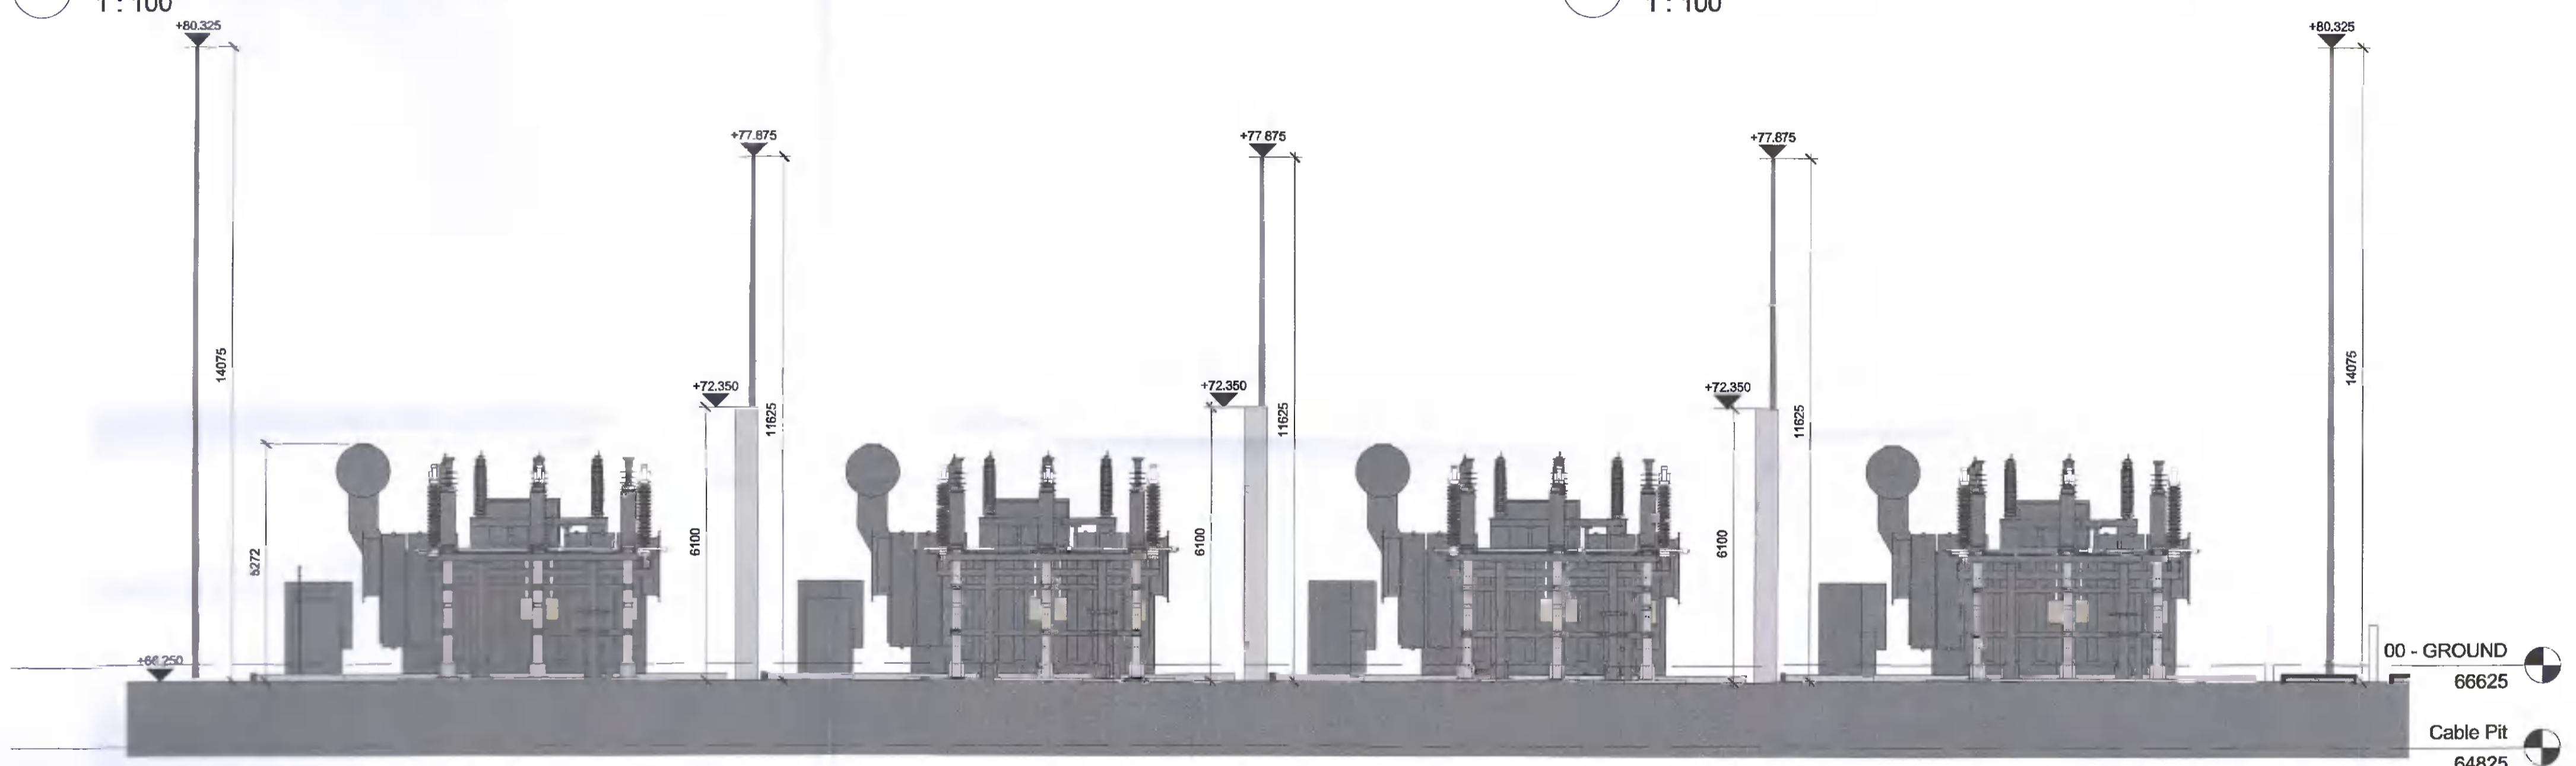

3 GA - TRANSFORMER YARD - NORTH ELEVATION
1 : 100

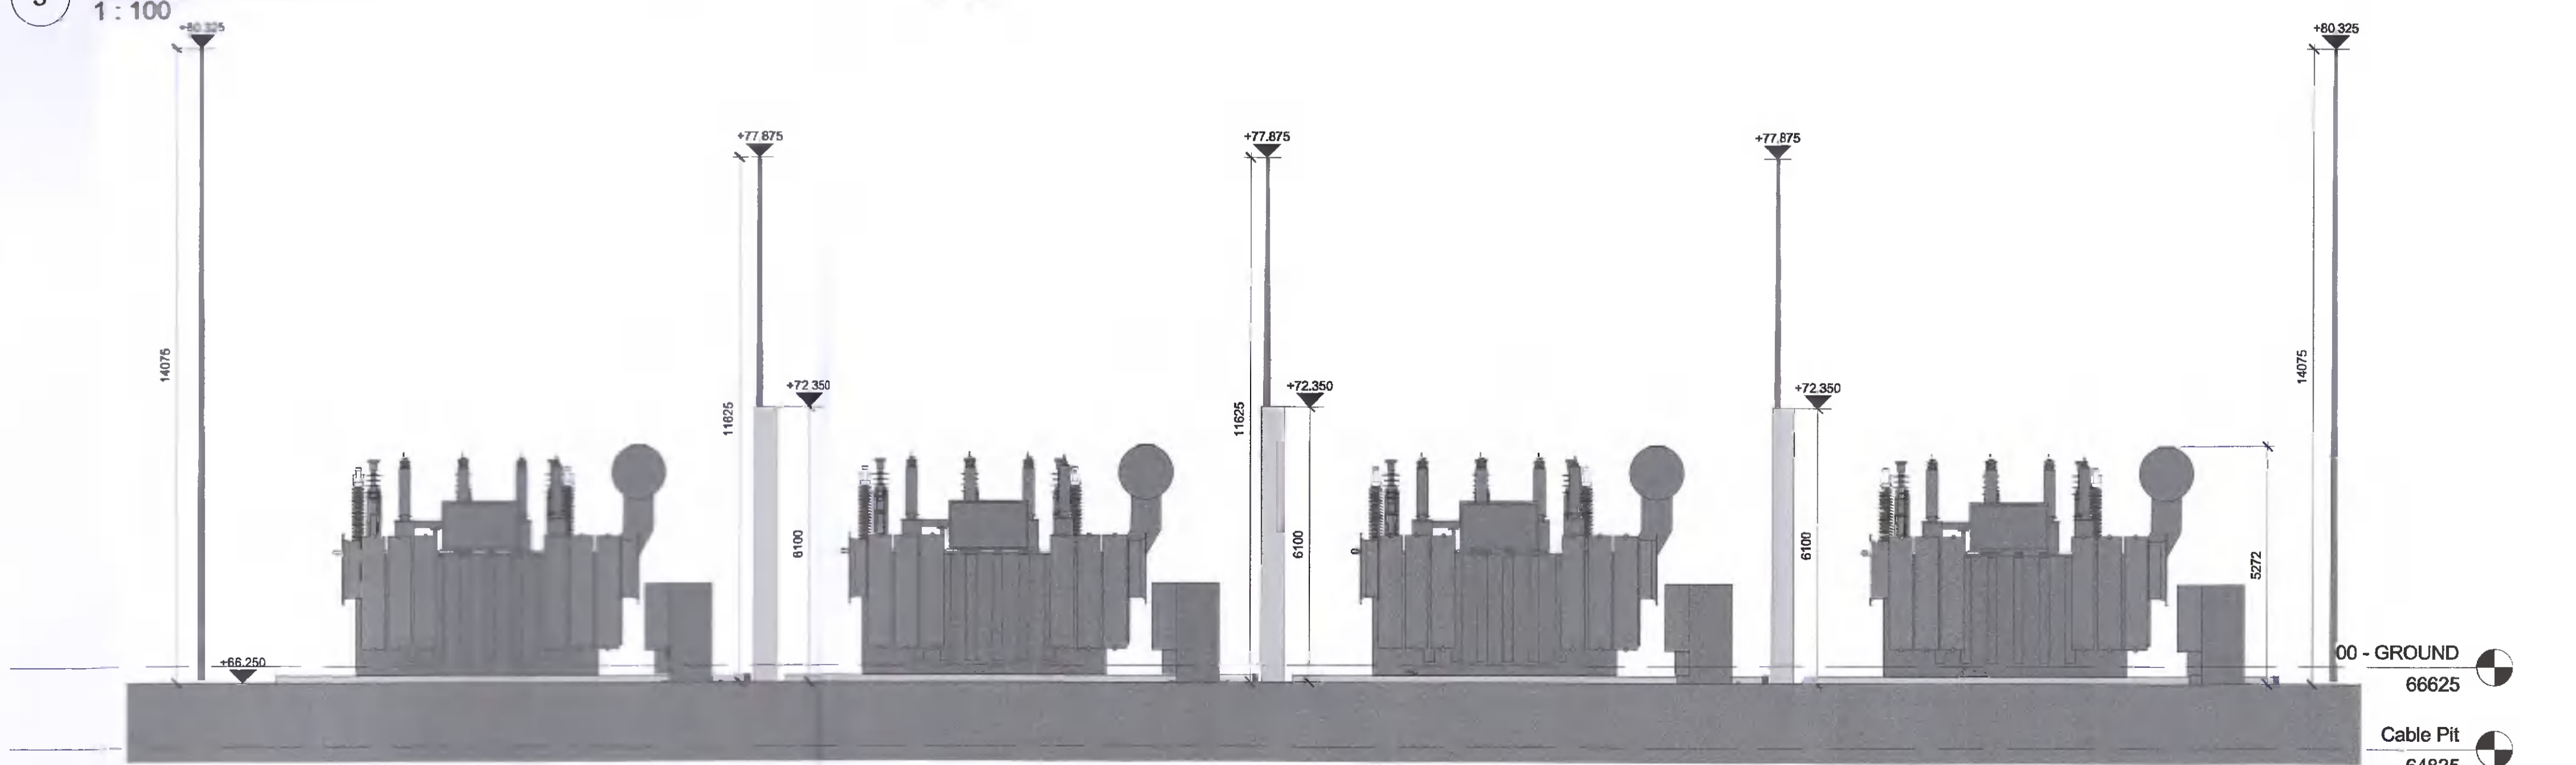

4 GA - TRANSFORMER YARD - SOUTH ELEVATION
1 : 100

CLIENT

BURR COMPUTER ENVIRONMENTS, INC.

10400 Rodgers Road
Houston, Texas 77070

Phone: 281-374-8644
Fax: 281-374-8992

HV Main Contractor

STRUCTURAL ENGINEER

ARCHITECT

Henry J Lyons

LEGEND

NOTES

DISCIPLINE

Henry J Lyons

PROJECT

ESSDUB98 - KISHOGE 110 KV
SUBSTATION

Rev	Date	Description	By	Ckd
P1	14/04/2022	ISSUED FOR PLANNING	CDA	JM

CONFIDENTIAL INFORMATION: This drawing/document and all design, details, inventions or developments covered or derived thereby are confidential and the exclusive property of the owner (or its affiliates), which reserve all rights in the is drawing/document. Copying, reproduction, duplication, or distribution to a third party, in whole or in part, is forbidden unless expressly authorized in writing.

Drawn by CDA	Checked by JM	Date 16/11/21
Scale (@ A1) As indicated	Status code A1	Project number 950918

Drawing Title
PROPOSED TRANSFORMERS
YARD ELEVATIONS

Drawing Number
(Project Code-Originator-Volume-Level-Type-Role-Sheet no.)
ESSDUB98- HJL- 01- XX- DR- A-4001

Revision
P1