

CLIENT
edgeconnex
BCEI
 BURR COMPUTER ENVIRONMENTS, INC.
 10400 Rodgers Road Houston, Texas 77070 Phone: 281-374-8644 Fax: 281-374-8992

HV Main Contractor
H&MV
 ENGINEERING
 High Voltage Solutions

STRUCTURAL ENGINEER
Clifton Scannell Emerson
 Associates

ARCHITECT
Henry J Lyons

LEGEND

NOTES

DISCIPLINE
Henry J Lyons

PROJECT
 ESSDUB98 - KISHOGE 110kV
 SUBSTATION


Rev	Date	Description	By	Ckd
P1	14/04/2022	ISSUED FOR PLANNING	CDA	JM

CONFIDENTIAL INFORMATION: This drawing/document and all design, details, inventions or developments covered or derived thereby are confidential and the exclusive property of the owner (or its affiliates), which reserve all rights in the drawing/document. Copying, reproduction, duplication, or distribution to a third party, in whole or in part, is forbidden unless expressly authorized in writing.


Drawn by CDA	Checked by JM	Date 26/11/21
Scale (@ A1) As indicated	Status code A1	Project number 950918

Drawing Title
**PERMITTED ESB BUILDING
 ELEVATIONS**


Drawing Number
 (Project Code-Originator-Volume-Level-Type-Role-Sheet no.)
 ESSDUB98- HJL- 04- XX- DR- A-4200 **P1**

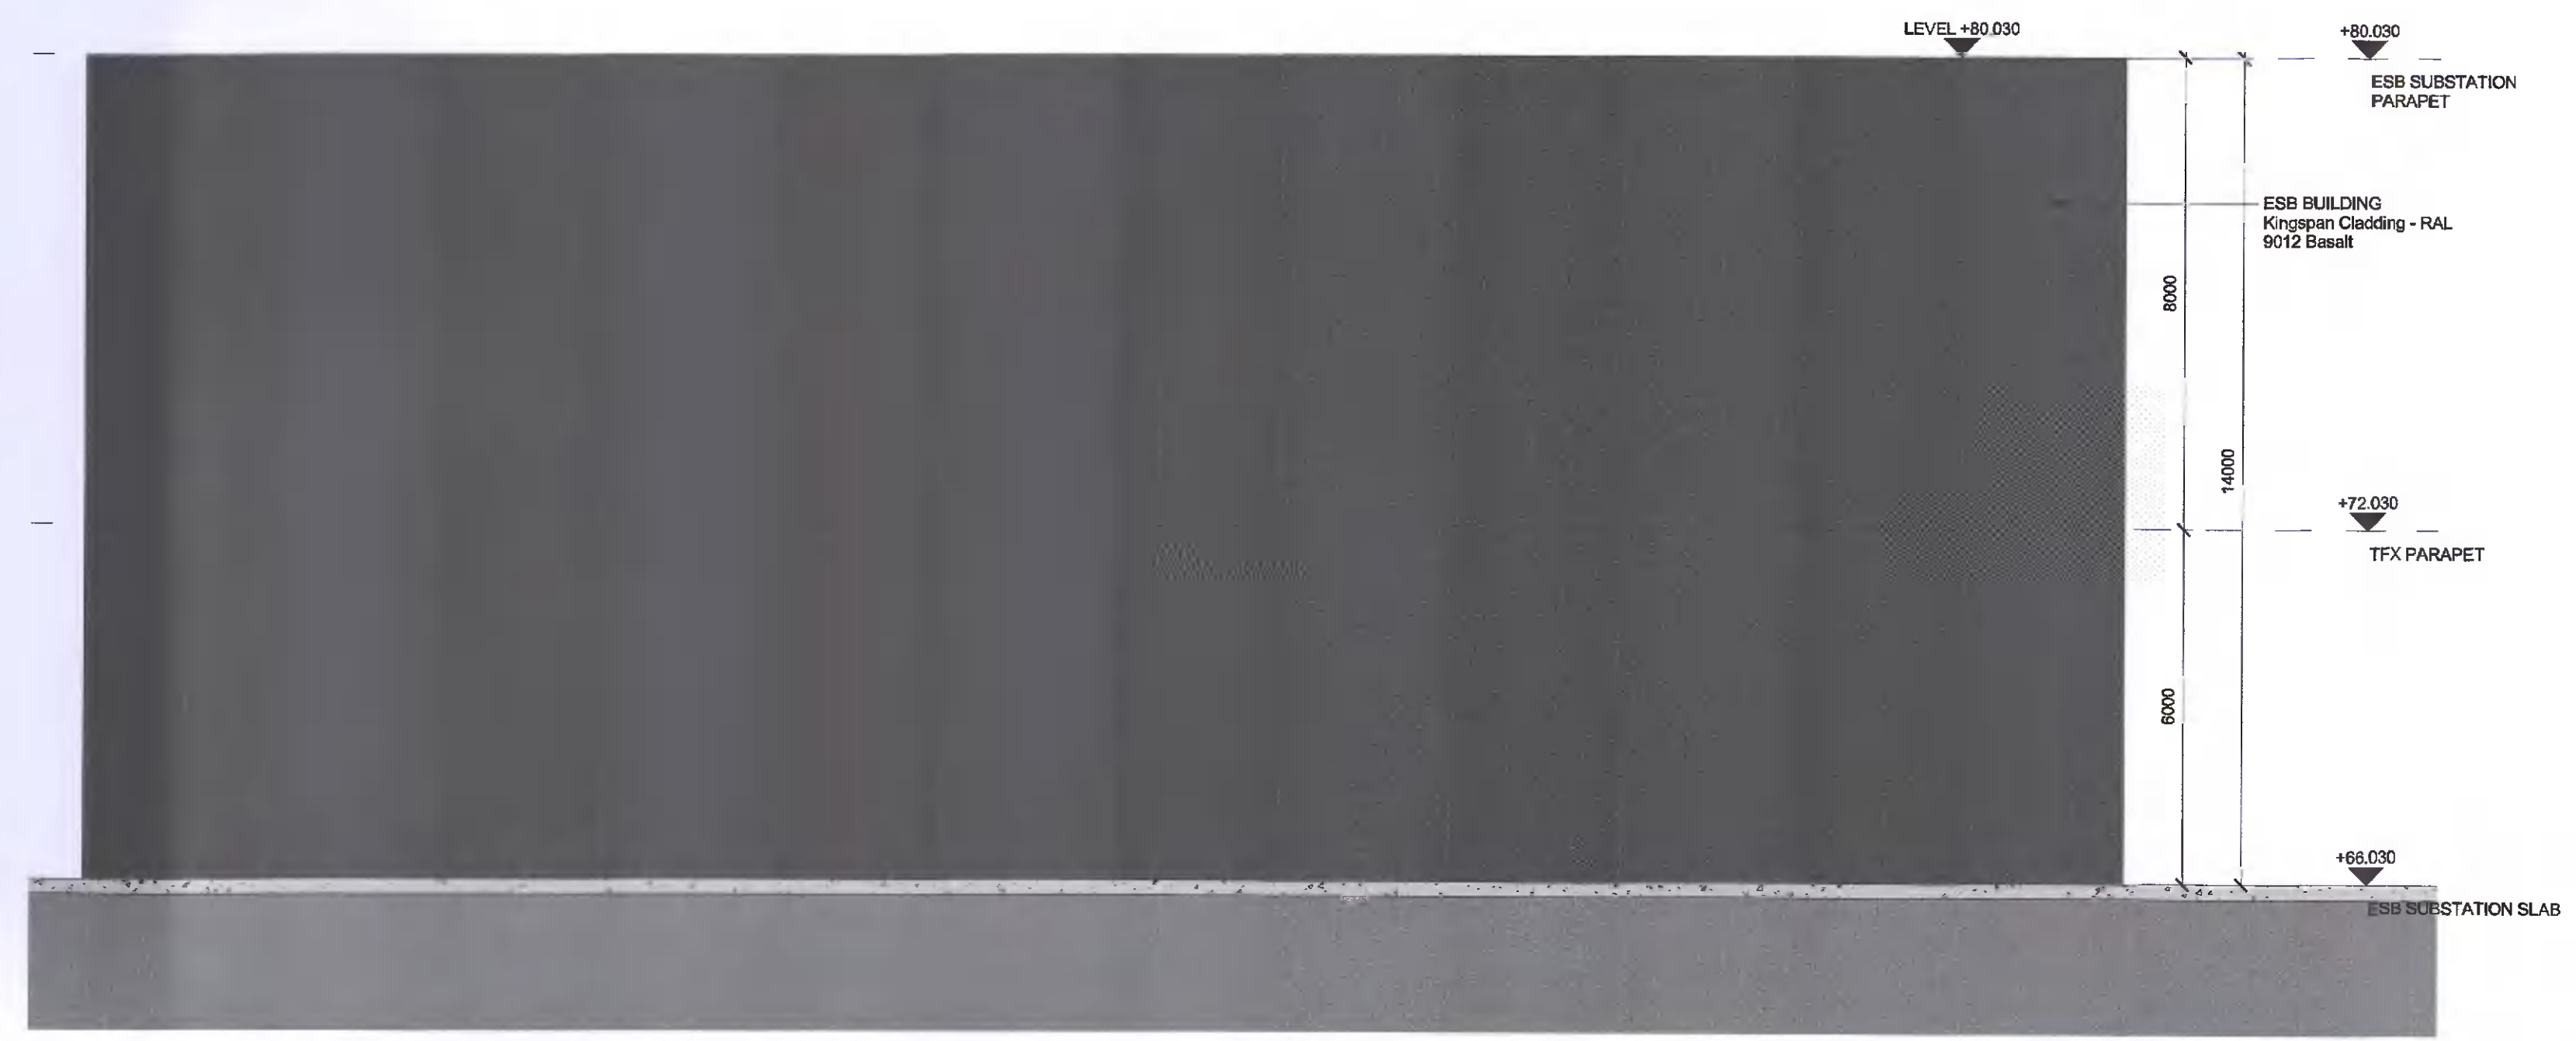


1 PERMITTED GA - ESB BUILDING - NORTH ELEVATION
 SCALE: 1:100

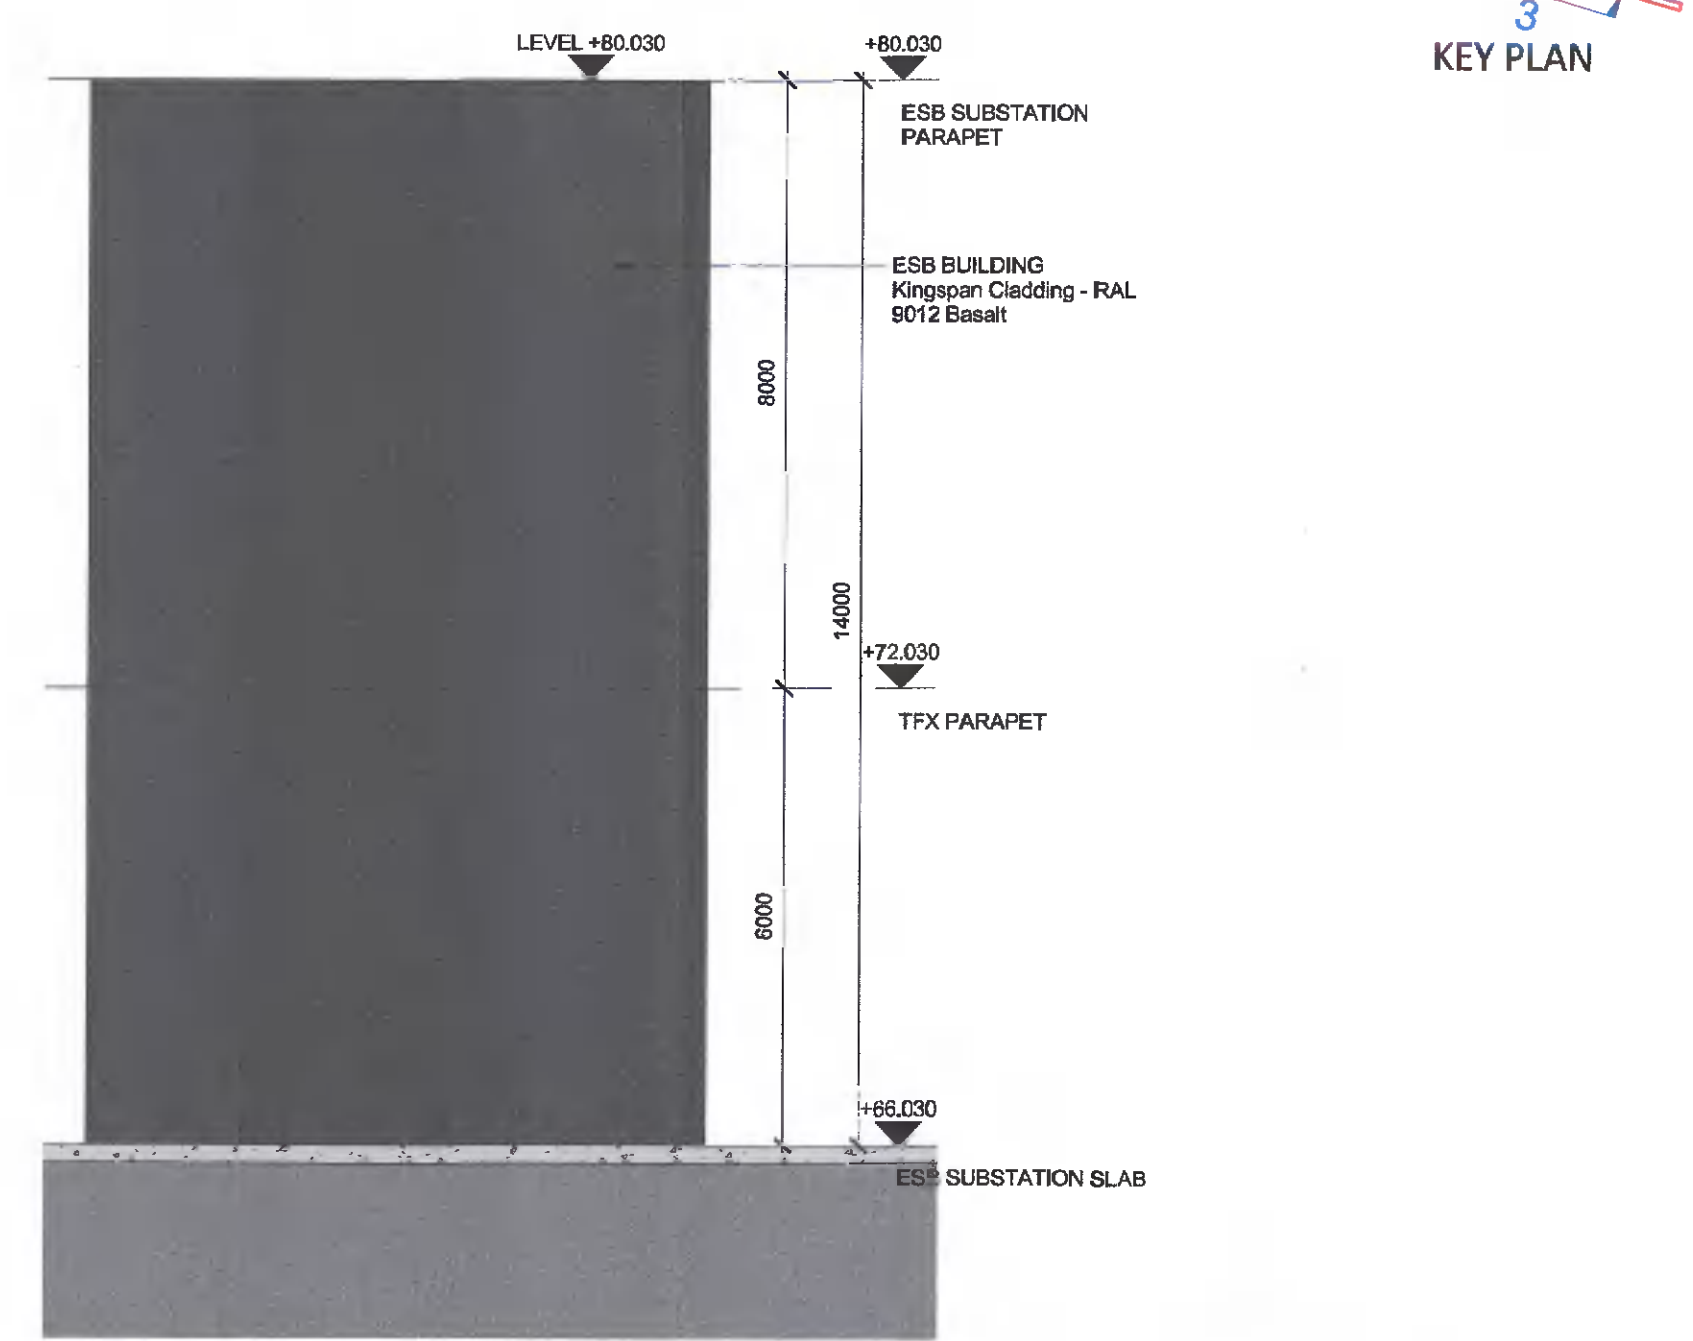

2 PERMITTED GA - ESB BUILDING - EAST ELEVATION
 SCALE: 1:100

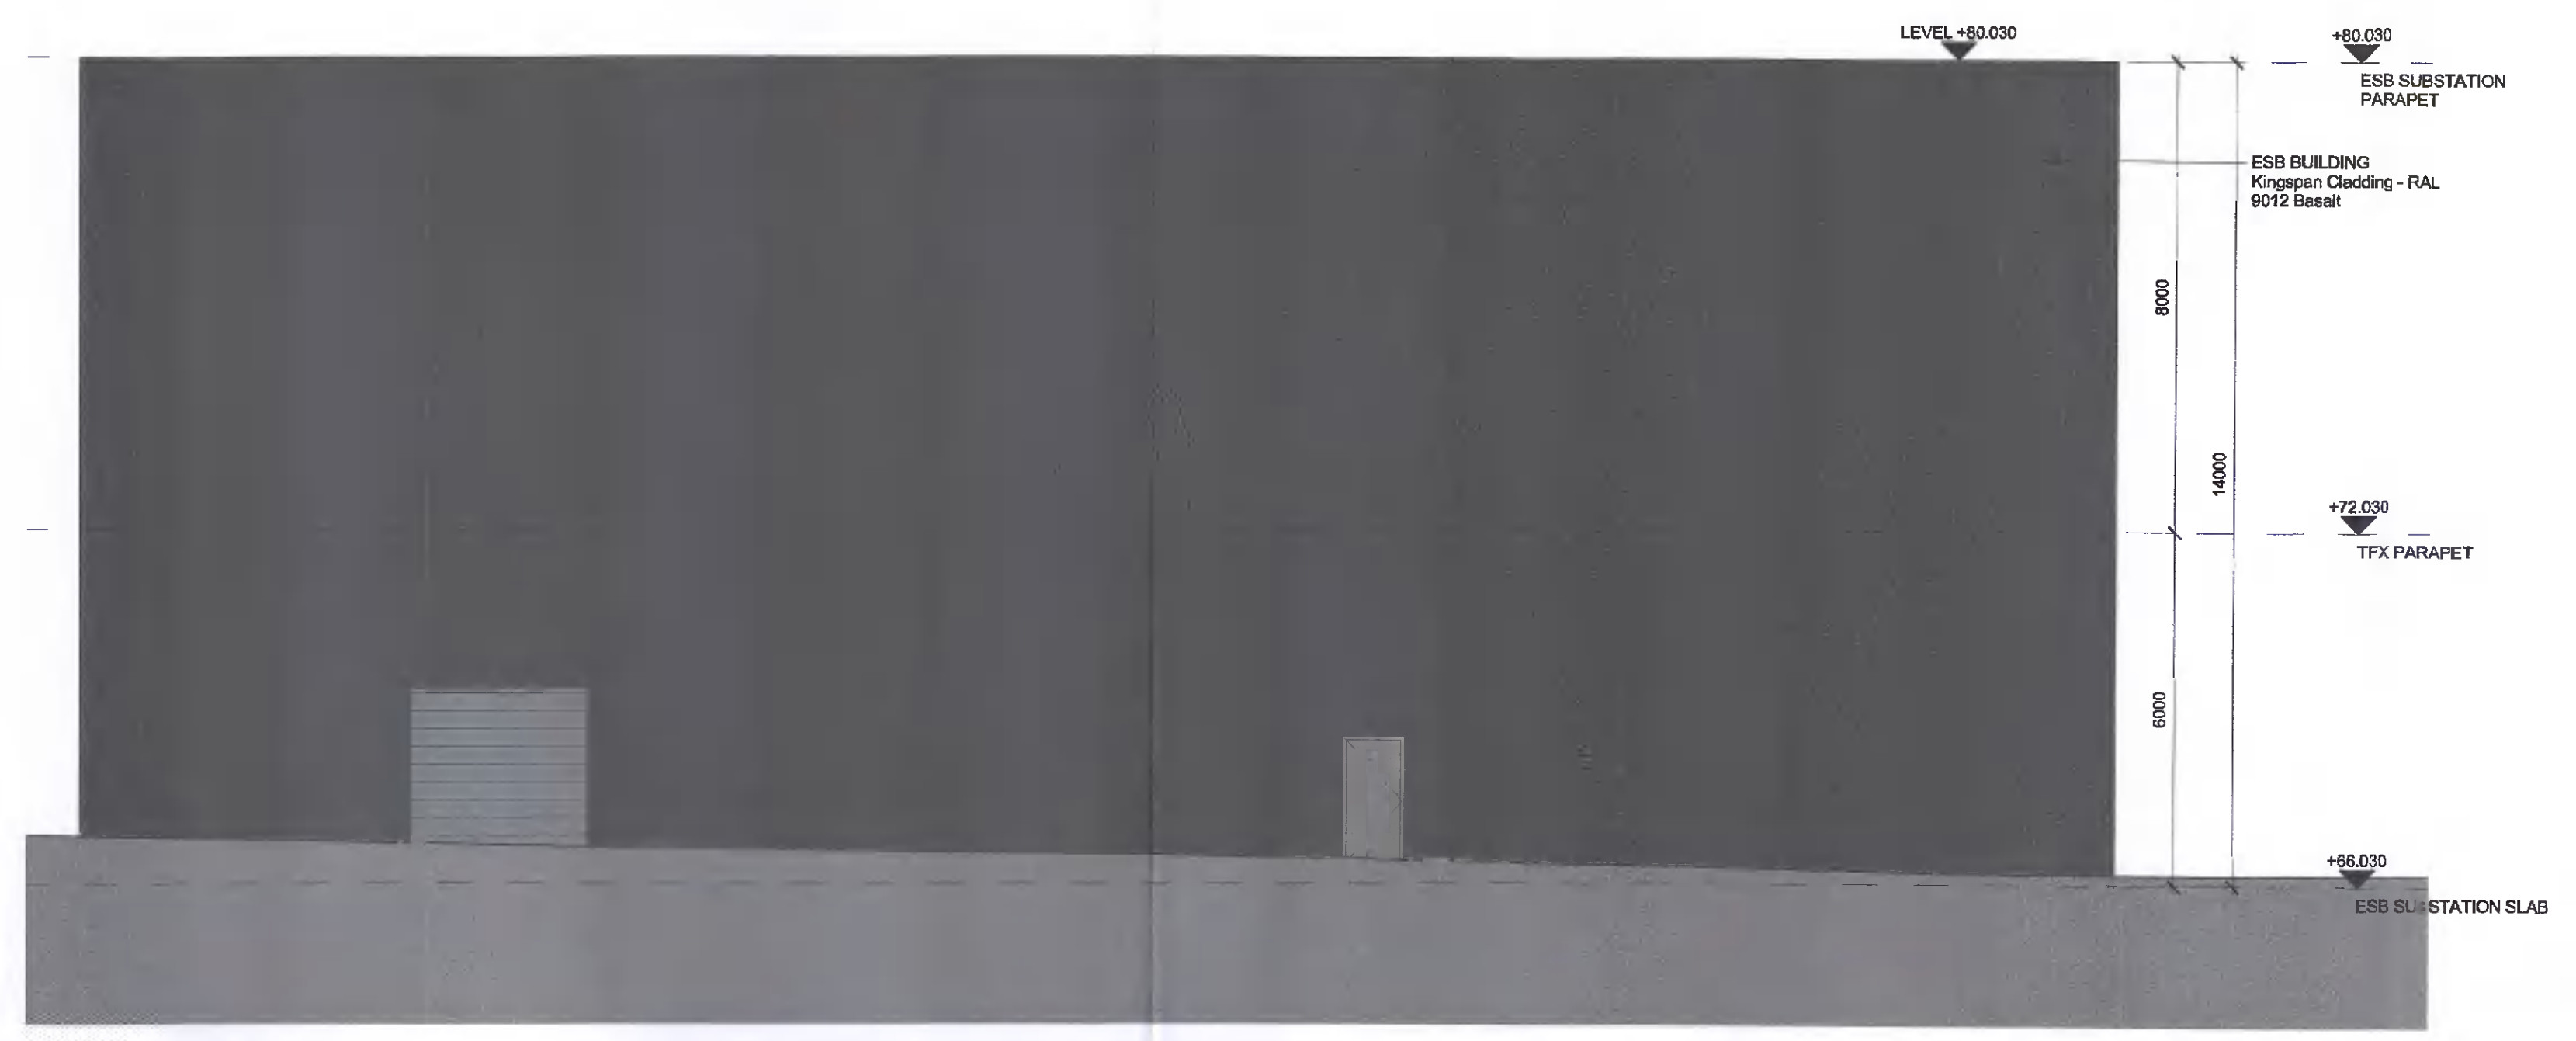

3 PERMITTED GA - ESB BUILDING - SOUTH ELEVATION
 SCALE: 1:100

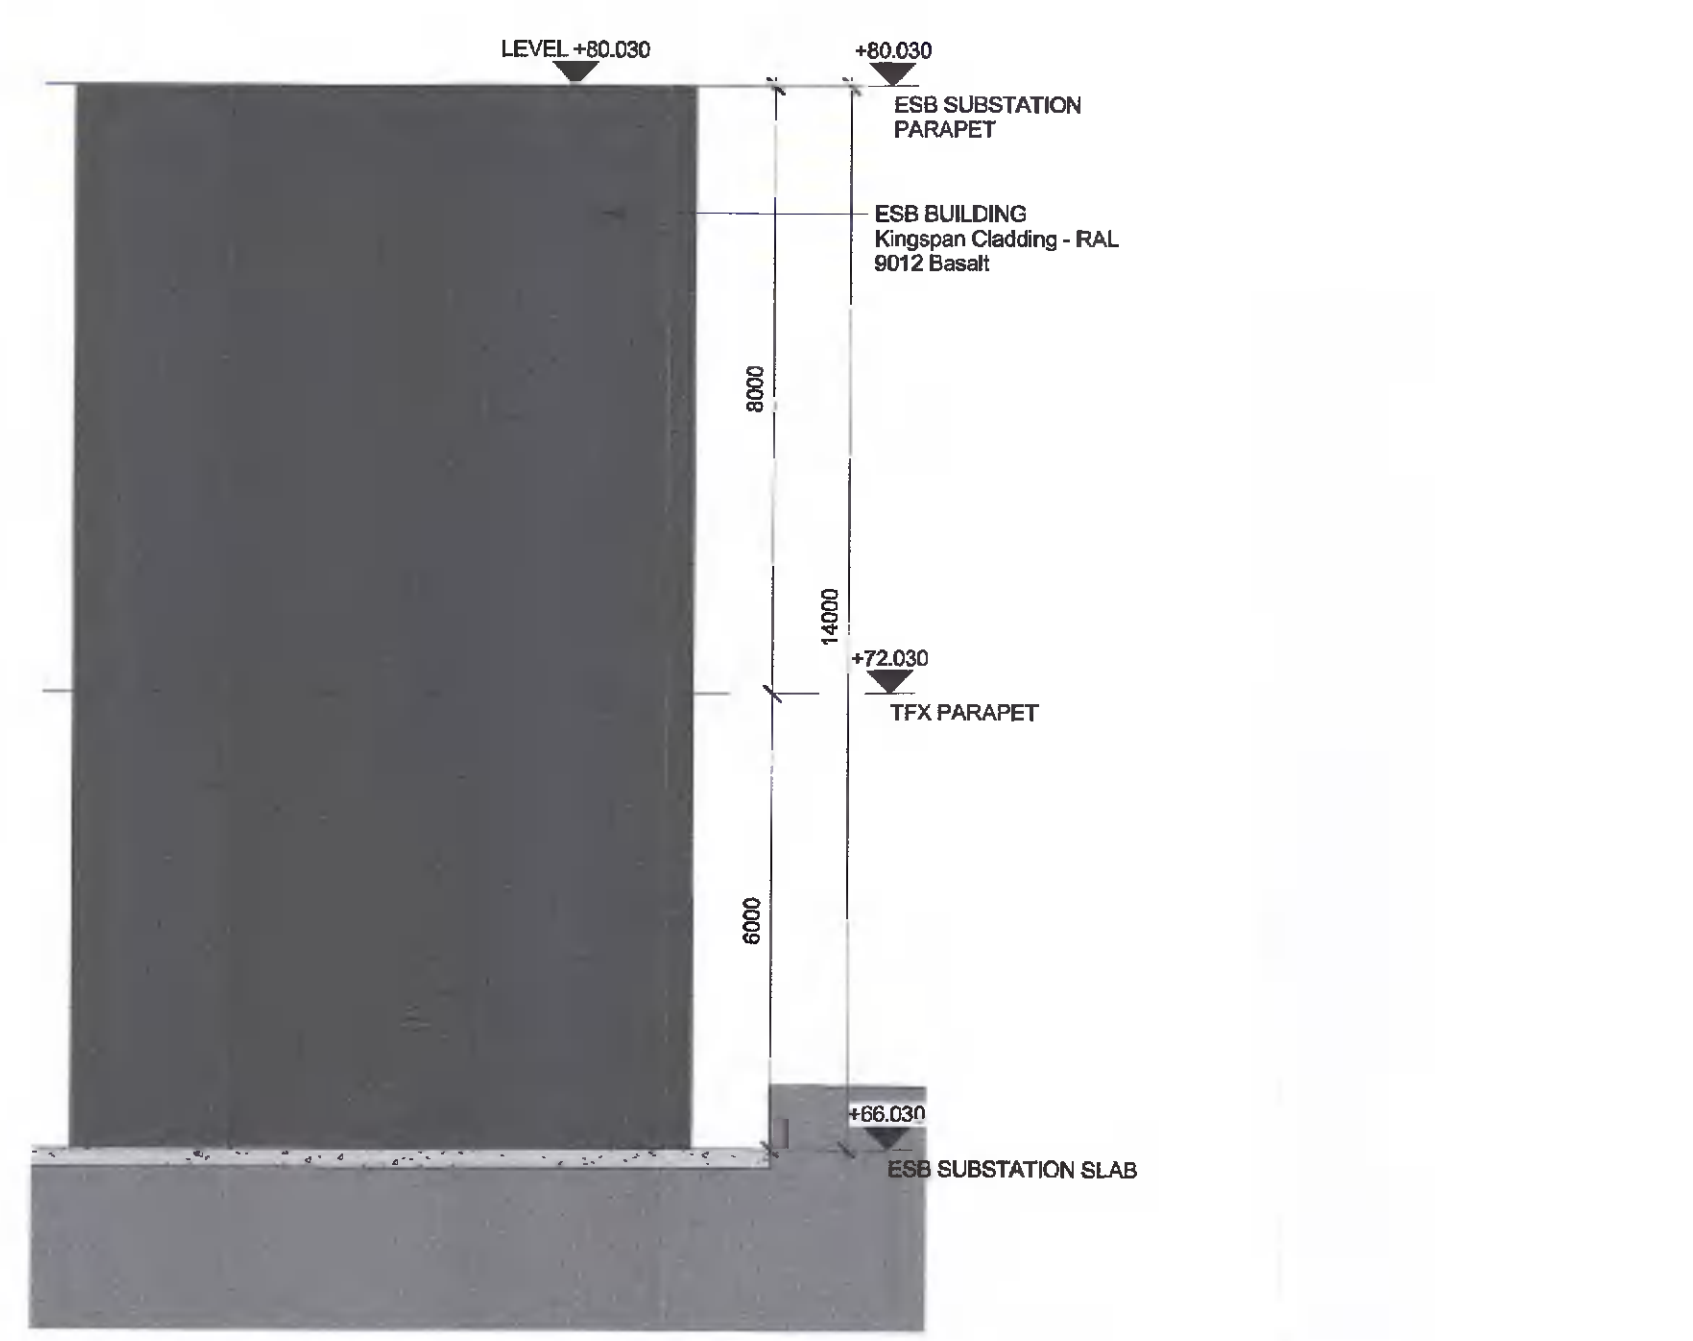

4 PERMITTED GA - ESB BUILDING - WEST ELEVATION
 SCALE: 1:100