




**1** PERMITTED GA - TRANSFORMER BUILDING - NORTH ELEVATION  
SCALE: 1:100

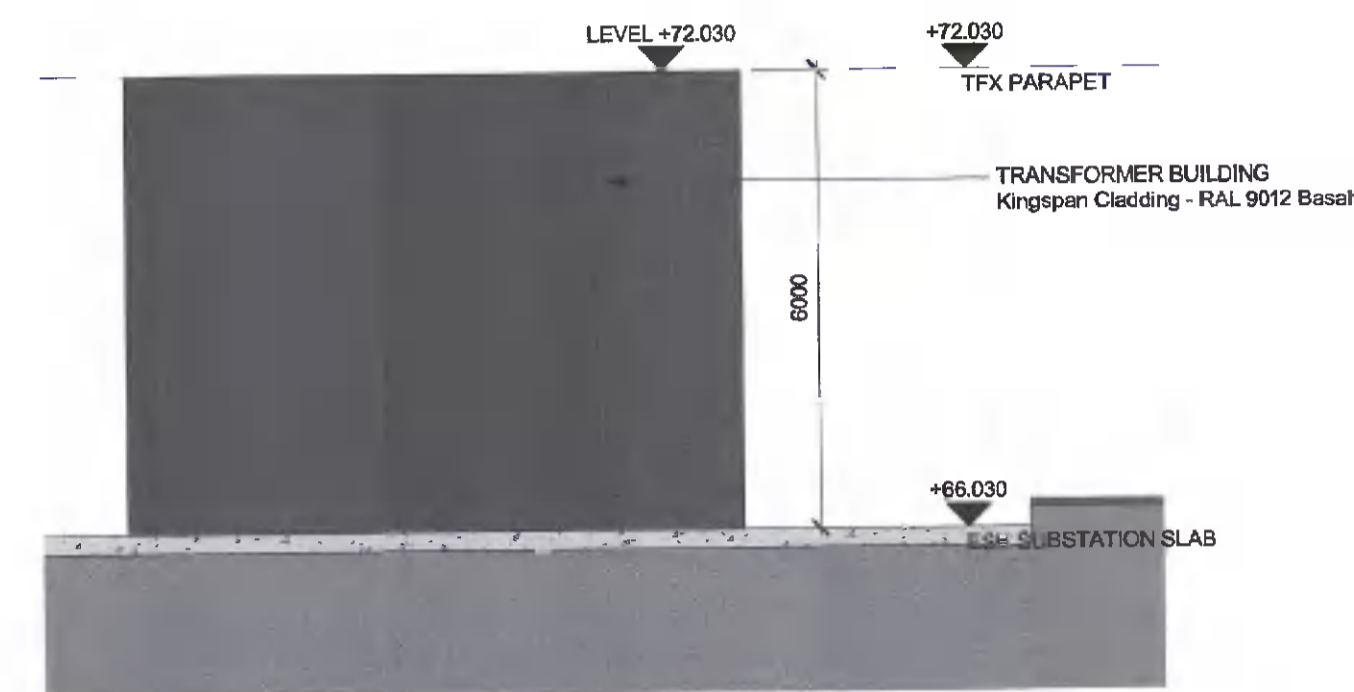

**2** PERMITTED GA - TRANSFORMER BUILDING - EAST ELEVATION  
SCALE: 1:100

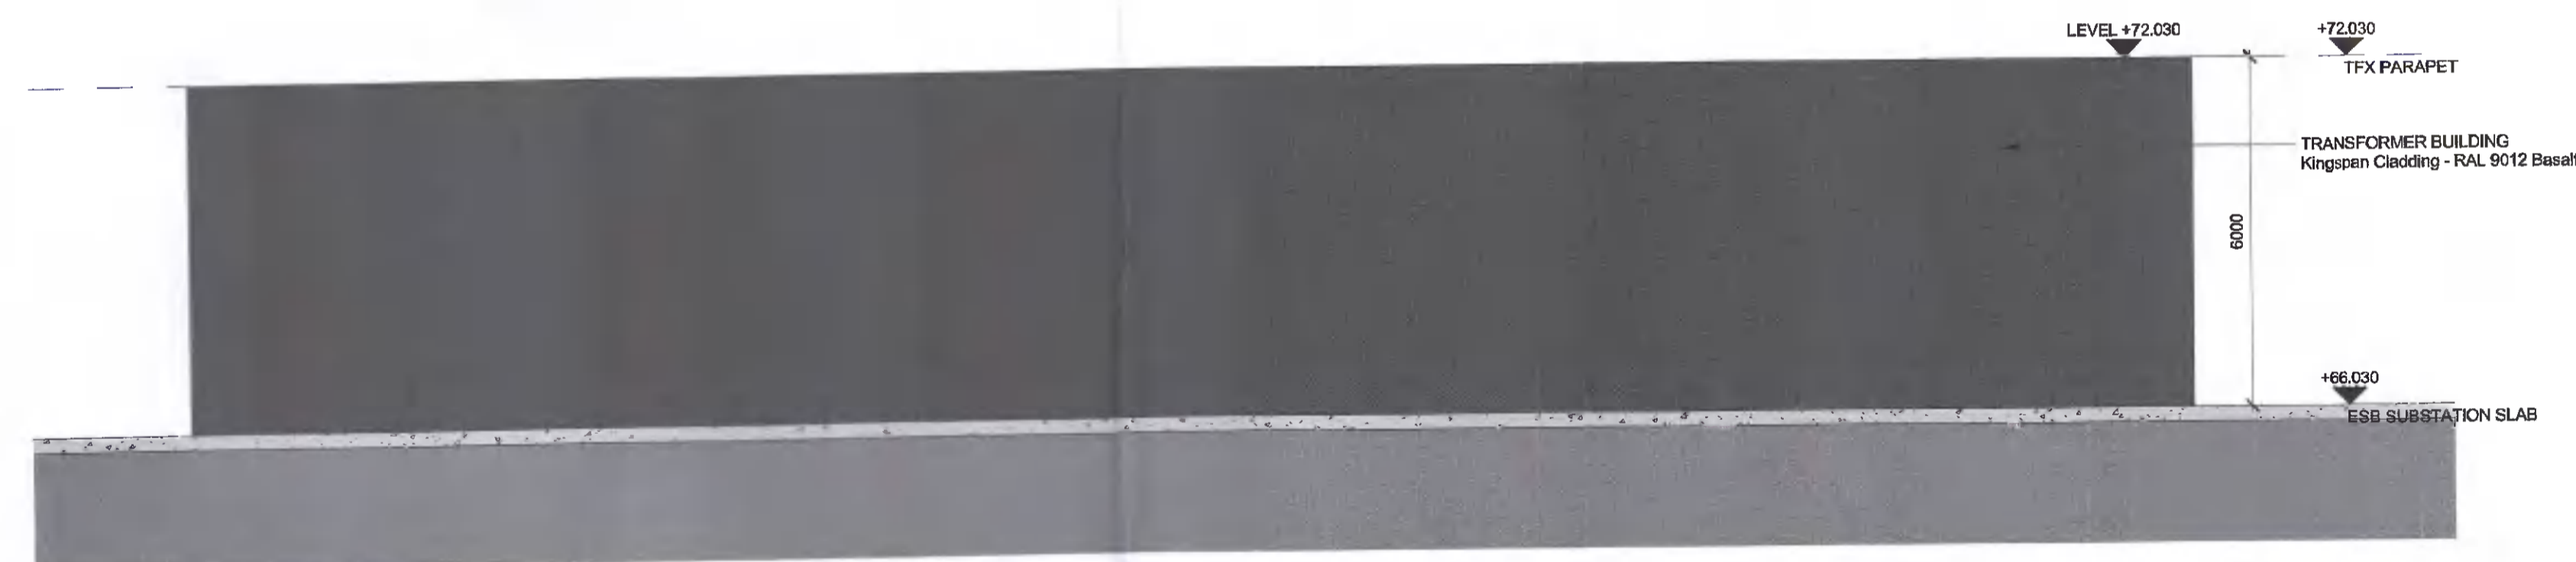

**3** PERMITTED GA - TRANSFORMER BUILDING - SOUTH ELEVATION  
SCALE: 1:100

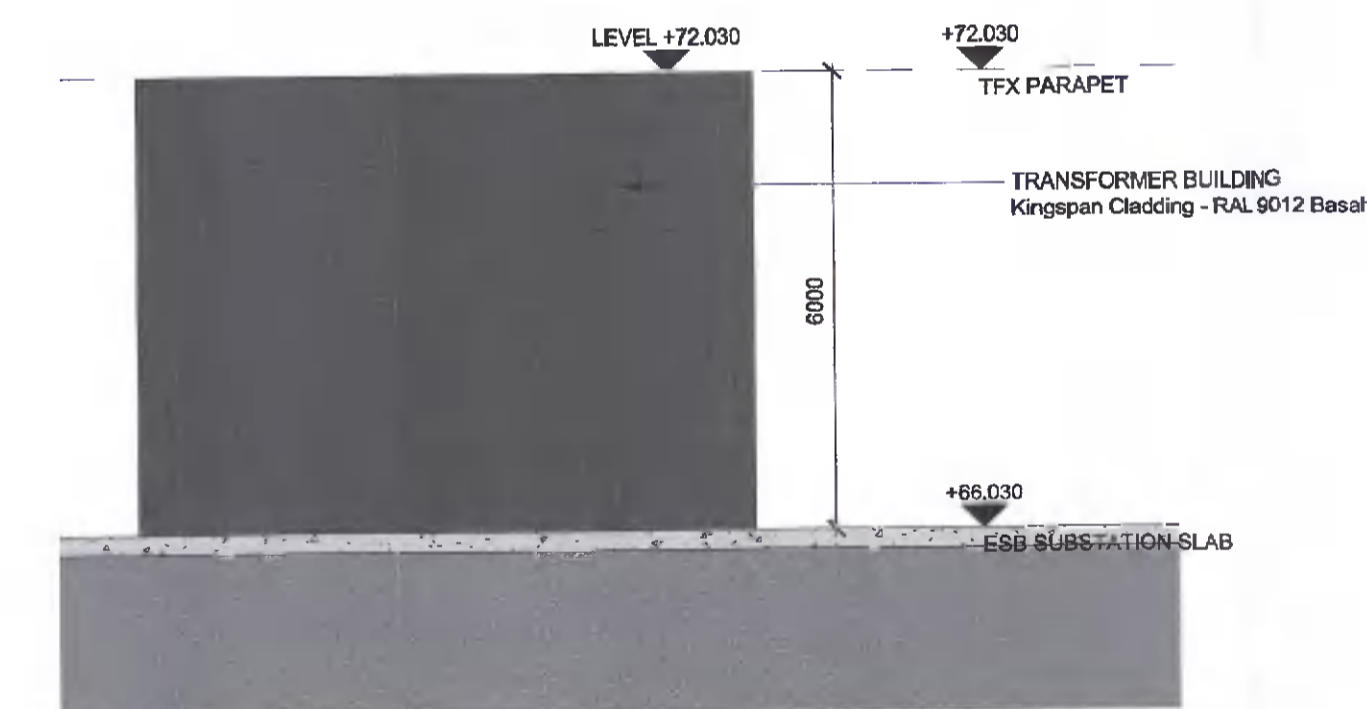

**4** PERMITTED GA - TRANSFORMER BUILDING - WEST ELEVATION  
SCALE: 1:100

CLIENT




10400 Rodgers Road  
Houston, Texas 77070  
Phone: 281-374-8644  
Fax: 281-374-8992

HV Main Contractor



STRUCTURAL ENGINEER

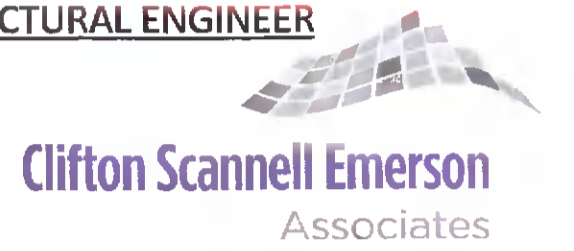

ARCHITECT

**Henry J Lyons**

LEGEND

NOTES

DISCIPLINE

**Henry J Lyons**

PROJECT

ESSDUB98 - KISHOGE 110kV  
SUBSTATION

Rev	Date	Description	By	Ckd
P1	14/04/2022	ISSUED FOR PLANNING	CDA	JM

CONFIDENTIAL INFORMATION: This drawing/document and all design, details, inventions or developments covered or derived thereby are confidential and the exclusive property of the owner (or its affiliates), which reserve all rights in the drawing/document. Copying, reproduction, duplication, or distribution to a third party, in whole or in part, is forbidden unless expressly authorised in writing.

Drawn by CDA	Checked by JM	Date 26/11/21
Scale (@ A1) As indicated	Status code A1	Project number 950918

Drawing Title  
**PERMITTED TRANSFORMER  
BUILDING ELEVATIONS**

Drawing Number  
(Project Code-Originator-Volume-Level-Type-Role-Sheet no.)  
ESSDUB98- HJL- 04- XX- DR- A-4201 **P1**