

















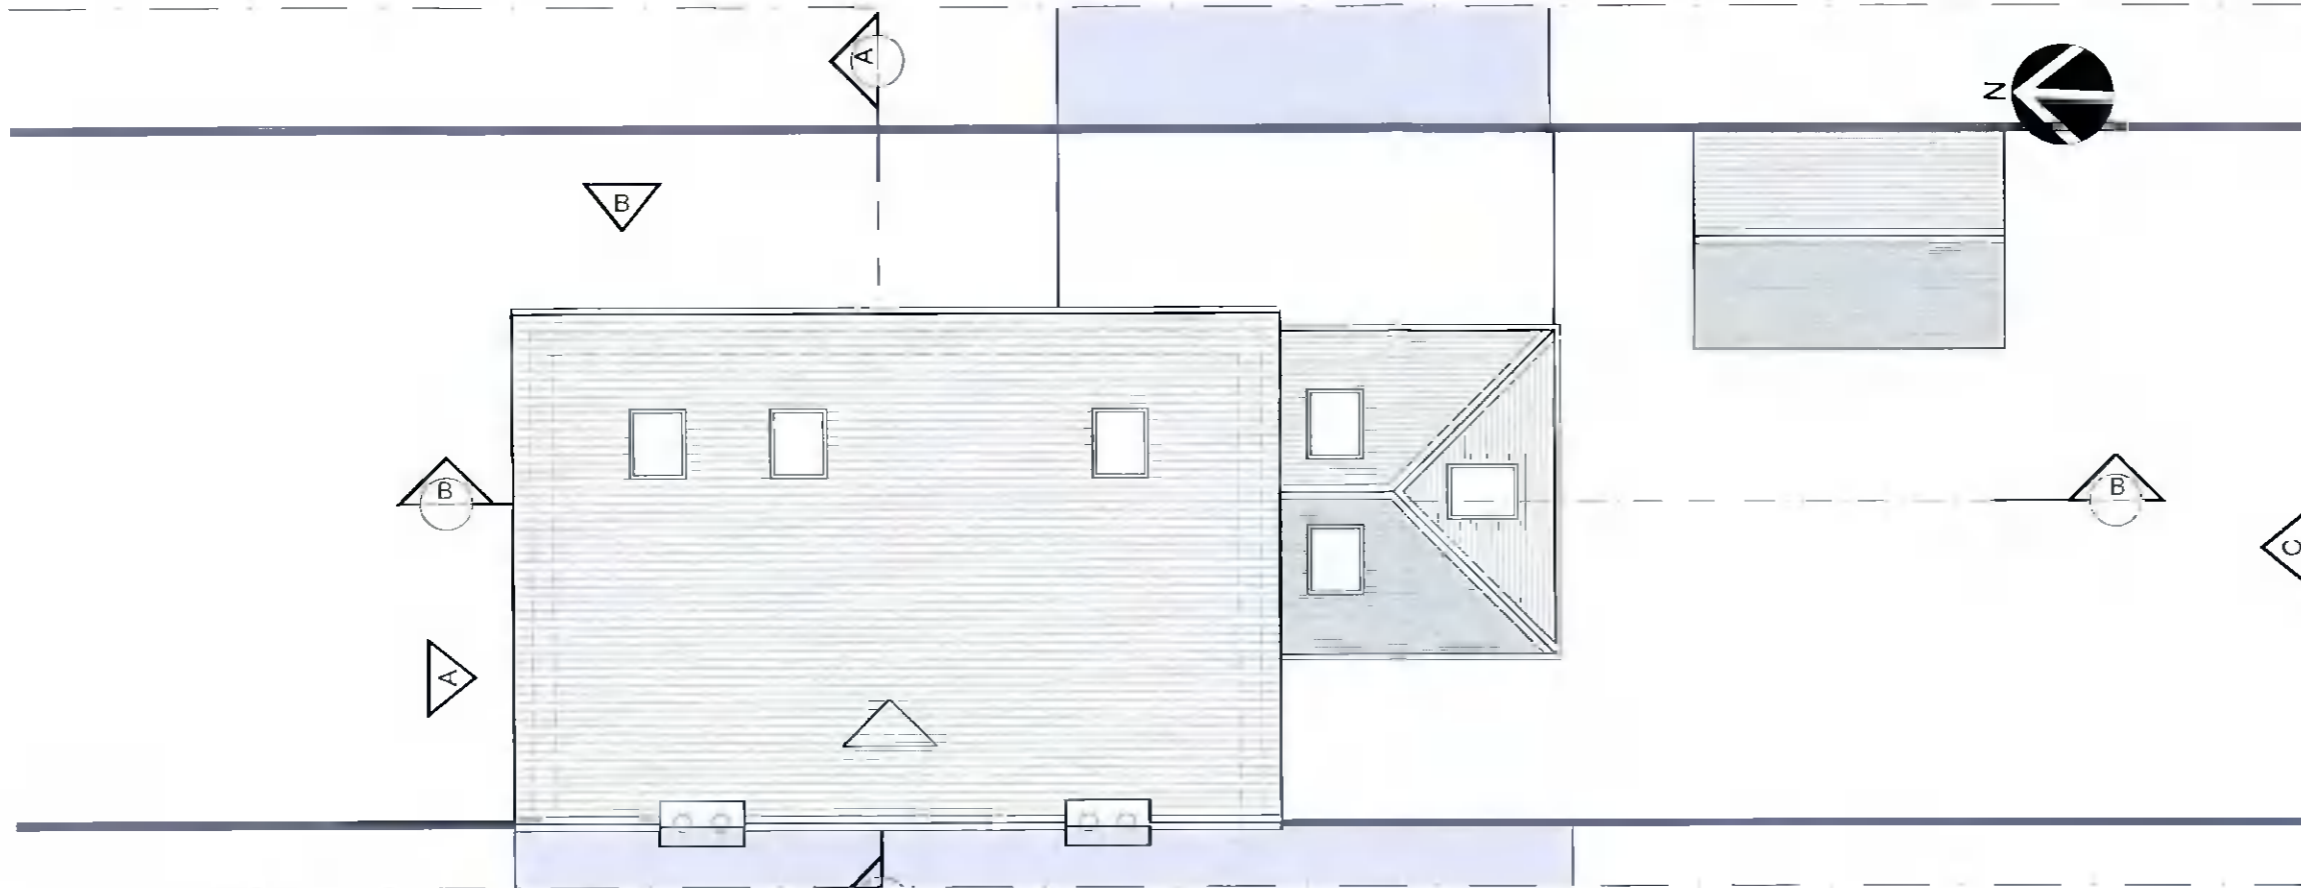
LEGEND

-  EXISTING WALLS
-  PROPOSED WALLS
-  S.V.P
-  RWP RAIN WATER PIPE
-  G.T GULLY TRAP
-  A.J ARMSTRONG JUNCTION
-  M.H MAN HOLE
-  FOUL WATER
-  SURFACE WATER
-  G.L. GROUND LEVEL
-  F.R.L. FLAT ROOF LEVEL
-  G.F.L. GROUND FLOOR LEVEL
-  F.F.L. FIRST FLOOR LEVEL
-  S.F.L. SECOND FLOOR LEVEL
-  R.L. ROOF LEVEL
-  B.F.L. BACKYARD FLOOR LEVEL



REV	DATE	DESCRIPTION
-----	------	-------------

© This drawing is copyright. Figured dimensions only to be taken from this drawing. All dimensions to be checked on site. Module Design Ltd to be informed immediately of any discrepancies before work proceeds.

PROJECT NO. <b>20109</b>	SCALE(S) <b>1:200</b>	REV. <b>01</b>
-----------------------------	--------------------------	-------------------



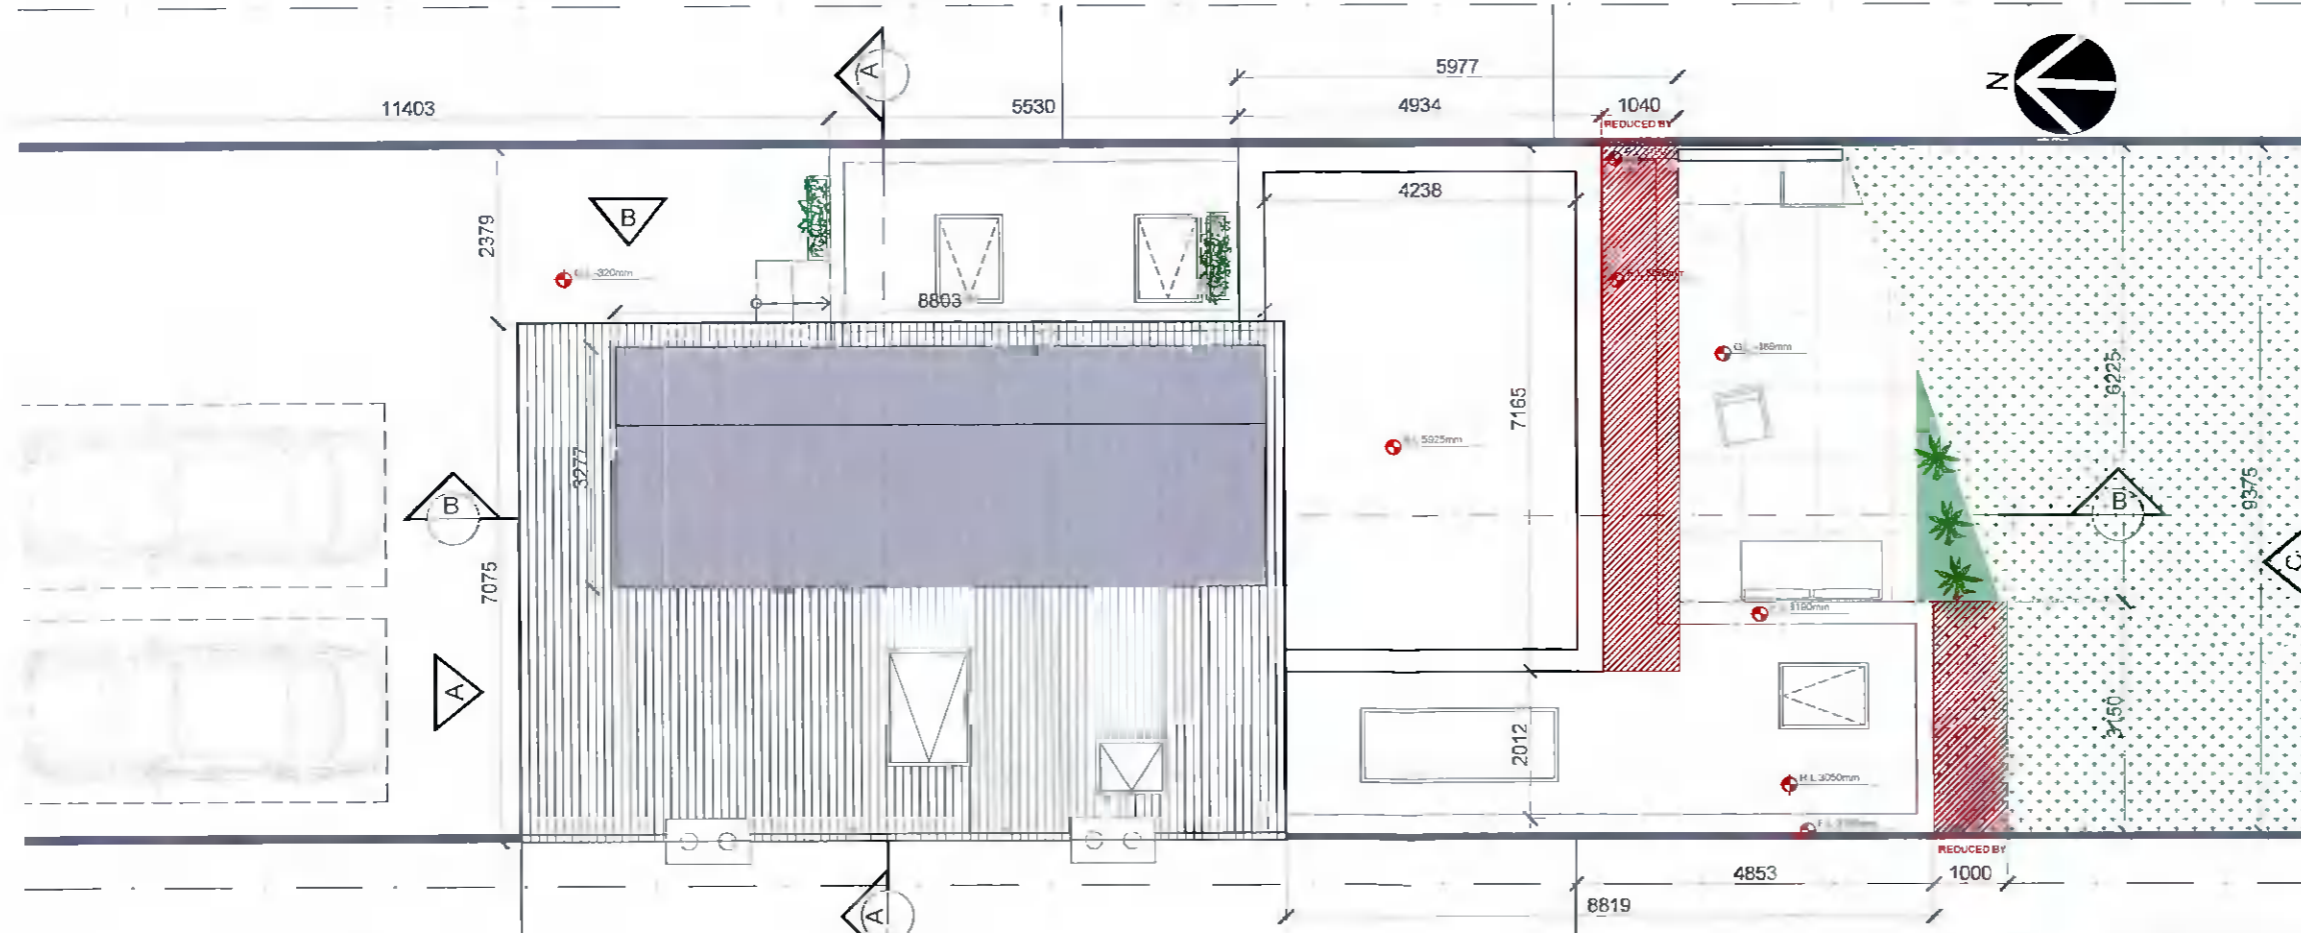**01** EXISTING DRAINAGE PLAN  
 SCALE: 1:200



**02** PROPOSED ROOF PLAN  
 SCALE: 1:100

MAP SHEETS  
 3194-23  
 3280-03

INCLUDES ORDNANCE SURVEY IRELAND DATA  
 REPRODUCED UNDER OSI LICENSE NUMBER 1621  
 UNAUTHORISED REPRODUCTION INFRINGES ORDNANCE  
 SURVEY IRELAND AND GOVERNMENT OF IRELAND  
 COPYRIGHT © ORDNANCE SURVEY IRELAND 2021