


Proposed Block Plan & Drainage Layout  
SCALE 1:200

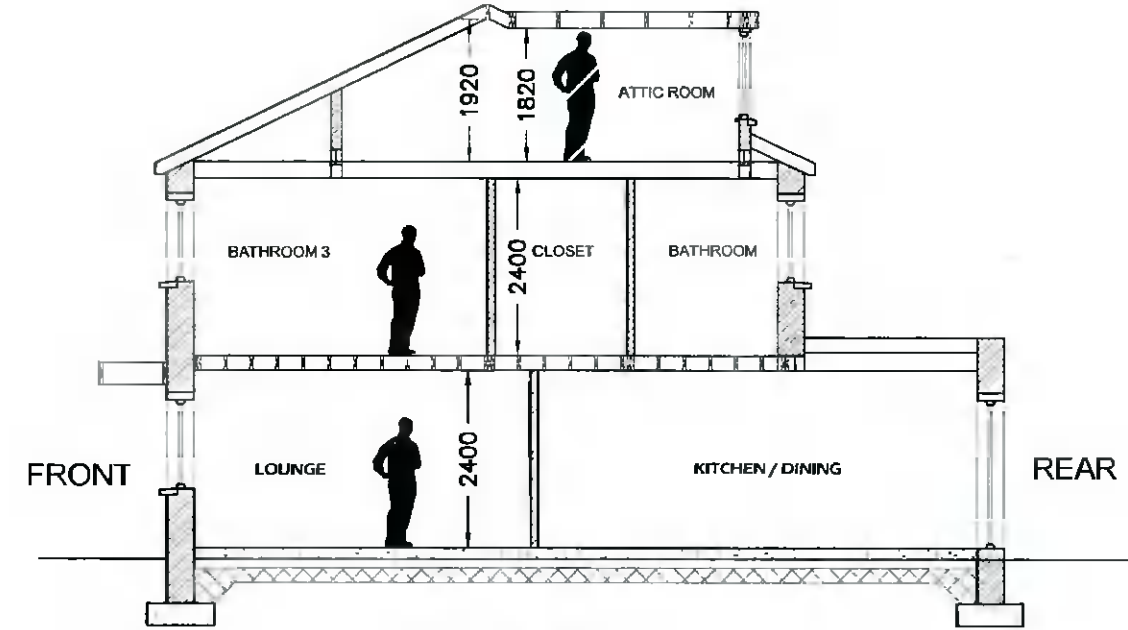

Section A-A  
SCALE 1:100

**DRAINAGE LEGEND**

	PROPOSED 150Ø UPVC SURFACE WATER PIPE
	PROPOSED 150Ø UPVC FOUL SEWER PIPE
	EXISTING SURFACE WATER PIPE
	EXISTING FOUL SEWER PIPE

P	ISSUED FOR PLANNING	TW	Apr' 2022
REV:	REVISION TITLE:	DRN:	CHD: DATE:

**Architectural Planning**  
4 CARRIGMORE CLOSE, AYLESBURY,  
Dublin 24 - Ph: 01 4148358

CLIENT: **Philip Brosnan**

JOB TITLE: **Proposed Works at 30 Pineview Rise, Aylesbury, Tallaght, Dublin 24**

TITLE: **Proposed Block Plan, Drainage Layout & Section A-A**

SCALE: as shown	INITIALS: TW	DATE: Apr' 2022
JOB No: S476	DRAWING No: 004	REV: P

**THIS DRAWING IS ISSUED FOR PLANNING PERMISSION ONLY, AND IS NOT A CONSTRUCTION DRAWING**

**NOTES:**  
This drawing is to be read in conjunction with all relevant Engineers drawings.  
Do not scale use figured dimensions ONLY.  
All dimensions in millimeters unless otherwise stated.  
All dimensions to be checked on site.  
All building works to comply with current building regulations & in accordance with Homebond Standards.