
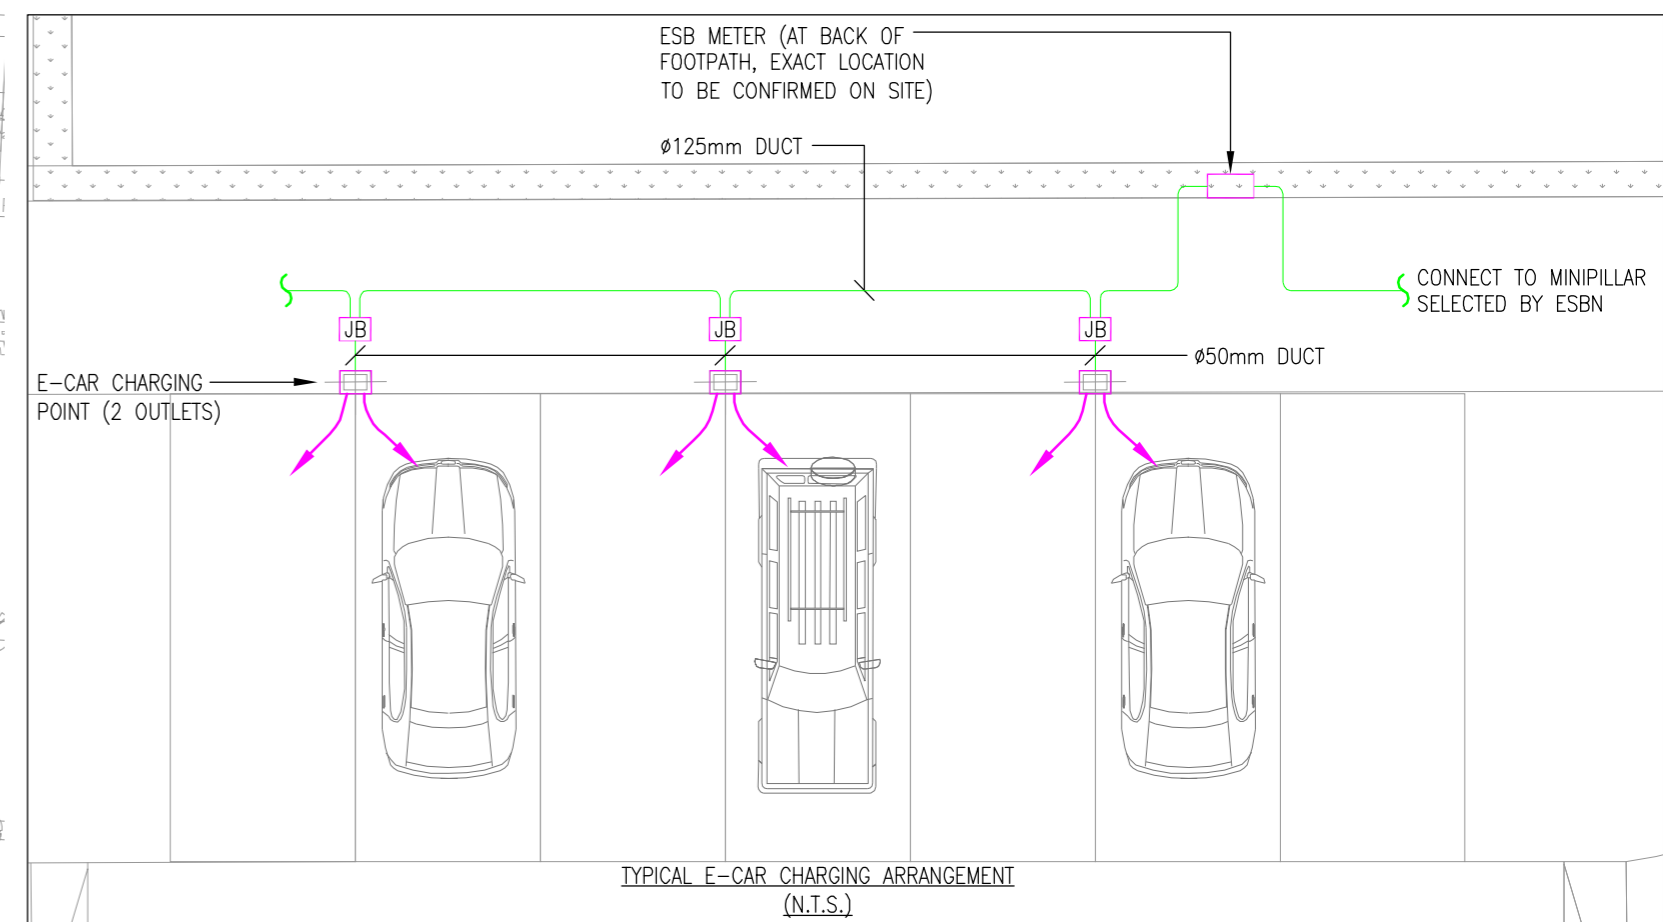


- NOTES
- DO NOT SCALE. USE FIGURED DIMENSIONS ONLY.
 - THIS DRAWING IS TO BE READ IN CONJUNCTION WITH ALL OTHER RELEVANT ARCHITECTURAL AND ENGINEERING DRAWINGS.
 - THIS IS NOT AN INSTALLATION DRAWING, THE SUB CONTRACTOR SHALL SUBMIT INSTALLATION DRAWINGS TO THE ENGINEER FOR APPROVAL.

LEGEND

- M ESB METER
- FM FUTURE ESB METER
- + E-CAR CHARGING POINT
- JB JUNCTION BOX
- #125mm DUCT
- E-CAR CHARGING SPACES (LIVE)
- E-CAR CHARGING SPACES (FUTURE DUCTING PROVISION)

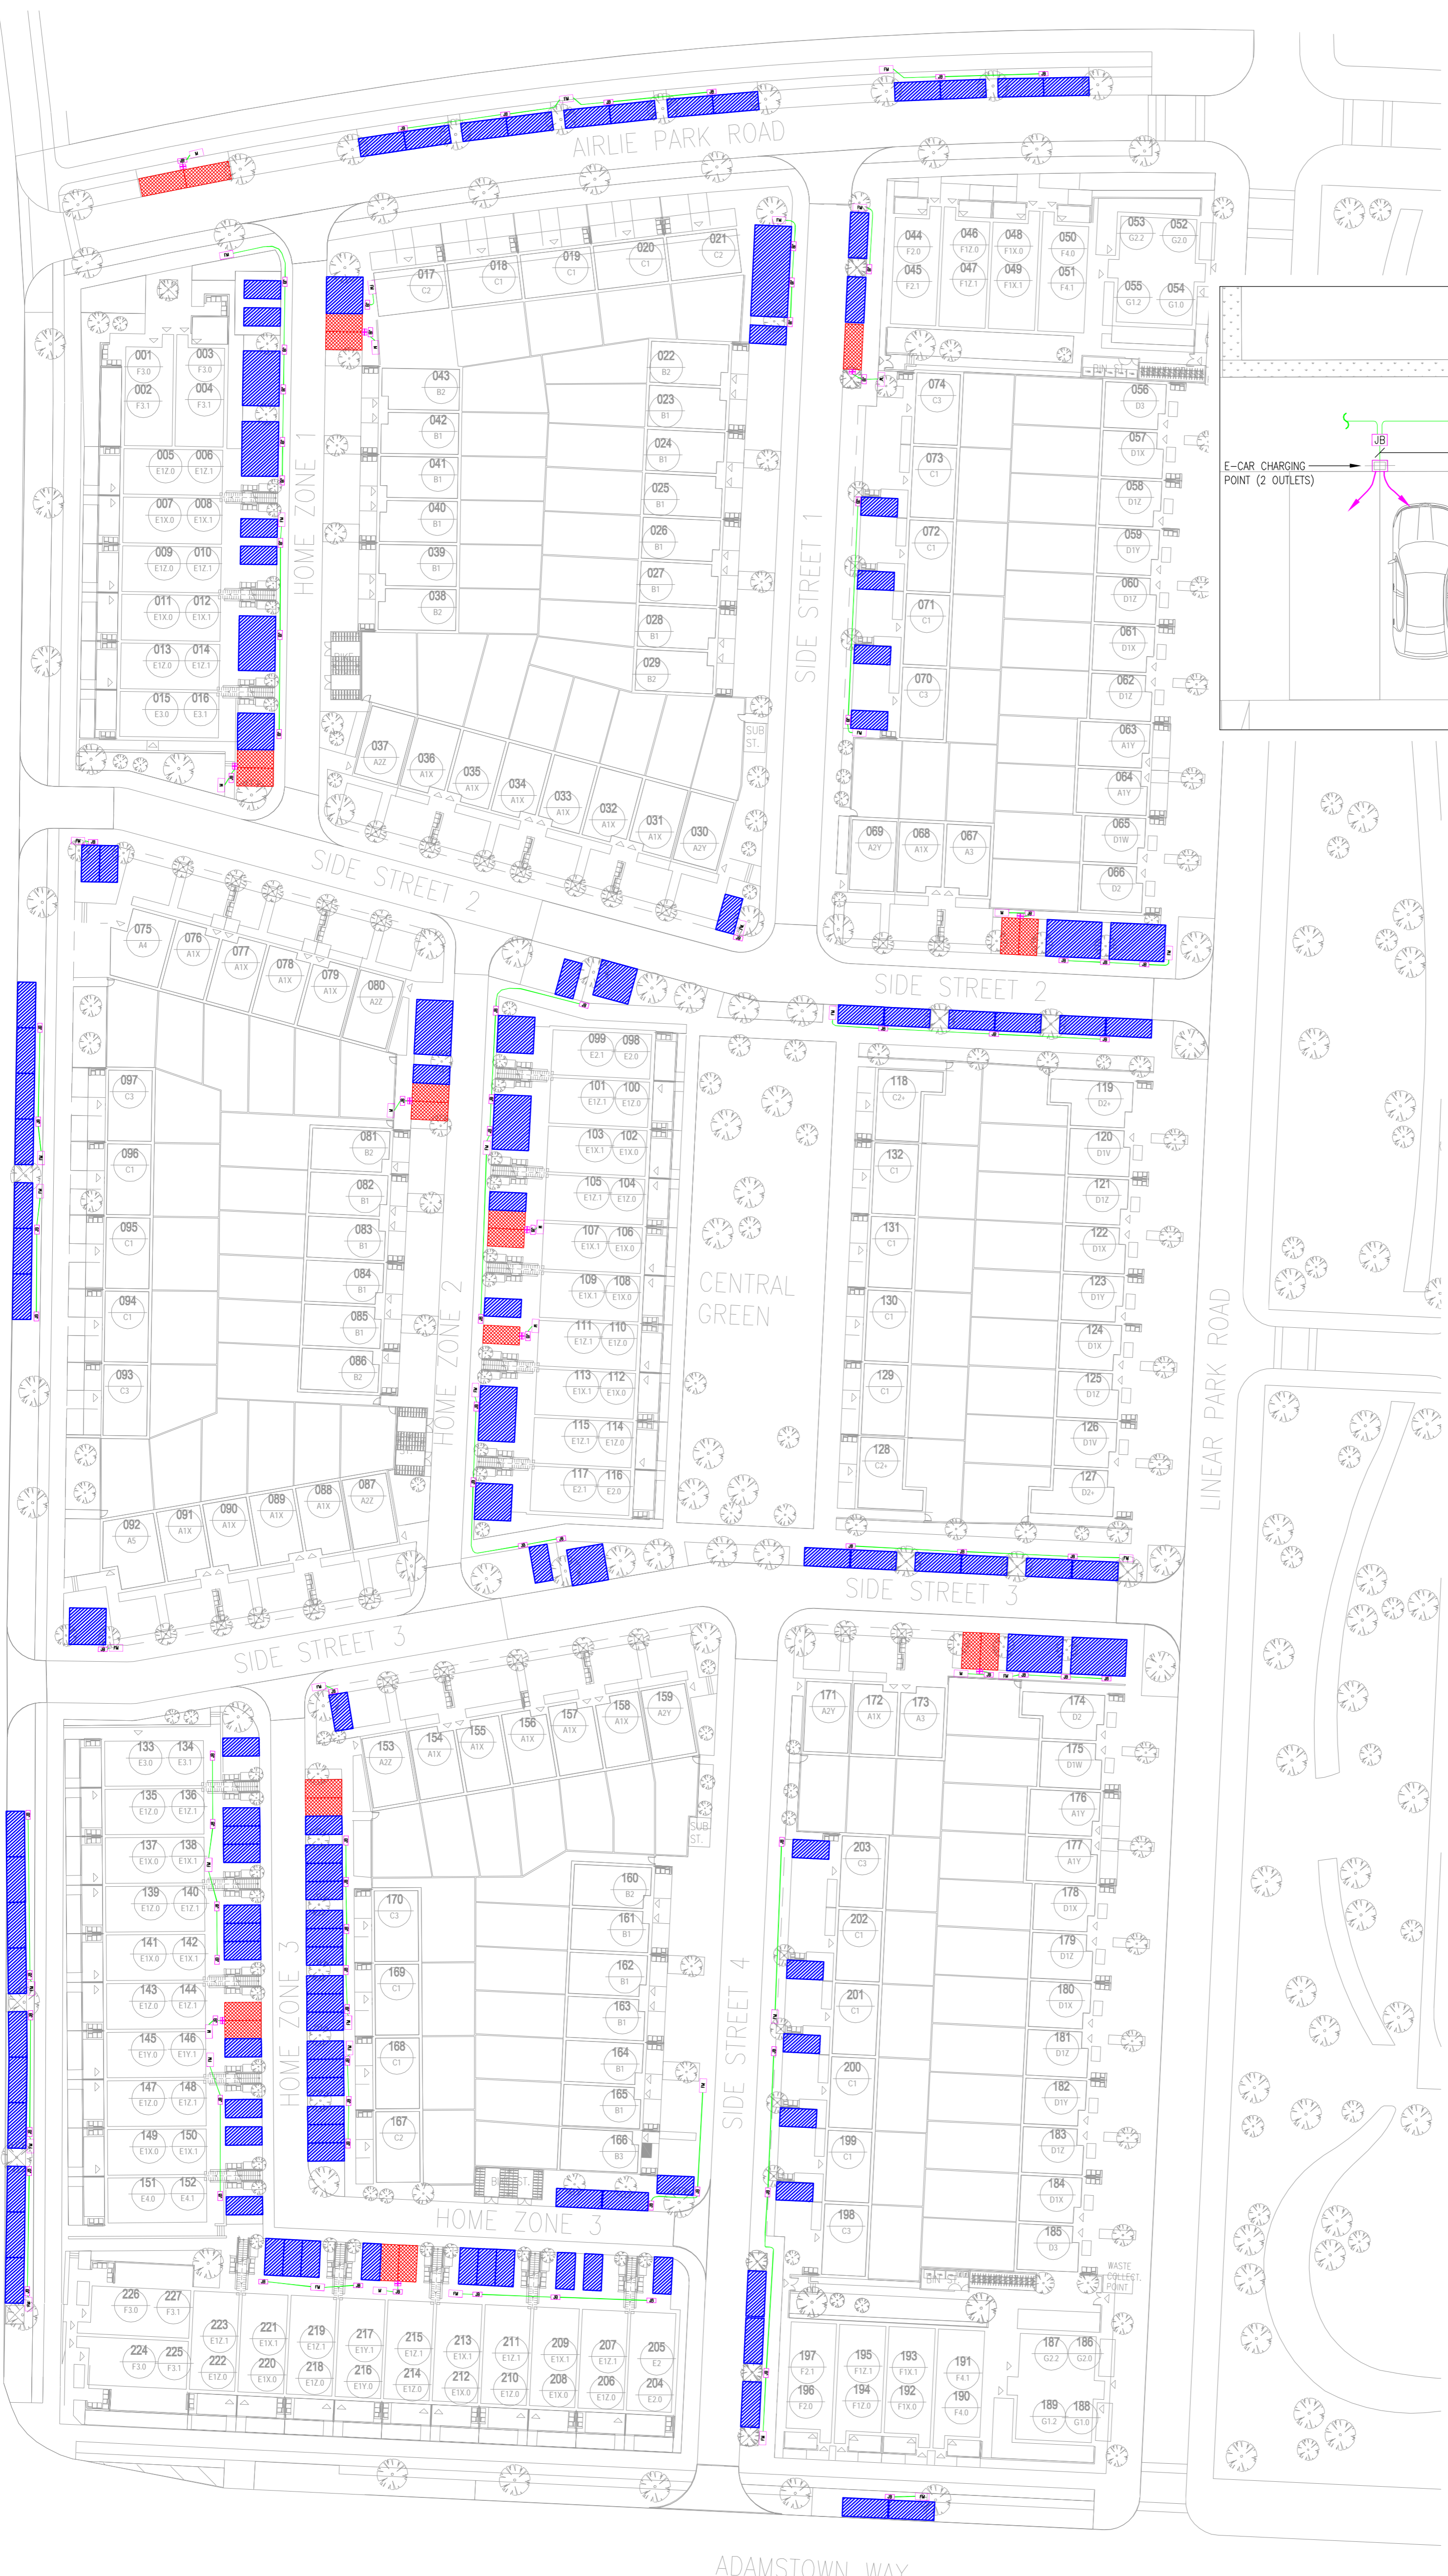

T1	17/12/21	UPDATED TO REFLECT REVISED SITE PLAN	NB	KF
T	02/12/21	TENDER ISSUE	NB	KF
REV.	DATE	AMENDMENT	DRN	APPD

STATUS **TENDER**

Waterman Moylan
Engineering Consultants

BLOCK 5, EASTPOINT BUSINESS PARK, ALFIE BYRNE ROAD,
DUBLIN D03 H3F4 IRELAND.
Tel: (01) 664 8900 Fax: (01) 661 3618
Email: info@waterman-moylan.ie www.waterman-moylan.ie

CLIENT **QUINTAIN IRELAND**

ARCHITECT **BKD ARCHITECTS**

PROJECT **RESIDENTIAL DEVELOPMENT
ADERRIG PHASE 2
ADAMSTOWN
Co. DUBLIN**

TITLE **ELECTRICAL/MECHANICAL ENGINEERING SERVICES
SITE UTILITIES
PROPOSED E-CAR CHARGE POINT LAYOUT**

DRAWN NB	DESIGNED TS	APPROVED KF	DATE OCT 2021
SCALE 1:500 @ A1	JOB NO. 21-072	DRG. NO. E1003	REVISION T1