


USE FIGURED DIMENSIONS ONLY

ALL DIMENSIONS TO BE CHECKED BY THE CONTRACTOR ON SITE. ANY ERRORS OR DISCREPANCIES TO BE REPORTED TO THE ENGINEER IN CHARGE.

NOTES

1. Drawings to be read in conjunction with all relevant Architects, Engineers and specialists drawings.
2. Do not scale, use given dimensions only. All dimensions are in millimeters except where shown.
3. Inform the Engineer of any discrepancies prior to proceeding with works.
4. This drawing should be printed in colour for clarity.
5. All levels to ordnance datum.
6. All connections, bedding etc is to be done strictly in accordance with Irish Water specifications & details.
7. For addition notes see drawing XXXX-MCE-00-XX-C-0000_Standard Notes

SURFACE WATER LEGEND

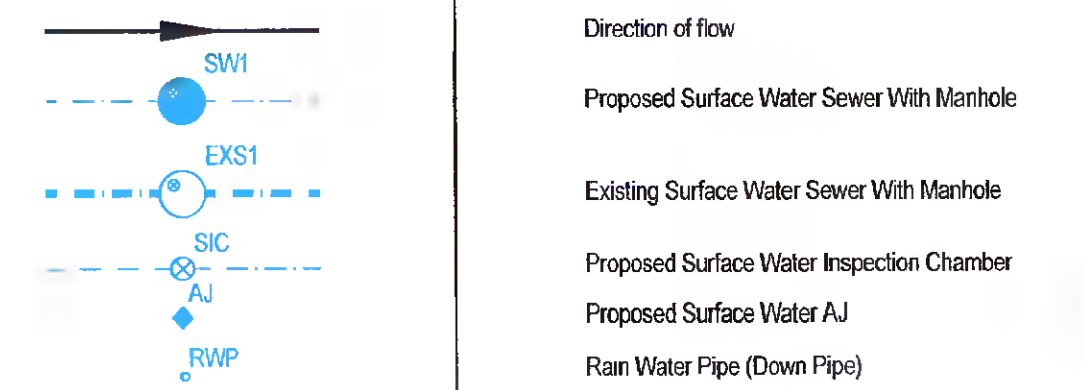

Rev.	Date	Description	By	Check
P2	12.05.2022	ISSUED FOR PLANNING ADDITIONAL INFORMATION	LOB	RMC
P1	05.10.2021	ISSUED FOR INFORMATION	LOB	RMC

THIS DRAWING IS COPYRIGHT ©
NO PART OF THIS DRAWING MAY BE REPRODUCED IN ANY FORM OR STORED IN ANY RETRIEVAL SYSTEM OF ANY NATURE WITHOUT THE WRITTEN PERMISSION OF MCE CONSULTING ENGINEERS EXCEPT AS AGREED FOR USE ON THE PROJECT FOR WHICH THE DRAWING WAS ORIGINALLY ISSUED.

PLANNING APPLICATION

Project Name: LYNBROOK HOUSES
 Drawing Title: SURFACE WATER DRAINAGE LAYOUT
 Architect: BROCK FINUCANE ARCHITECTS

Drawn: LOB
 Checked: NOB
 Approved: RMC
 Scale: 1:200 @ A1



M & C R A E
 CONSULTING ENGINEERS

FIRE, CIVIL & STRUCTURAL
 CONSULTING ENGINEERS
 REAR 684 ANHOURFIELD TERRACE,
 DUNELIN BUSINESS PARK, DUNELIN 14
 TEL: 01 296 2599
 INFO@MCEENGINEERS.IE
 WWW.MCEENGINEERS.IE

Project No:	Originator:	Volume:	Level:	Type:	Role:	Number:	Rev:
5558	MCE	00	XX	DR	C	0003	P1



Surface Water Drainage Layout
 SCALE 1:200