


Proposed Block Plan & Drainage Layout
SCALE 1:200

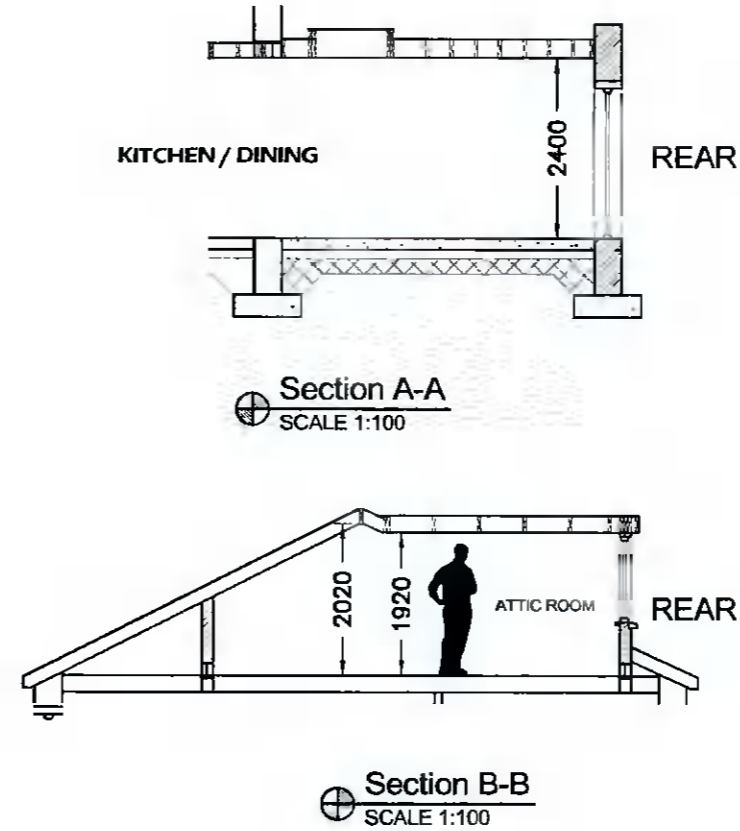

Section A-A
SCALE 1:100

Section B-B
SCALE 1:100

DRAINAGE LEGEND

- PROPOSED 150Ø UPVC SURFACE WATER PIPE
- PROPOSED 150Ø UPVC FOUL SEWER PIPE
- EXISTING SURFACE WATER PIPE
- EXISTING FOUL SEWER PIPE

P	ISSUED FOR PLANNING	TW	MAY 2022
REV:	REVISION TITLE:	DRN:	CHD:

THIS DRAWING IS ISSUED FOR PLANNING PERMISSION ONLY, AND IS NOT A CONSTRUCTION DRAWING

Architectural Planning

4 CARRIGMORE CLOSE, AYLESBURY,
Dublin 24 - Ph: 01 4148358

CLIENT: **Deidre & Darren White**
JOB TITLE: **Proposed Works at 41 The Drive, Boden Park, Rathfarnham, Dublin 16**

TITLE: **Proposed Block Plan, Drainage Layout & Sections**

SCALE: as shown INITIALS: TW DATE: Apr' 2022

JOB No: S477 DRAWING No: 004 REV: P

NOTES:
This drawing is to be read in conjunction with all relevant Engineers drawings.
Do not scale use figured dimensions ONLY.
All dimensions in millimeters unless otherwise stated.
All dimensions to be checked on site.
All building works to comply with current building regulations & in accordance with Homebond Standards.