


DRAINAGE LEGEND

	PROPOSED 1500 UPVC SURFACE WATER PIPE
	PROPOSED 1500 UPVC FOUL SEWER PIPE
	EXISTING SURFACE WATER PIPE
	EXISTING FOUL SEWER PIPE

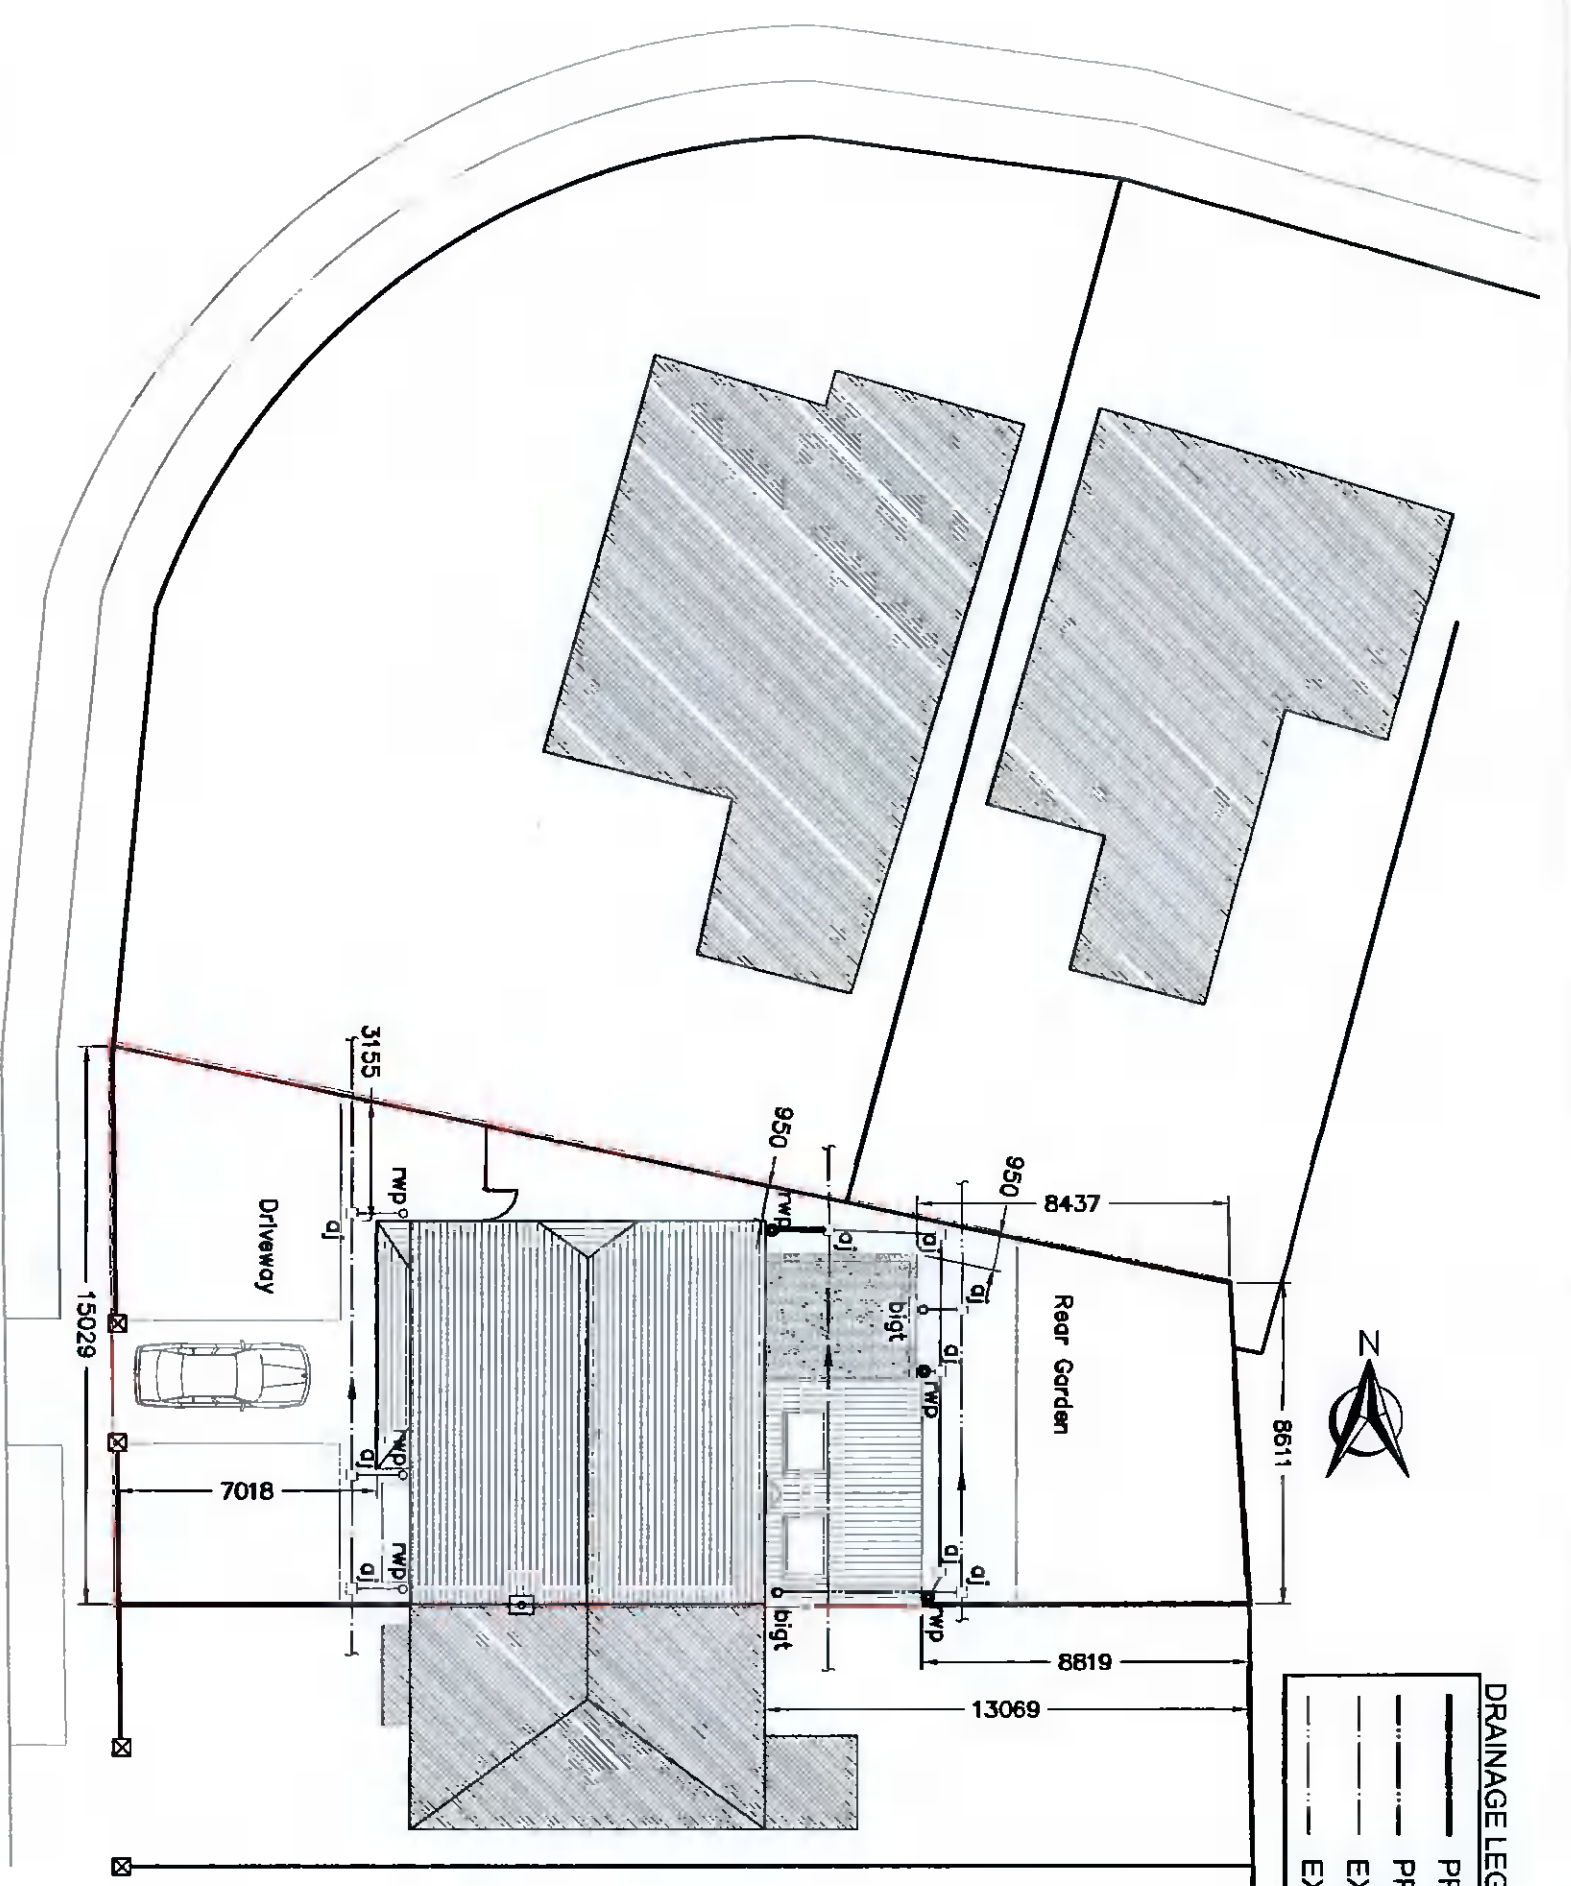

Proposed Block Plan & Drainage Layout
 SCALE 1:200

ISSUED FOR PLANNING	TW	APR 2022
REV: REVISION TITLE:	DRN: CHD: DATE:	

Architectural Planning

4 CARRIGMORE CLOSE, AYLESBURY,
 Dublin 24 - Ph: 01 4148358

CLIENT: **NEIL & CIARA REID**
 JOB TITLE: **PROPOSED WORKS AT 1 WOODSTOWN RISE, KNOCKLYON, DUBLIN 16**

TITLE: **PROPOSED BLOCK PLAN & DRAINAGE LAYOUT**

SCALE: 1:200	INITIALS: TW	DATE: APR 2022
JOB No: S401	DRAWING No: 004	REV: P

NOTES:
 This drawing is to be read in conjunction with all relevant Engineers drawings.
 Do not scale use figured dimensions ONLY.
 All dimensions in millimeters unless otherwise stated.
 All dimensions to be checked on site.
 All building works to comply with current building regulations & in accordance with Homebond Standards.

**NOTE : ALL SURFACE WATER TO DISCHARGE TO SURFACE WATER MAINS.
 ALL FOUL WATER TO DISCHARGE TO FOUL SEWER**

THIS DRAWING IS ISSUED FOR PLANNING PERMISSION ONLY, AND IS NOT A CONSTRUCTION DRAWING