




**PROPOSED CARPARK SURFACE WATER DRAINAGE LAYOUT**  
SCALE 1:200

- GENERAL NOTES:**
1. THIS DRAWING IS TO BE READ IN CONJUNCTION WITH ALL RELEVANT ARCHITECTS & ENGINEERS DRAWINGS, SPECIFICATIONS, ETC..
  2. DO NOT SCALE, USE FIGURED DIMENSIONS ONLY (WHERE APPLICABLE)
  3. ANY DISCREPANCIES / DEVIATIONS ENCOUNTERED TO BE REPORTED TO THE ENGINEER IMMEDIATELY (IN WRITING).
  4. FOR ALL SETTING OUT DIMENSIONS REFER TO ARCHITECTS DRAWINGS.

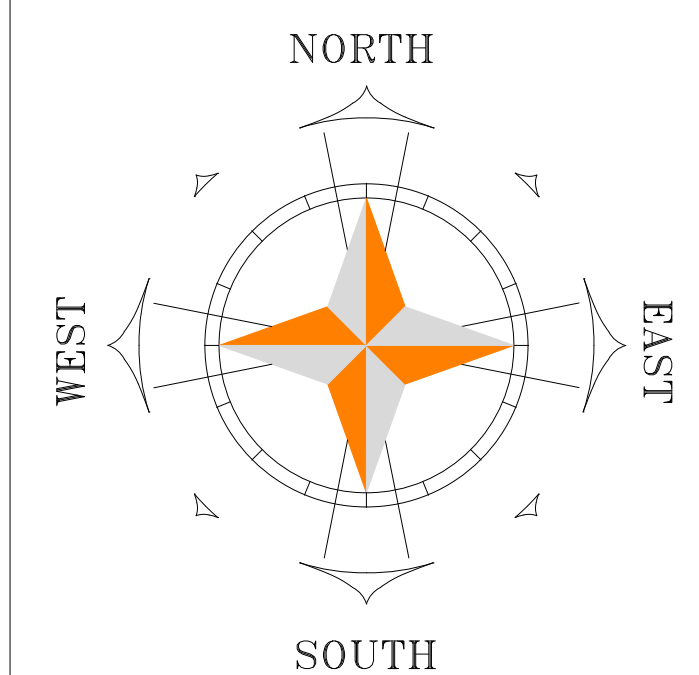

- LEGEND**
- F10.1 PROPOSED FOUL
  - PROPOSED CARPARK FOUL
  - 600Ø EXISTING FOUL
  - FMH P12 IL 83.382
  - PROPOSED PERMEABLE PAVING SURFACE

\*\*\* DO NOT SCALE USE FIGURED DIMENSIONS ONLY \*\*\*

P2	PF	LAYOUT REVISED	13-05-2022
P1	PF	NEW DRAINAGE LAYOUT	26-04-2022
REV:	BY:	AMENDMENTS:	DATE:

DRAWN BY:	PM	TECH. CHECK:	PF
SCALE:	1:200	SIZE:	A1
DATE:	26/04/2022	ENG. CHECK:	AF
DRAWING STATUS:		APPROVED:	AF

**FOR PLANNING**

CLIENT: GEENHILLS LIVING  
C/O BELVEDERE LIVING LTD

JOB TITLE: BANCROFT VIEW SHD

DRAWING TITLE: CARPARK DRAINAGE LAYOUT

JOB No:	DRAWING No:	REV:
20_4993	607	P2