


FOUL MH	Cover Level	Invert Level
1	87.00	85.50
2	86.20	85.50
3	87.20	85.35
4	87.20	85.20
5	86.70	85.40
6	86.40	85.30
7	86.20	85.01
8	86.20	85.00
9	86.30	84.95
10	86.00	84.89
10.1	86.35	84.74
10.2	86.35	84.59
11	86.35	84.84
12	86.50	84.60
<b>SADDLE CONNECTION</b>	<b>86.50</b>	<b>84.58</b>

- GENERAL NOTES:
1. THIS DRAWING IS TO BE READ IN CONJUNCTION WITH ALL RELEVANT ARCHITECTS & ENGINEERS DRAWINGS, SPECIFICATIONS, ETC..
  2. DO NOT SCALE, USE FIGURED DIMENSIONS ONLY (WHERE APPLICABLE)
  3. ANY DISCREPANCIES / DEVIATIONS ENCOUNTERED TO BE REPORTED TO THE ENGINEER IMMEDIATELY (IN WRITING).
  4. FOR ALL SETTING OUT DIMENSIONS REFER TO ARCHITECTS DRAWINGS.

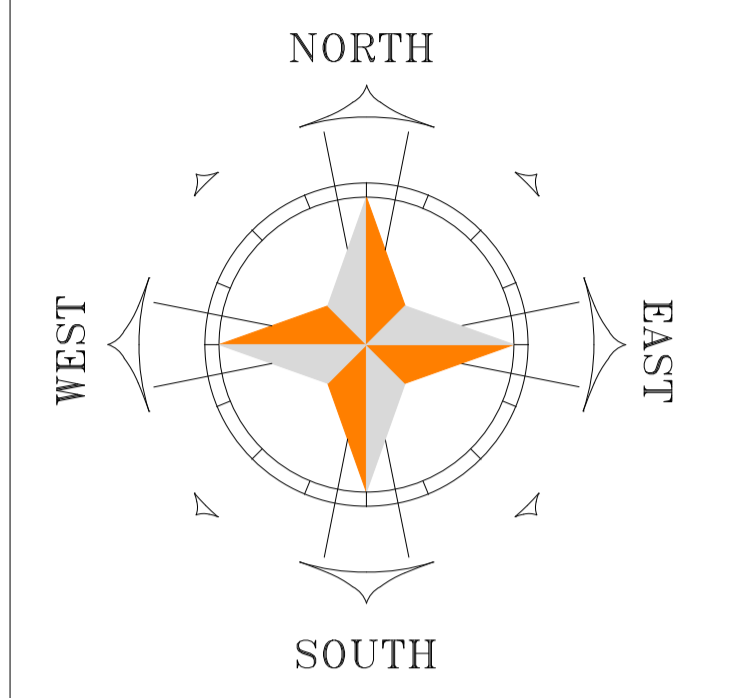

- LEGEND
- PROPOSED FOUL
  - PROPOSED 1000 HDPE SR17 RISING MAIN
  - EXISTING FOUL
  - SP/VP

NOTE:  
PIPE MATERIAL PVC-U S8 TO E.N. 13476-2:2007 UNLESS NOTED OTHERWISE.

\*\*\* DO NOT SCALE USE FIGURED DIMENSIONS ONLY \*\*\*

P6	PF	LAYOUT REVISED	13-05-2022
P5	PF	LAYOUT REVISED	02-05-2022
P4	PF	LAYOUT REVISED	26-04-2022
P3	PM	FOR COMMENT	15/01/2021
P2	PM	FOR COMMENT	13/01/2021
REV:	BY:	AMENDMENTS:	DATE:

DRAWN BY:	PM	TECH. CHECK:	PM
SCALE:	1:200	SIZE:	A1
DATE:	08/01/2021	ENG. CHECK:	AF
DRAWING STATUS:	APPROVED: AF		

**FOR PLANNING**


CLIENT: GEENHILLS LIVING  
C/O BELVEDERE LIVING LTD

JOB TITLE: BANCROFT VIEW SHD

DRAWING TITLE: PROPOSED FOUL WATER DRAINAGE LAYOUT

Fitzsimons Doyle & Associates  
250 Harold's Cross Road, Dublin 6w  
Tel: +353 (0) 4966011 Fax: +353 (0) 4967018  
Web: www.fidaconsulting.ie Email: admin@fidaconsulting.ie

JOB No:	DRAWING No:	REV:
20_4993	601	P6

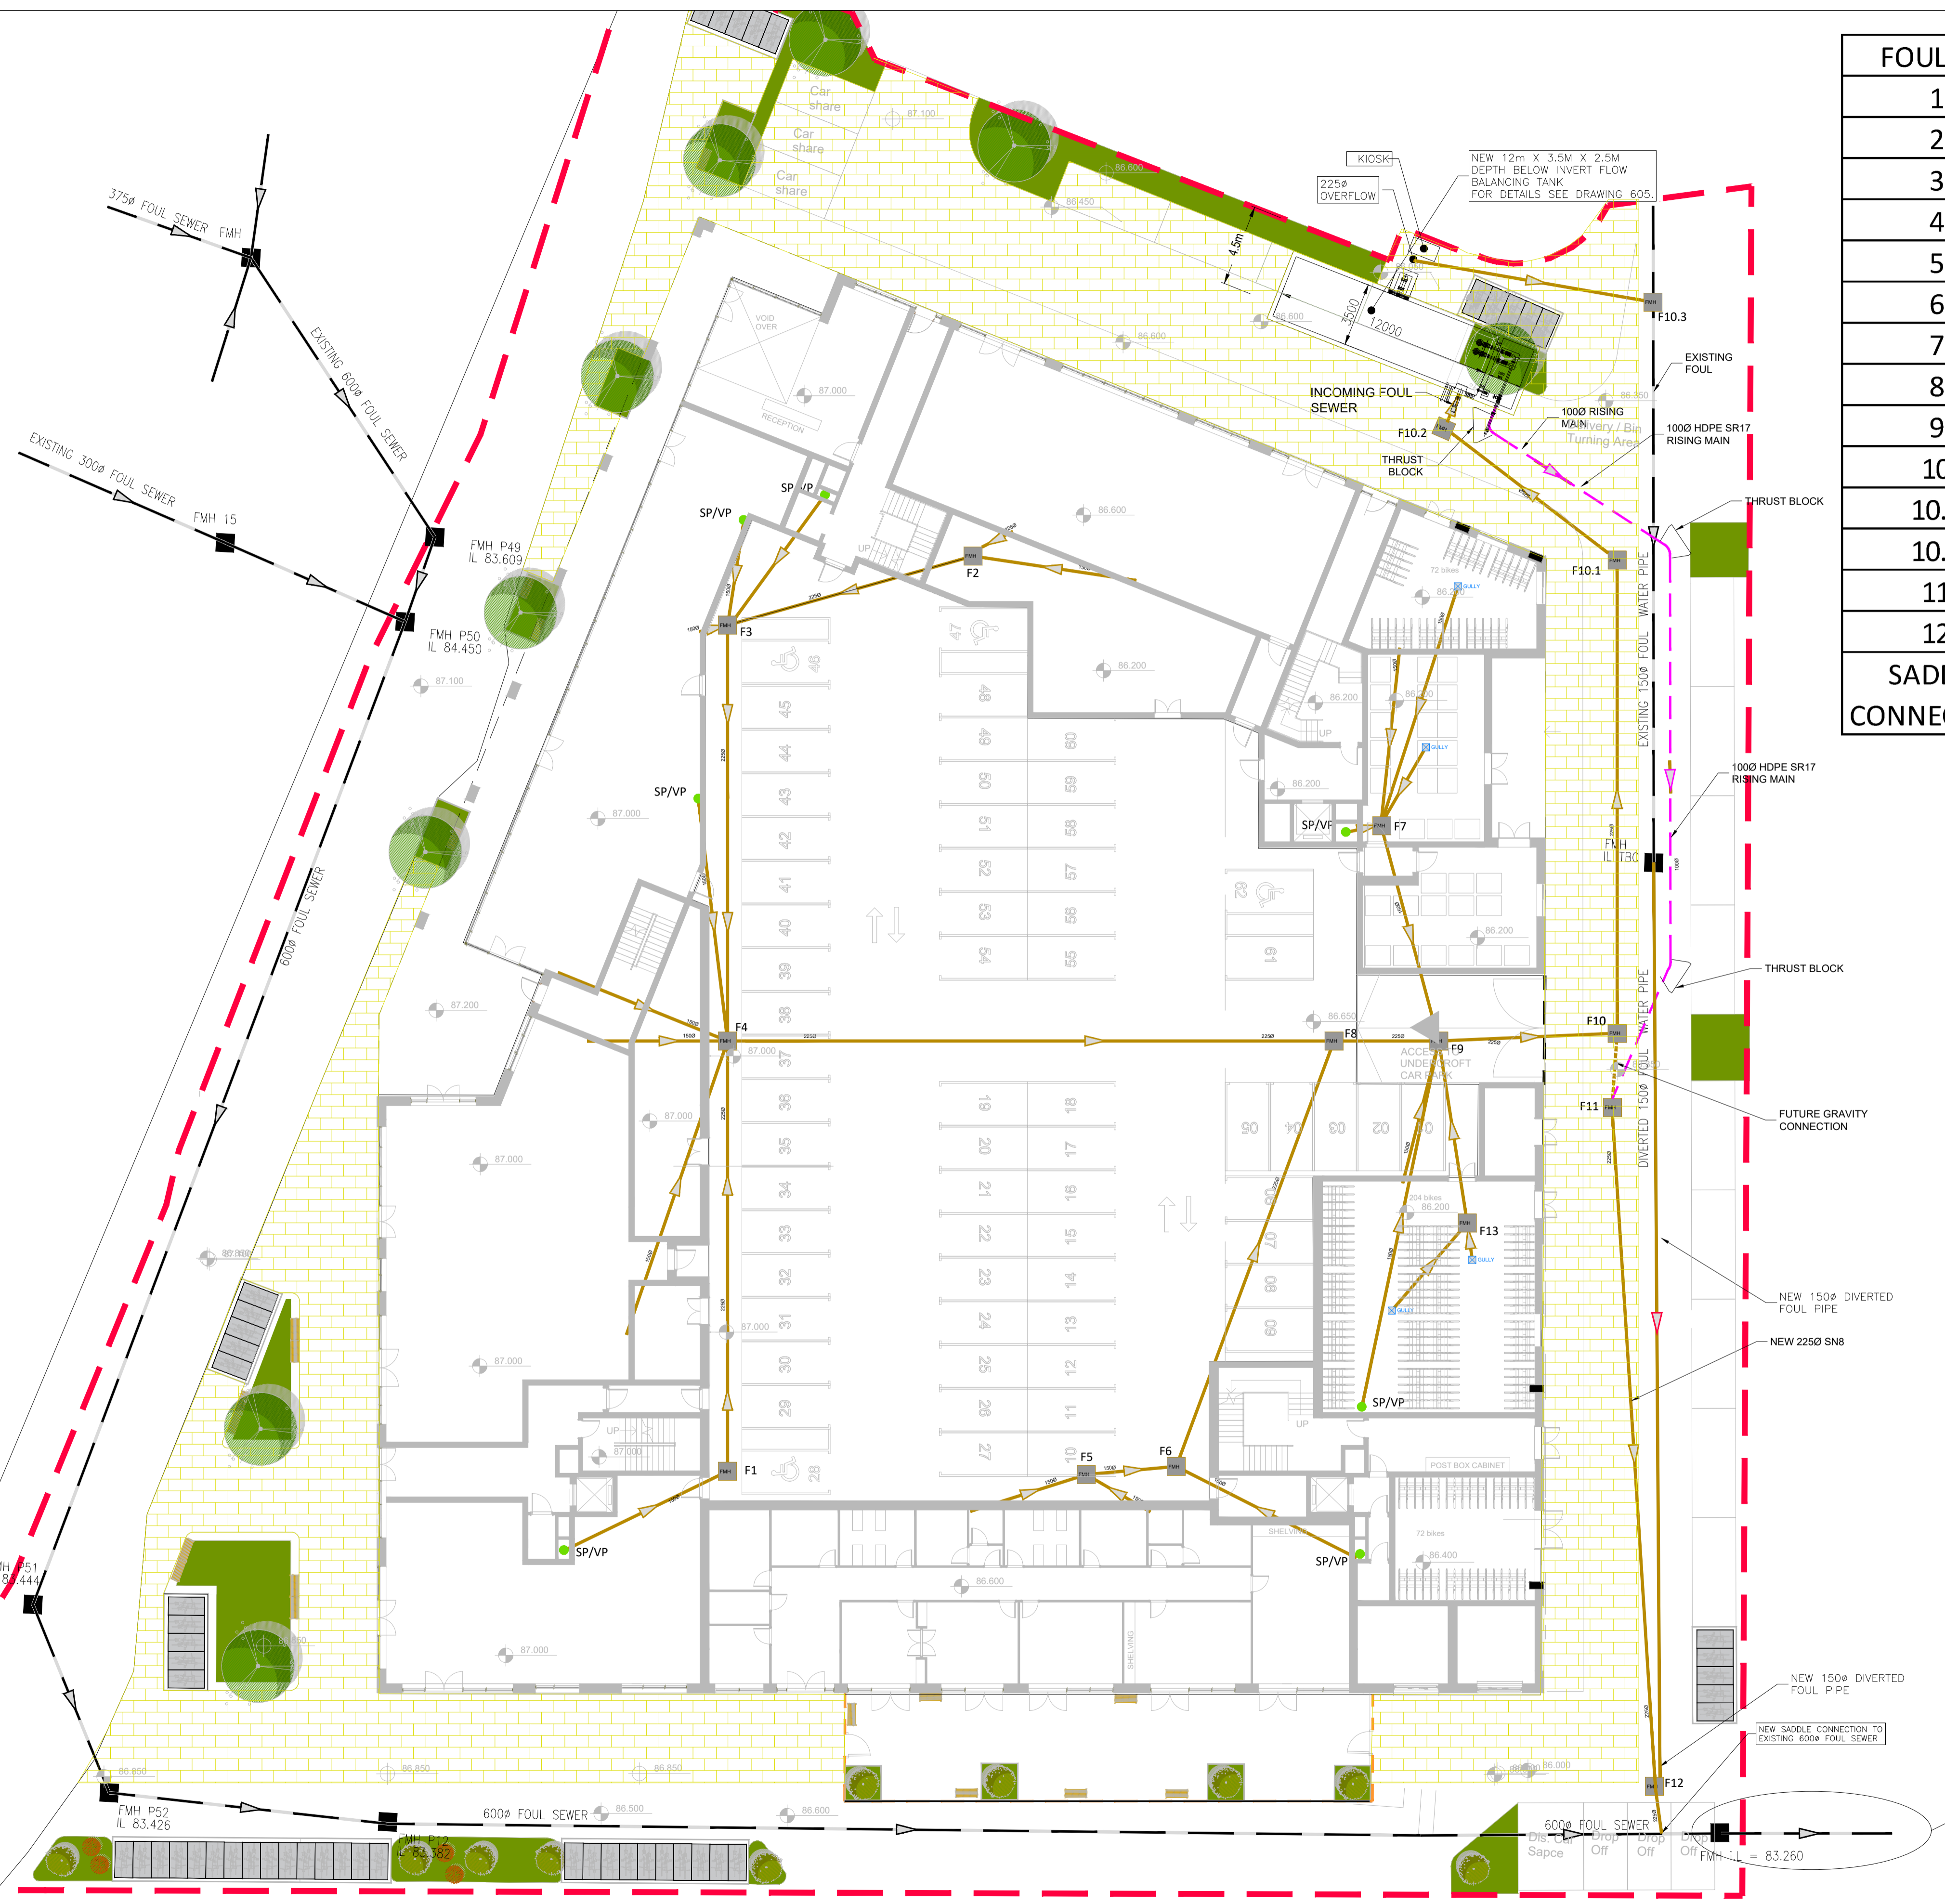

DETAIL 1  
DWG - 20-4993-606

PROPOSED FOUL WATER DRAINAGE LAYOUT  
SCALE 1:200