


- NOTES:
- DO NOT SCALE. USE FIGURED DIMENSIONS ONLY.
 - THIS DRAWING IS TO BE READ IN CONJUNCTION WITH ALL OTHER RELEVANT ARCHITECTURAL AND ENGINEERING DRAWINGS.
 - IT IS THE CONTRACTOR'S RESPONSIBILITY TO ENSURE THAT ALL WORKS ARE CONSTRUCTED IN ACCORDANCE WITH THE IRISH WATER CODE OF PRACTICE AND STANDARD DETAILS. THE CODE OF PRACTICE AND STANDARD DETAILS ARE AVAILABLE TO DOWNLOAD FROM THE IRISH WATER WEB SITE AT WWW.WATER.CO/CONTRACTORS/DEVELOPER-SERVICES/ WHERE THE DETAILS CONTAINED ON THIS DRAWING DIFFER FROM THE IRISH WATER CODE OF PRACTICE OR STANDARD DETAILS THIS MUST BE BROUGHT TO THE ATTENTION OF THE ENGINEER IMMEDIATELY. IRISH WATER STANDARDS WILL TAKE PRECEDENCE.

LEGEND:

- EXTENT OF WORKS
- AREA SUBJECT OF APPLICATION FOR OUTLINE PERMISSION
- FW MHXXX CL XXXX IL XXXX → EXISTING FOUL WATER SEWER WITH PIPE SIZE, GRADE, MANHOLE REF. AND INVERT LEVEL
- SW MHXXX CL XXXX IL XXXX → EXISTING SURFACE WATER SEWER WITH PIPE SIZE, GRADE, MANHOLE REF. AND INVERT LEVEL
- 100mm @ 1:100 → PROPOSED FOUL WATER SEWER WITH PIPE SIZE, GRADE, MANHOLE REF. AND INVERT LEVEL
- 100mm @ 1:100 → PROPOSED SURFACE WATER SEWER WITH PIPE SIZE, GRADE, MANHOLE REF. AND INVERT LEVEL
- PROPOSED 100mm FOUL WATER HOUSE DRAIN AND INSPECTION CHAMBER
- PROPOSED LINEAR RESERVE WATER FEATURE
- PROPOSED SWALE
- PROPOSED WATER BUTT
- PROPOSED BIORETENTION TREE PIT
- PROPOSED ROAD GULLY

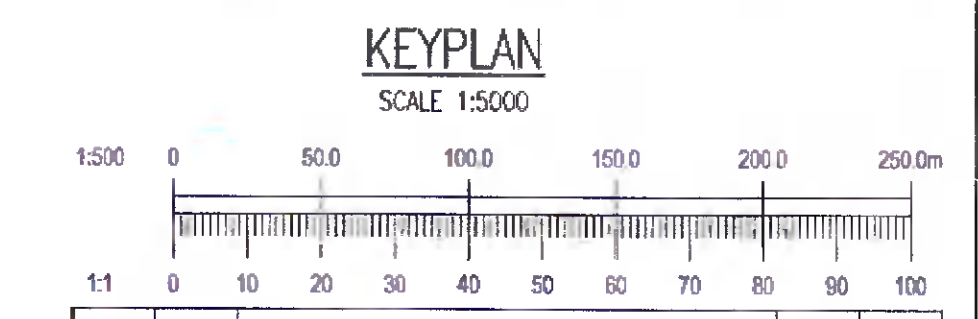

26/04/22	ISSUED FOR PLANNING	MS	EC
REV.	DATE	AMENDMENT	DRN APPD

STATUS FOR PLANNING ONLY
NOT FOR CONSTRUCTION

Waterman Moylan
Engineering Consultants

MARINE HOUSE, CLANWILLIAM PLACE, DUBLIN D02 FY24.
Tel: (01) 664 8500 Fax: (01) 661 3618
Email: info@waterman-moylan.ie www.waterman-moylan.ie

CLIENT **ADAMSTOWN STATION AND BOULEVARD LTD.**
ARCHITECT **MCCAULEY DAYE O'CONNELL ARCHITECTS LTD.**

PROJECT **ADAMSTOWN - BOULEVARD TILE PHASE 1**

TITLE **PROPOSED DRAINAGE LAYOUT SHEET 2 OF 2**

DRAWN MS	DESIGNED EC	APPROVED EC	DATE APRIL 2022
SCALE 1:500 @ A1	JOB NO. 21-074	DRG. NO. P211	REVISION

© 2018. This drawing is prepared as part of an agreement and is not to be reproduced or transmitted in any form or used in any manner without the prior written permission of the consulting engineer. No copyright notice is required as per the project for which it is prepared.