
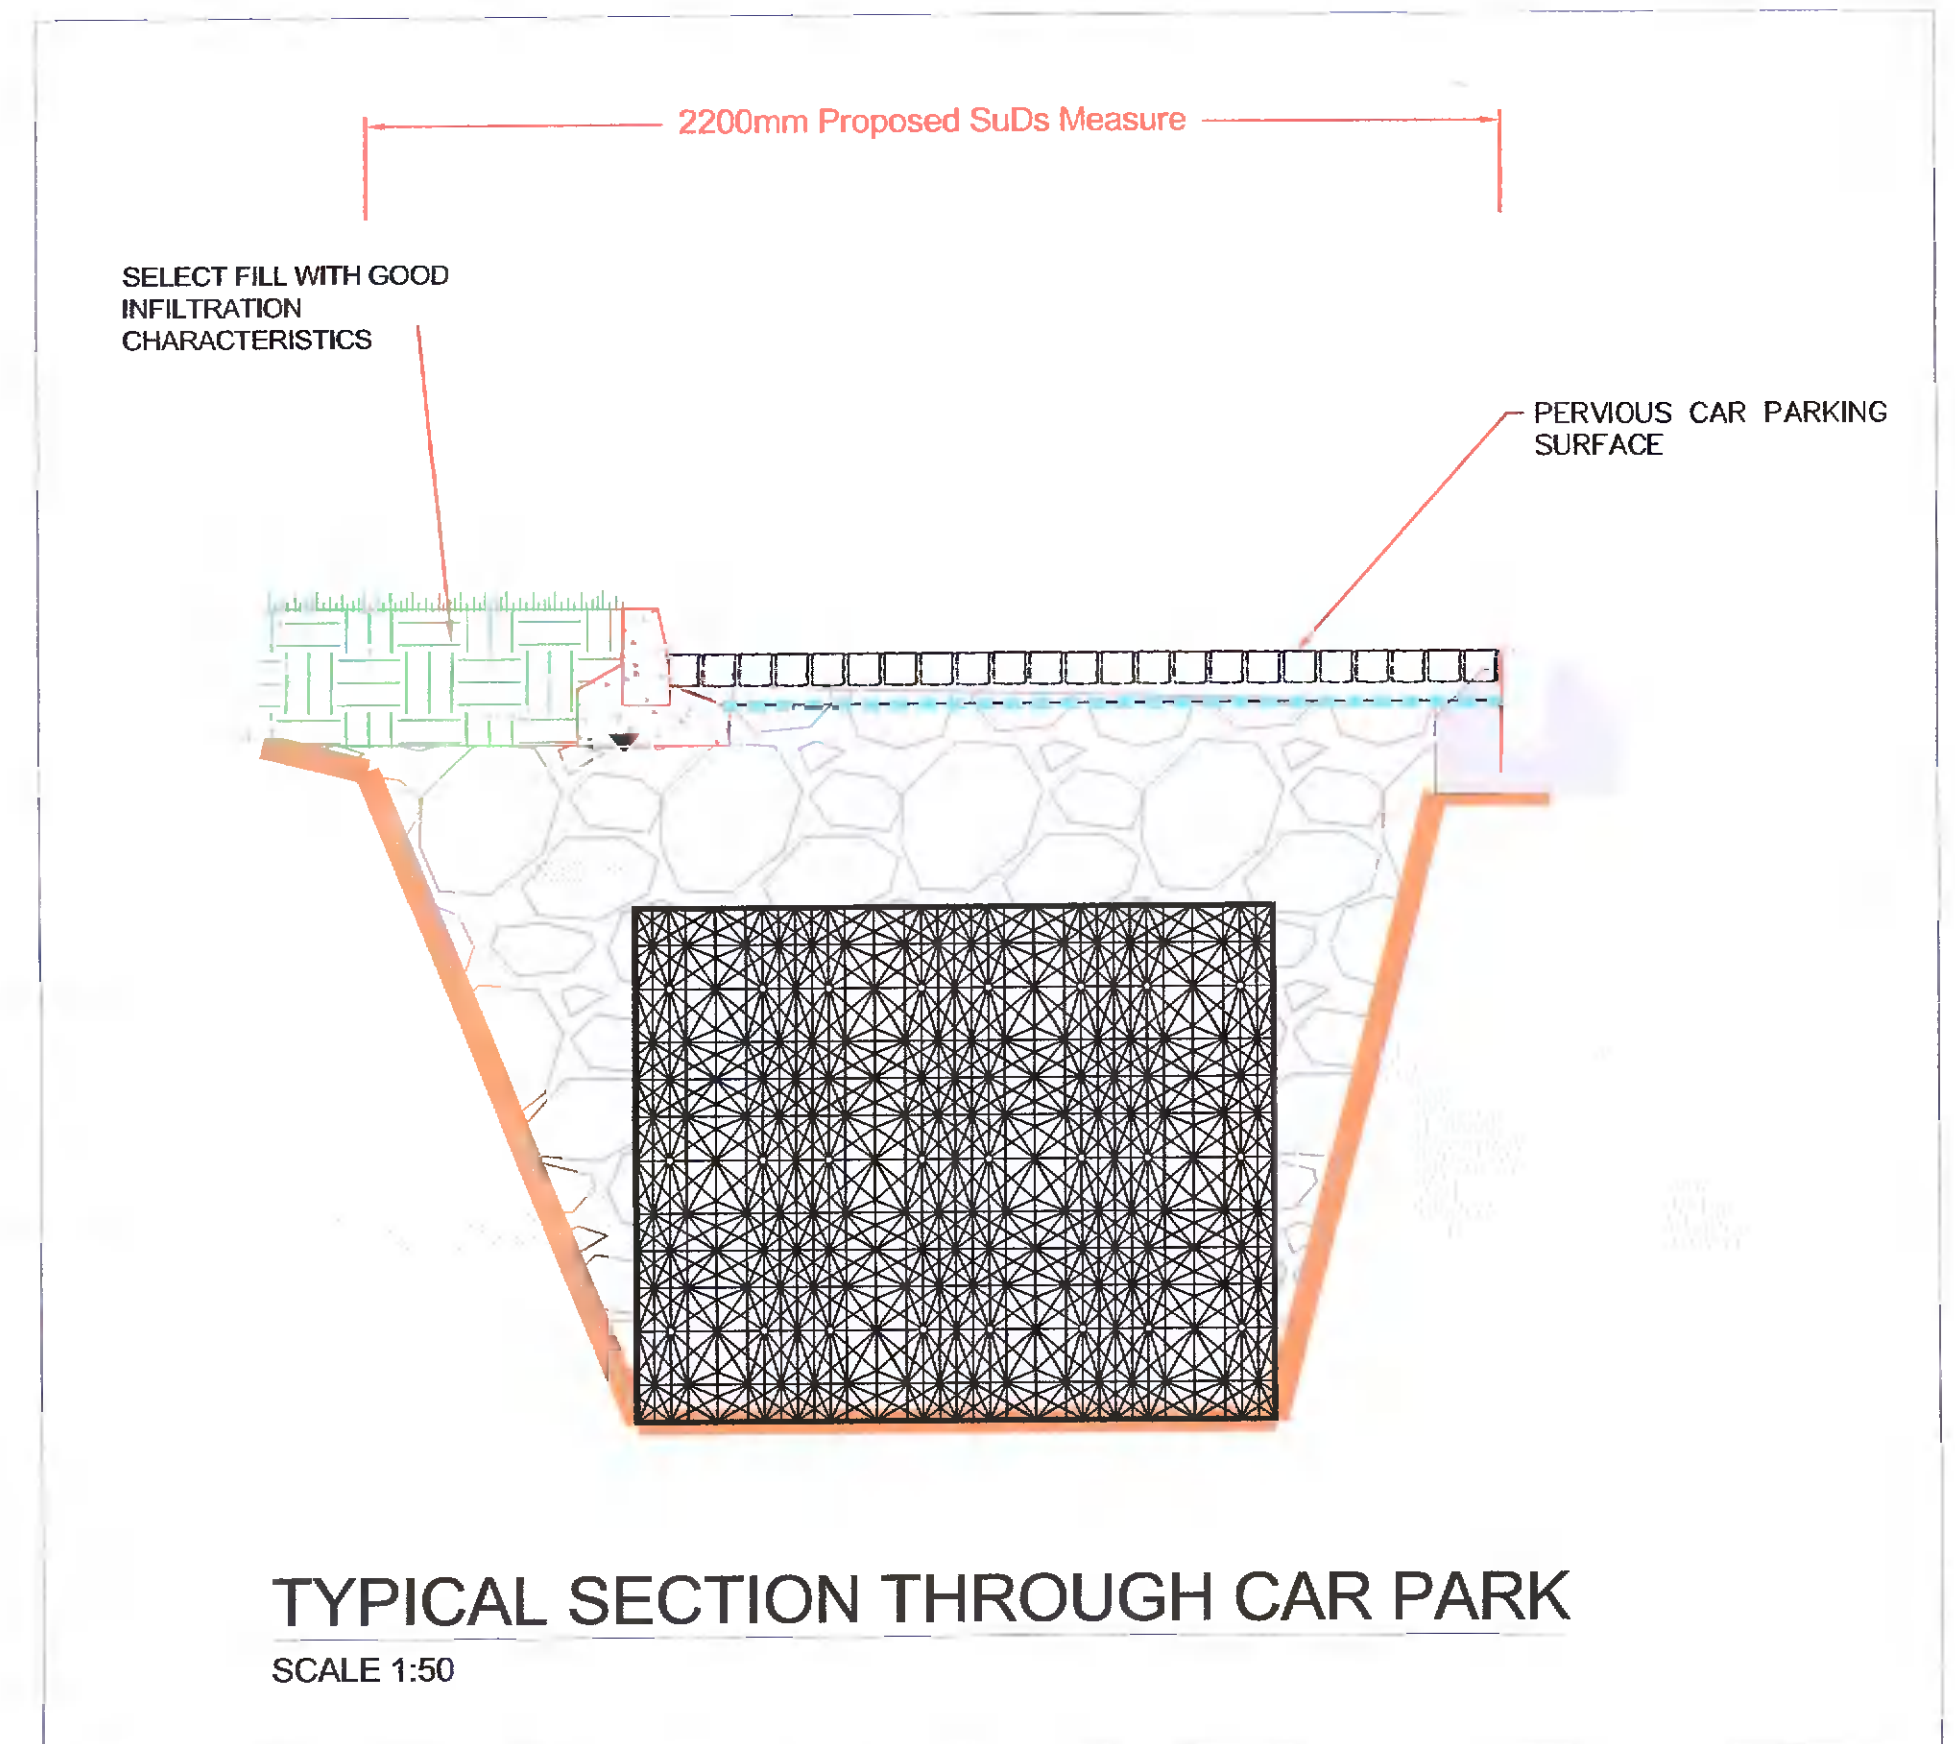


P04

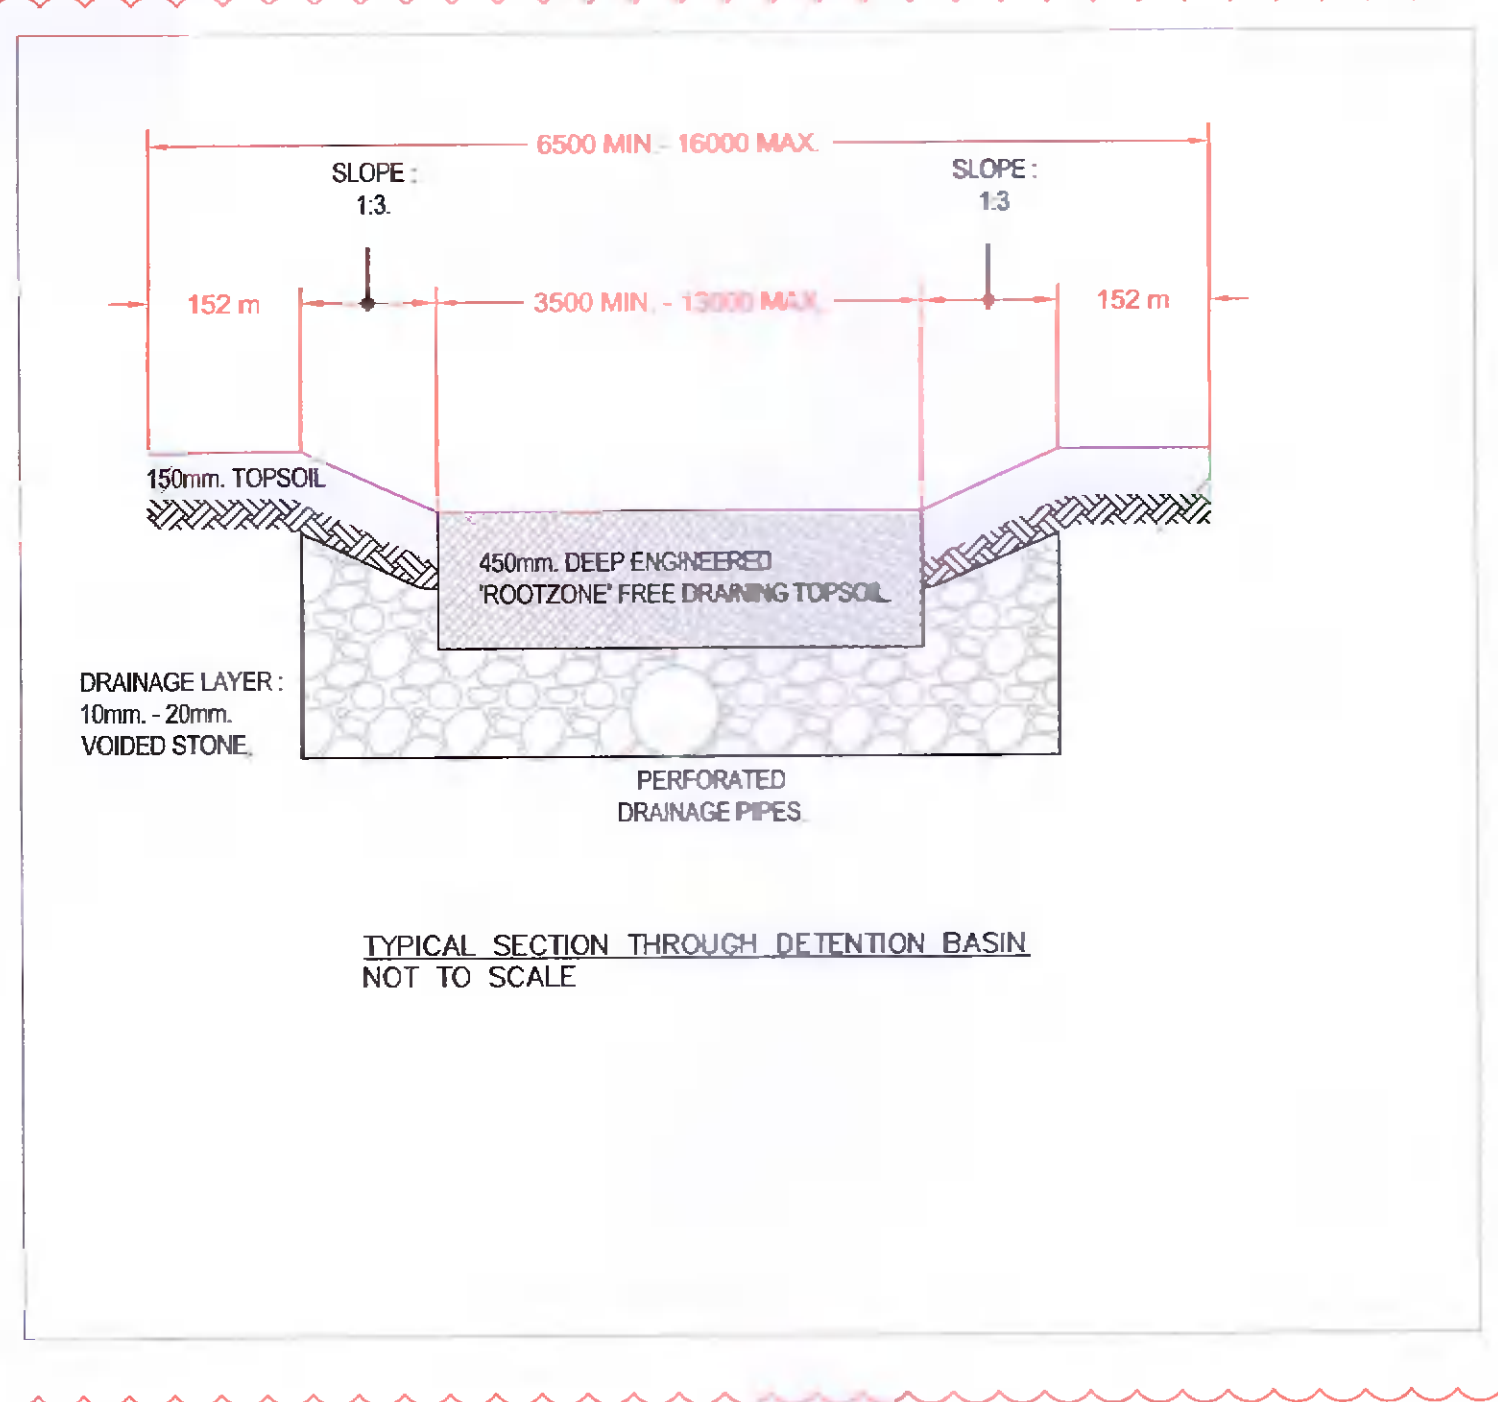

- NOTES:**
1. FIGURED DIMENSIONS ONLY TO BE TAKEN FROM THIS DRAWING.
 2. ALL DRAWINGS TO BE CHECKED BY THE CONTRACTOR ON SITE
 3. ENGINEER/EMPLOYERS REPRESENTATIVE, AS APPROPRIATE, TO BE INFORMED BY THE CONTRACTOR OF ANY DISCREPANCIES BEFORE ANY WORK COMMENCES
 4. THE CONTRACTOR SHALL UNDERTAKE A THOROUGH CHECK FOR THE ACTUAL LOCATION OF ALL SERVICES/UTILITIES, ABOVE AND BELOW GROUND, BEFORE ANY WORK COMMENCES
 5. ALL LEVELS SHOWN RELATE TO ORDINANCE SURVEY DATUM AT MALIN HEAD

Rev	Date	Description	By	Chkd.
P04	18/05/2022	POND DETAIL AND DETENTION BASIN DETAIL ADDED	PF	LB
P03	23/03/2022	CARP PARKING SECTION ADDED	PF	MCC
P02	09/12/2021	DETENTION BASIN AND SWALE ADDED	PF	MCC
P01	18/02/2021	ISSUED FOR PLANNING	PF	MCC

Client: **centrica**

Project: **PROFILE PARK POWER PLANT**

Title: **PROPOSED SUDs DETAILS**

Scale @ A1:	AS SHOWN	
Prepared by:	Checked:	Date:
PF	MMcC	Feb' 2021
Project Director:	BRIAN CARROLL	
Drawing Status:	PLANNING	

TOBIN
CONSULTING ENGINEERS
TOBIN Consulting Engineers,
Block 10-4, Blanchardstown Corporate Park,
Dublin 15, Ireland.
tel: +353-(0)1-8030406
fax: +353-(0)1-8030409
e-mail: dublin@tobin.ie
www.tobin.ie

Tobin Consulting Engineers will not be liable for any use of this document for any purpose other than that for which it was originally prepared and provided. Except where specifically and explicitly agreed in writing by TOBIN Consulting Engineers, no copyright notice, no part of this document may be reproduced or transmitted in any form and this document shall not be relied upon by any third party for any purpose.

Drawing No.: **11069-2036** | Revision: **P04**

P04

