




North Facing Elevation S2

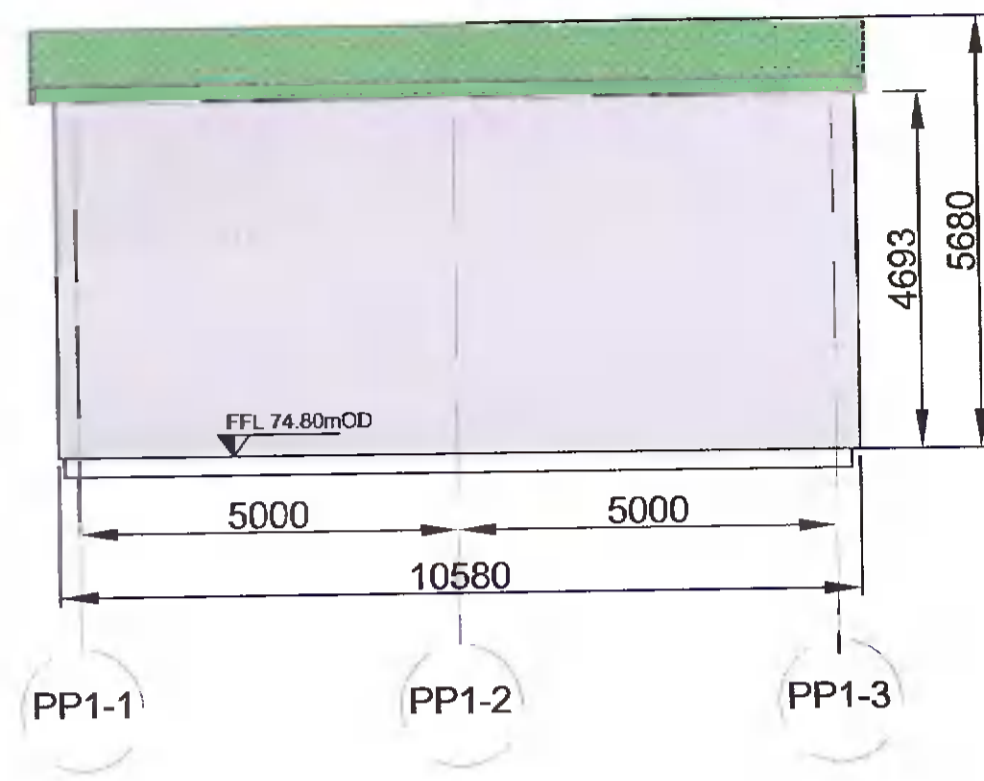


East Facing Elevation S1

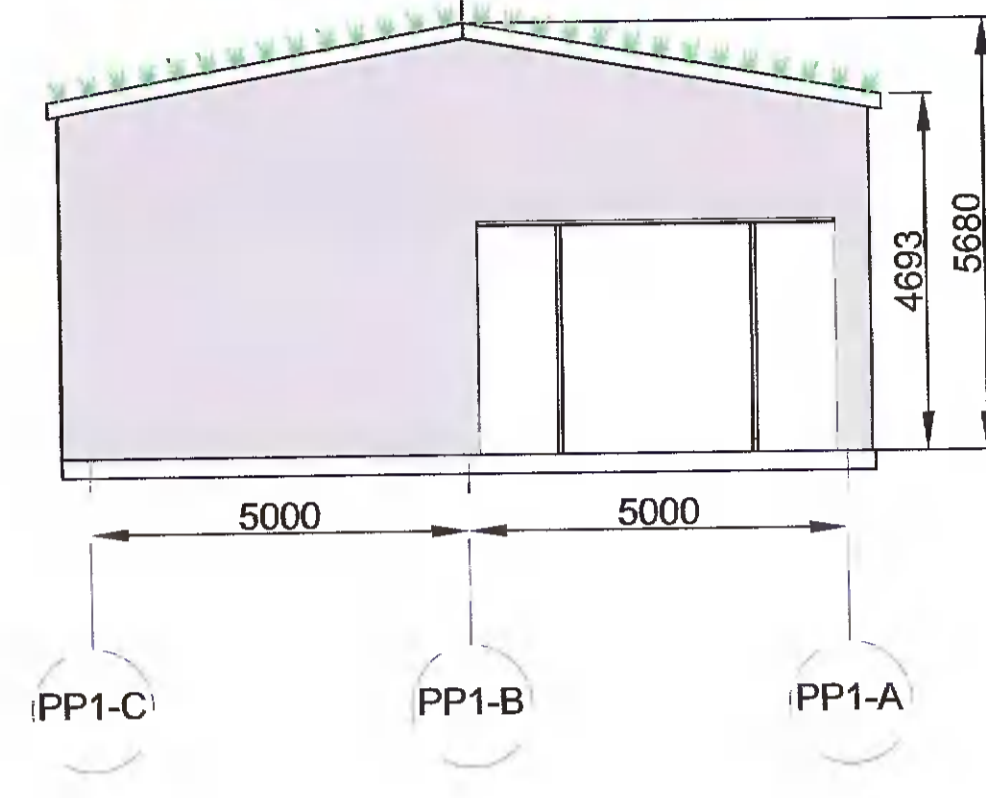


Section S2

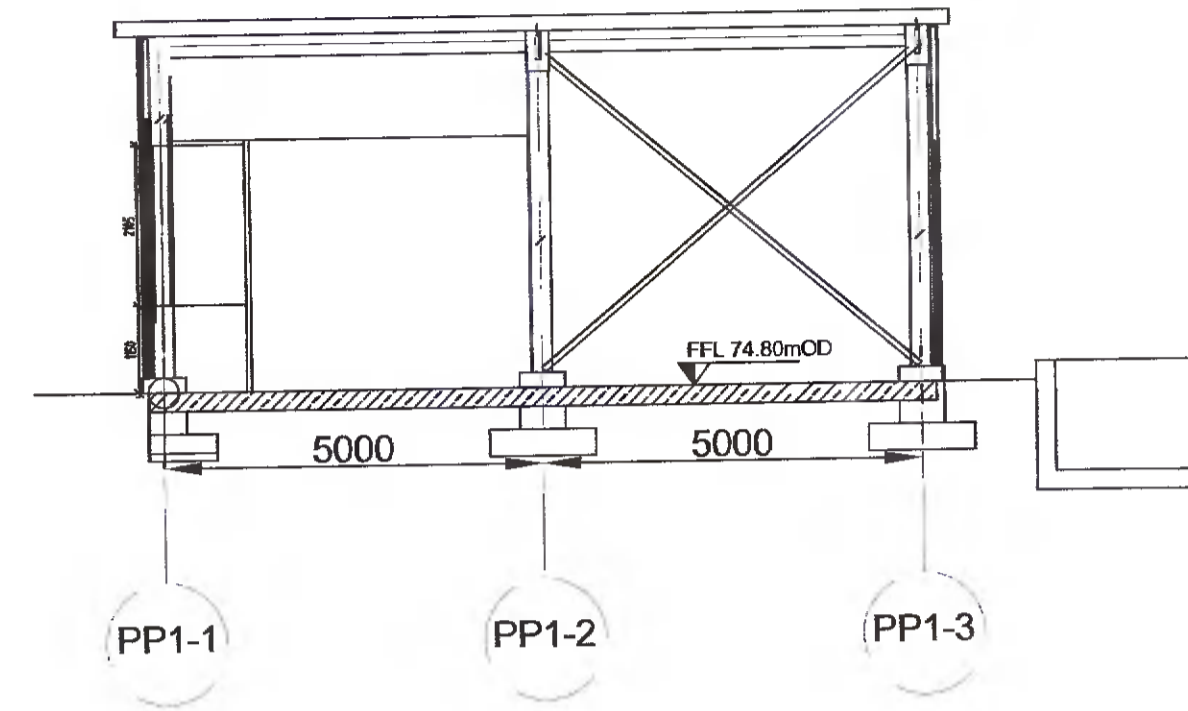



South Facing Elevation S4

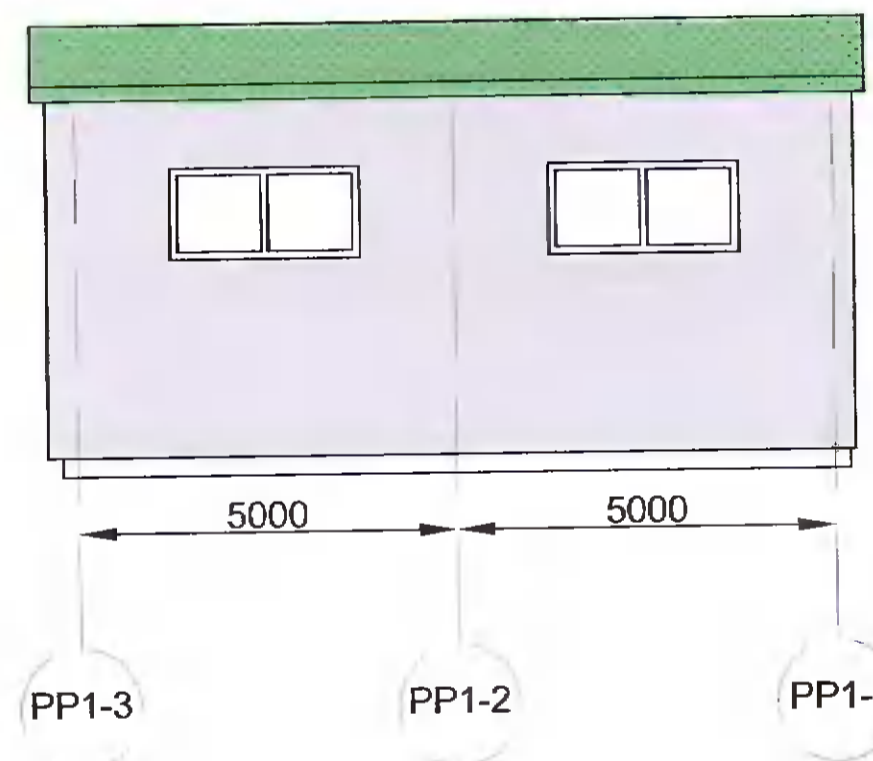

West Facing Elevation S3

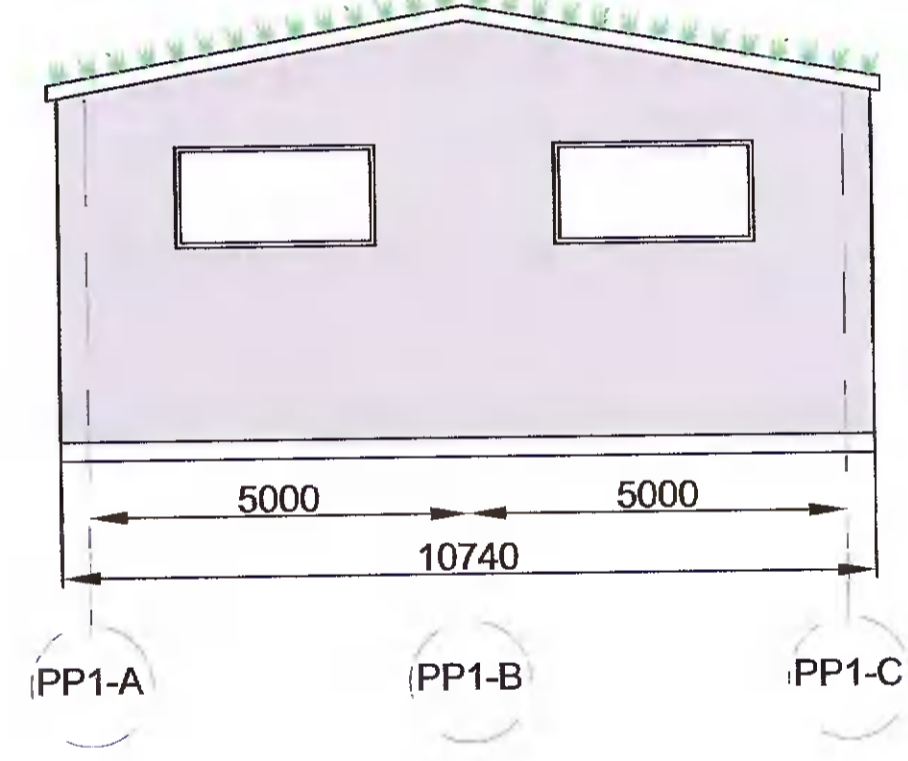

Plan

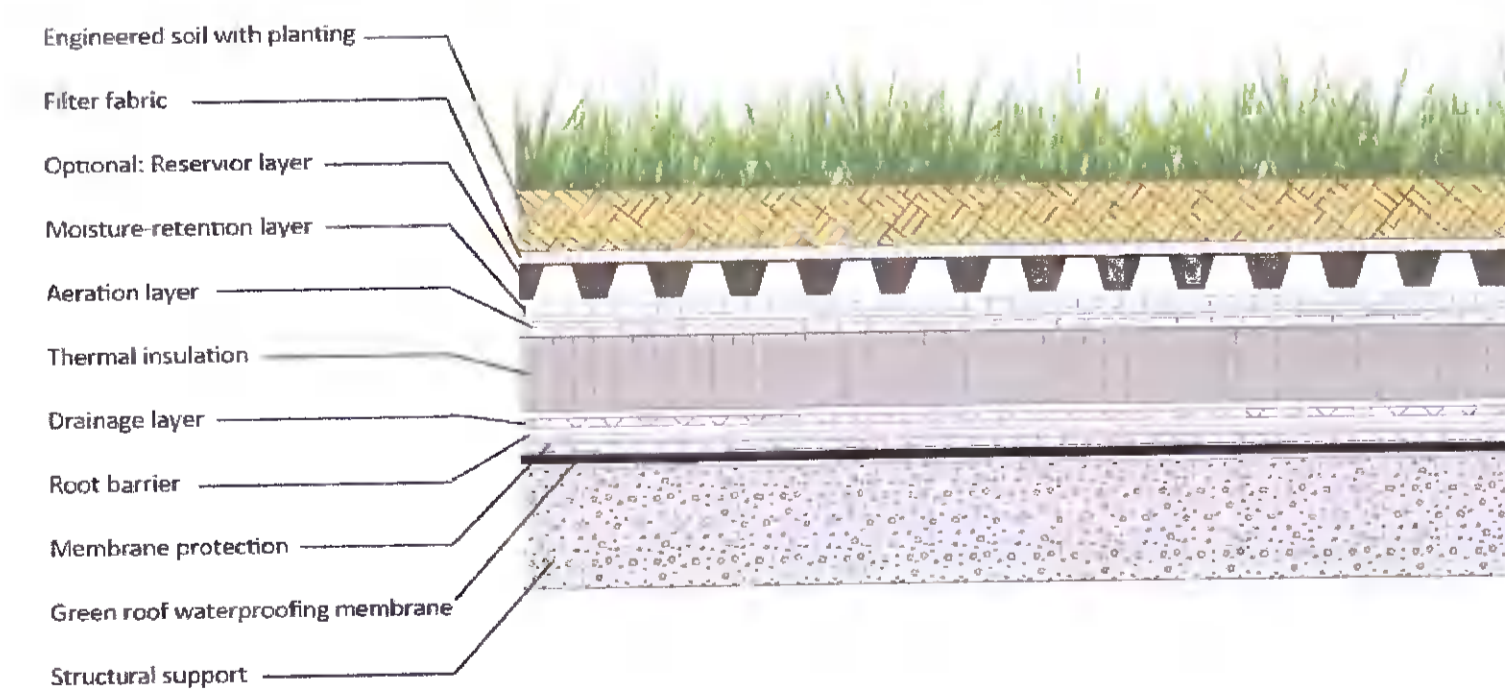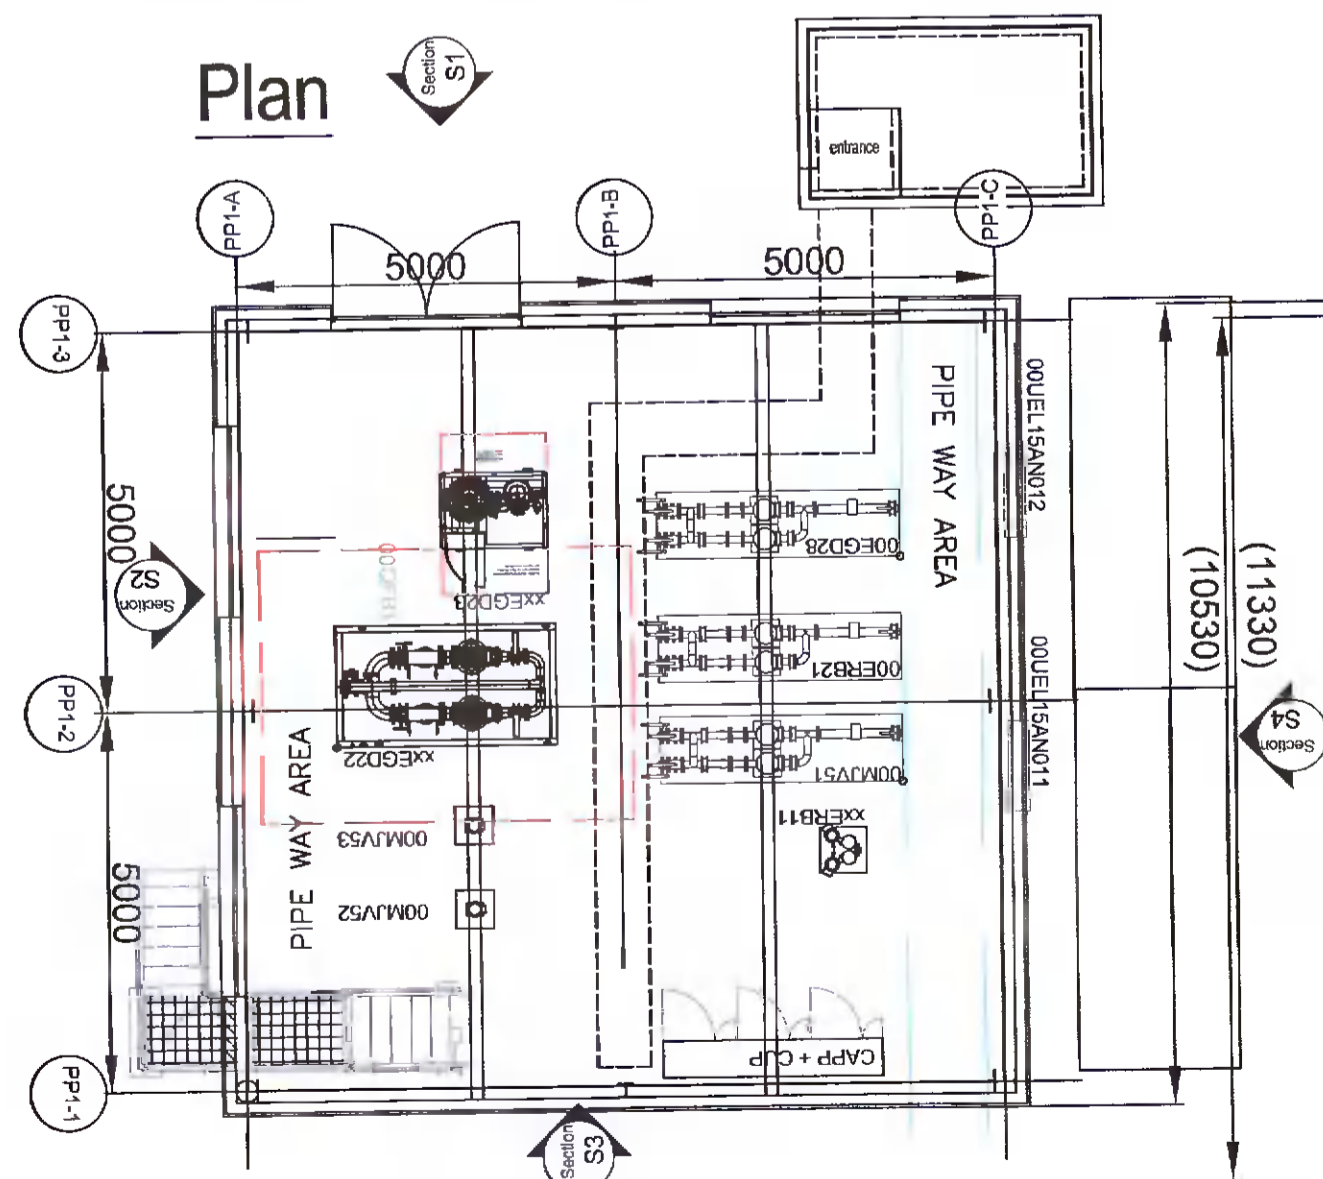

Typical Green Roof Design (TBC at Detailed design stage)

As agreed with South Dublin County Council in the pre-application consultation meeting the final finishes, including cladding materials and colour codes, will be agreed with the Council post planning through planning condition. Greener Ideas Limited will ensure only Council approved finishes are applied on site.

Rev	Date	Description	By	Chkd.
B	23.05.22	CF ISSUE	MN	LB
A	02.03.22	PLANNING ISSUE	MN	MMcC



Client:  
**PROFILE PARK POWER PLANT**

Title:  
**TANK FARM BUILDING PLAN, ELEVATIONS & SECTION**

Scale @ A1: 1:100  
Prepared by: M. Nolan  
Checked: M. McCarthy  
Date: March 2022  
Project Director: S. Tinnelly  
Drawing Status: Planning

**TOBIN**  
CONSULTING ENGINEERS

Block 10-4, Blanchardstown Corporate Park,  
Dublin 15, Ireland.  
tel: +353-(0)1-8030406  
fax: +353-(0)1-8030409  
e-mail: dublin@tobin.ie  
www.tobin.ie

Tobin Consulting Engineers will not be liable for any use of this document for any purpose other than that for which it was originally prepared and produced. Except where specifically and explicitly agreed in writing, by Tobin Consulting Engineers, no copyright holder, in part or in whole, may be reproduced or transmitted in any form and this document shall not be relied upon by any third party for any purpose.  
Drawing No.: 11069-2047  
Revision: B