

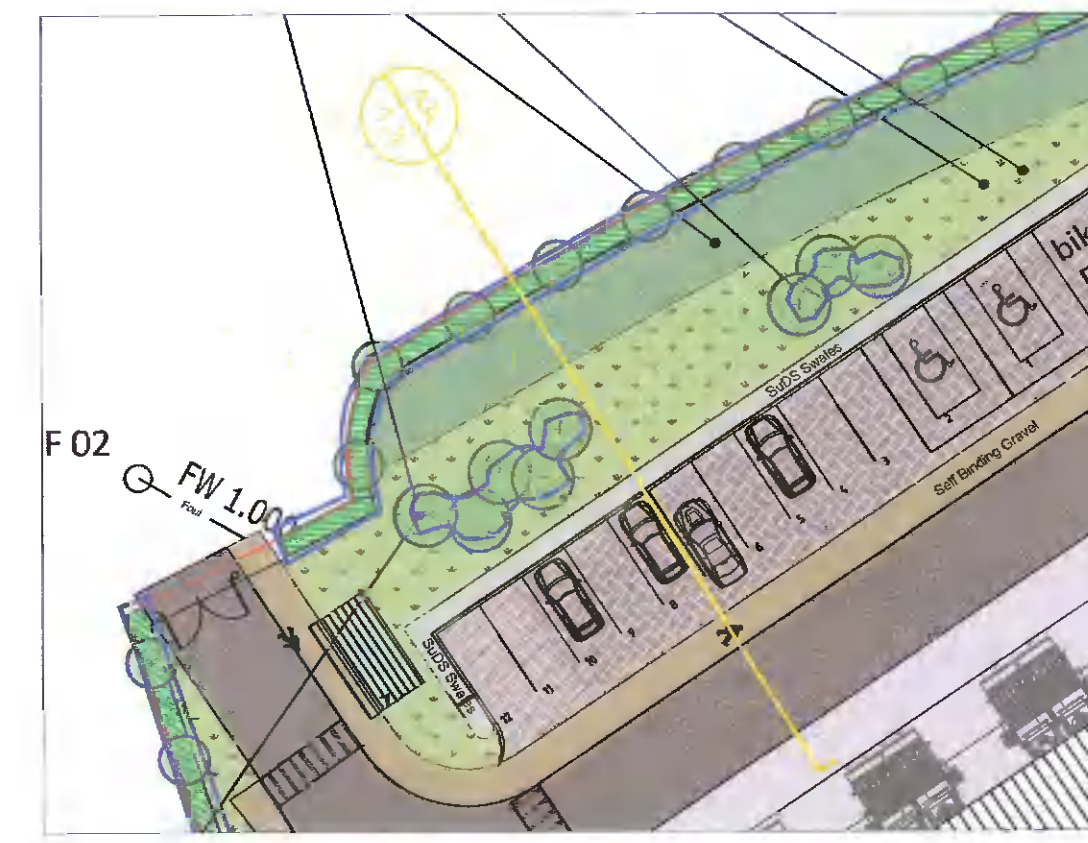
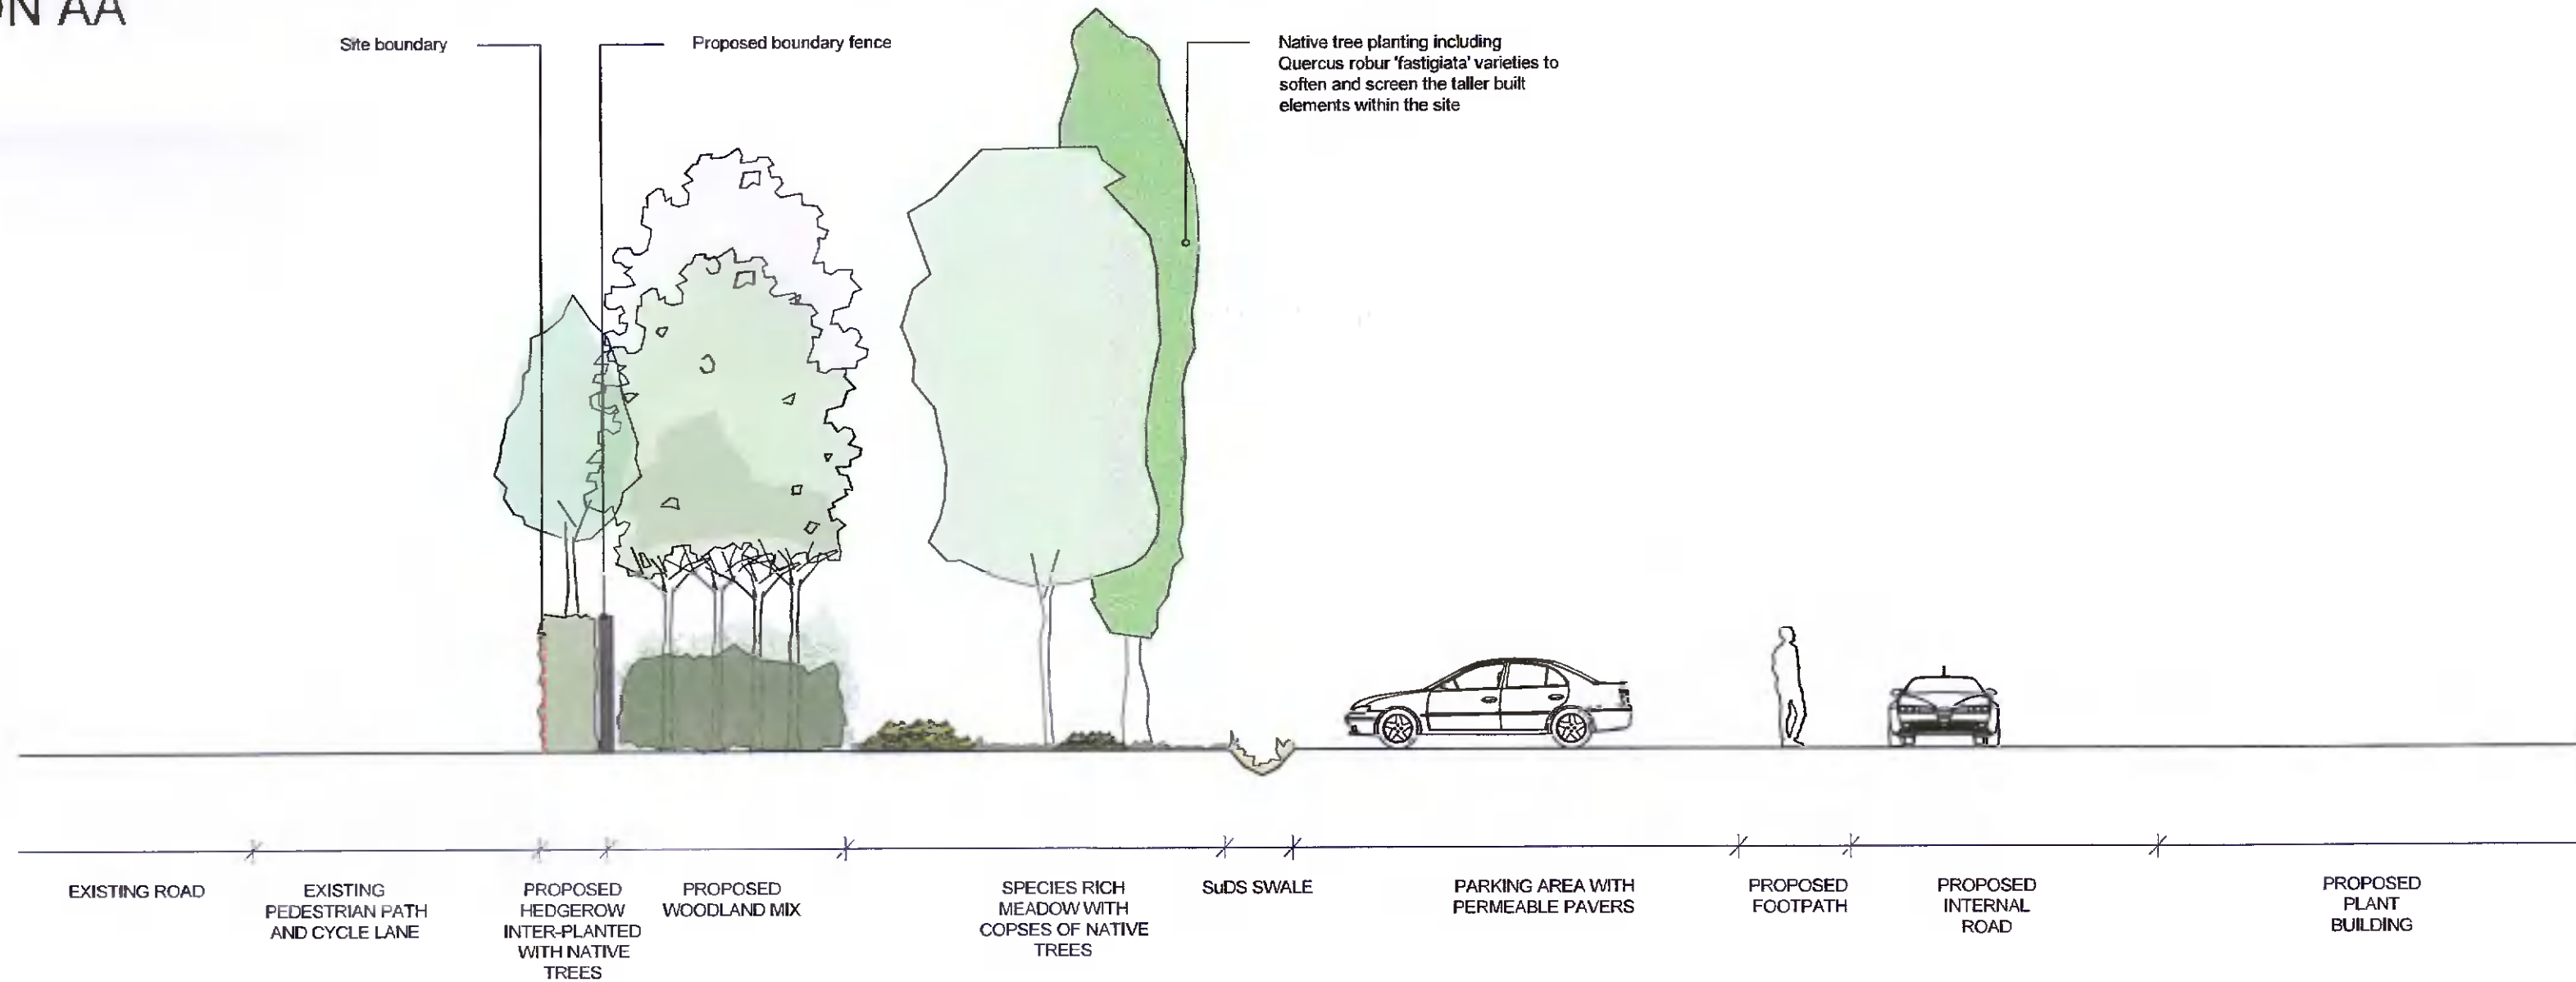




SECTION AA
1:100

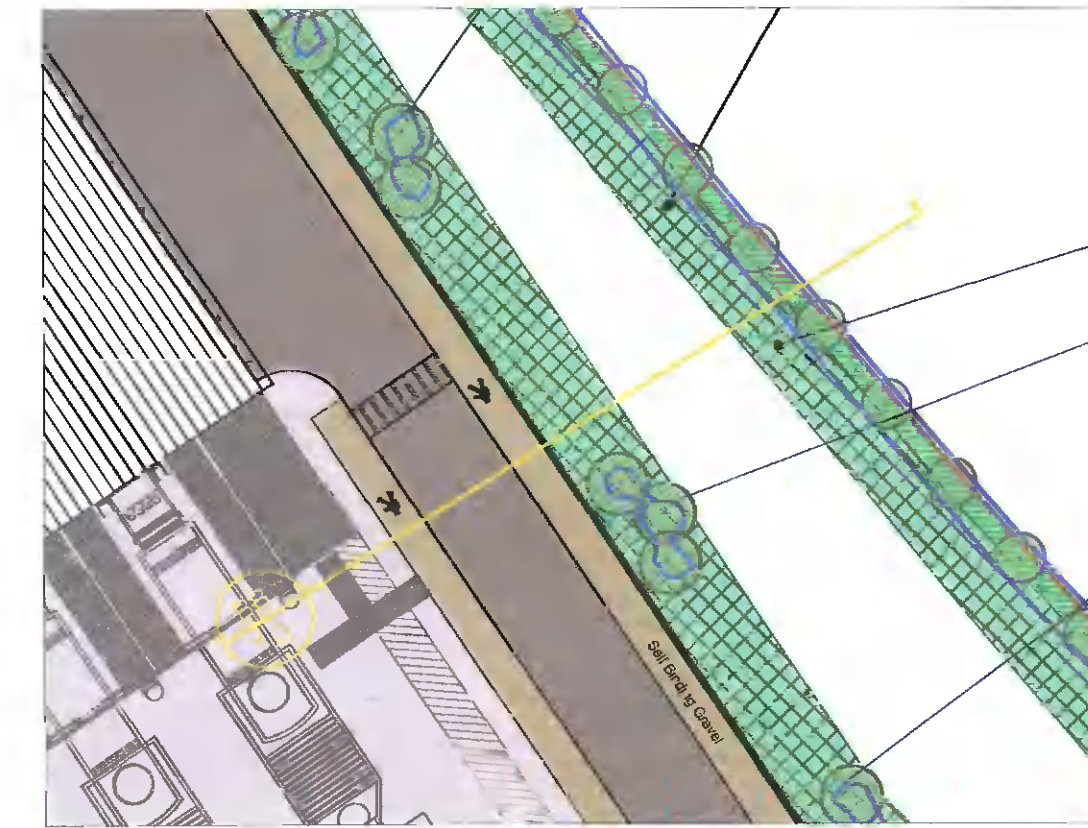

SECTION BB
1:100

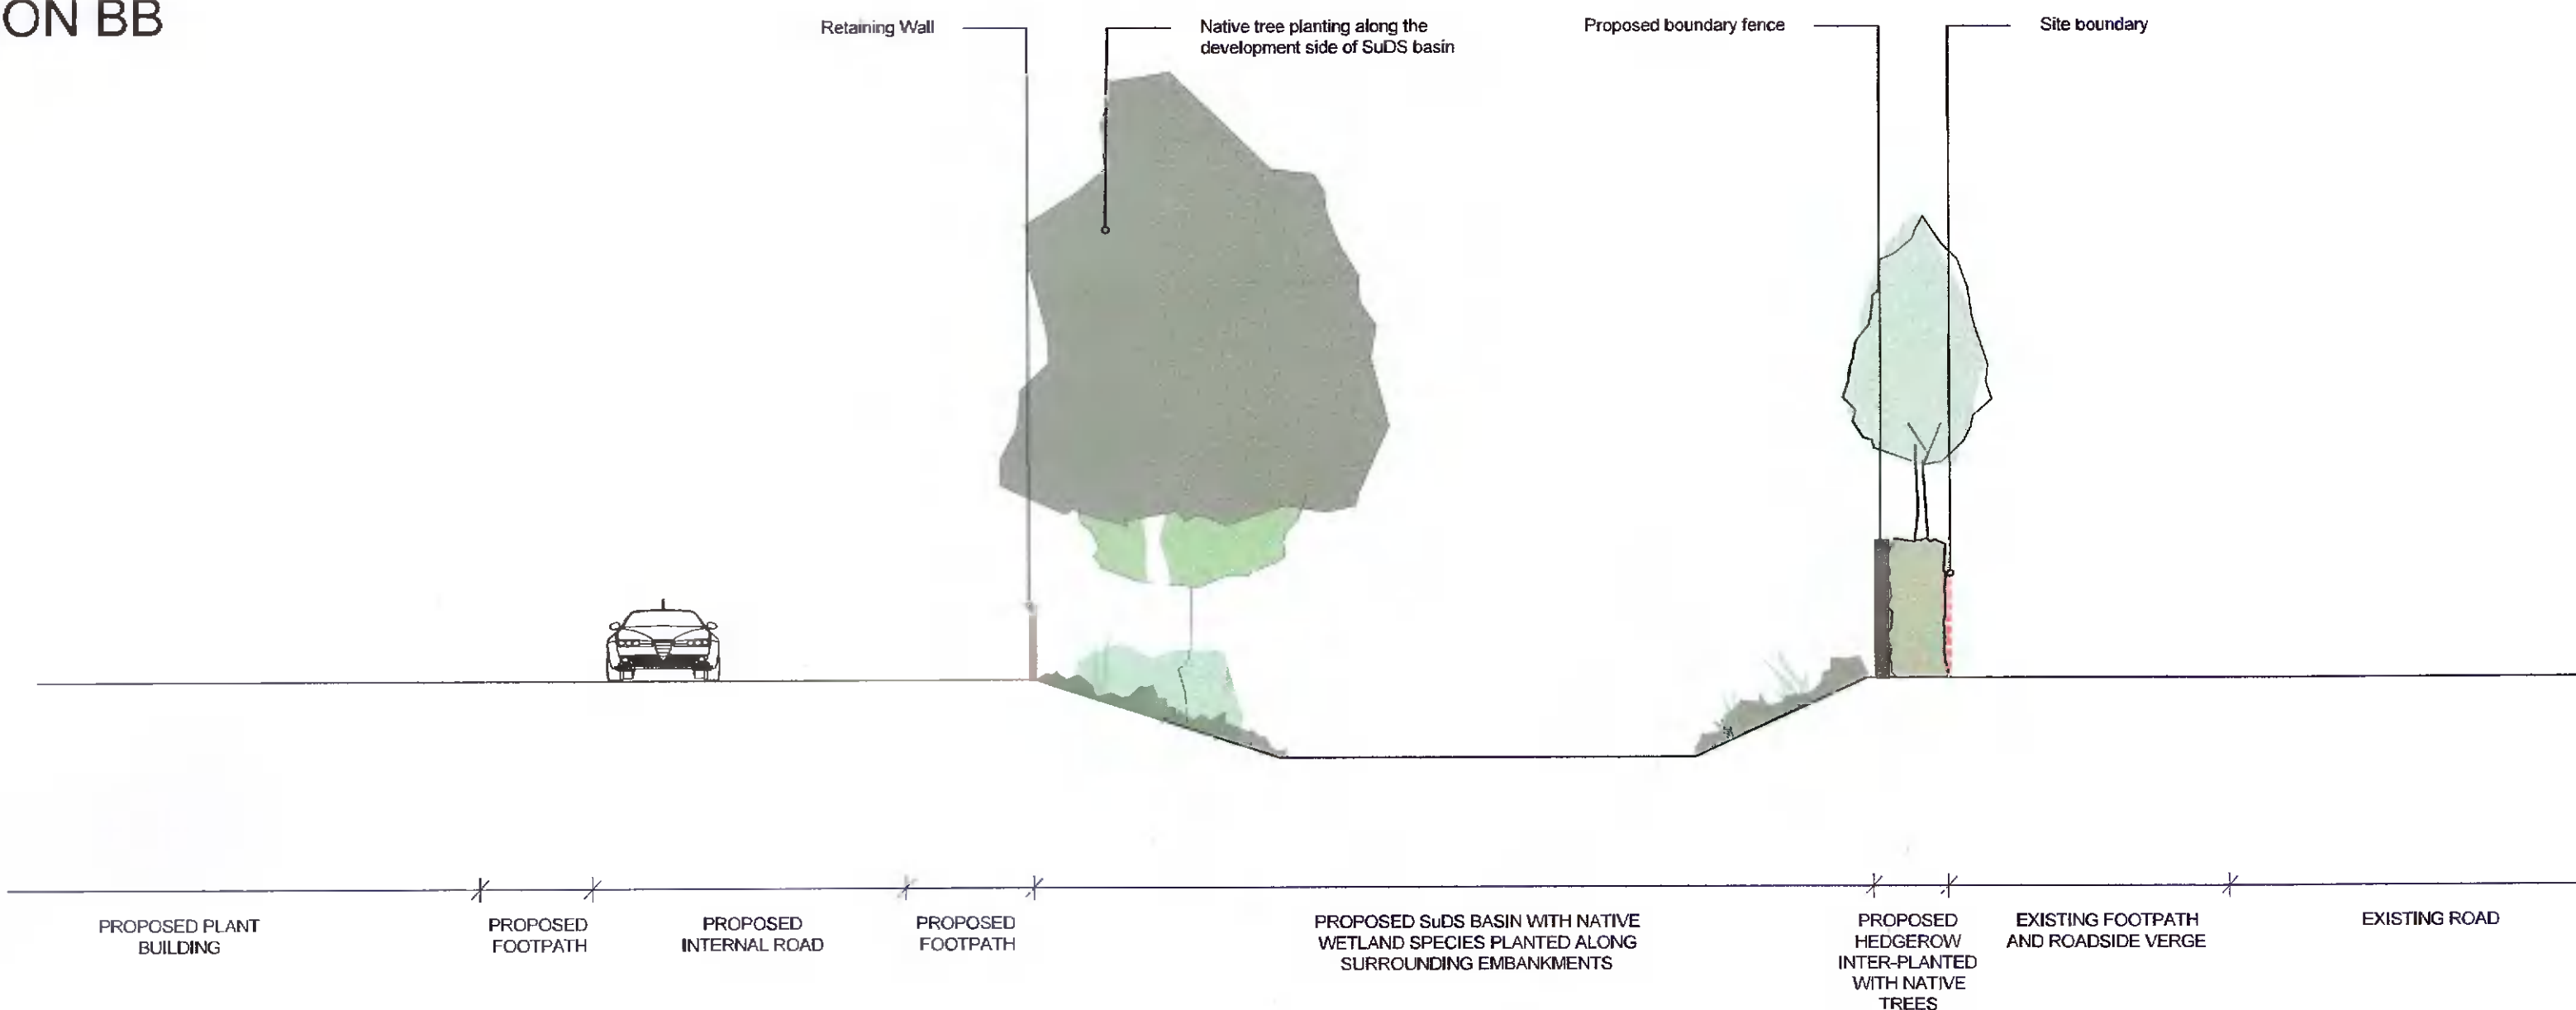

SECTION CC
1:100

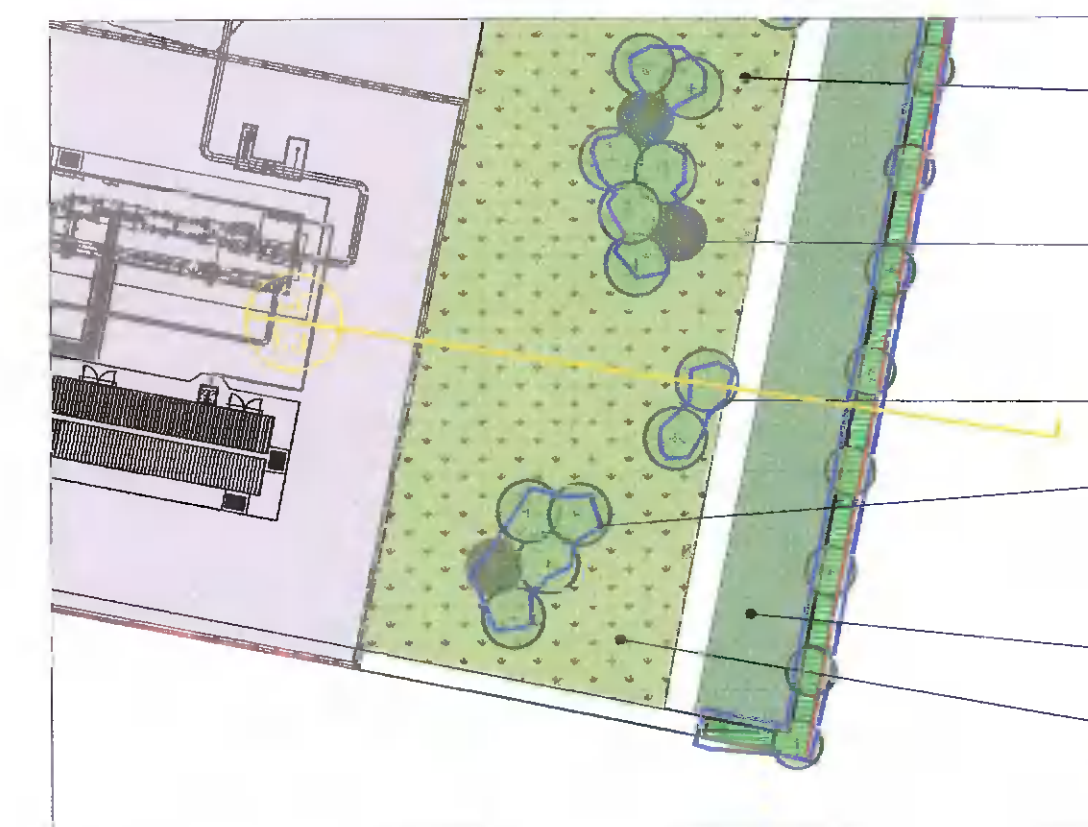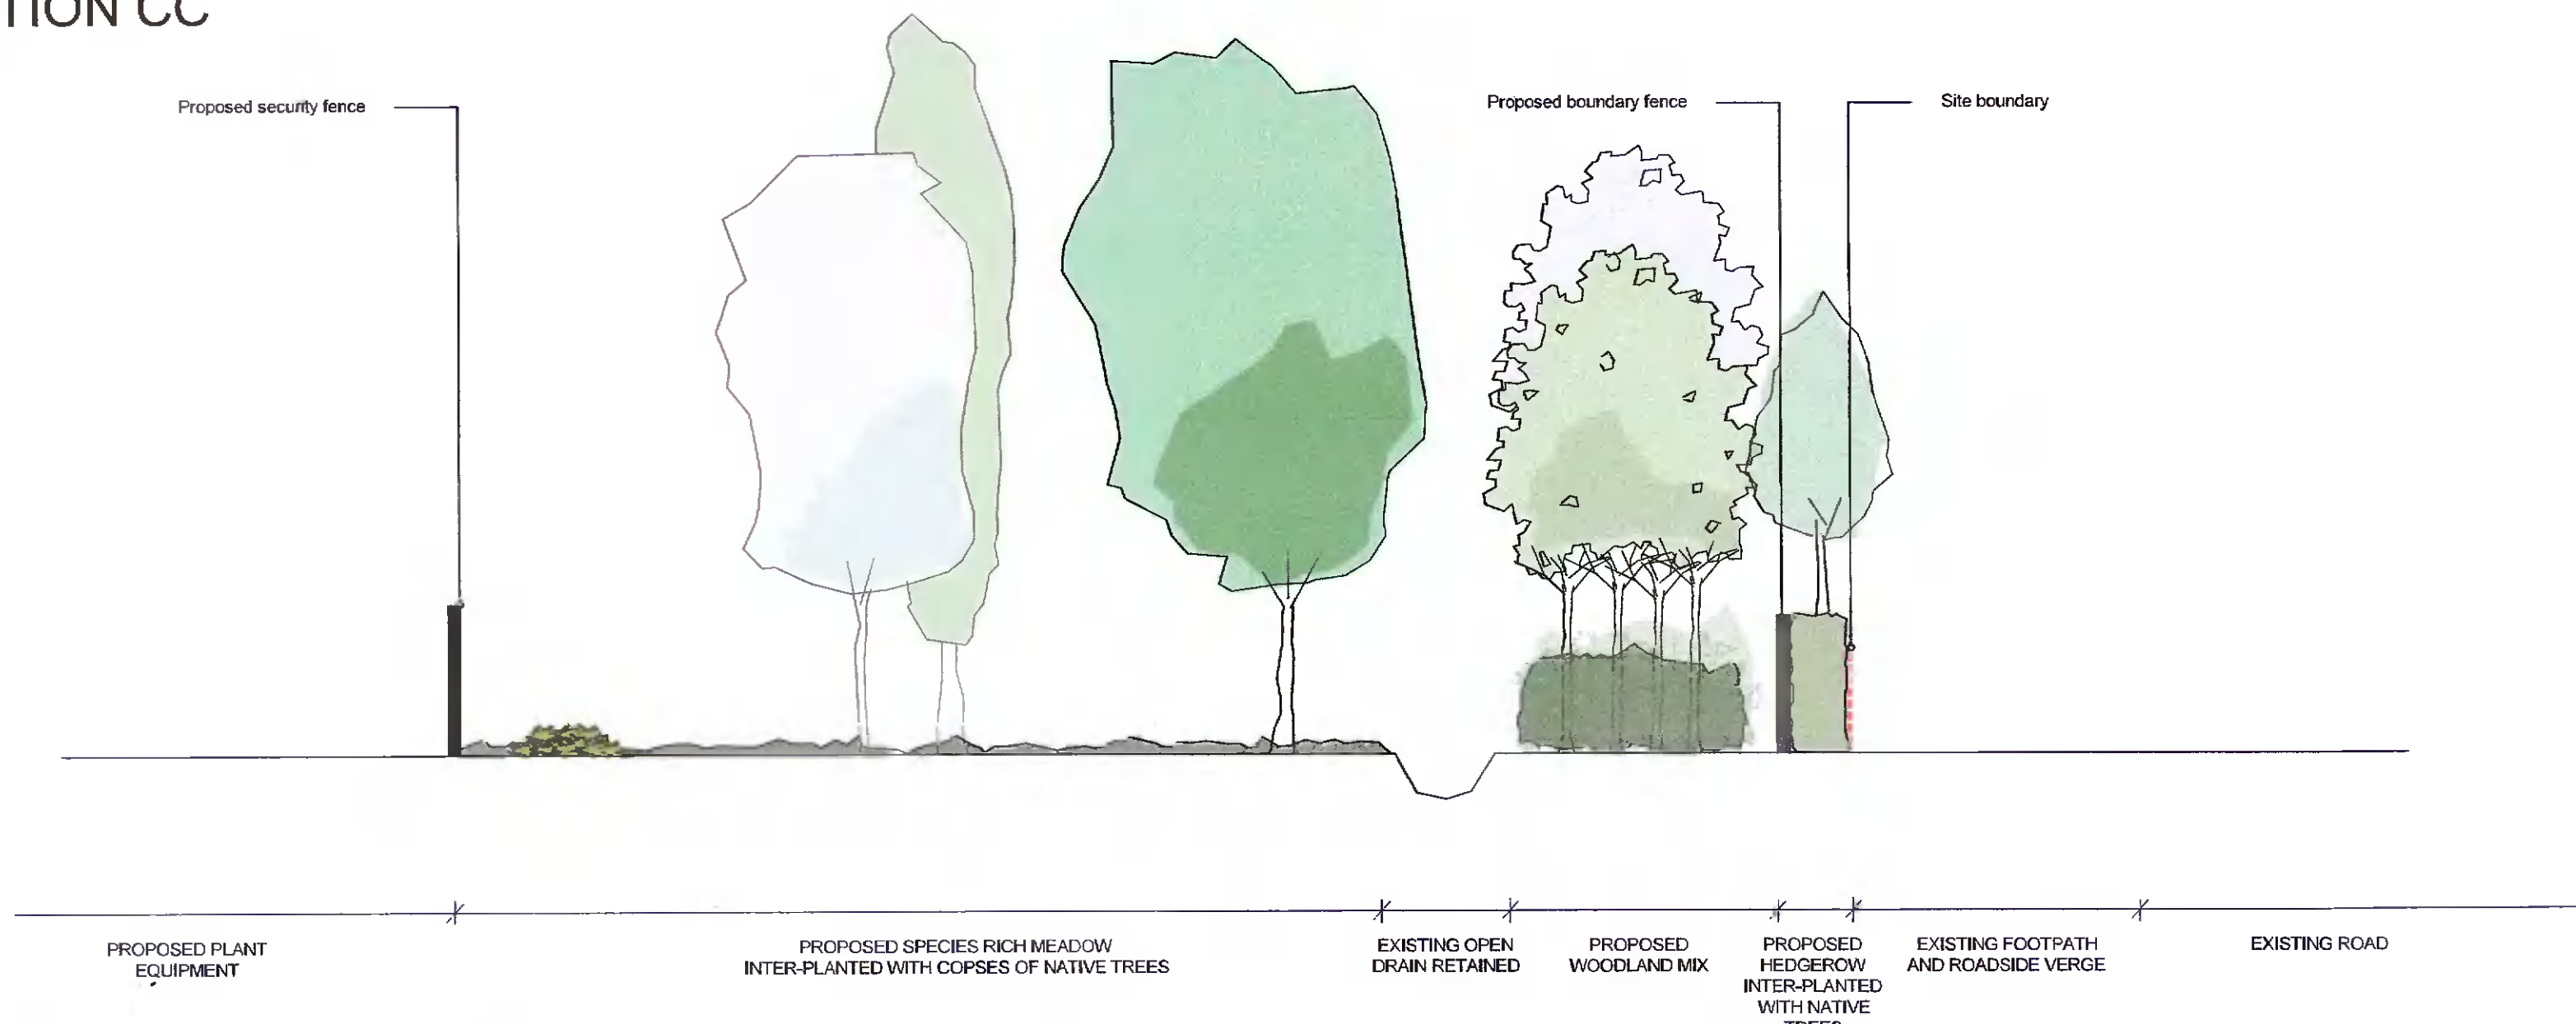

Legend

Notes

REVISIONS:

| | | |
|----|------------------|------------|
| 1. | CFI draft issued | 18/05/2022 |
| 2. | | |
| 3. | | |
| 4. | | |
| 5. | | |
| 6. | | |

Prepared by
MACRO WORKS,
HIBERNIA HOUSE,
CHERRYWOOD BUSINESS PARK,
LOCKINGSTOWN, DUBLIN 18
00353 (01) 2360565
info@macroworks.ie

Site location:
**KILCAREBY,
COUNTY DUBLIN**

Drawing Title:
LANDSCAPE PLAN (CFI) - SECTIONS

Project:
PROFILE PARK POWER PLANT (CFI)

Drawn by:
CD

Checked by:
RB

Drawing Ref:
LD.PRFLEPRK 1.3

Scale:
AS SHOWN @ A1

Date:
MAY 2022

ISSUED - CFI