


CONTIGUOUS ELEVATION A
- Scale 1:250

As agreed with South Dublin County Council in the pre-application consultation meeting the final finishes, including cladding materials and colour codes, will be agreed with the Council post planning through planning condition. Greener Ideas Limited will ensure only Council approved finishes are applied on site.

| Rev | Date | Description | By | Chkd. |
|-----|----------|----------------|----|-------|
| B | 23.05.22 | CFI ISSUE | MN | LB |
| A | 02.03.22 | PLANNING ISSUE | MN | MMcC |

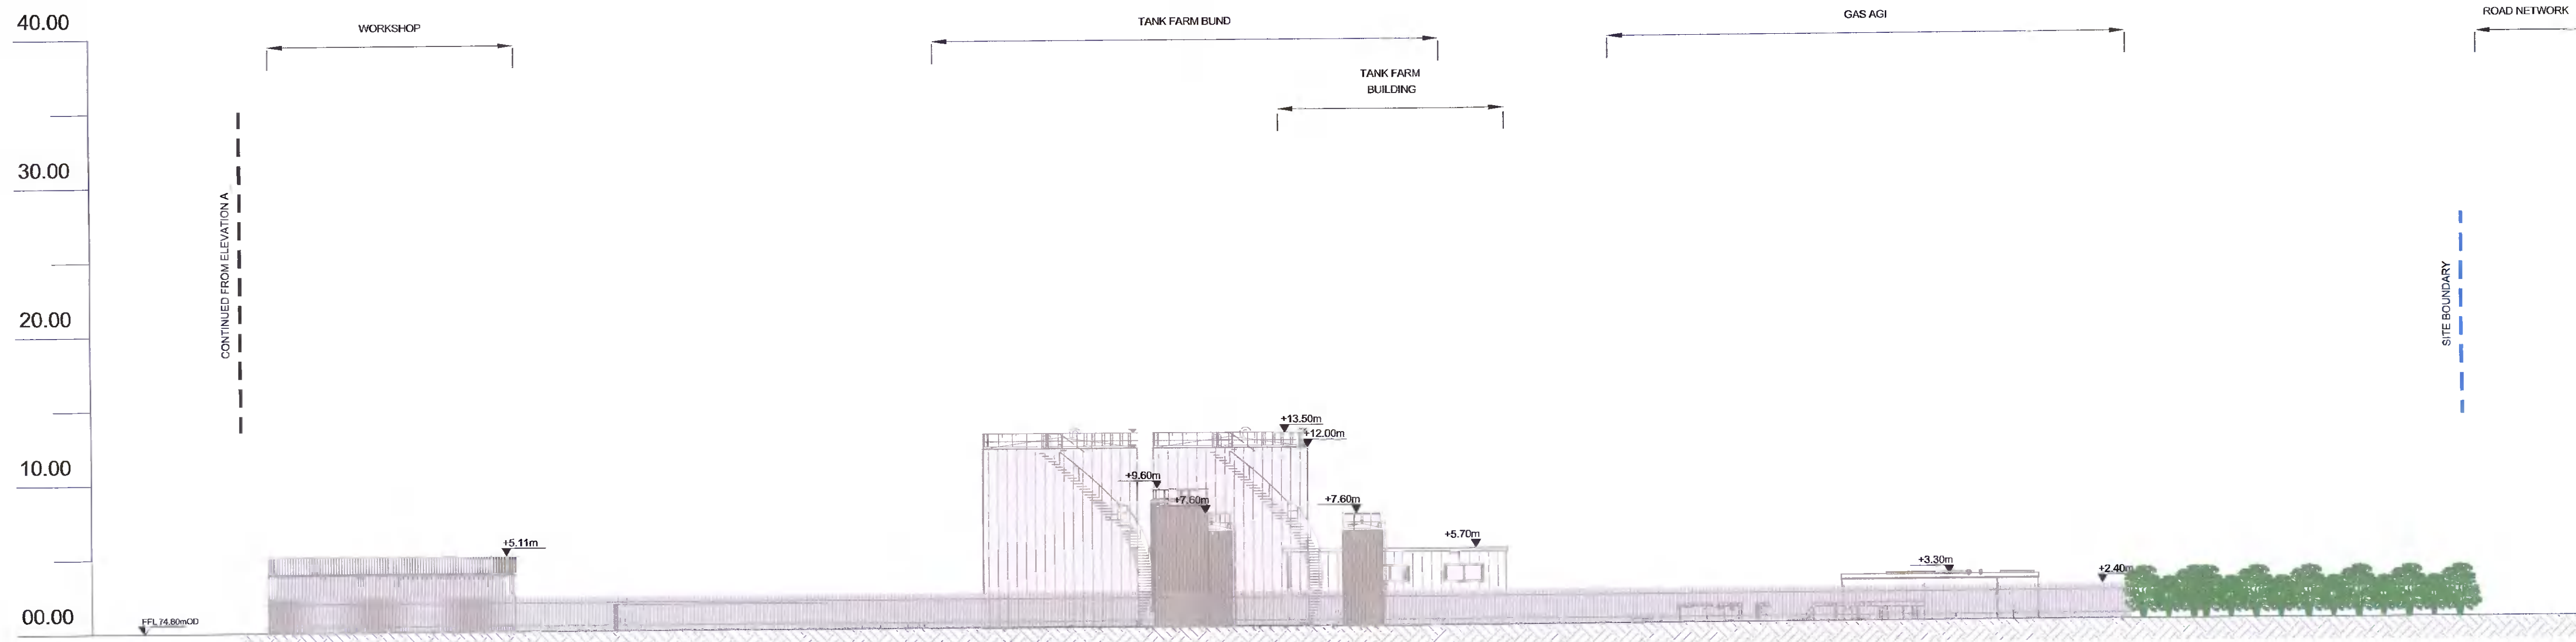

CONTIGUOUS ELEVATION B
- Scale 1:250

Client:

Project: **PROFILE PARK POWER PLANT**

Title: **CONTIGUOUS ELEVATION Sheet 1 of 3**

| | | |
|-------------------|-------------|------------|
| Scale @ A1: | 1:250 | |
| Prepared by: | Checked: | Date: |
| M. Nolan | M. McCarthy | March 2022 |
| Project Director: | S. Tinnelly | |
| Drawing Status: | Planning | |

TOBIN
CONSULTING ENGINEERS
Block 10-4, Blanchardstown Corporate Park,
Dublin 15, Ireland.
tel: +353-(0)1-8030406
fax: +353-(0)1-8030409
e-mail: dublin@tobin.ie
www.tobin.ie

Tobin Consulting Engineers will not be liable for any use of this document for any purpose other than that for which it was originally prepared and provided. This project is the property of Tobin Consulting Engineers and copyright notice, no part of this document may be reproduced or transmitted in any form and this document shall not be relied upon by any third party for any purpose.

Drawing No.: **11069-2059** Revision: **B**